

OWNER:


**ARCHETYPE, P.A.
ARCHITECTS**
48 Union Wharf Portland, Maine 04101
(207) 772-6022 Fax (207) 772-4056

Project:
53 DANFORTH STREET
PORTLAND, ME

Date: 15 JULY 2008
Scale: AS NOTED


100% CONST DOCS
FOURTH FL POWER & LIGHTING PLANS

E1.04

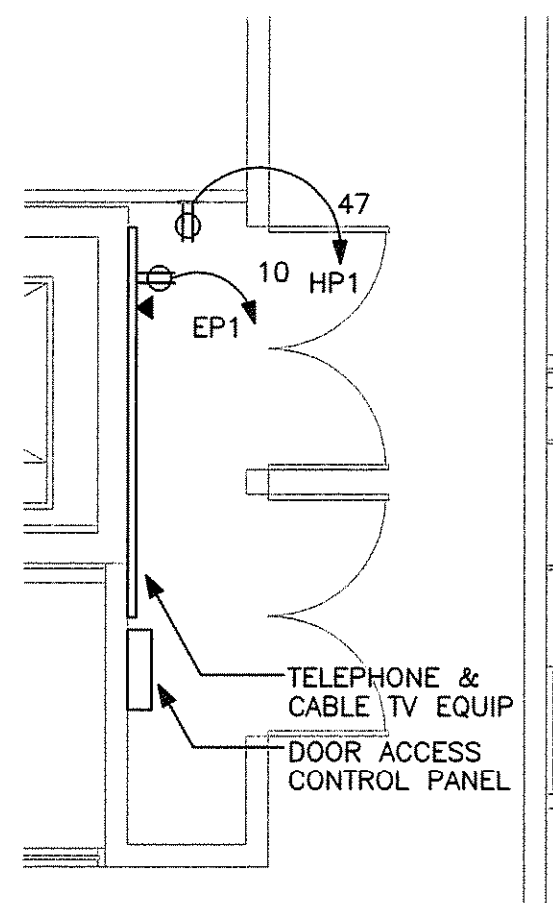


TELCOM ROOM
1/4" = 1'-0"

- NOTES:
1. SEE SHEET E3.01 FIR EXHAUST FAN CONTROL WIRING.
2. VERIFY EXACT LOCATION OF MECHANICAL EQUIPMENT PRIOR TO ROUGH-IN.

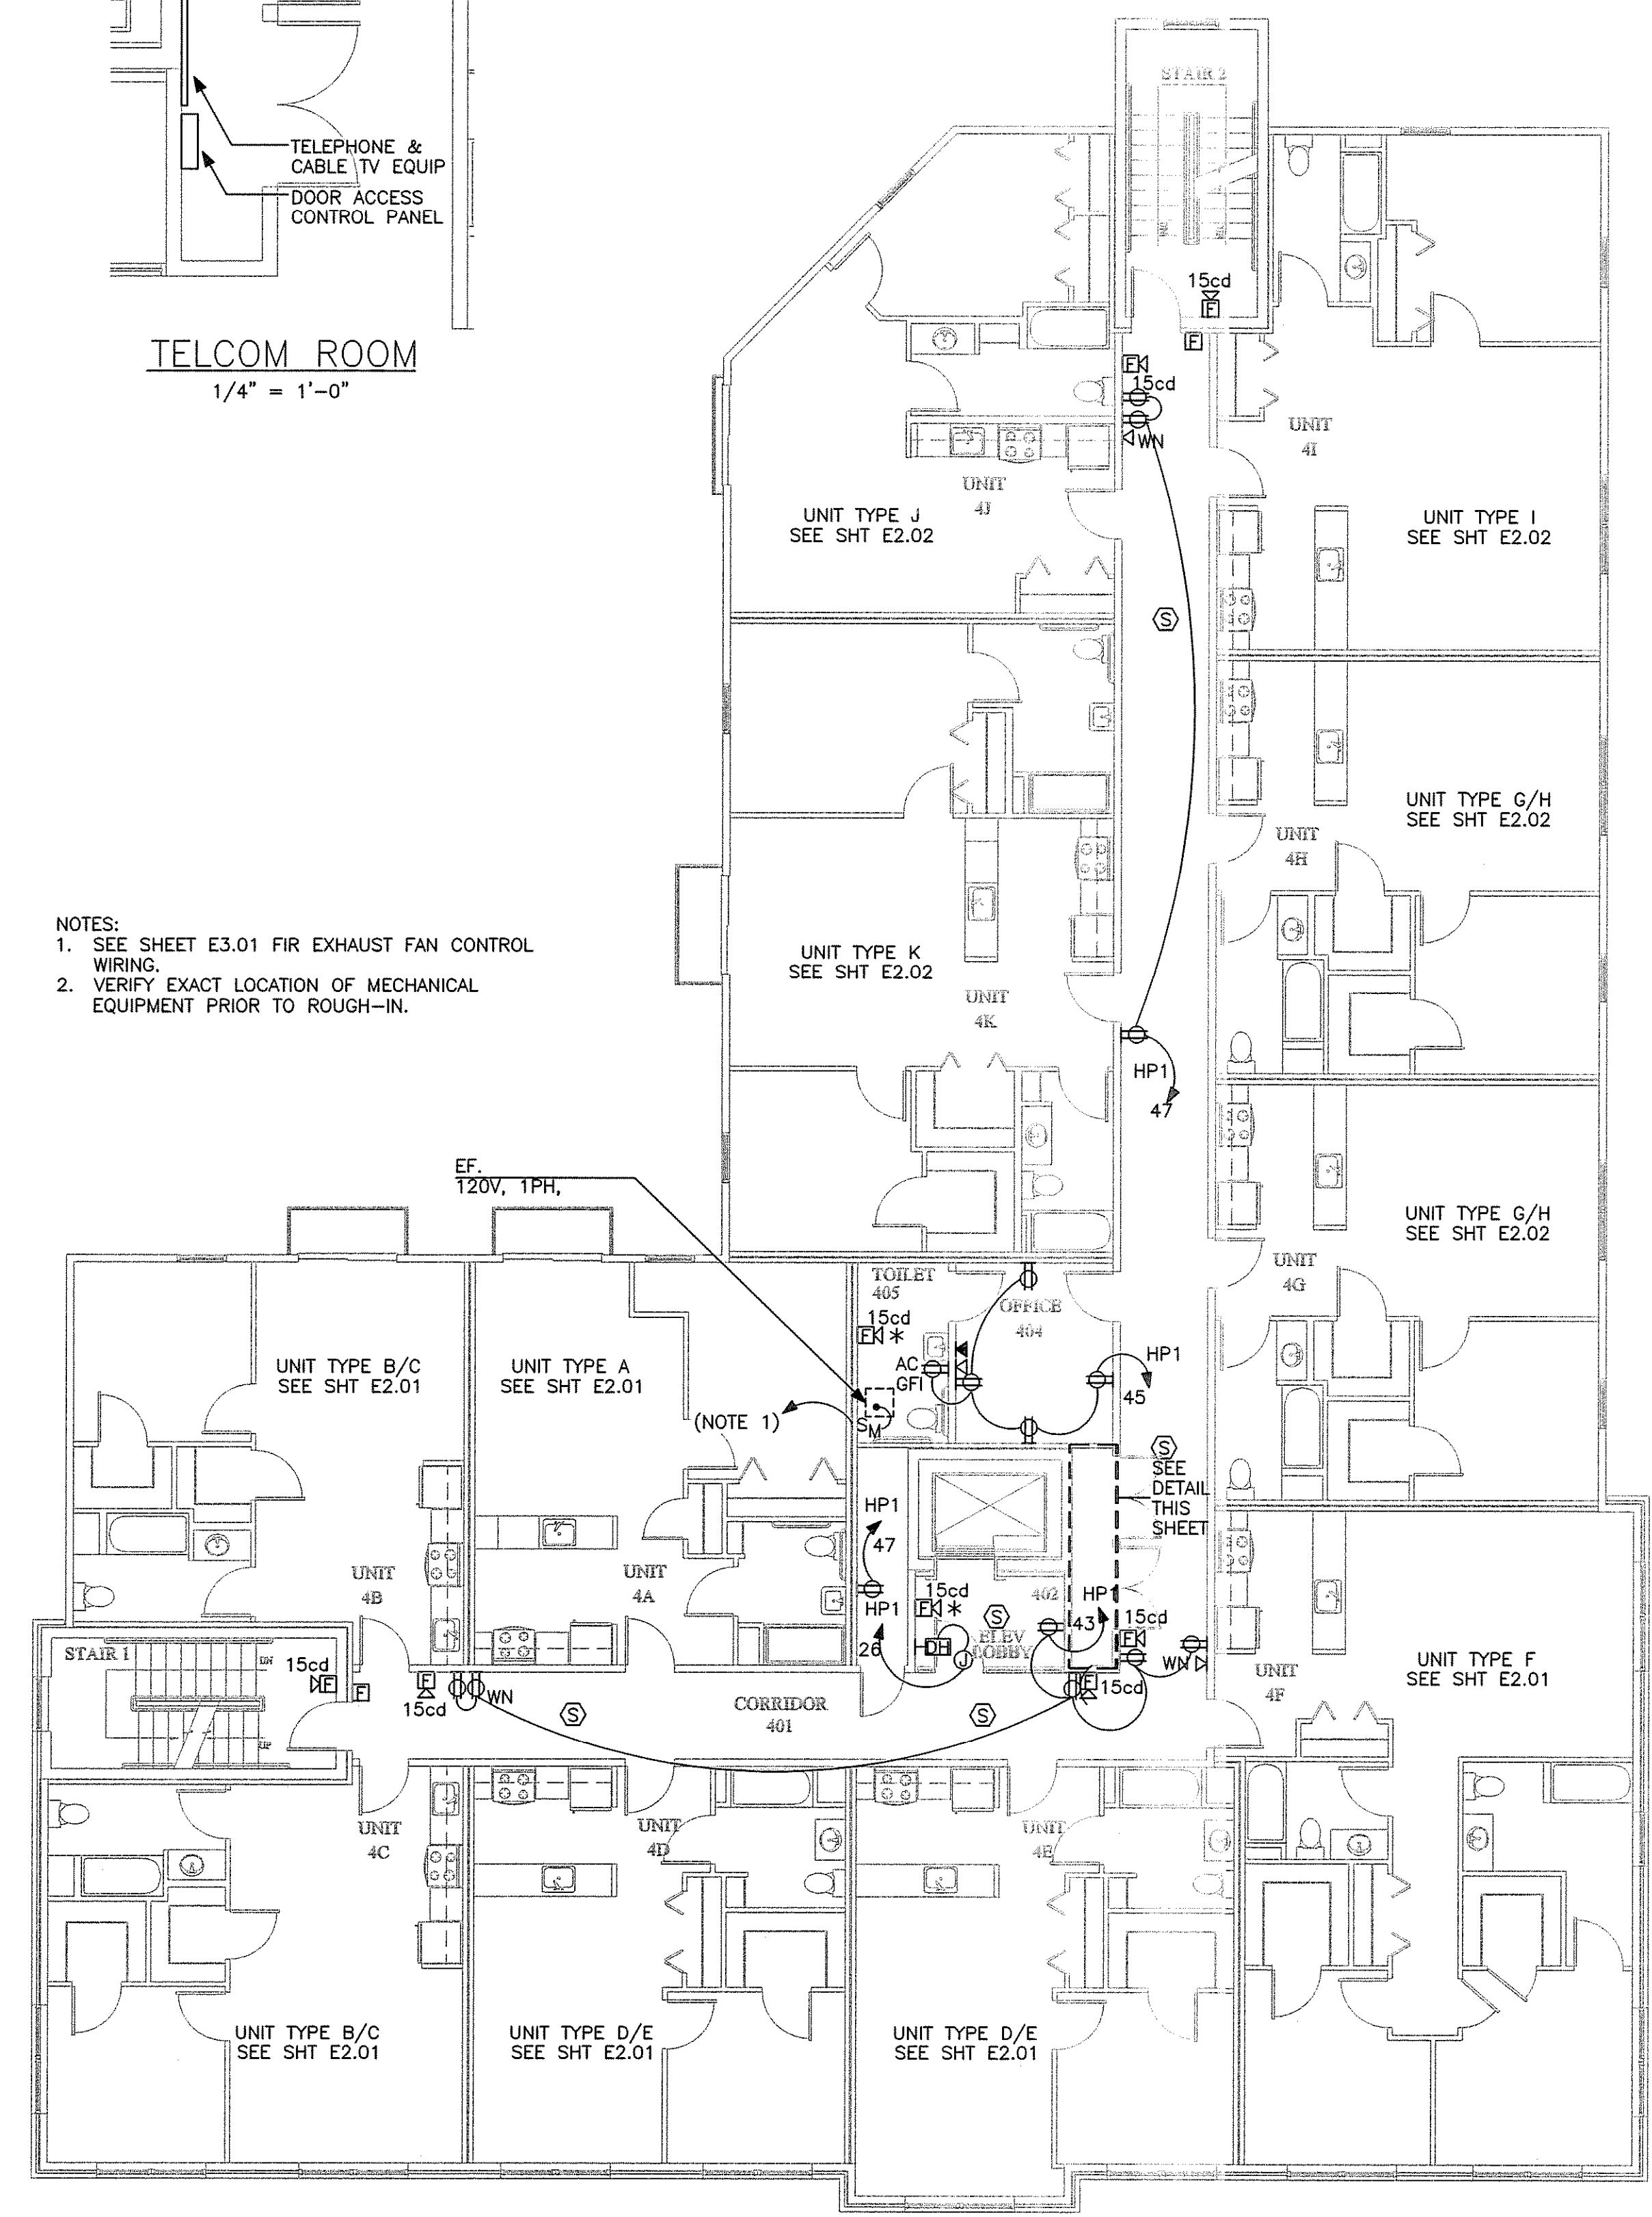

FOURTH FLOOR POWER PLAN
1/8" = 1'-0"

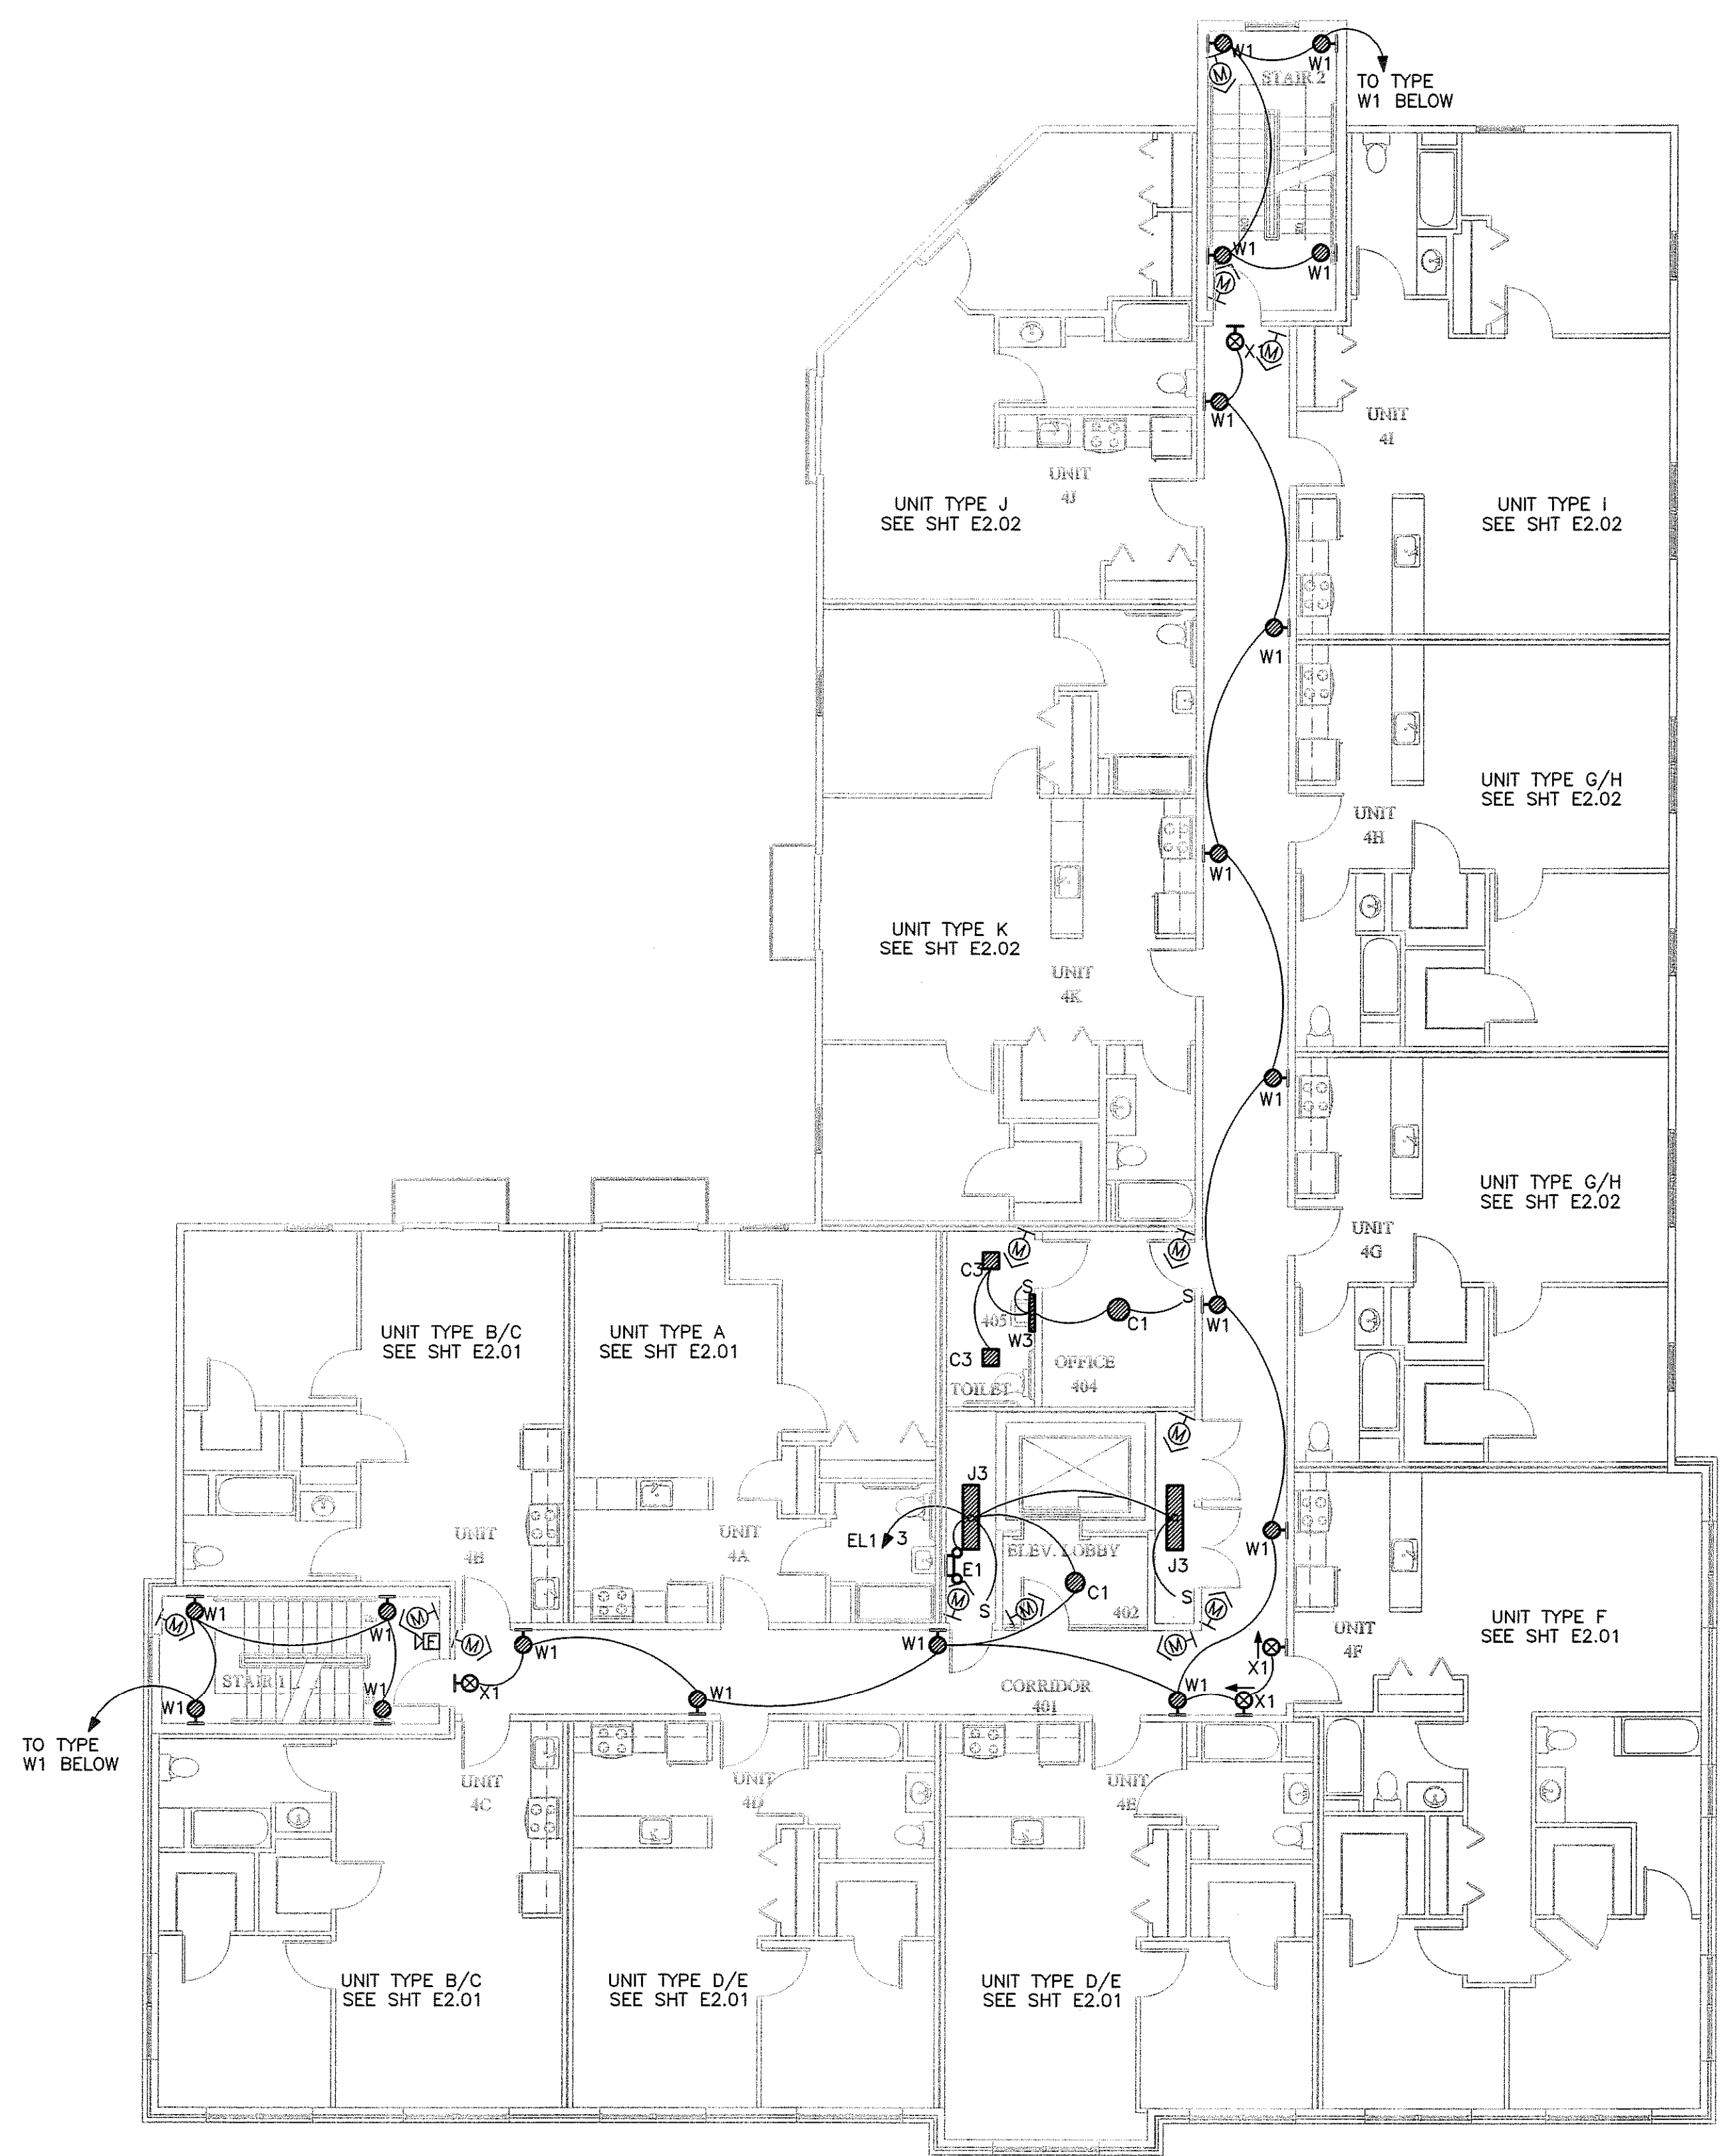

FOURTH FLOOR LIGHTING PLAN
1/8" = 1'-0"

