




B2 2 BEDROOM ACCESSIBLE UNIT FIRE ALARM PLAN
1/4" = 1'-0"; UNIT 308

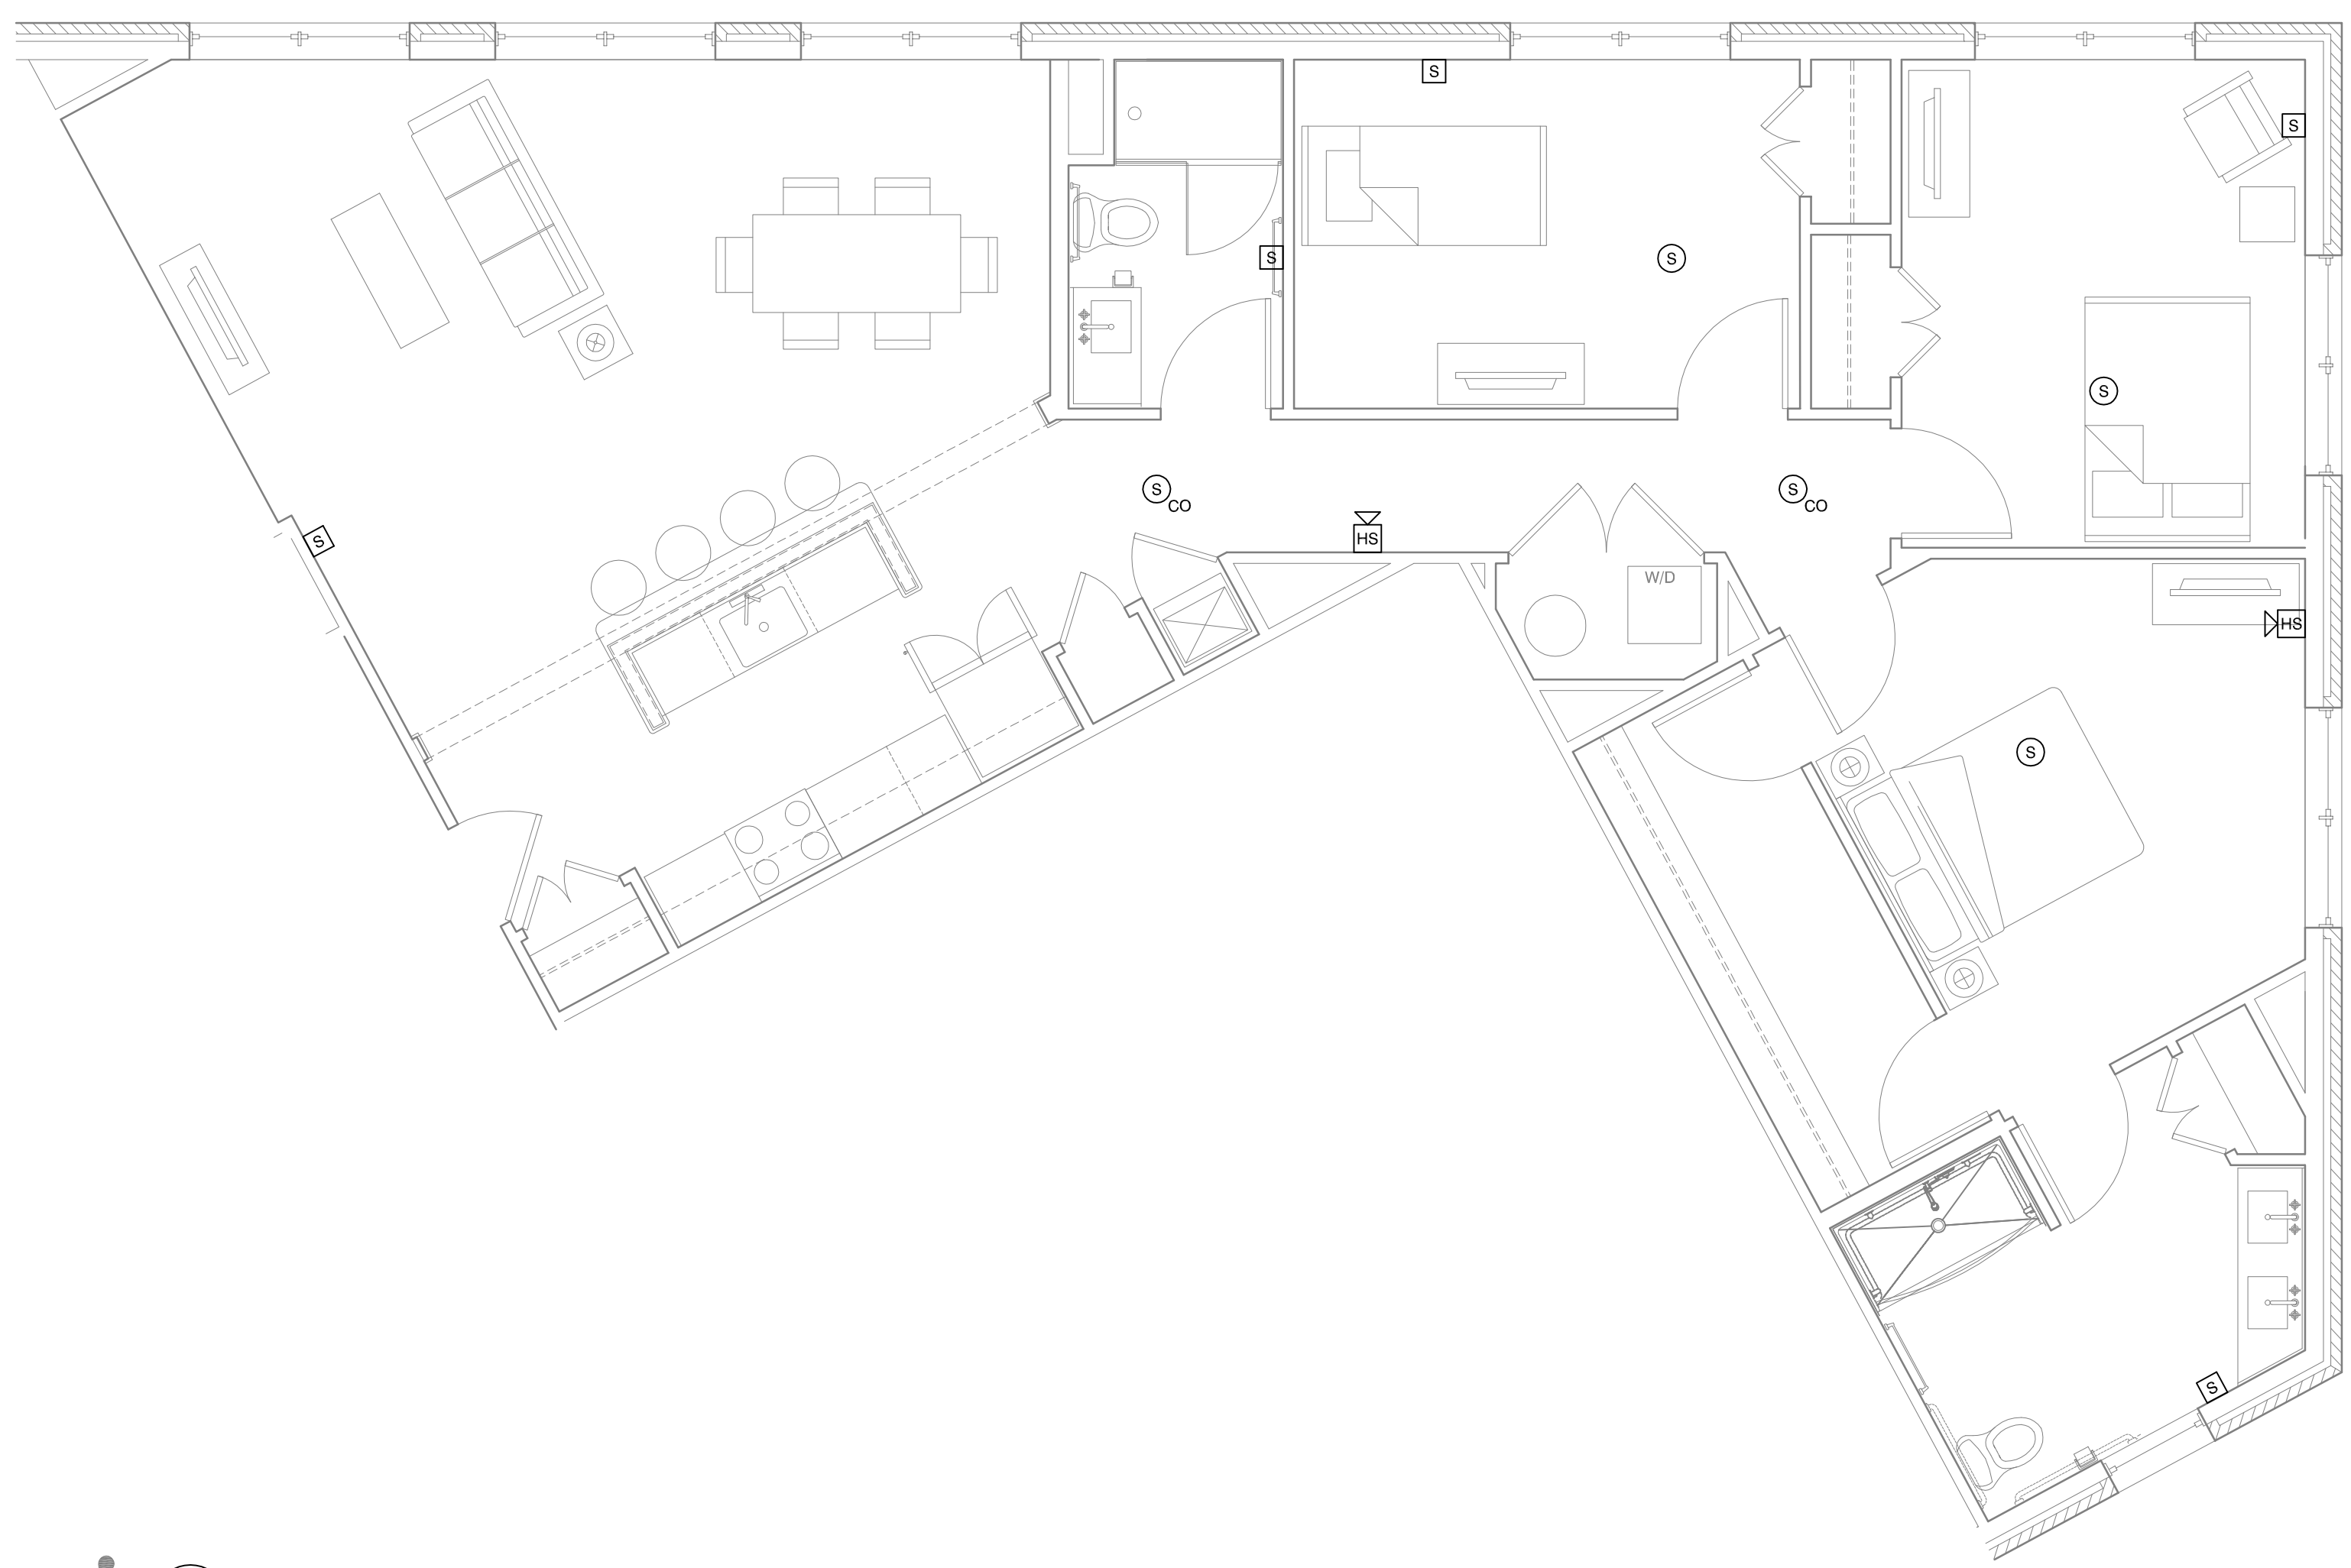

C1 3 BEDROOM ACCESSIBLE UNIT FIRE ALARM PLAN
1/4" = 1'-0"; UNIT 215

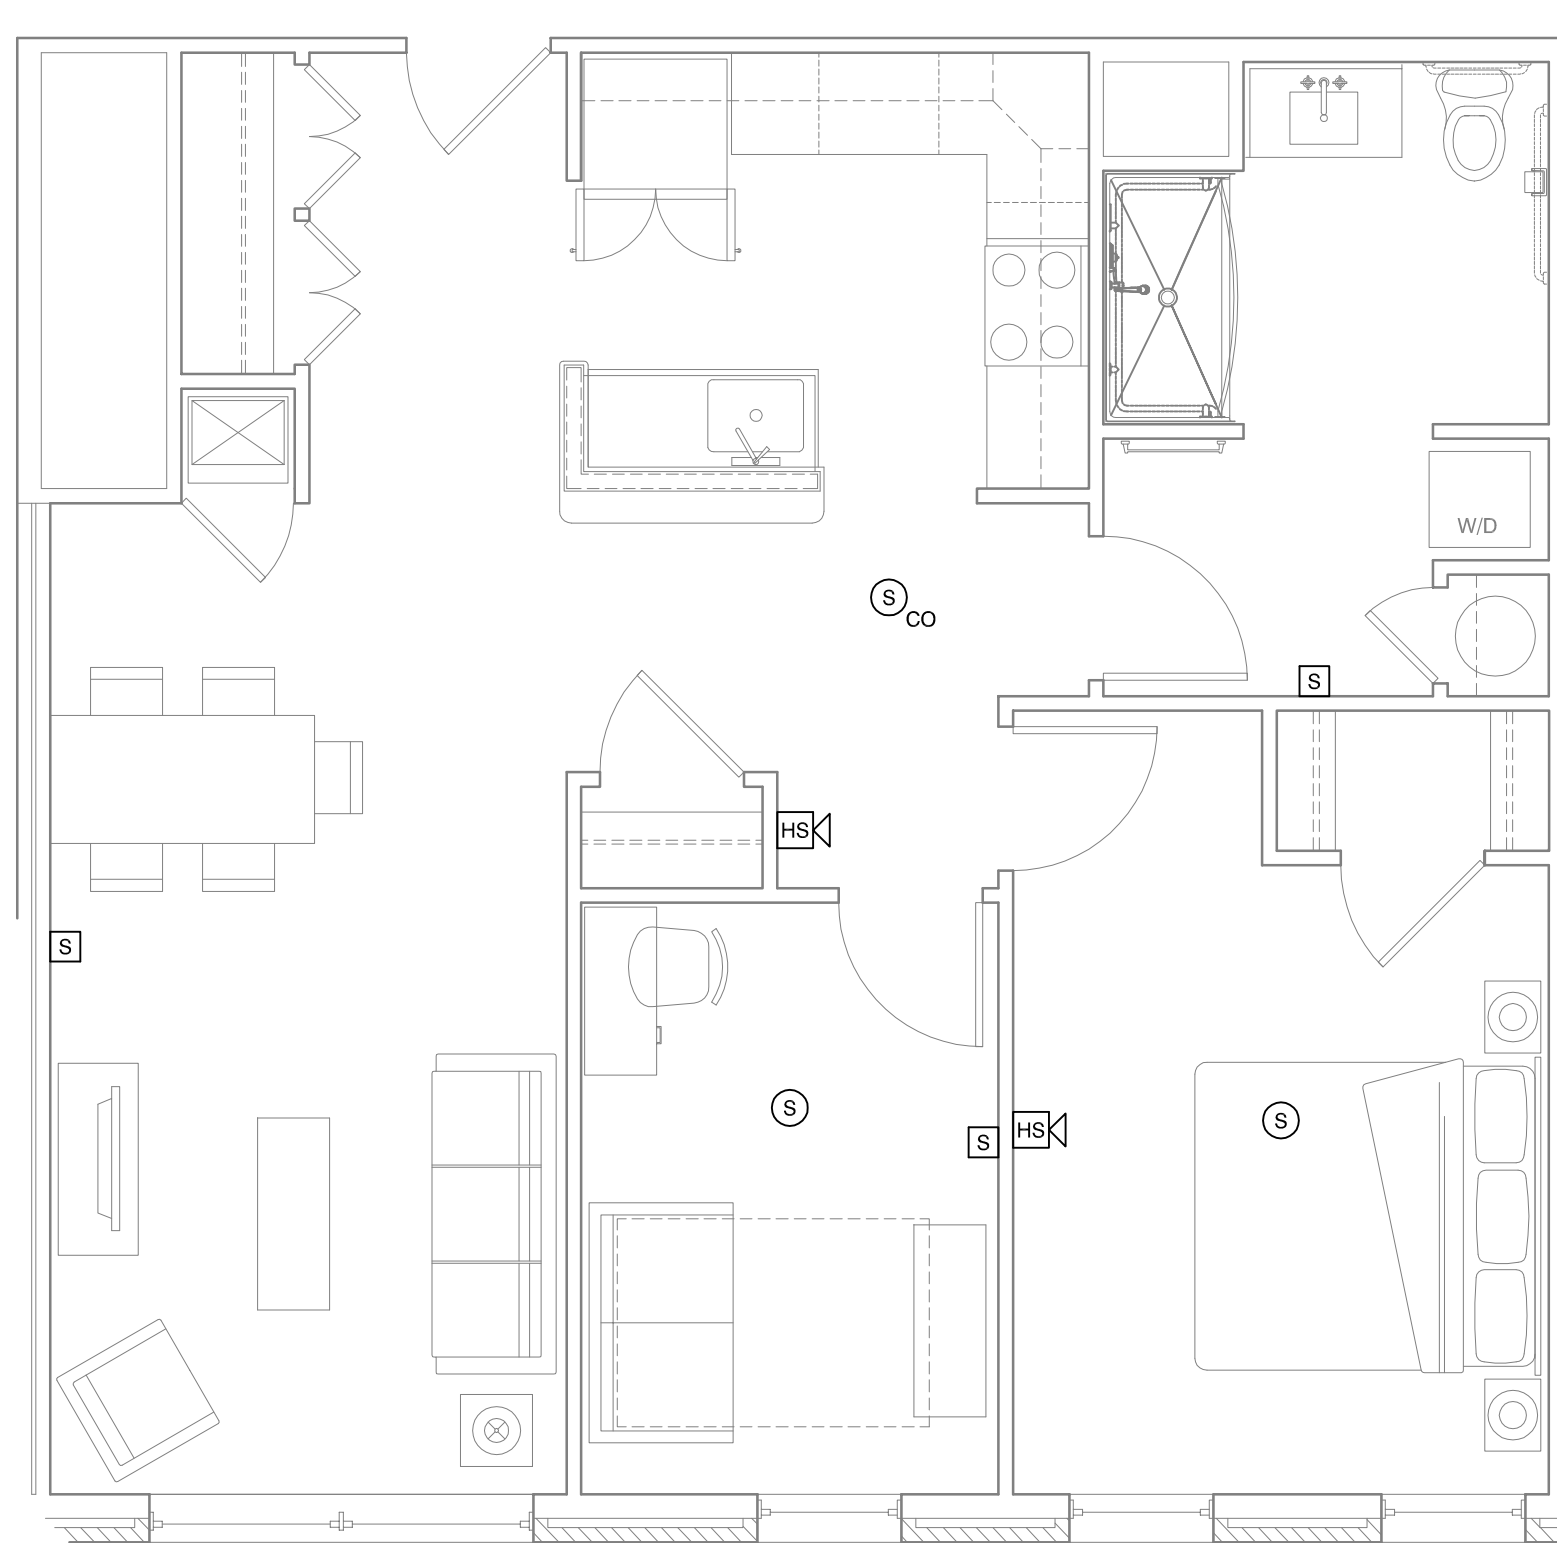

A4 1 BEDROOM ACCESSIBLE UNIT FIRE ALARM PLAN
1/4" = 1'-0"; UNIT 504

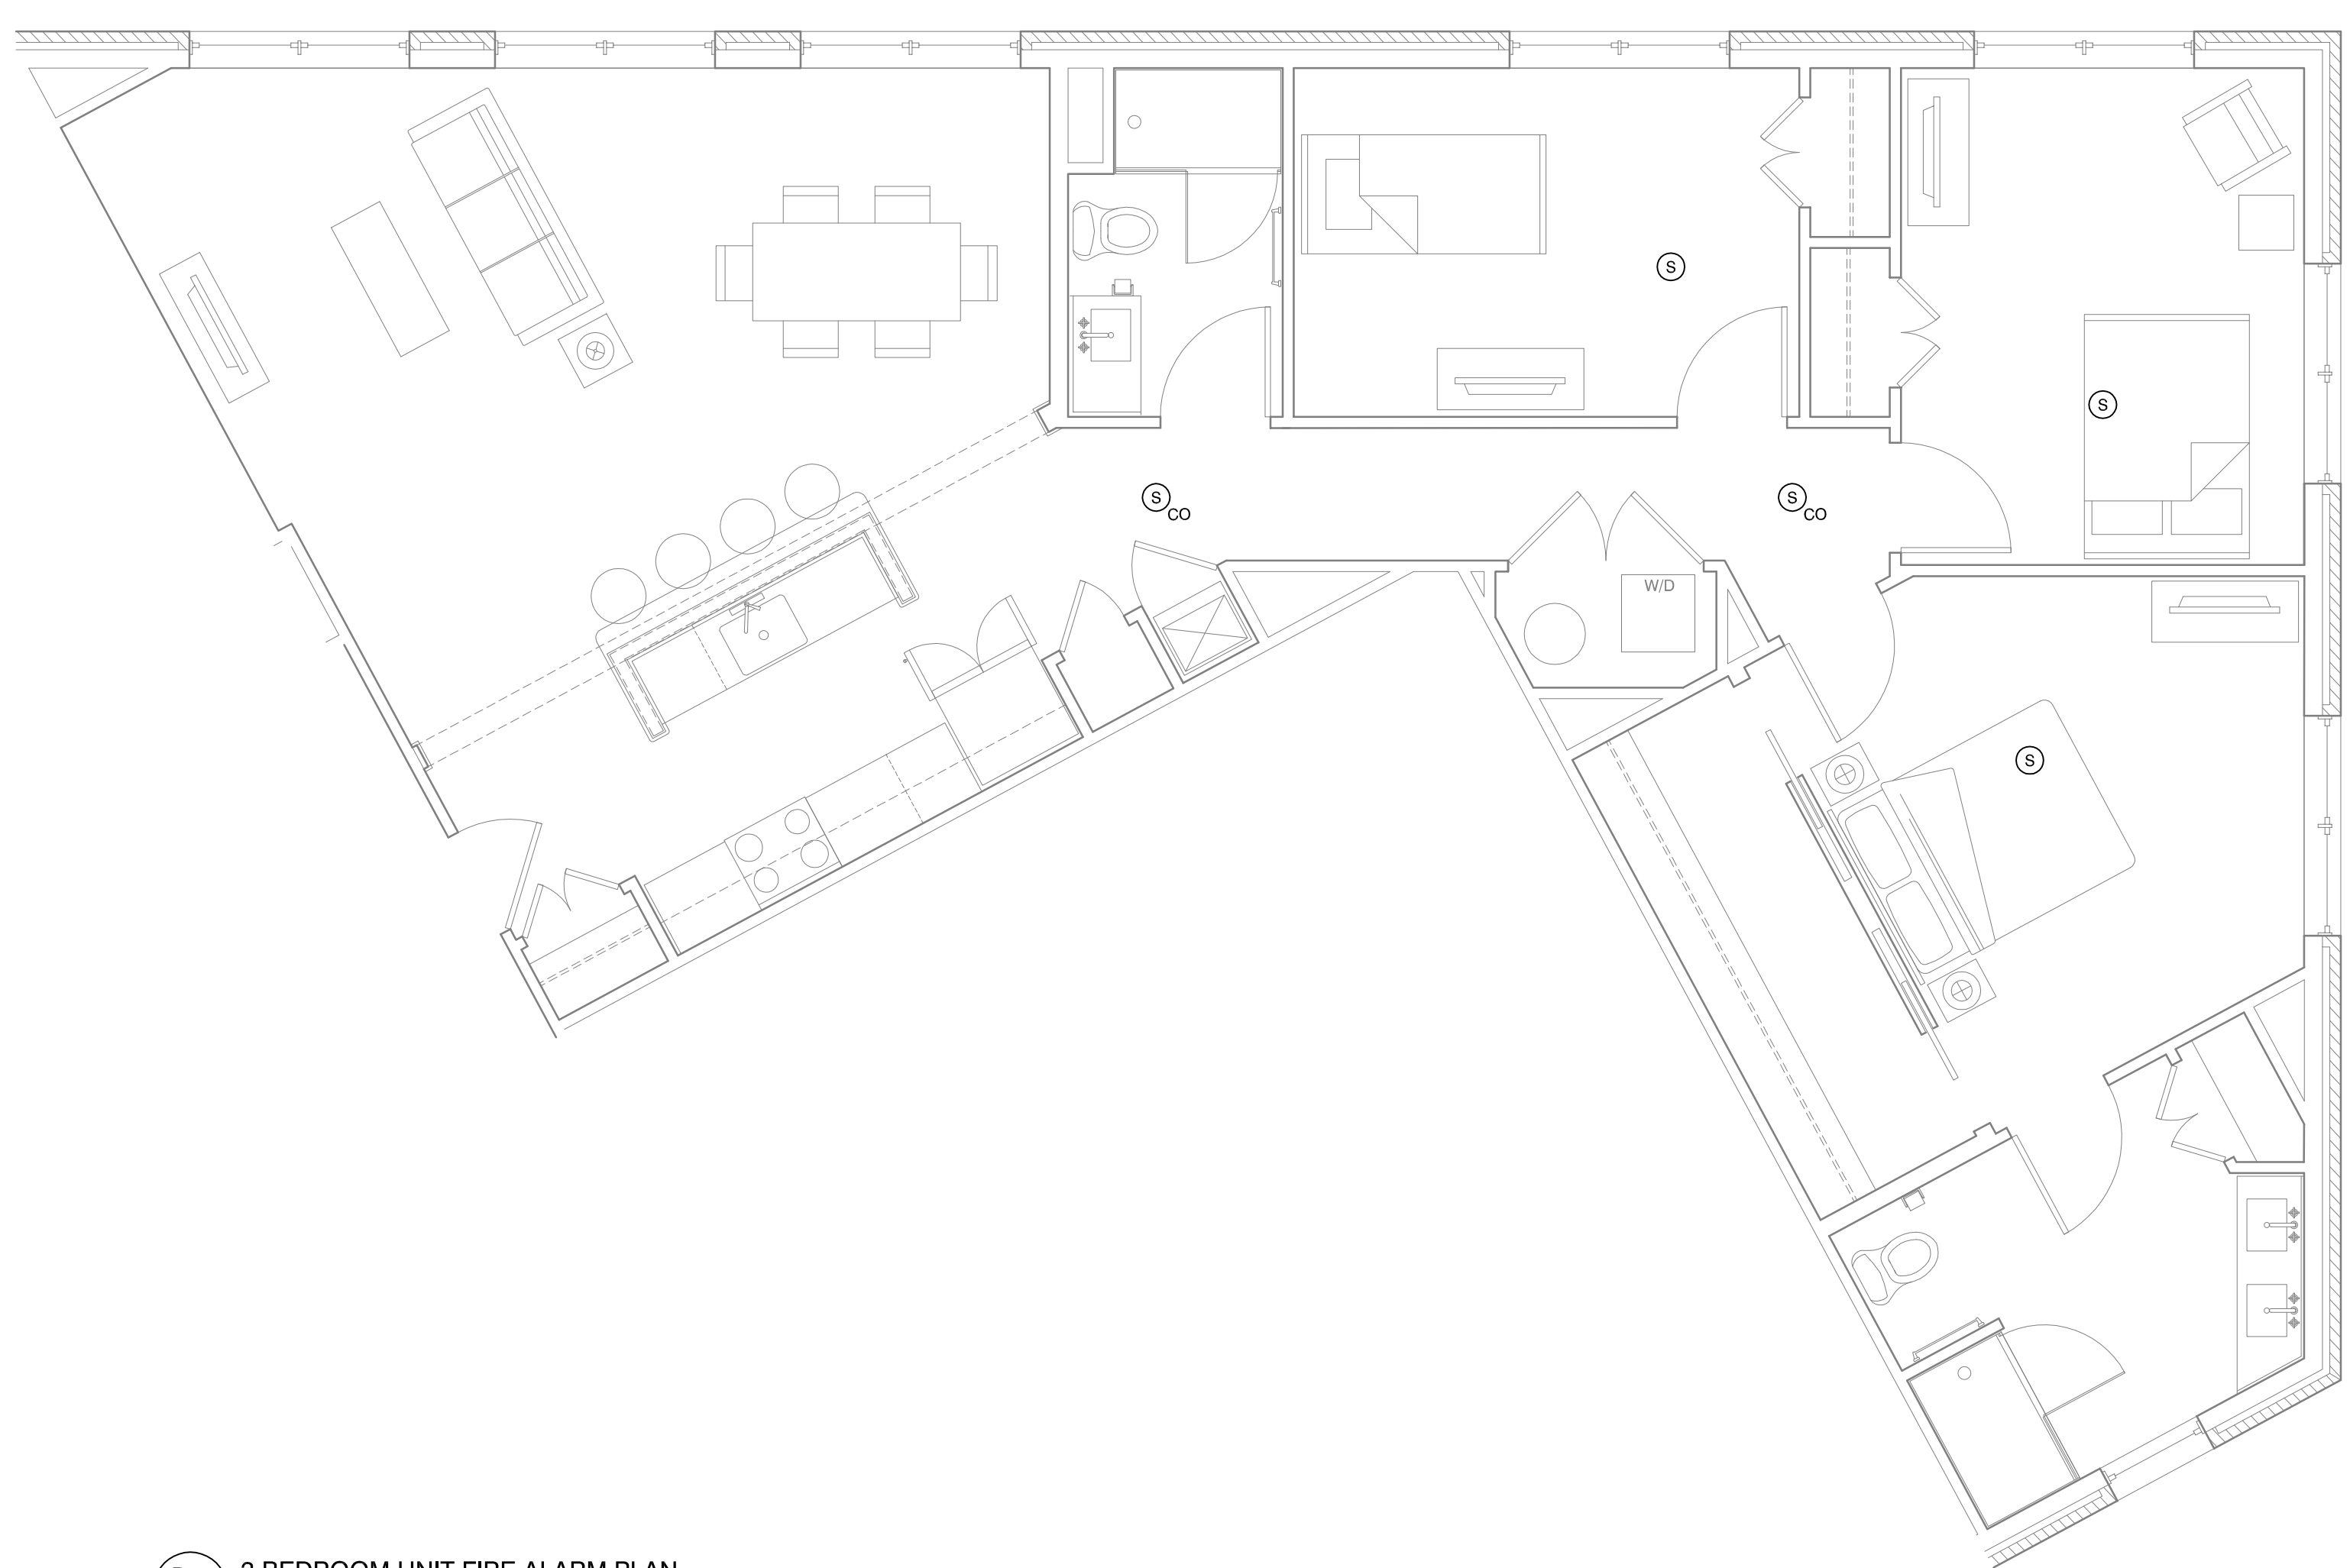

C1 3 BEDROOM UNIT FIRE ALARM PLAN
1/4" = 1'-0"; UNITS 315, 415, 515

REVISION:
.....

ISSUED:
.....

project architect: KAK
drawn by: JJD

RESIDENTIAL
3 BR & ACC UNIT
FIRE ALM. PLANS

sheet number:

FA2.03