




1 A1 UNIT DUCTWORK PLAN
SCALE: 1/4" = 1'-0"

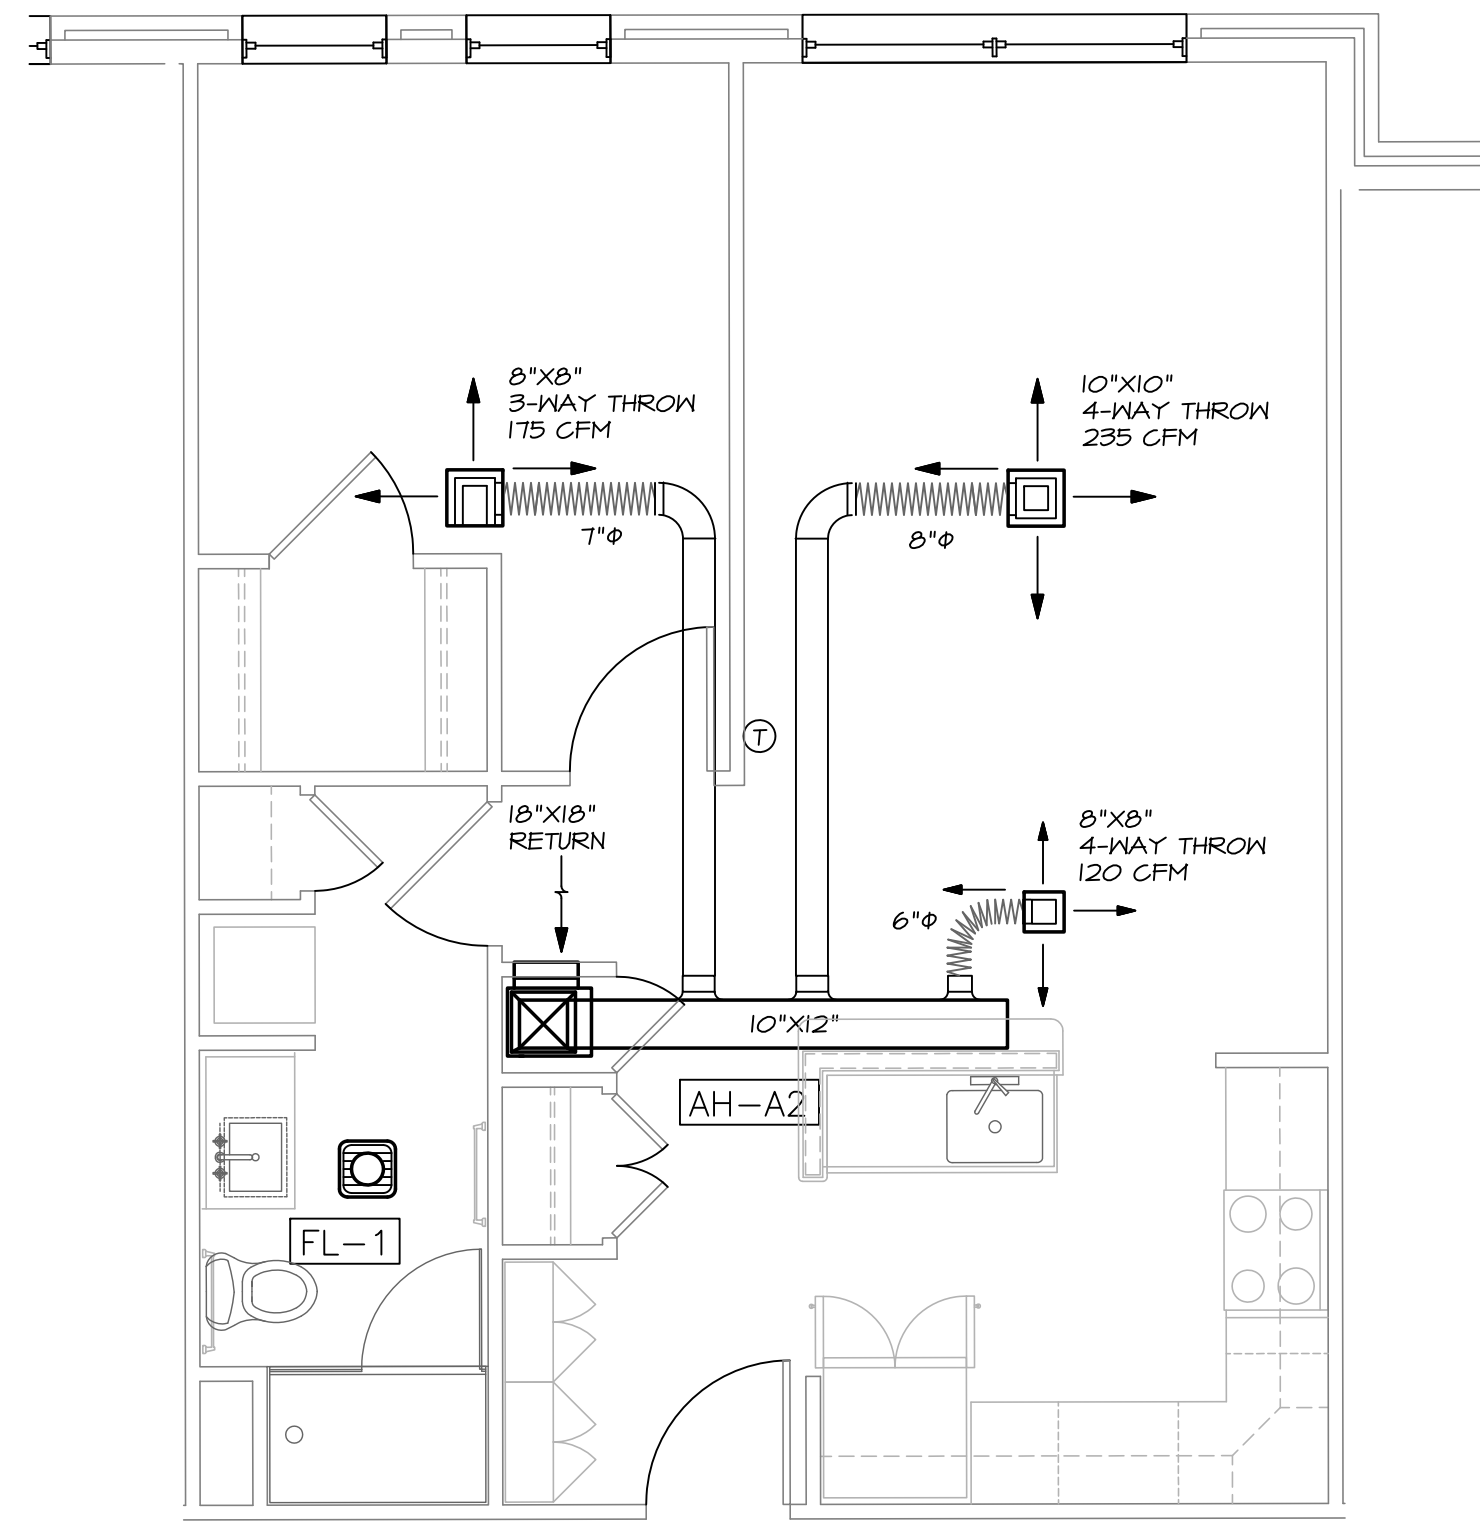


2 A2 UNIT DUCTWORK PLAN
SCALE: 1/4" = 1'-0"

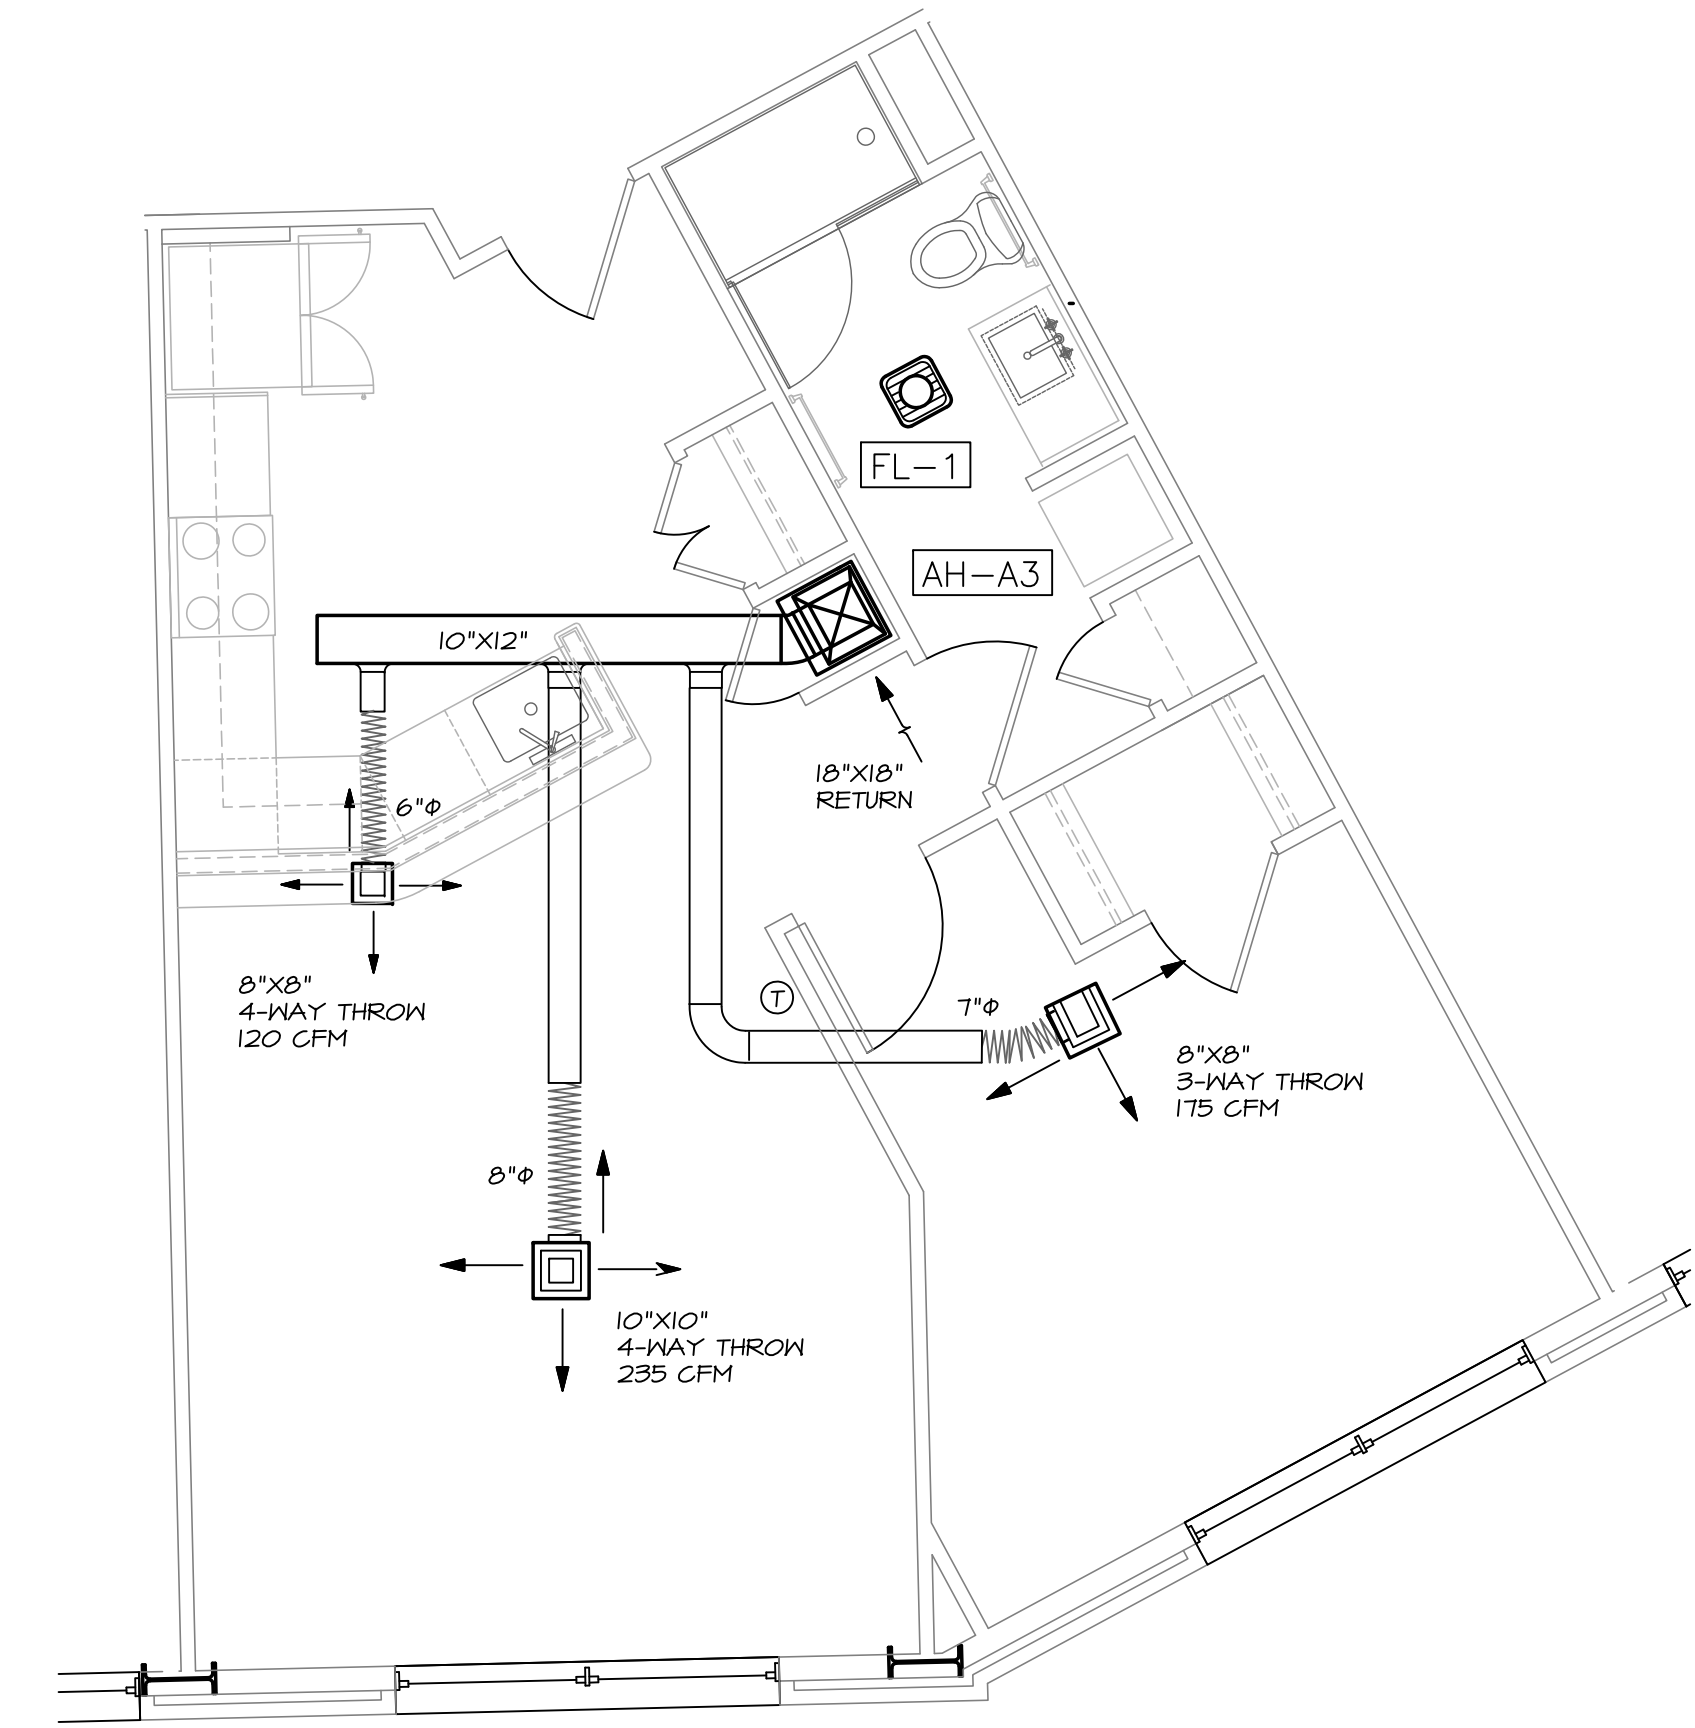


3 A3 UNIT DUCTWORK PLAN
SCALE: 1/4" = 1'-0"

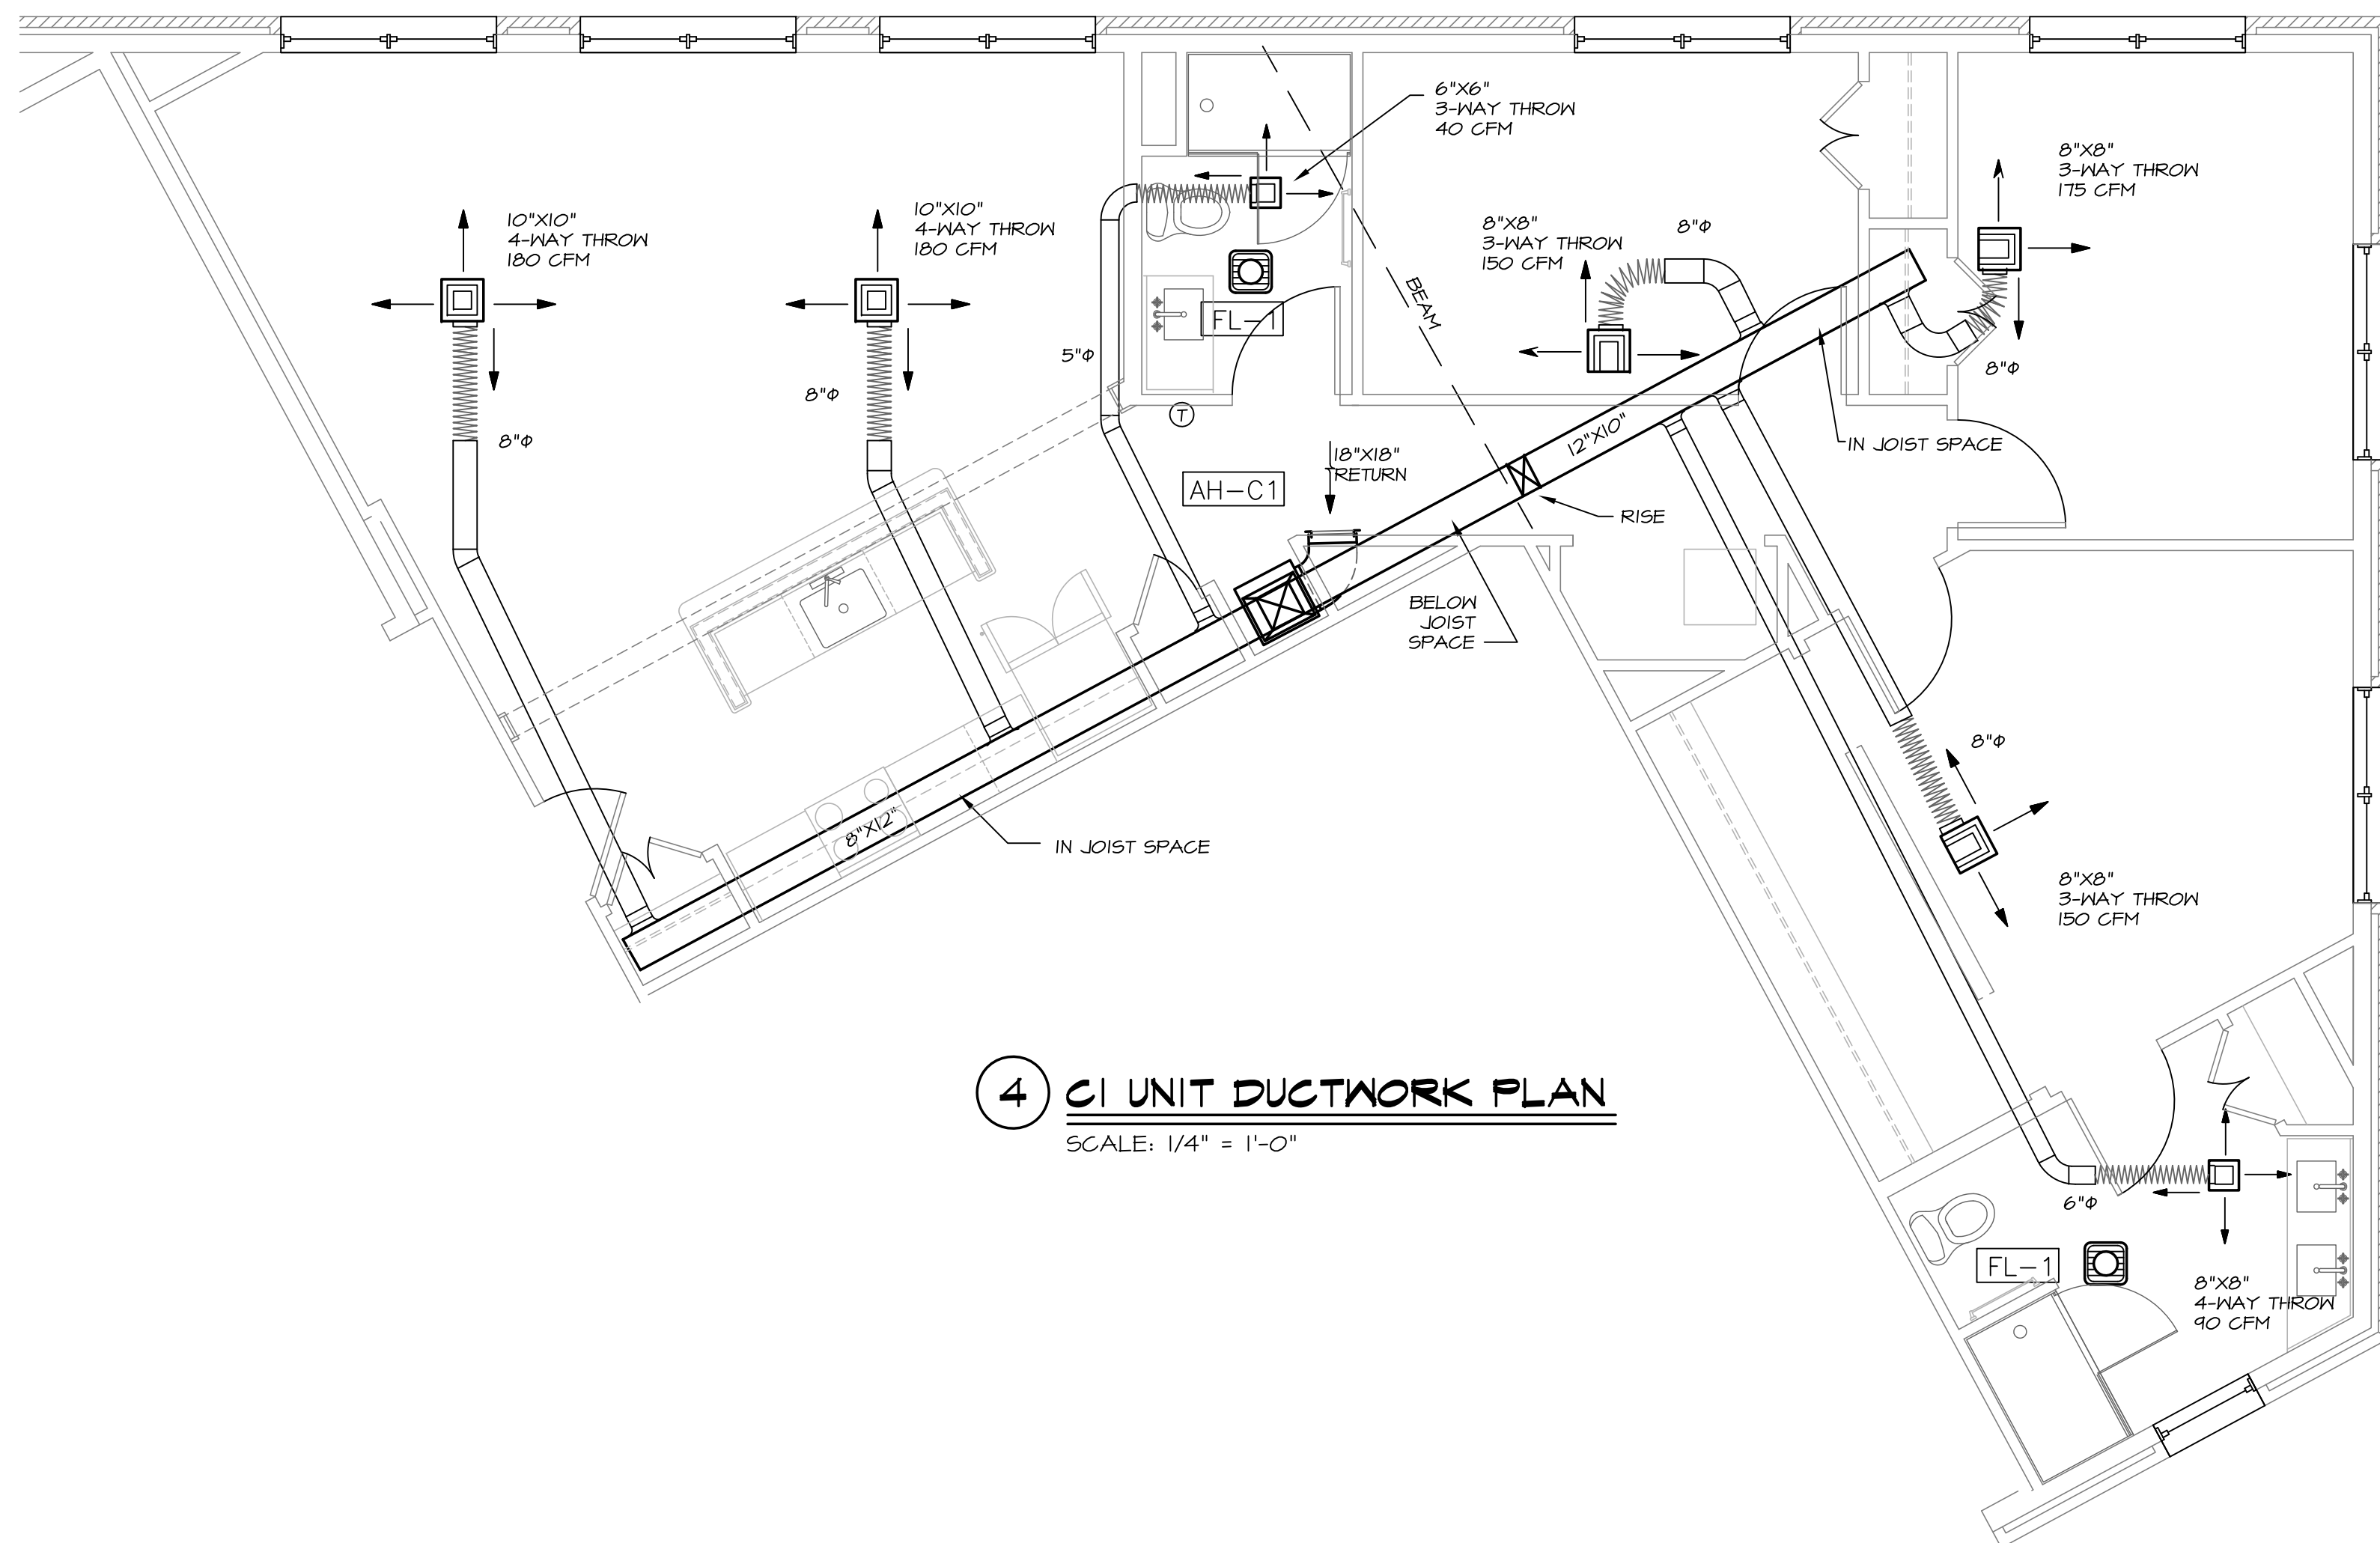

4 A4 UNIT DUCTWORK PLAN
SCALE: 1/4" = 1'-0"

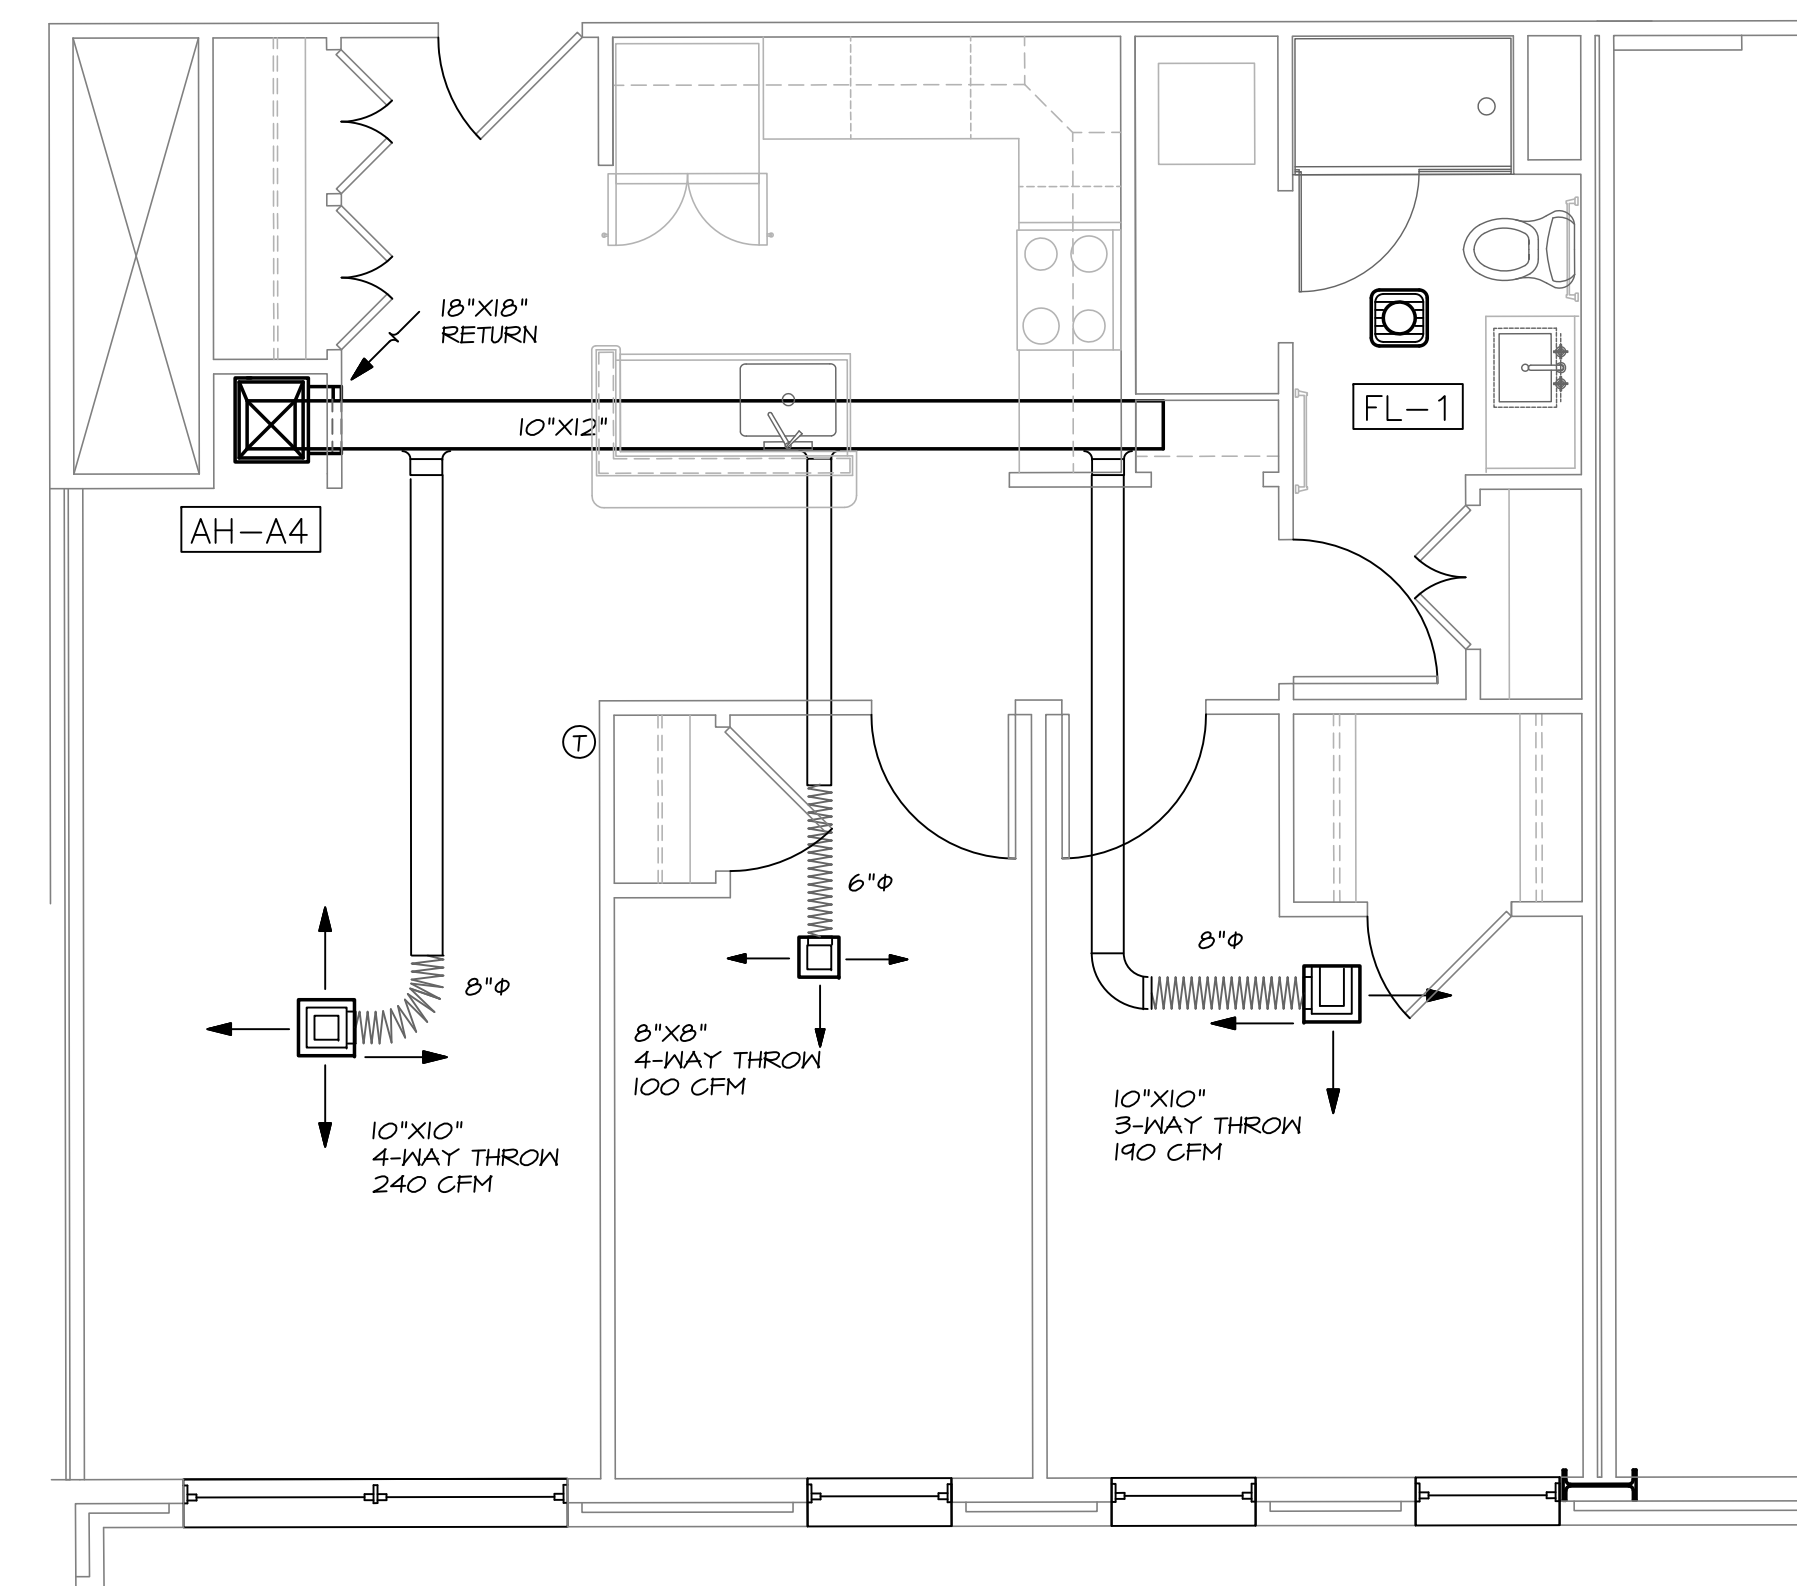

5 A5 UNIT DUCTWORK PLAN
SCALE: 1/4" = 1'-0"

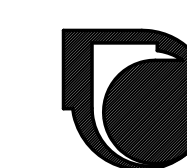

MECHANICAL SYSTEMS ENGINEERS
ROYAL RIVER CENTER, UNIT 10B
10 FOREST FALLS DRIVE, YARMOUTH, MAINE 04096
(207) 846-1441
FACEBOOK: MECHANICAL SYSTEMS ENGINEERS
© COPYRIGHT 2016
M.S.E. Proj. 1608

