




1 BI UNIT (STYLE 1) DUCTWORK PLAN
SCALE: 1/4" = 1'-0"

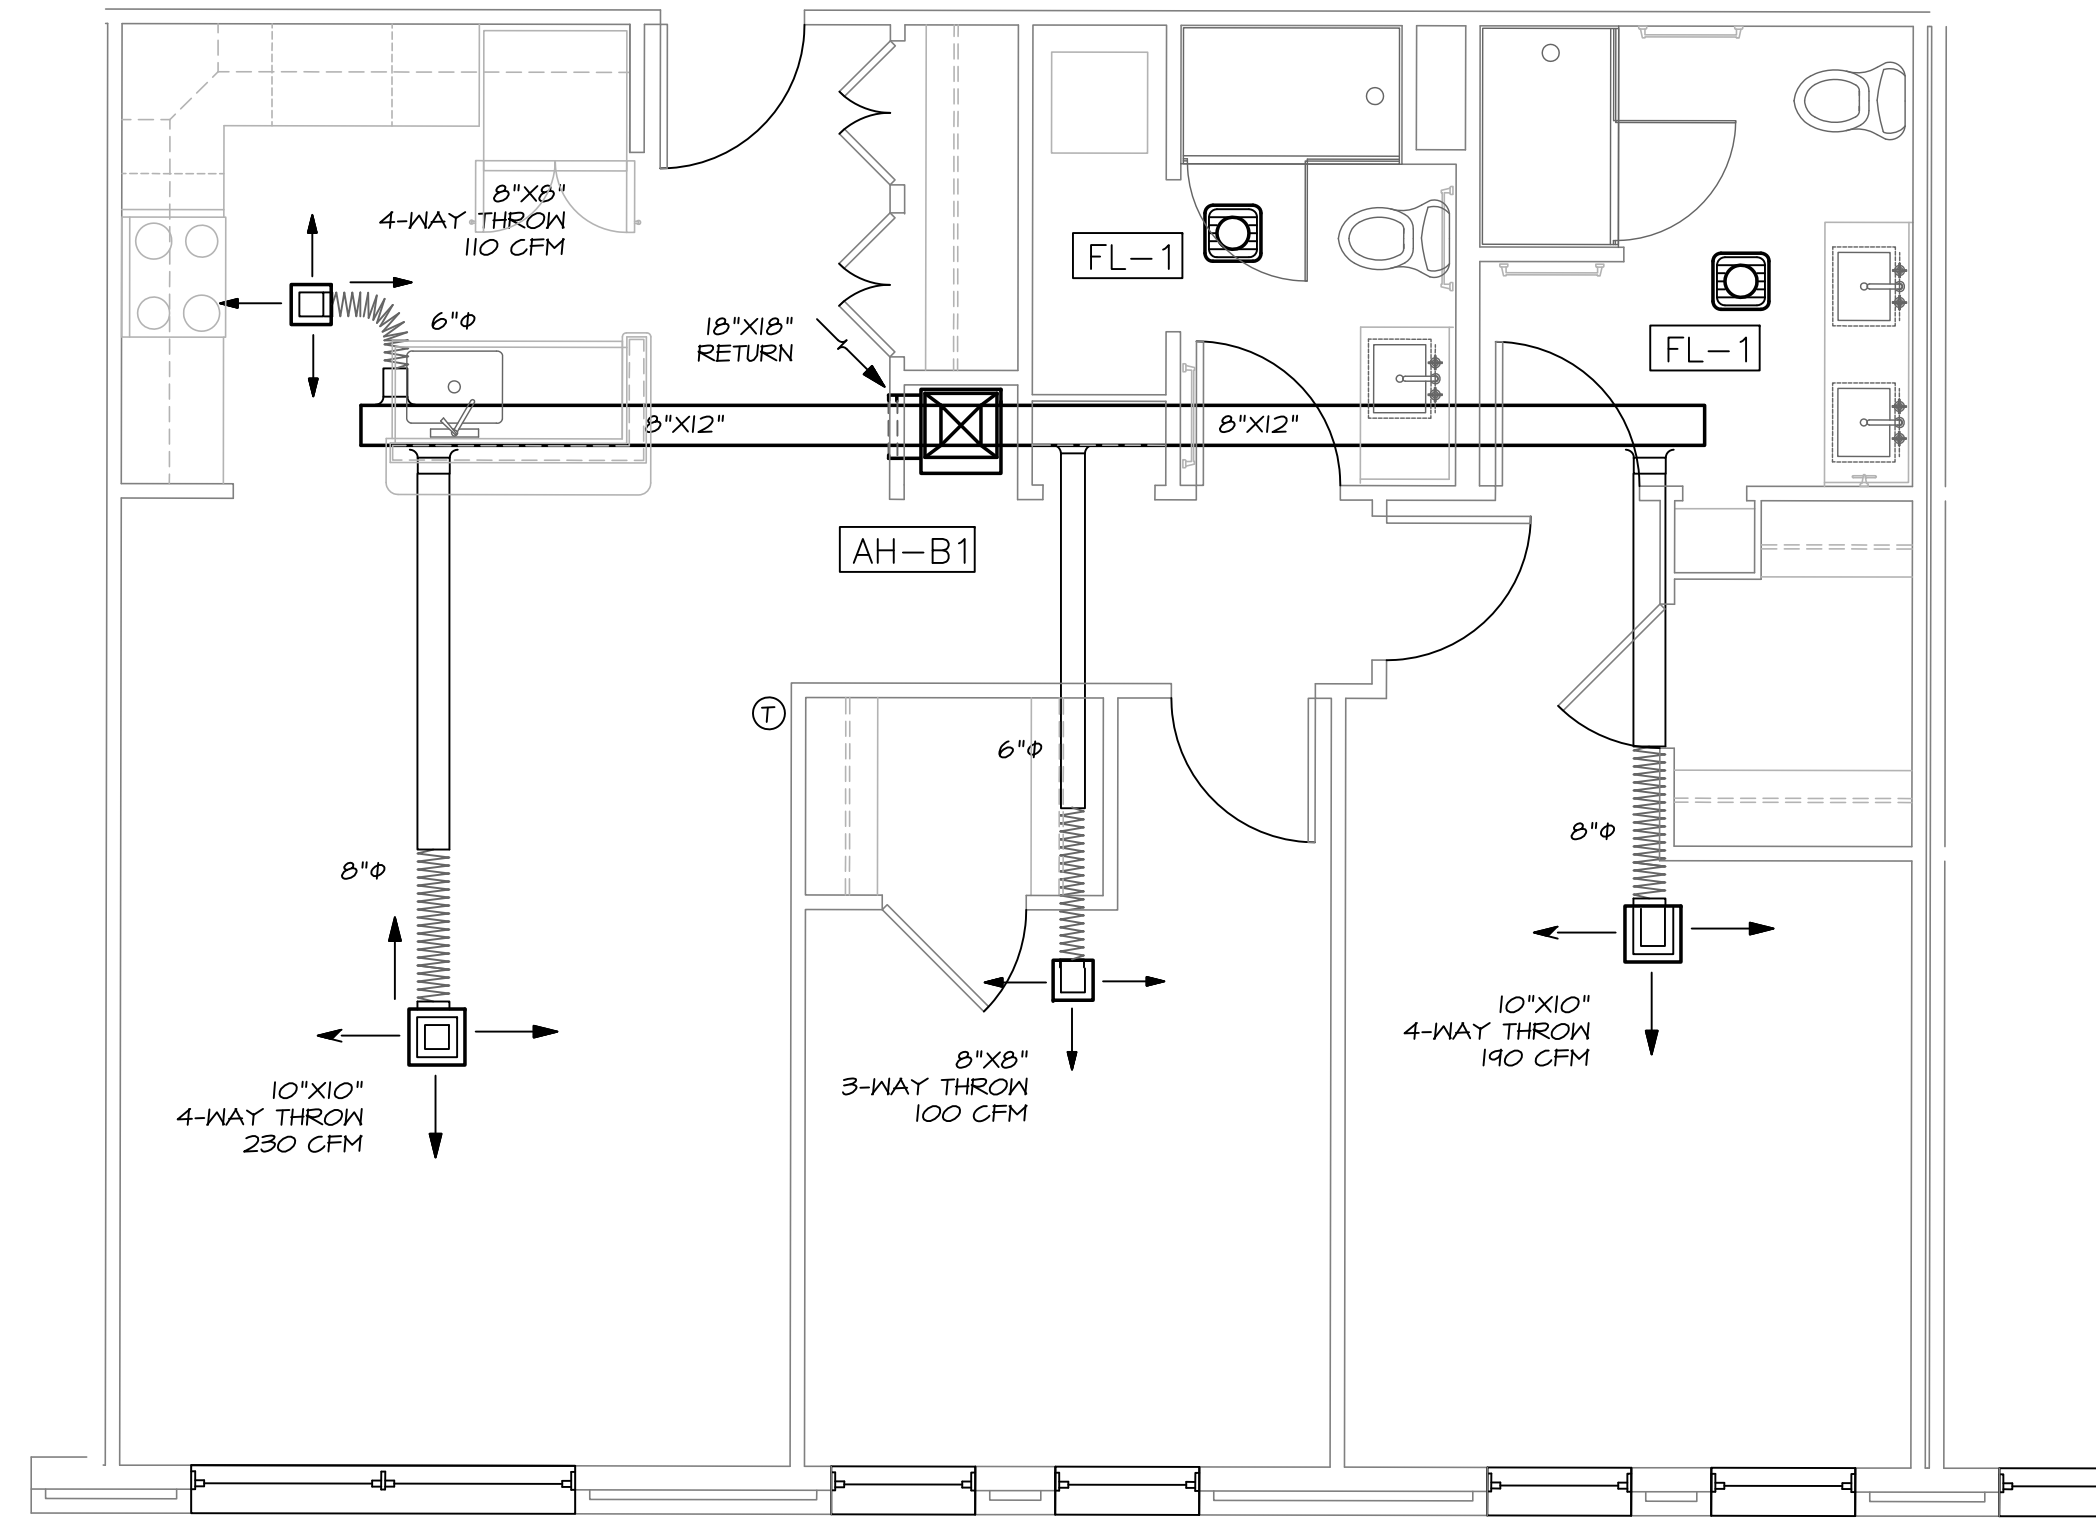


2 BI UNIT (STYLE 2) DUCTWORK PLAN
SCALE: 1/4" = 1'-0"

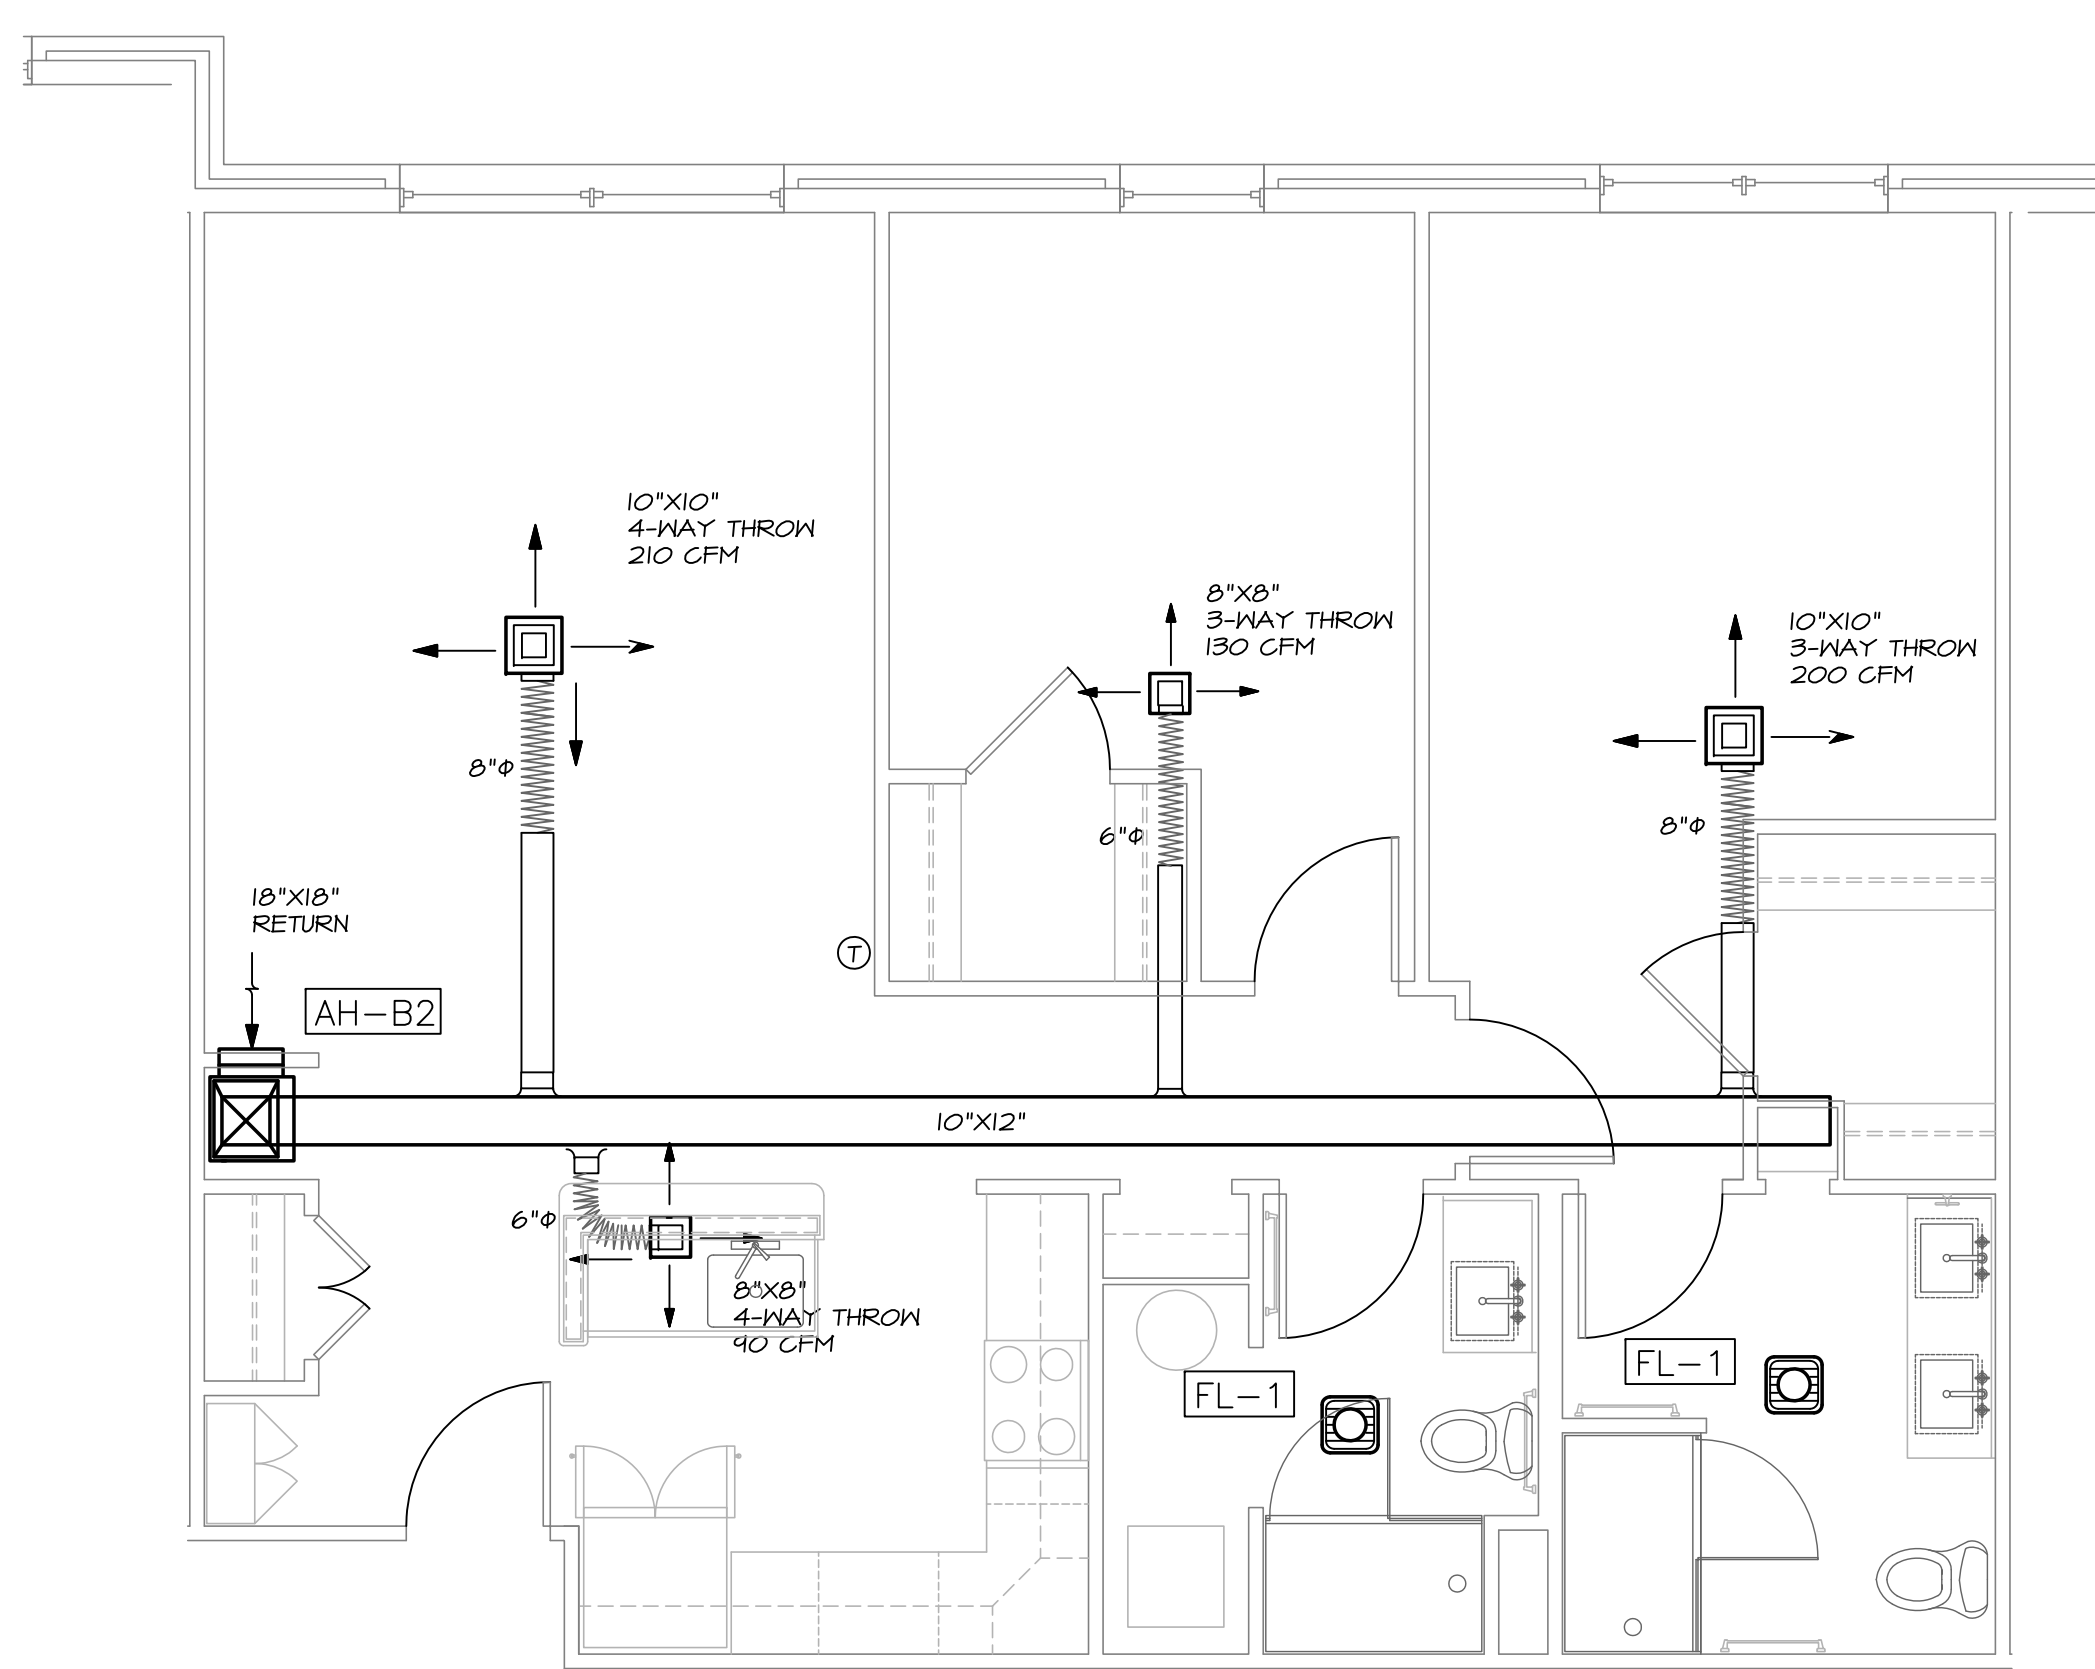

3 B2 UNIT DUCTWORK PLAN
SCALE: 1/4" = 1'-0"

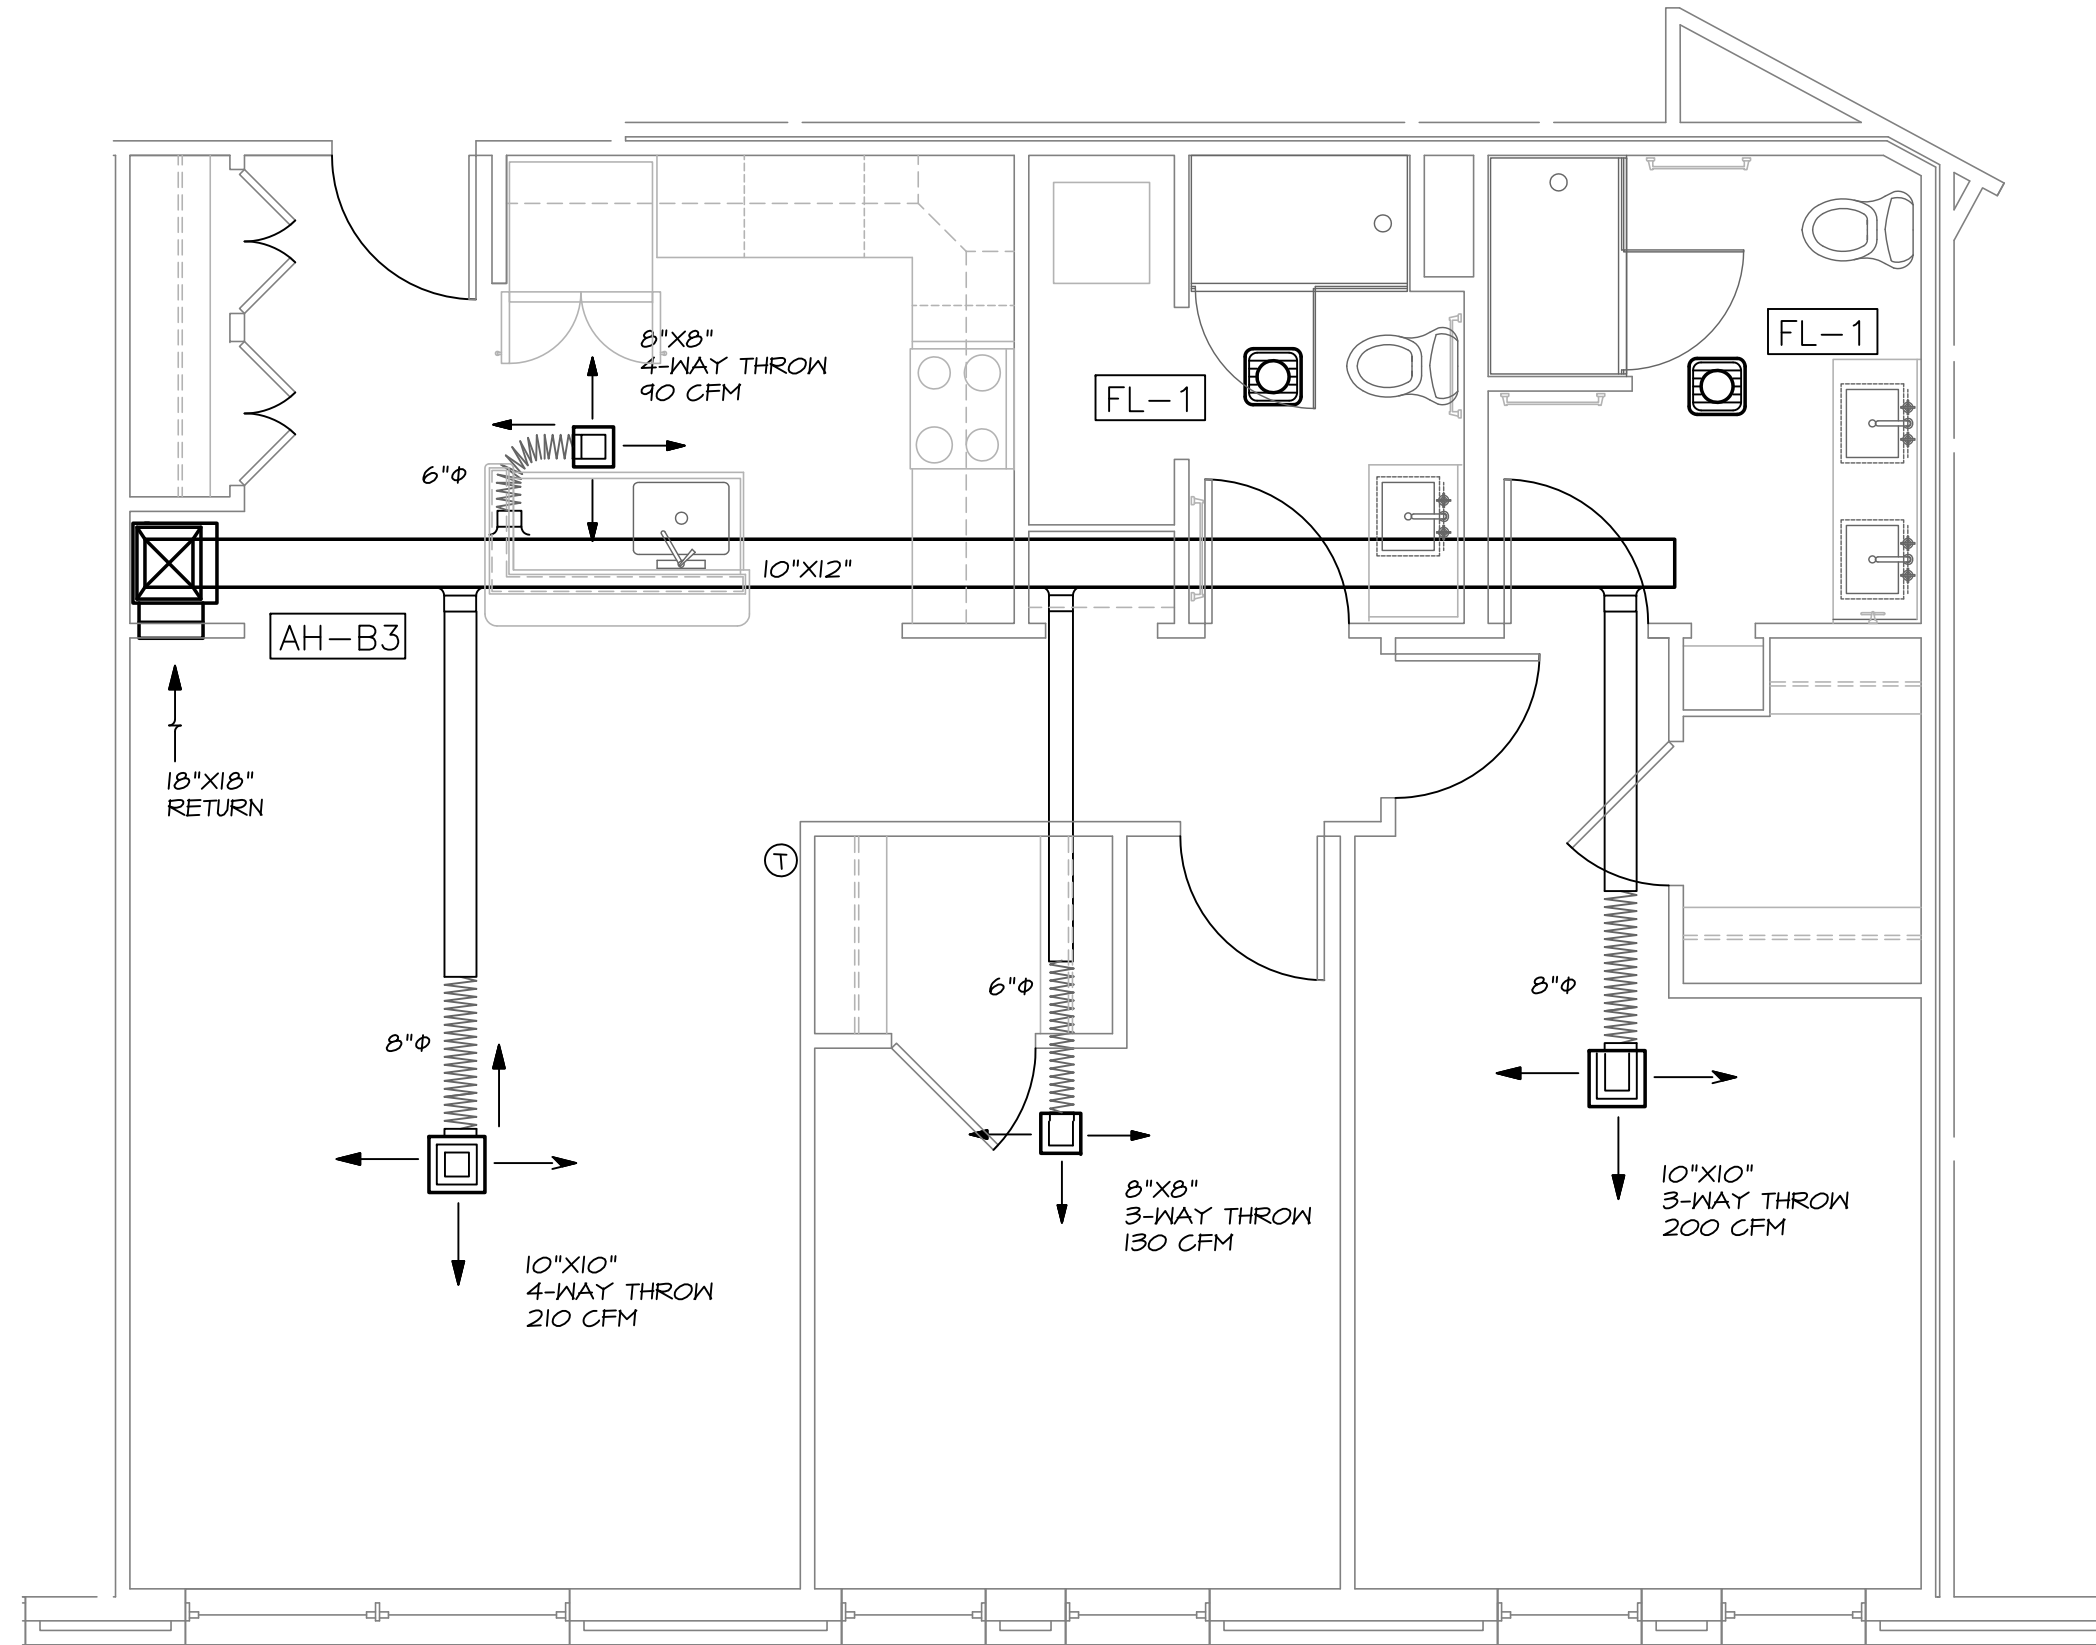

4 B3 UNIT DUCTWORK PLAN
SCALE: 1/4" = 1'-0"

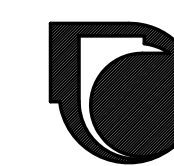

MECHANICAL SYSTEMS ENGINEERS
ROYAL RIVER CENTER, UNIT 10B
10 FOREST FALLS DRIVE, YARMOUTH, MAINE 04096
(207) 846-1441
FACEBOOK: MECHANICAL SYSTEMS ENGINEERS
© COPYRIGHT 2016
M.S.E. Proj. 1608

