

Copyright 2016 Opechee Construction Corporation
Wednesday, March 23, 2016 3:58:25 PM


REVISION:


ISSUED:

project architect: KAK
drawn by: JJD

**FOURTH LEVEL
PLUMBING
PLAN**

sheet number:
P1.04

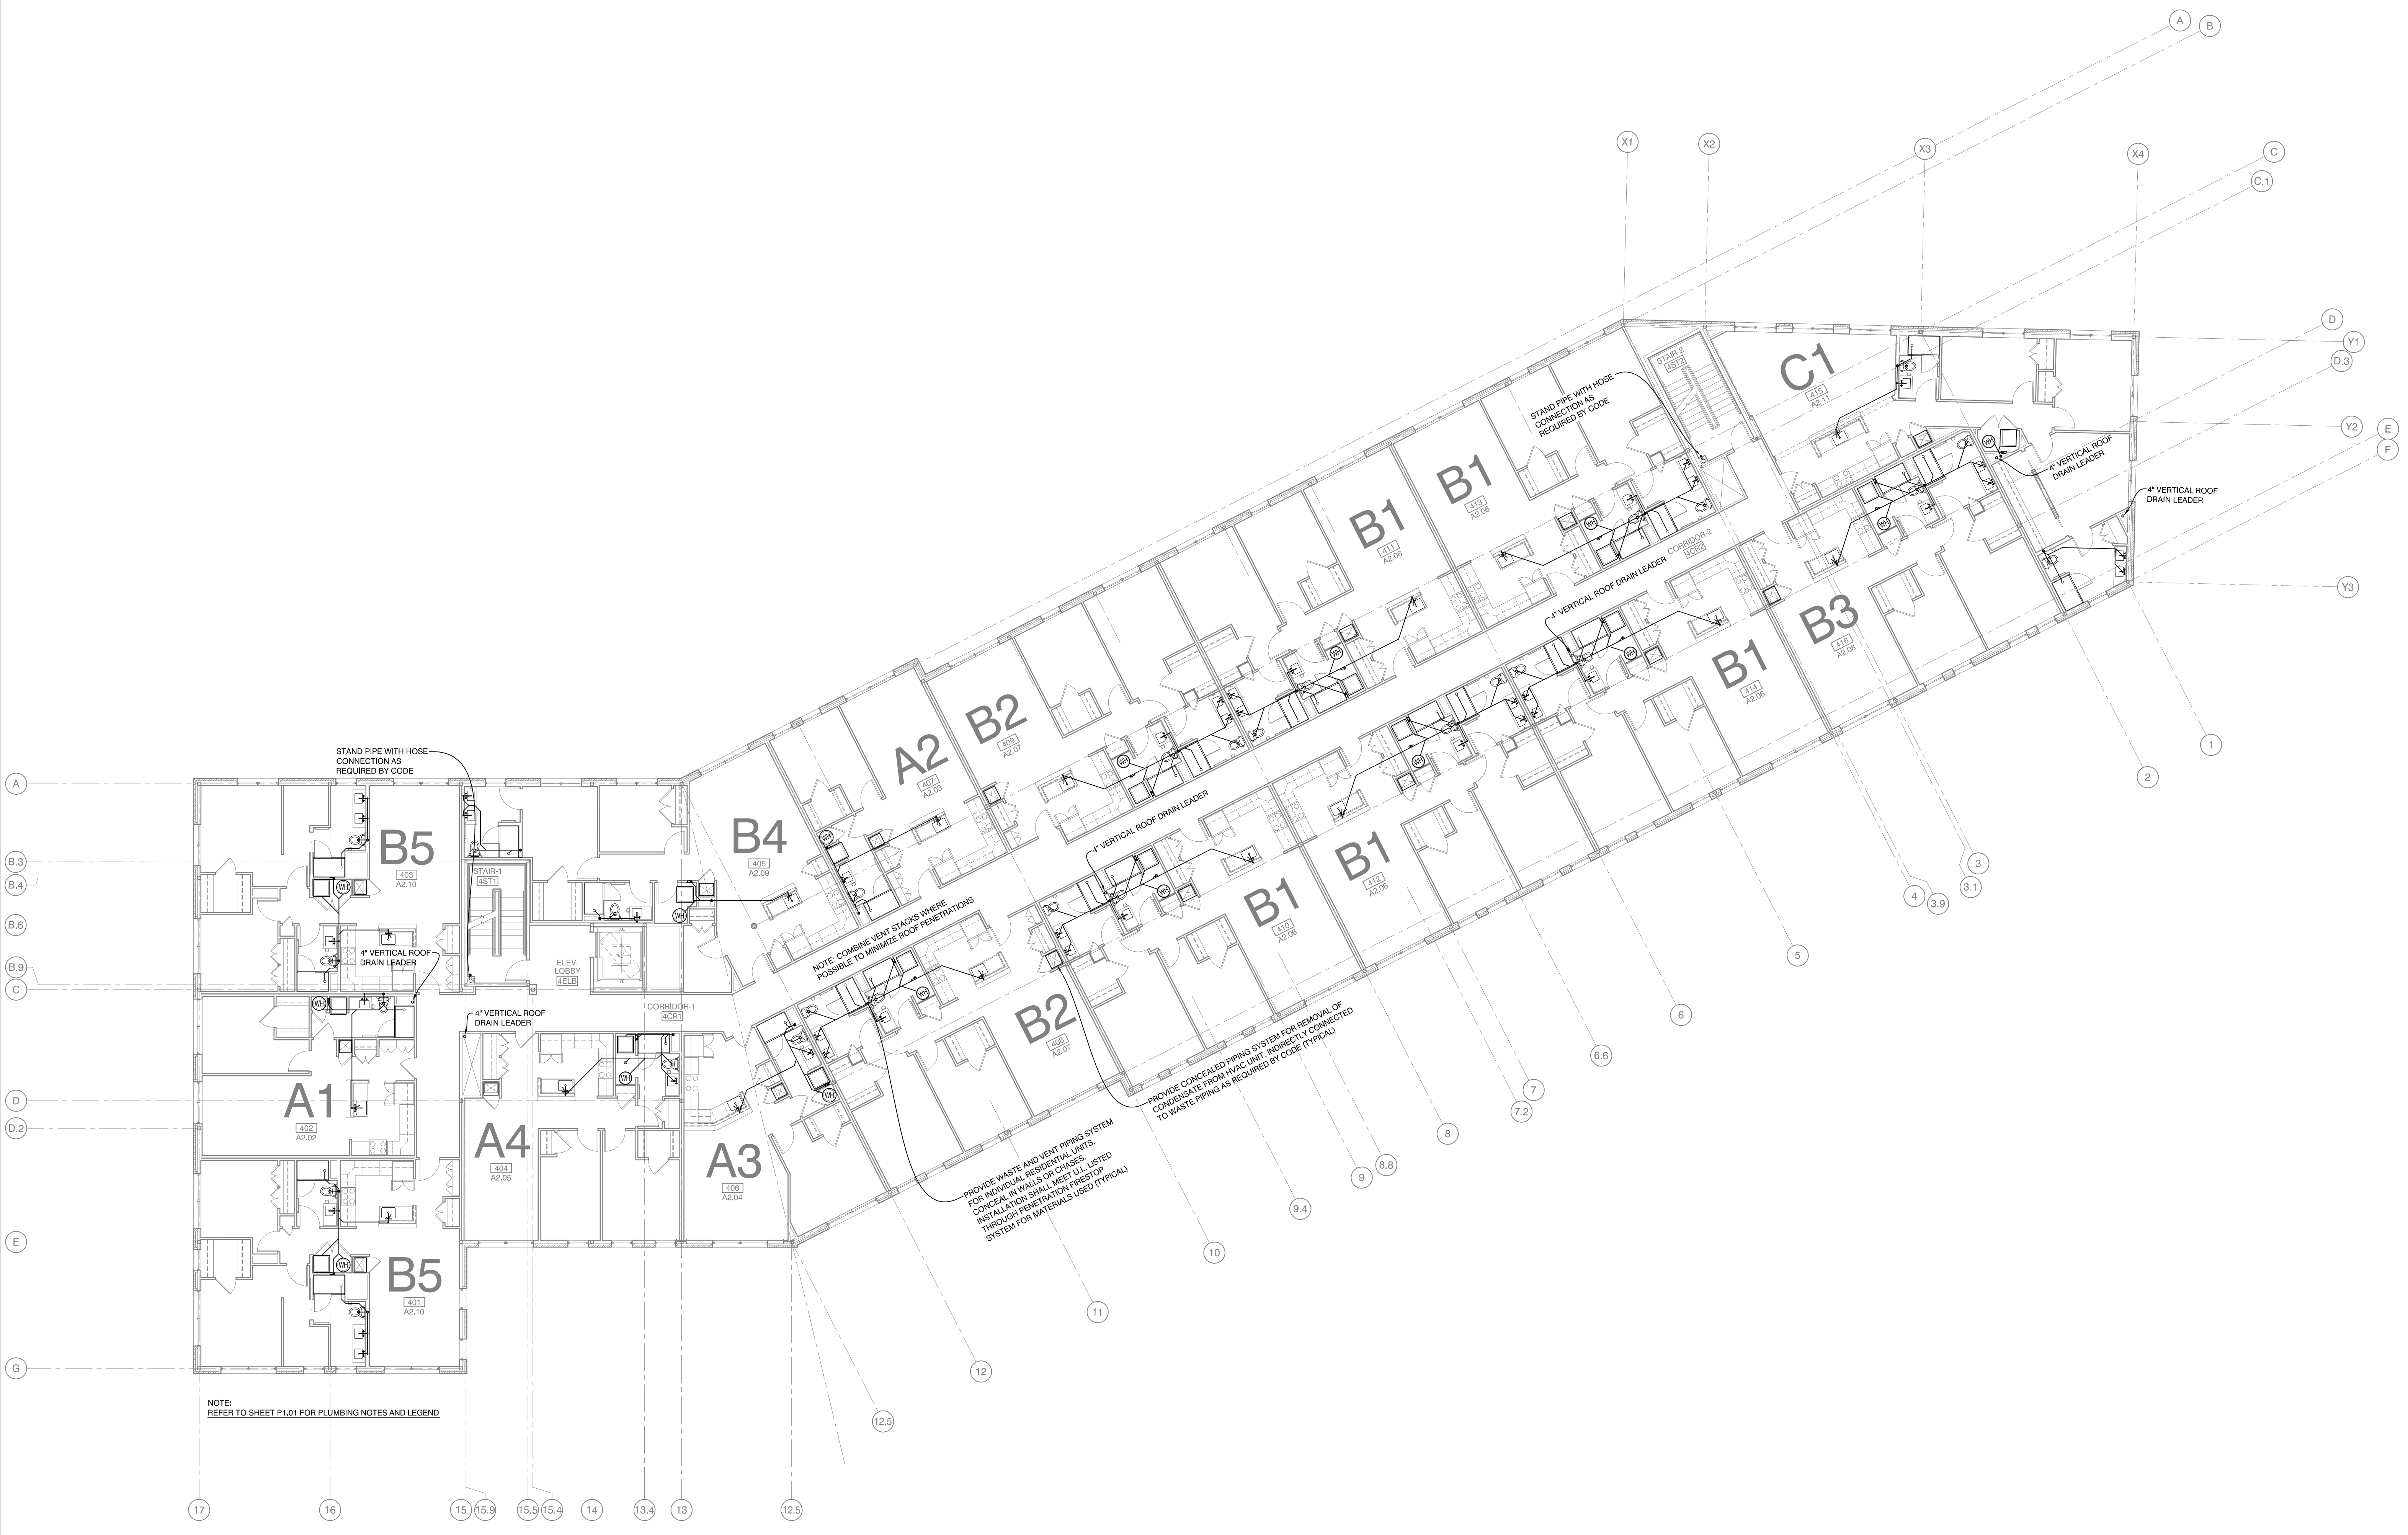

PLAN  NORTH **1** FOURTH LEVEL PLUMBING PLAN
3/32" = 1'-0"