




B5 2 BEDROOM UNIT FIRE ALARM PLAN
 1/4" = 1'-0"; UNITS 201, 203, 301, 303, 401, 403, 501, & 503

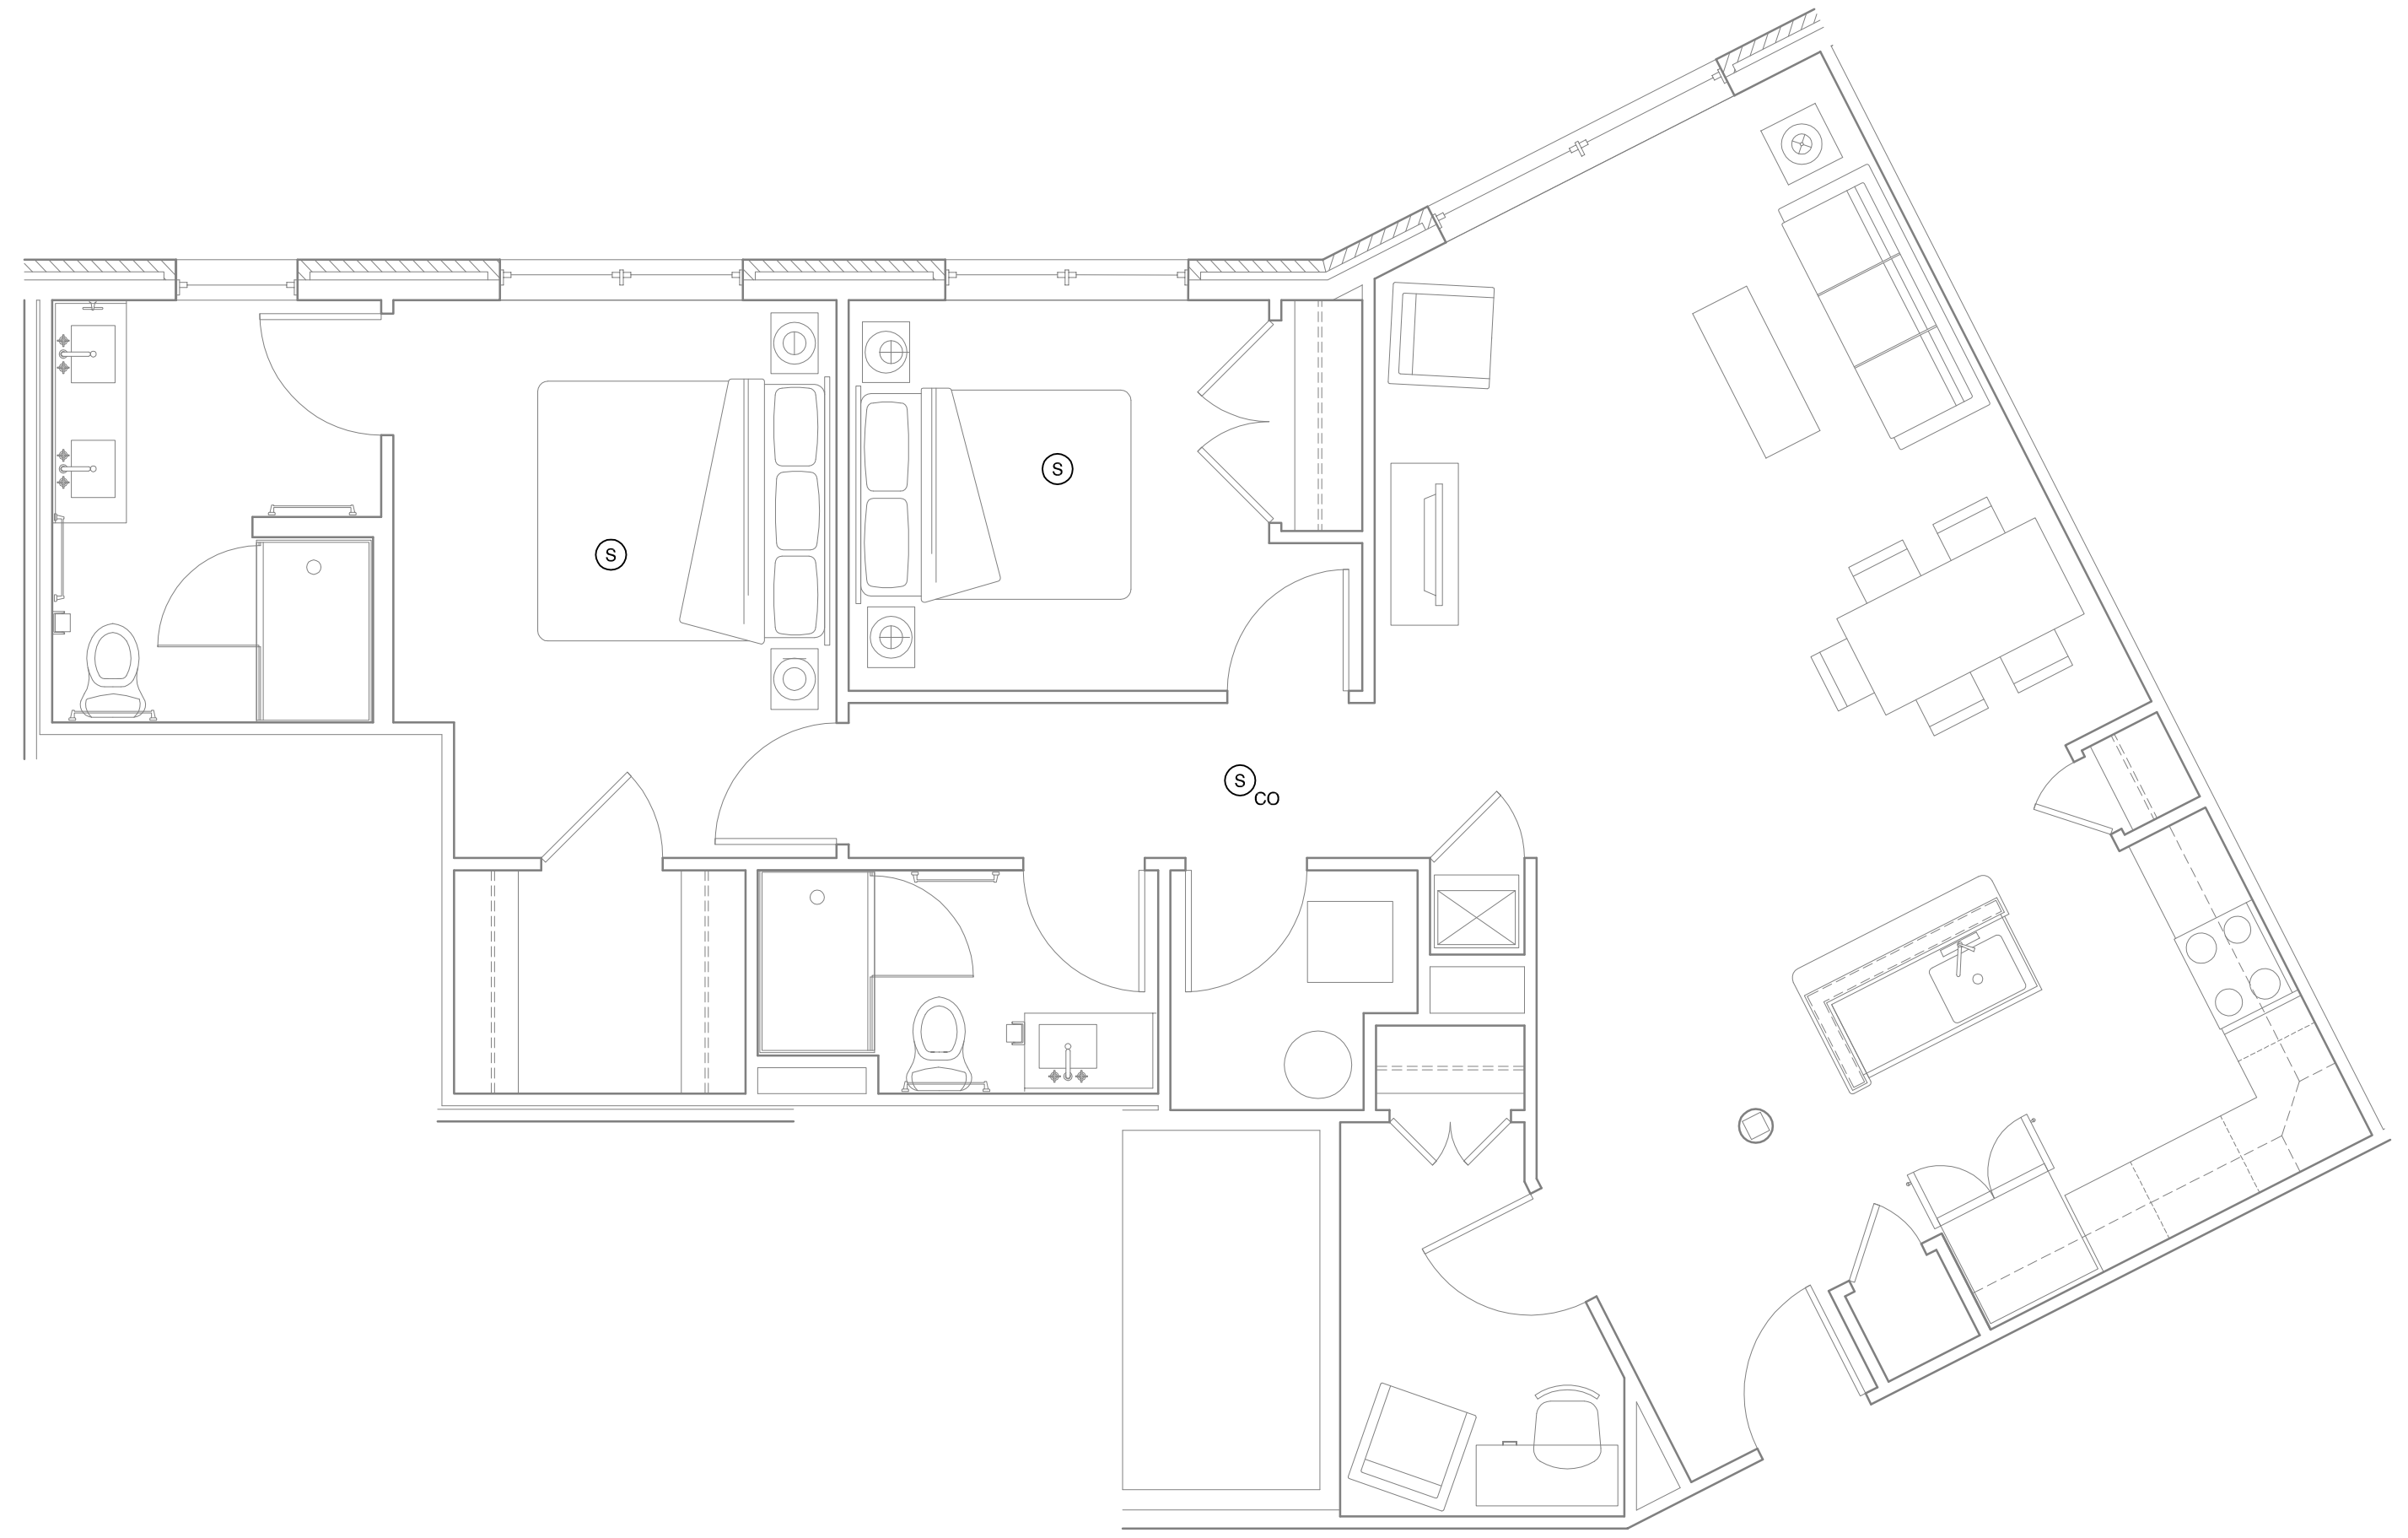


B4 2 BEDROOM UNIT FIRE ALARM PLAN
 1/4" = 1'-0"; UNITS - 305, 405, & 505

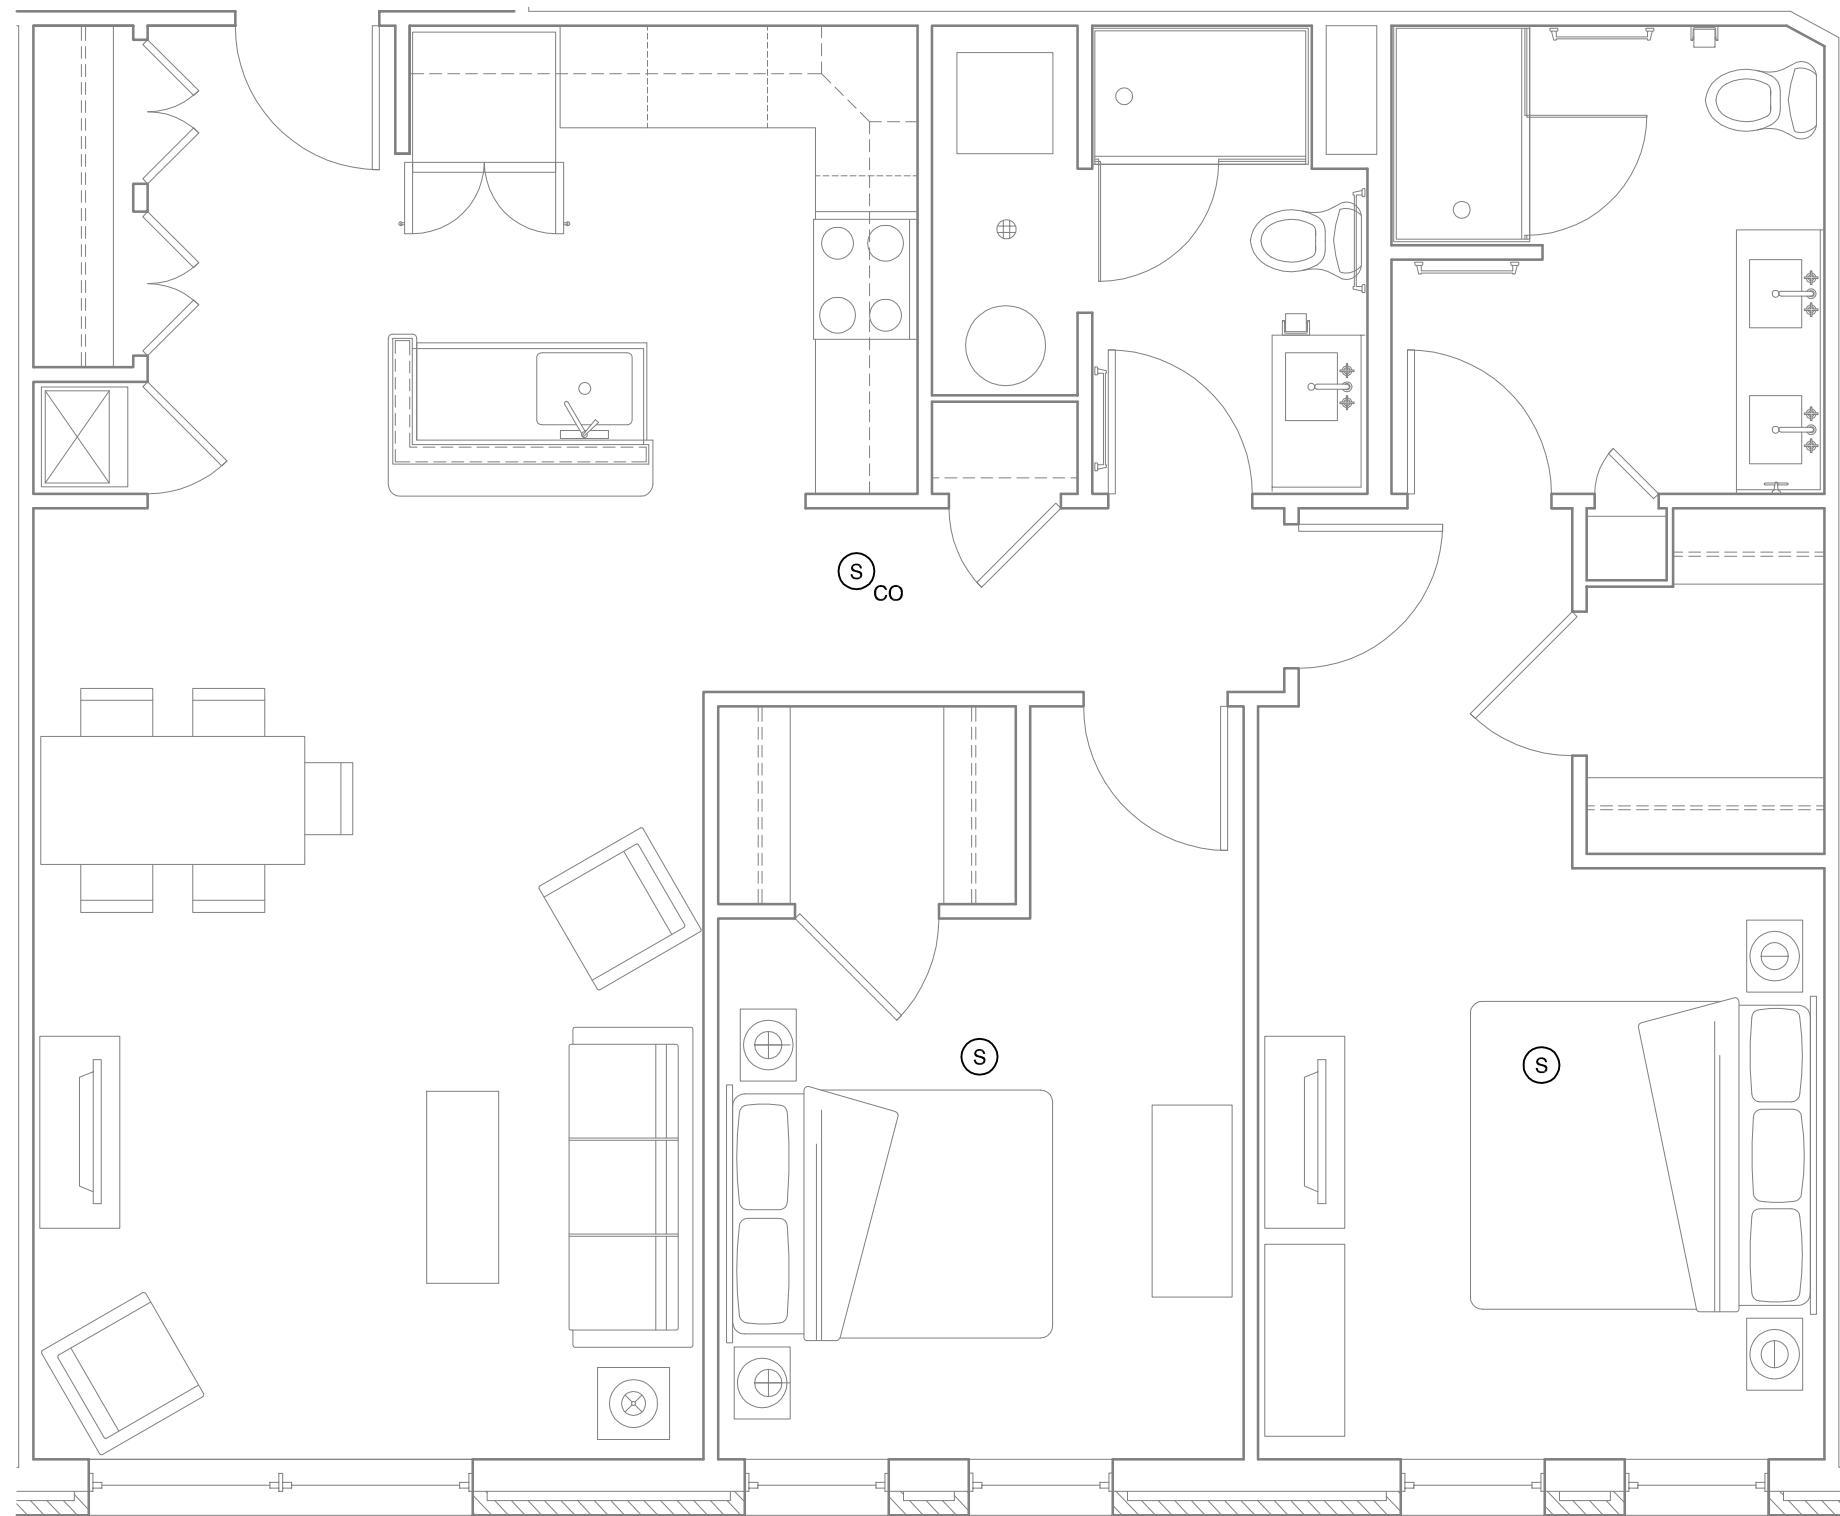

B3 2 BEDROOM UNIT FIRE ALARM PLAN
 1/4" = 1'-0"; UNITS 216, 316, 416, & 516

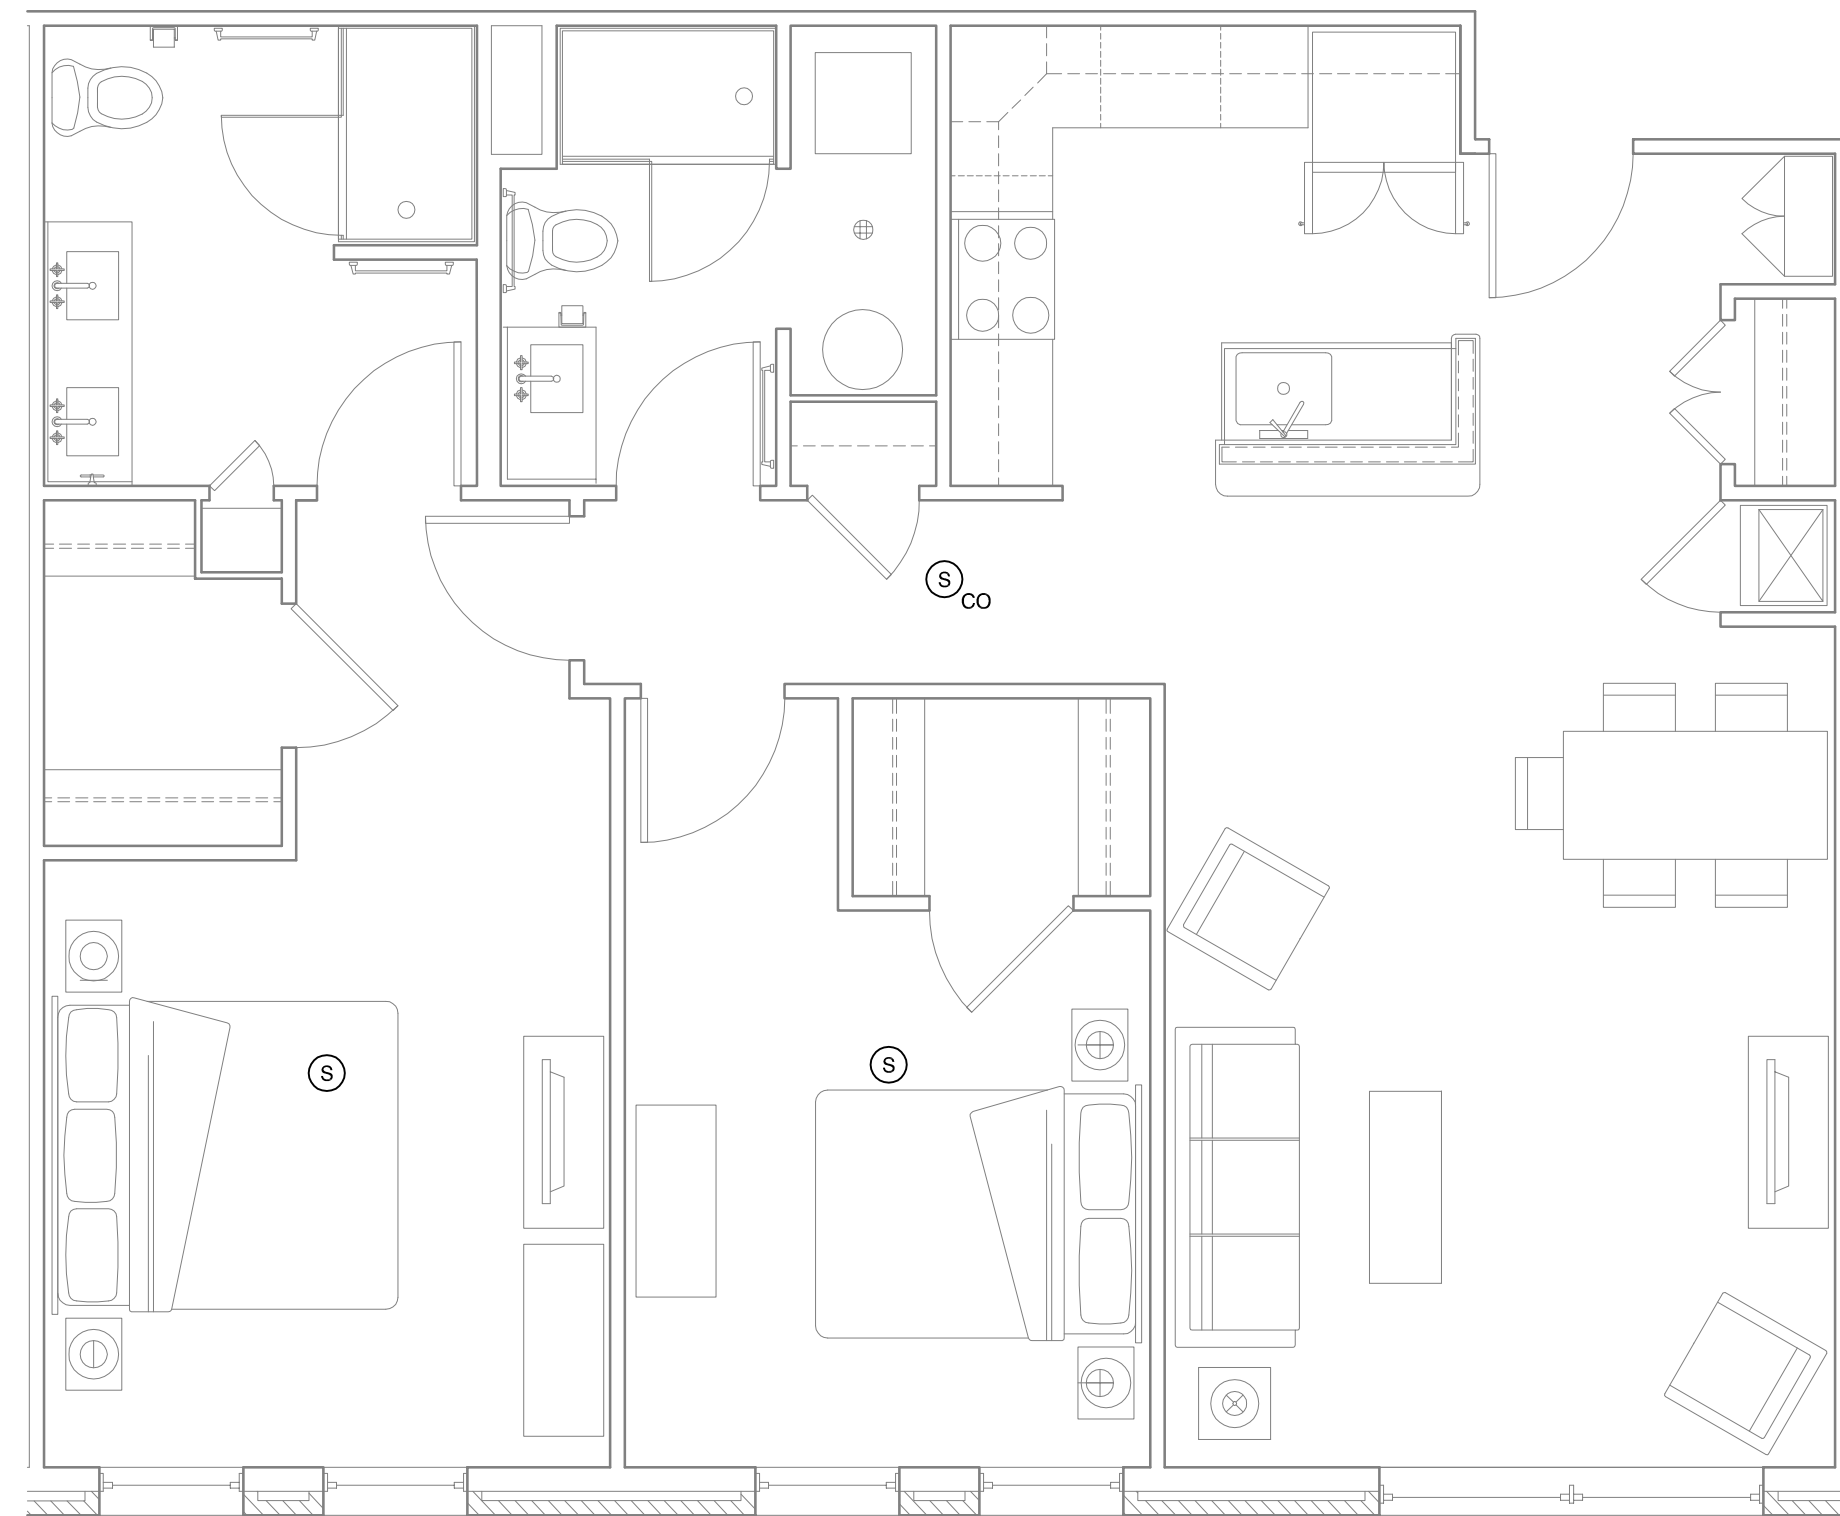

B2 2 BEDROOM UNIT FIRE ALARM PLAN
 1/4" = 1'-0"; UNITS 208, 209, 309, 408, 409, 508, & 509

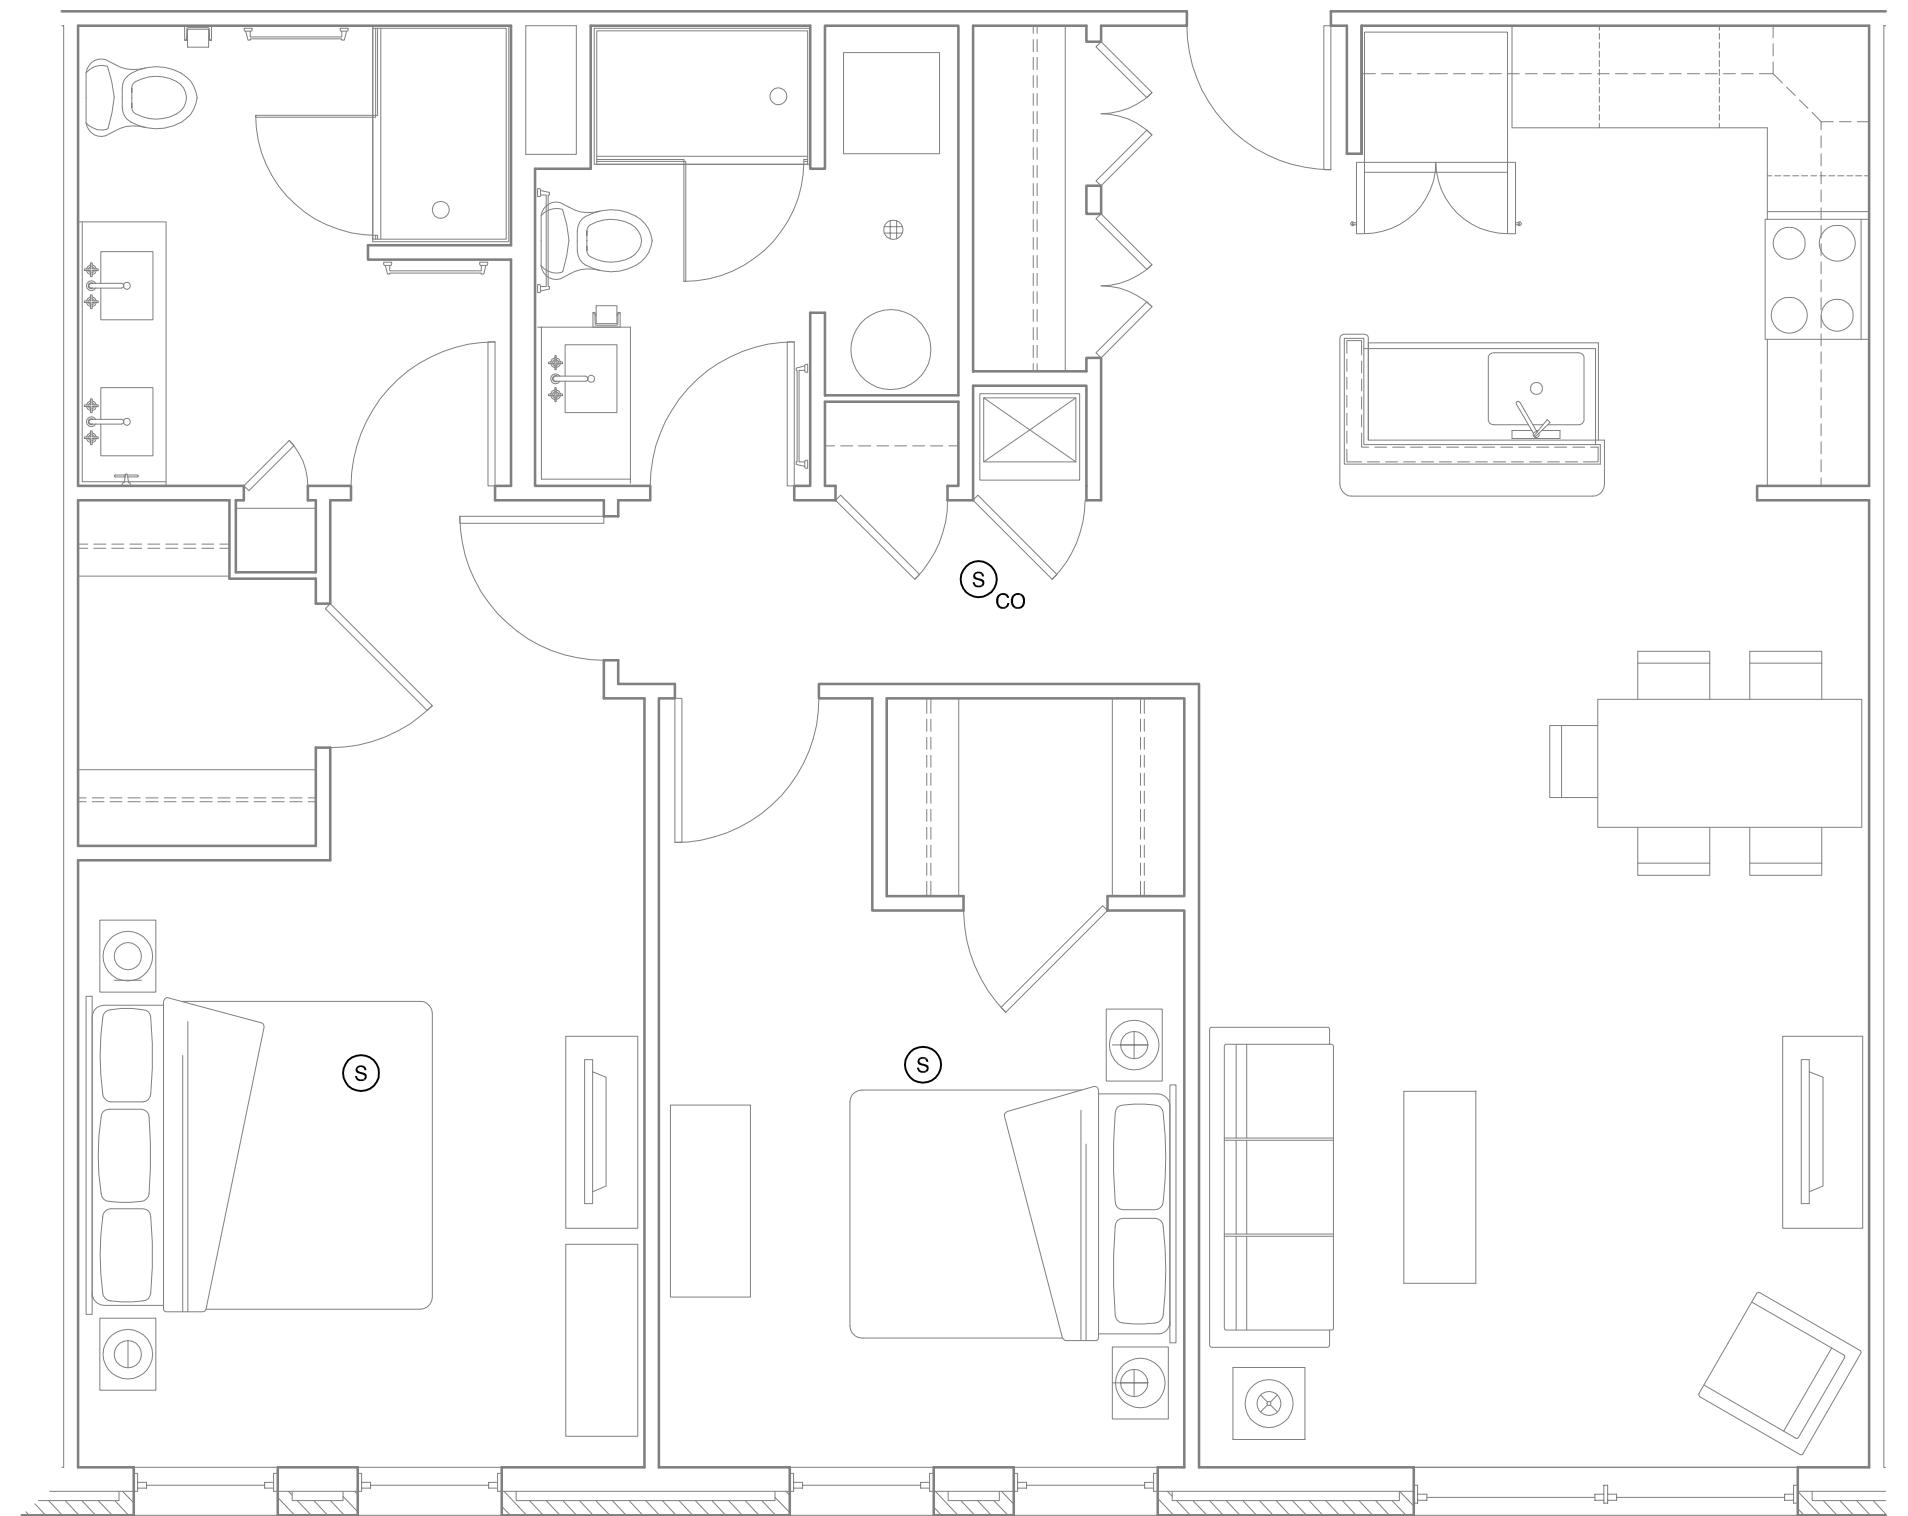

B1 2 BEDROOM UNIT FIRE ALARM PLAN
 1/4" = 1'-0"; UNITS - 210, 211, 212, 213, 214, 310, 311, 312, 313, 314, 410, 411, 412, 413, 414, 510, 511, 512, 513, & 514

Mixed Use Development

York & High Street
 Portland, Maine

REVISION:
 07-13-16 SMOKE / CO UPDATED IN UNIT B4

ISSUED:
 project architect: KAK
 drawn by: JJD

RESIDENTIAL
 2 BR UNIT
 FIRE ALM. PLANS

sheet number:
FA2.02