




1 BI UNIT (STYLE 1) DUCTWORK PLAN
SCALE: 1/4" = 1'-0"

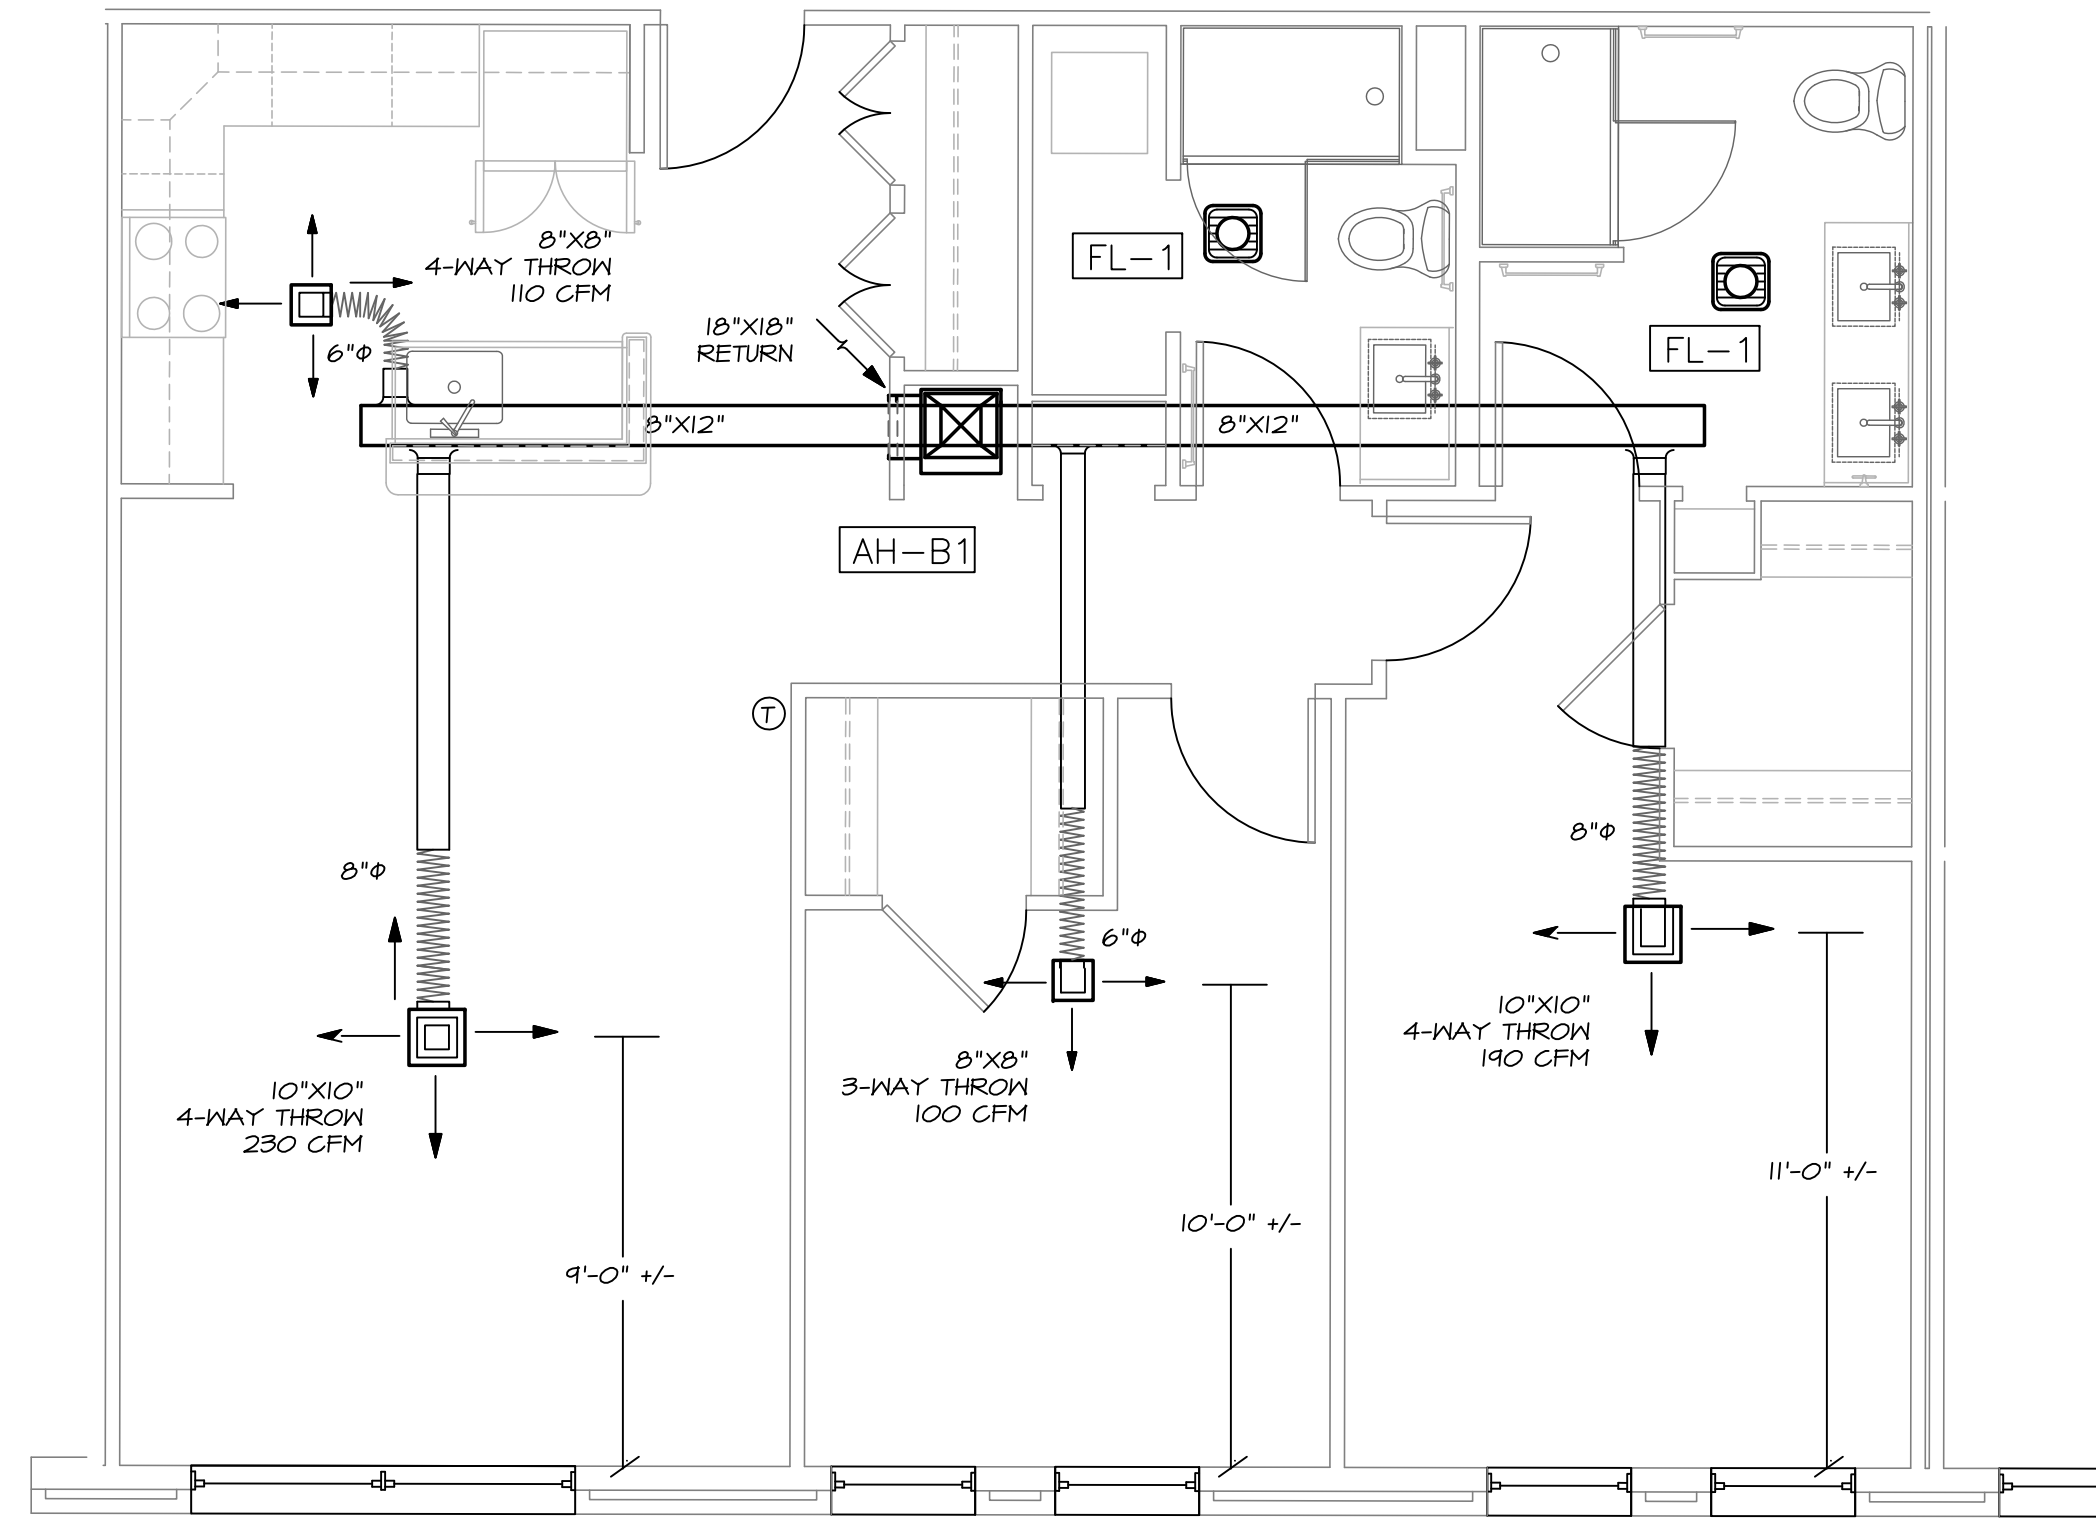

2 BI UNIT (STYLE 2) DUCTWORK PLAN
SCALE: 1/4" = 1'-0"

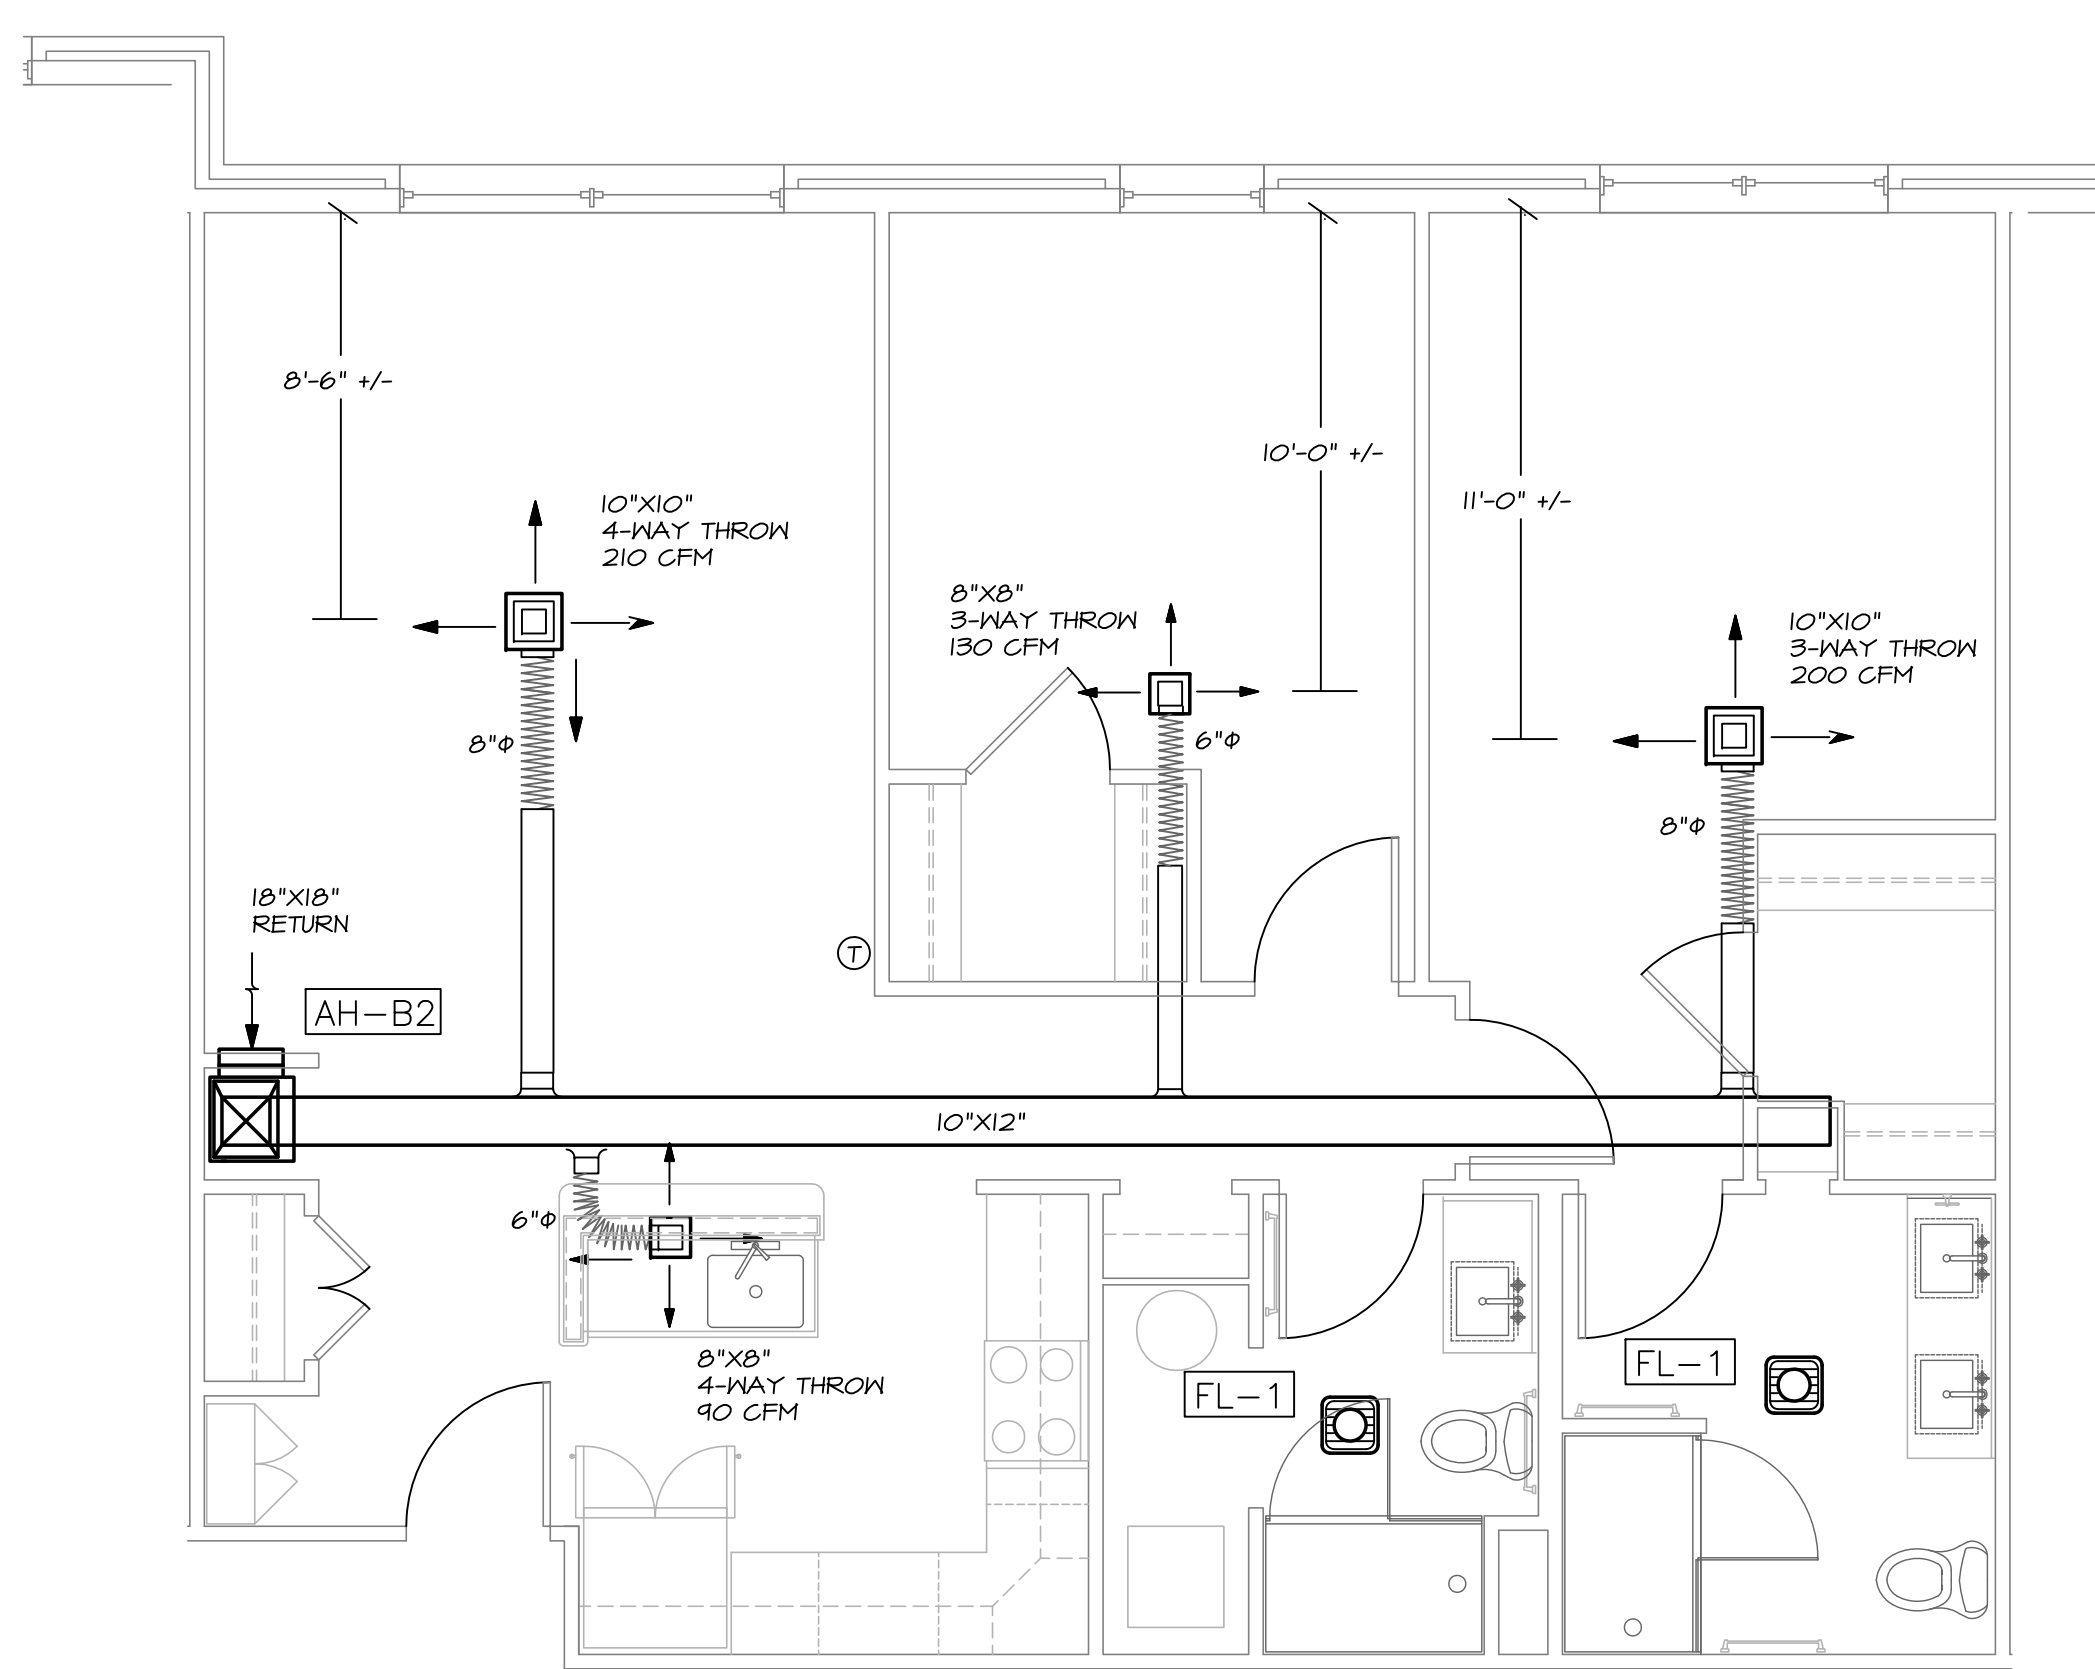


3 B2 UNIT DUCTWORK PLAN
SCALE: 1/4" = 1'-0"

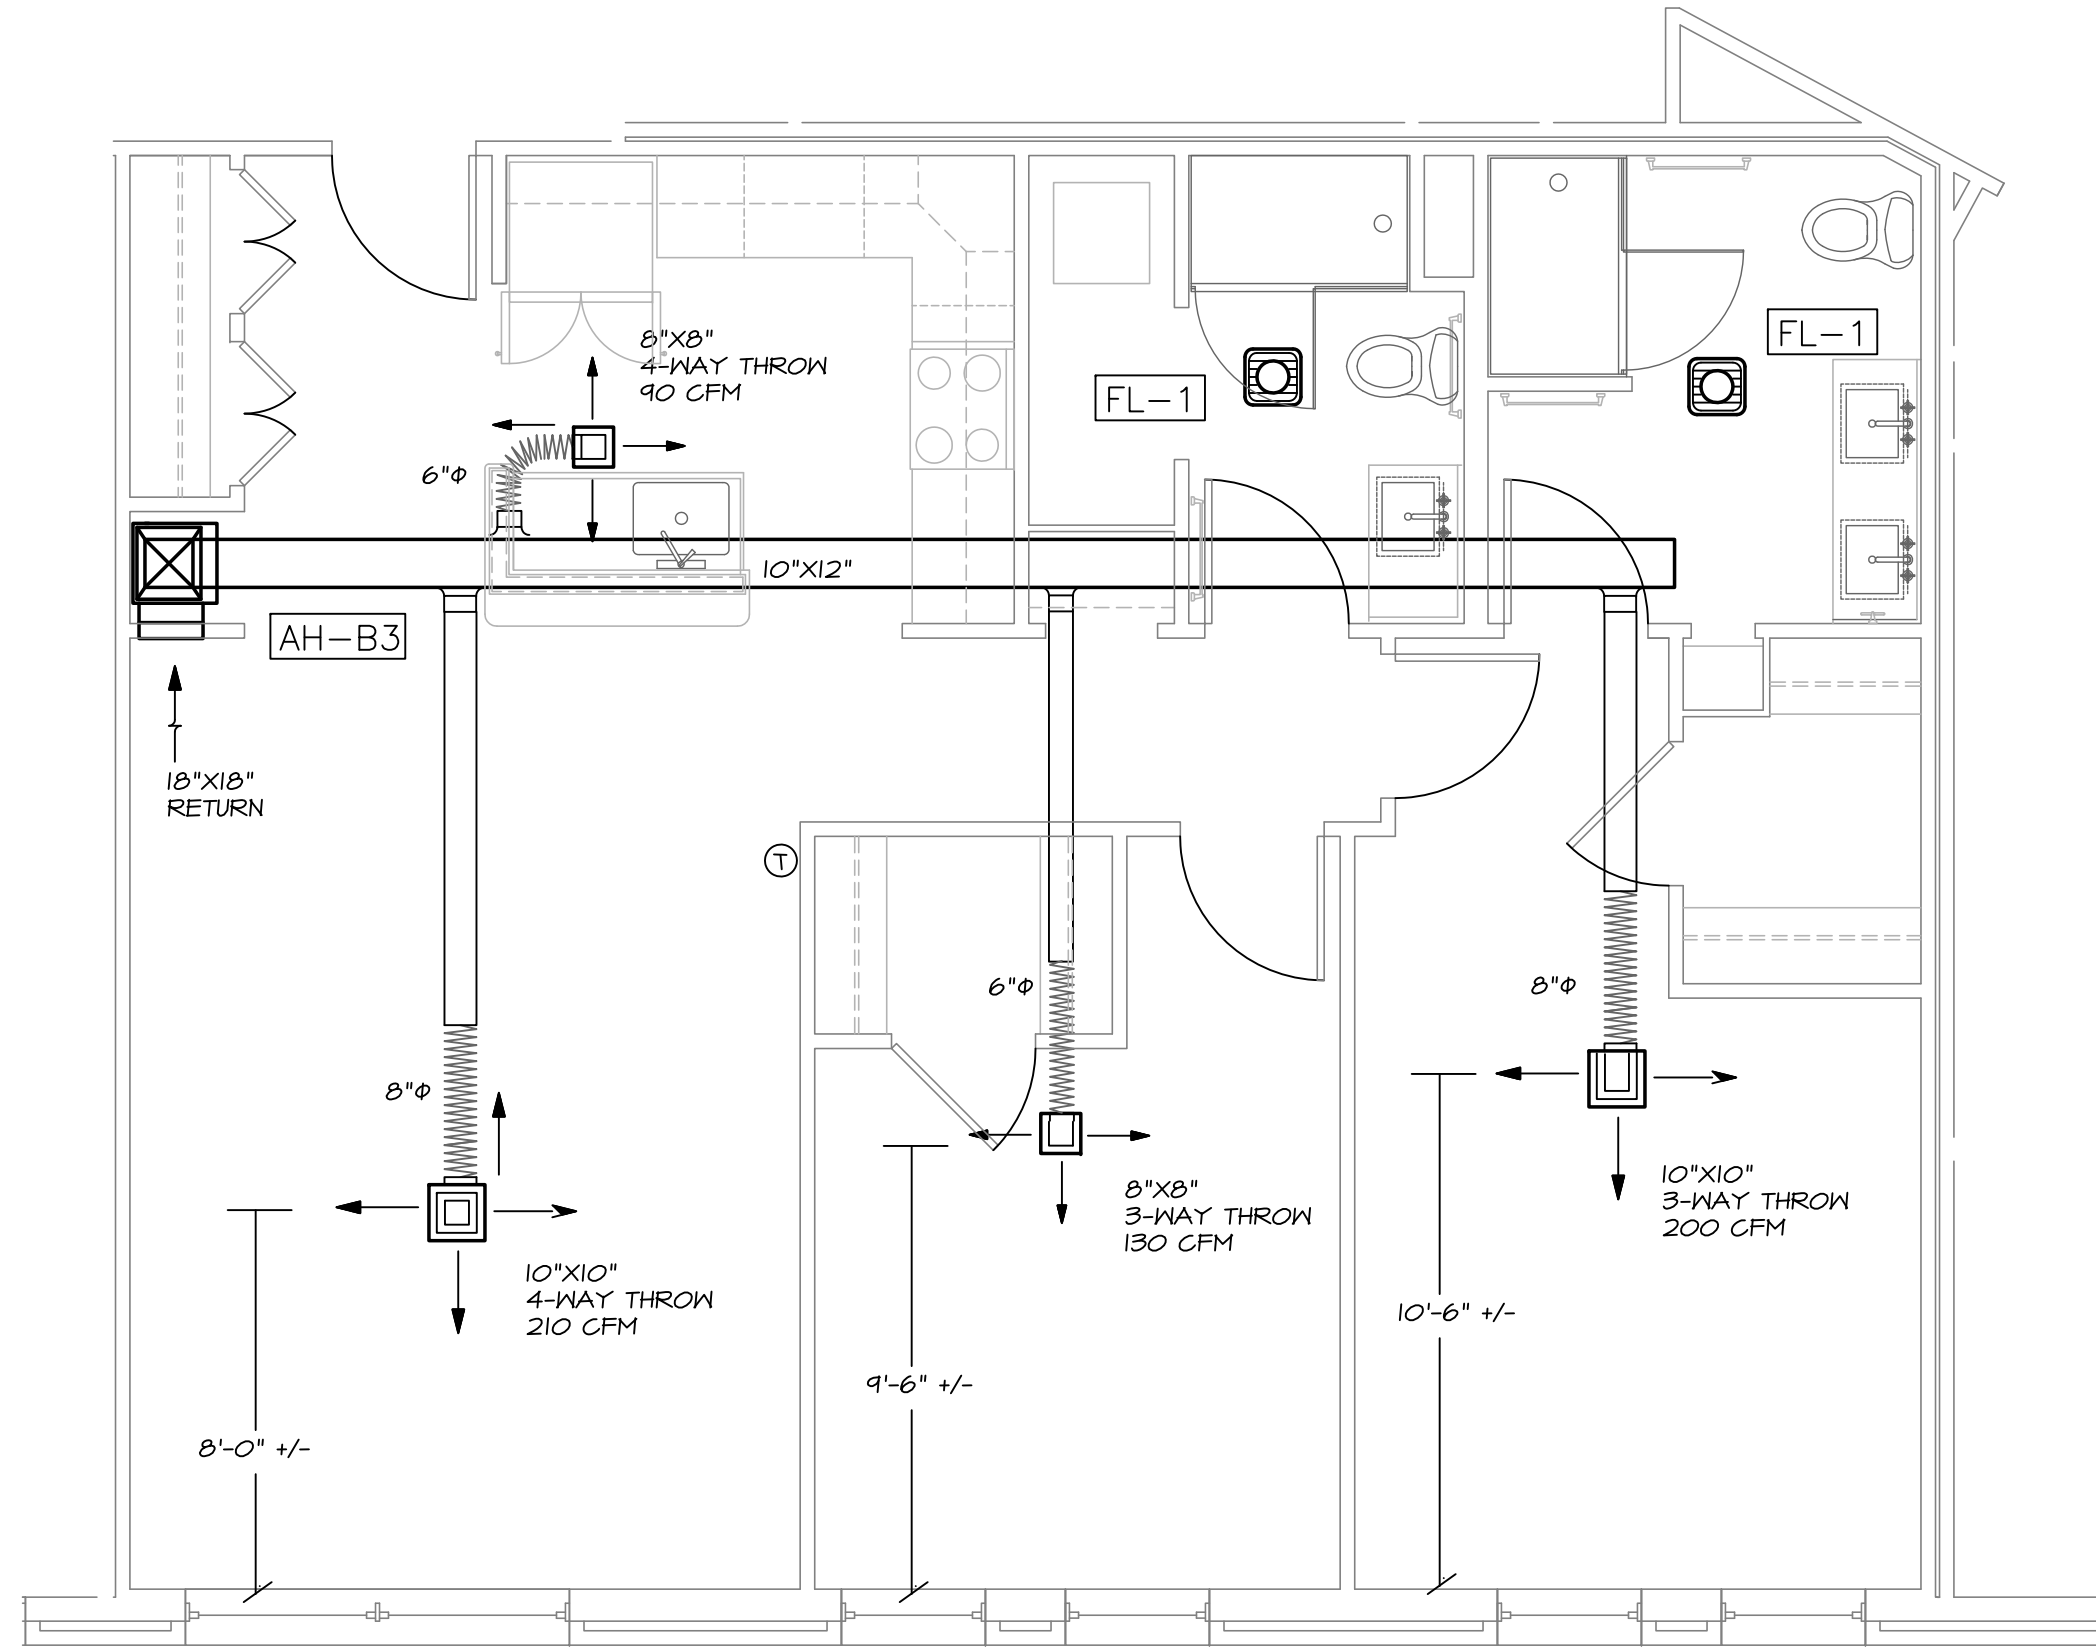

4 B3 UNIT DUCTWORK PLAN
SCALE: 1/4" = 1'-0"



MECHANICAL SYSTEMS ENGINEERS
ROYAL RIVER CENTER, UNIT 10B
10 FOREST FALLS DRIVE, YARMOUTH, MAINE 04096
(207) 846-1441
FACEBOOK: MECHANICAL SYSTEMS ENGINEERS
© COPYRIGHT 2016
M.S.E. Proj. 1608

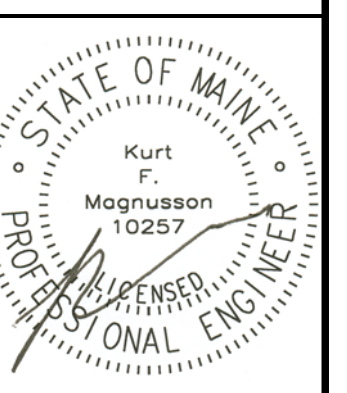

REVISION:

ISSUED:
FOR BID 05/27/2016

project architect: KAK
drawn by: KFM

**B1,2&3
DUCTWORK**

sheet number:

M1.08