

Copyright 2016 Opechee Construction Corporation  
Wednesday, August 31, 2016 2:14:05 PM

**Mixed Use Development**  
York & High Street  
Portland, Maine


REVISION:  
06-08-16 ROOF DRAINS RELOCATED  
06-20-16 ROOF DRAINS RELOCATED  
08-15-16 SHOWERS @ 2 BEDROOM UNITS  
09-02-16 SHOWER DOORS & DRAINS

ISSUED:  
.....

project architect: KAK  
drawn by: JJD

**SECOND LEVEL  
PLUMBING  
PLAN**

sheet number:  
**P1.02**

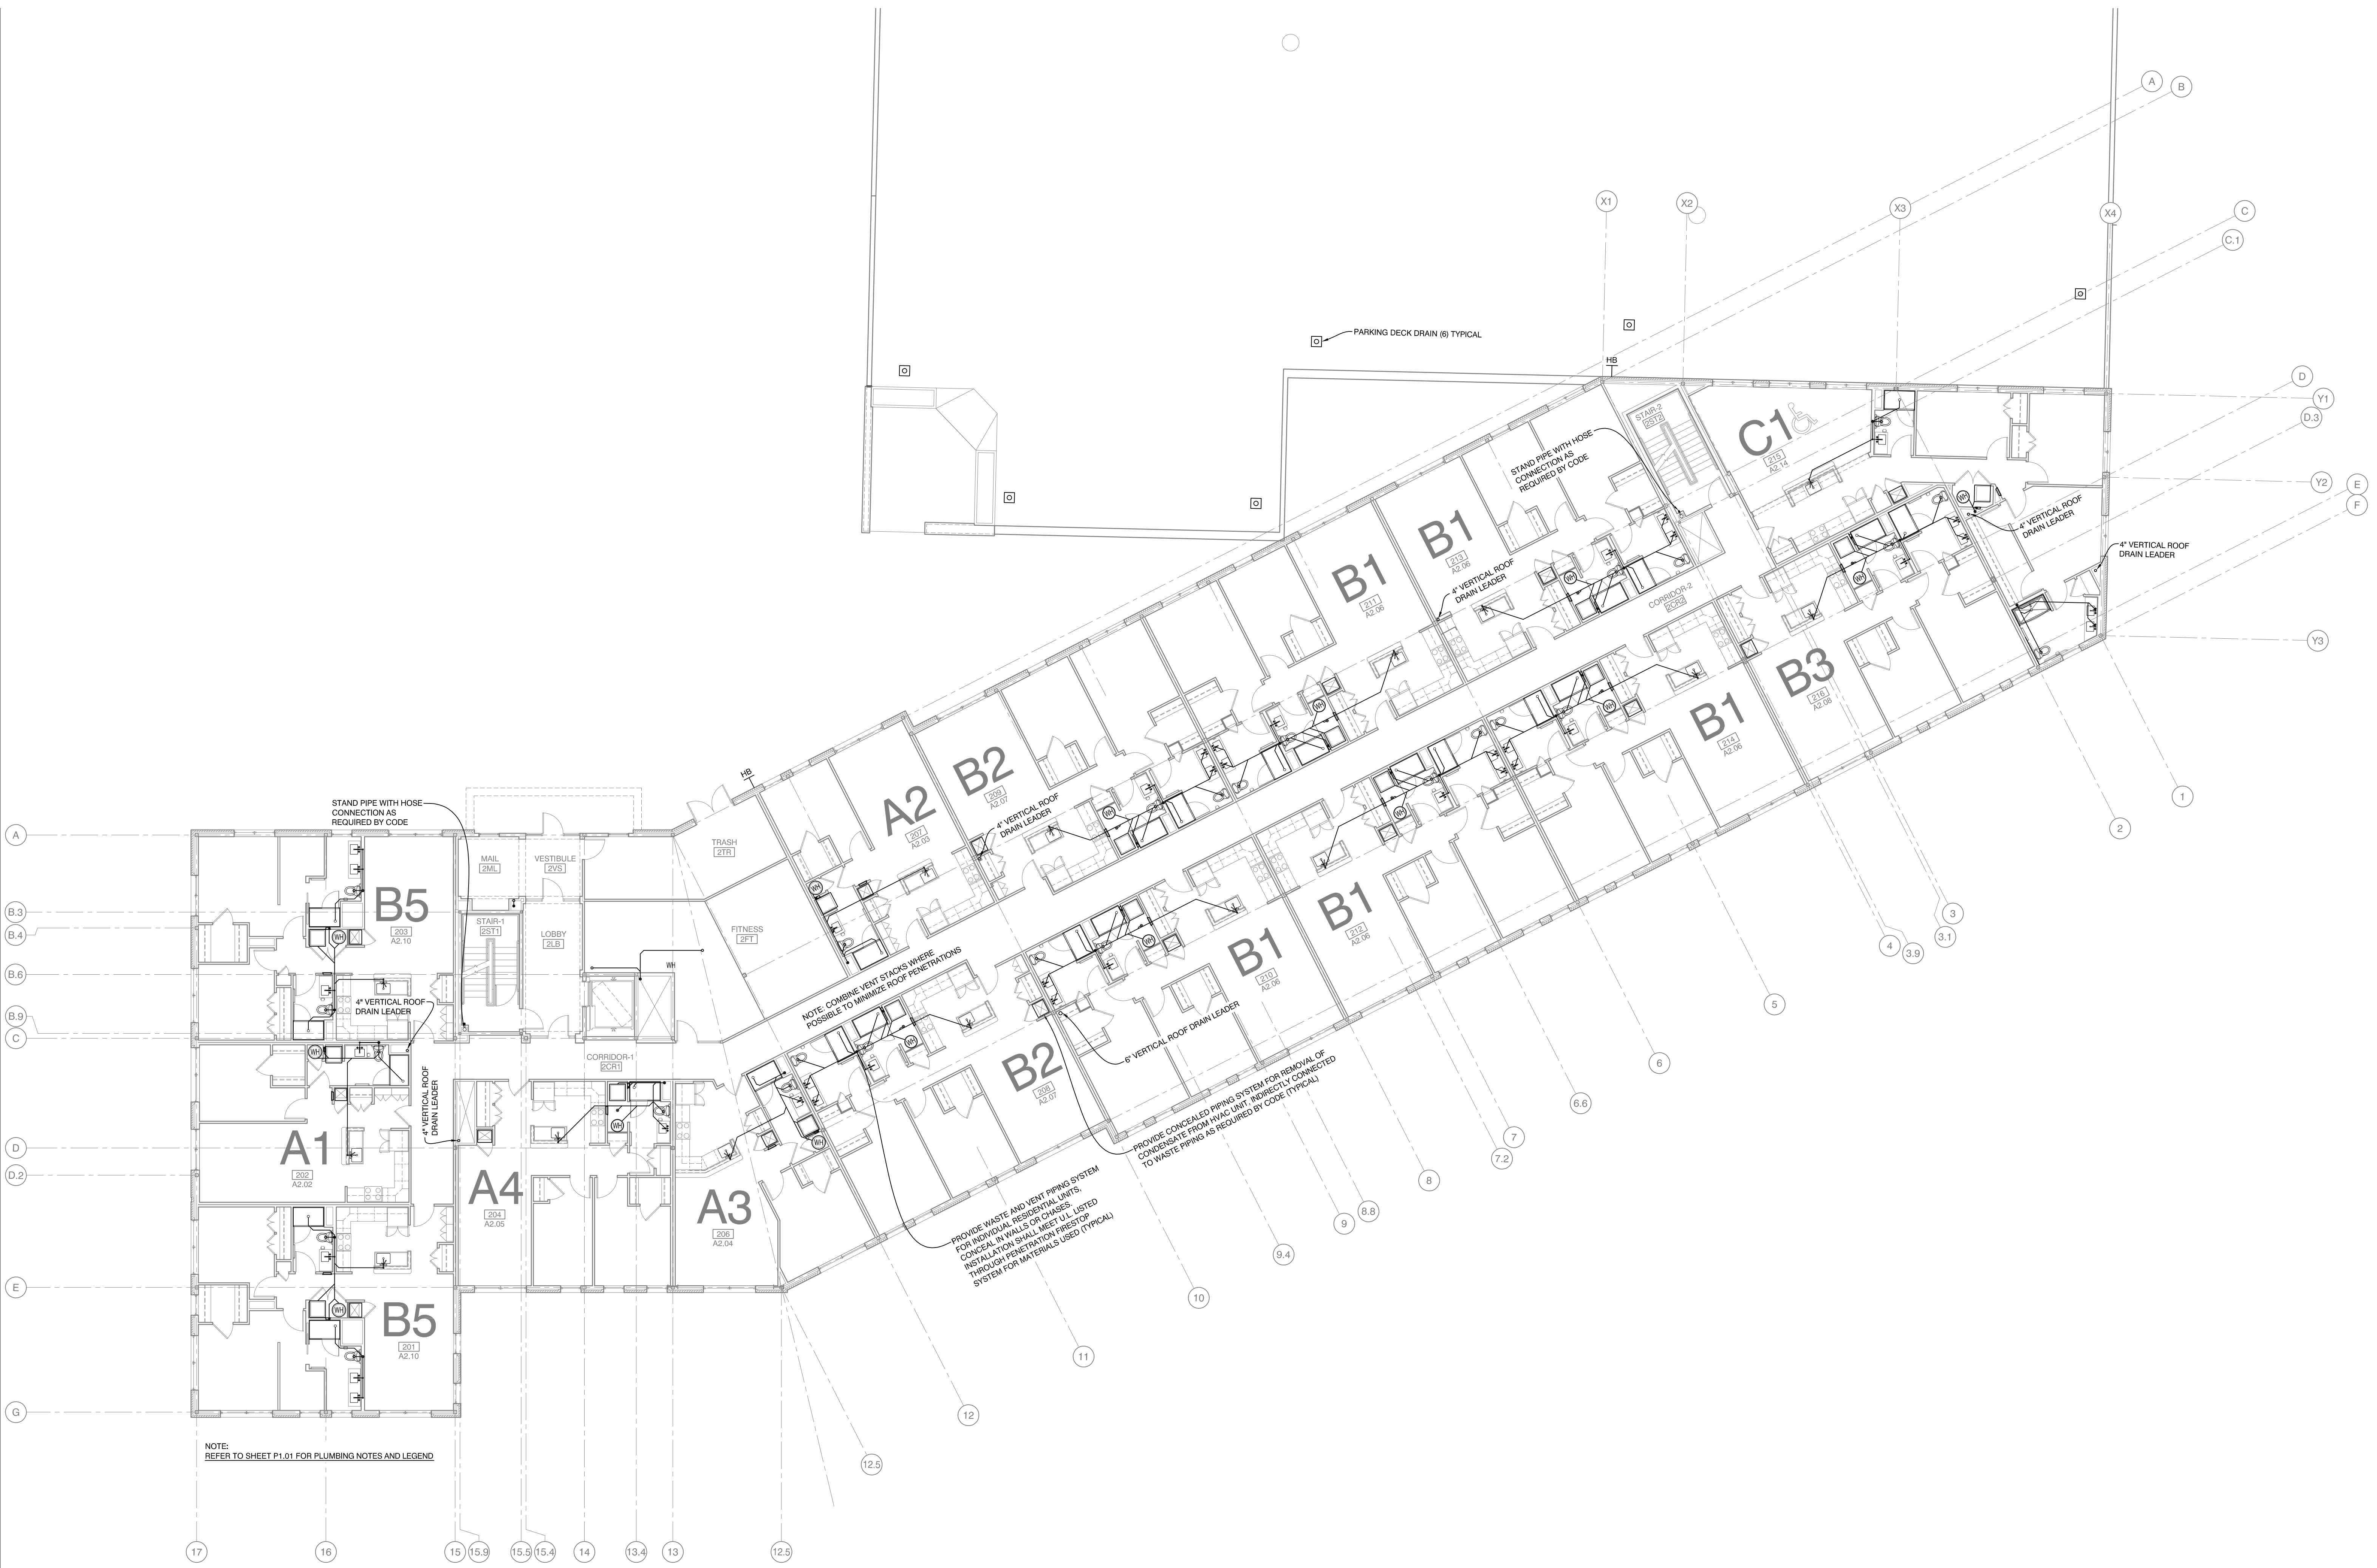

PLAN NORTH **1** SECOND LEVEL PLUMBING PLAN  
3/32" = 1'-0"