


Wednesday, August 31, 2016 2:15:26 PM

Copyright 2016 Opechee Construction Corporation

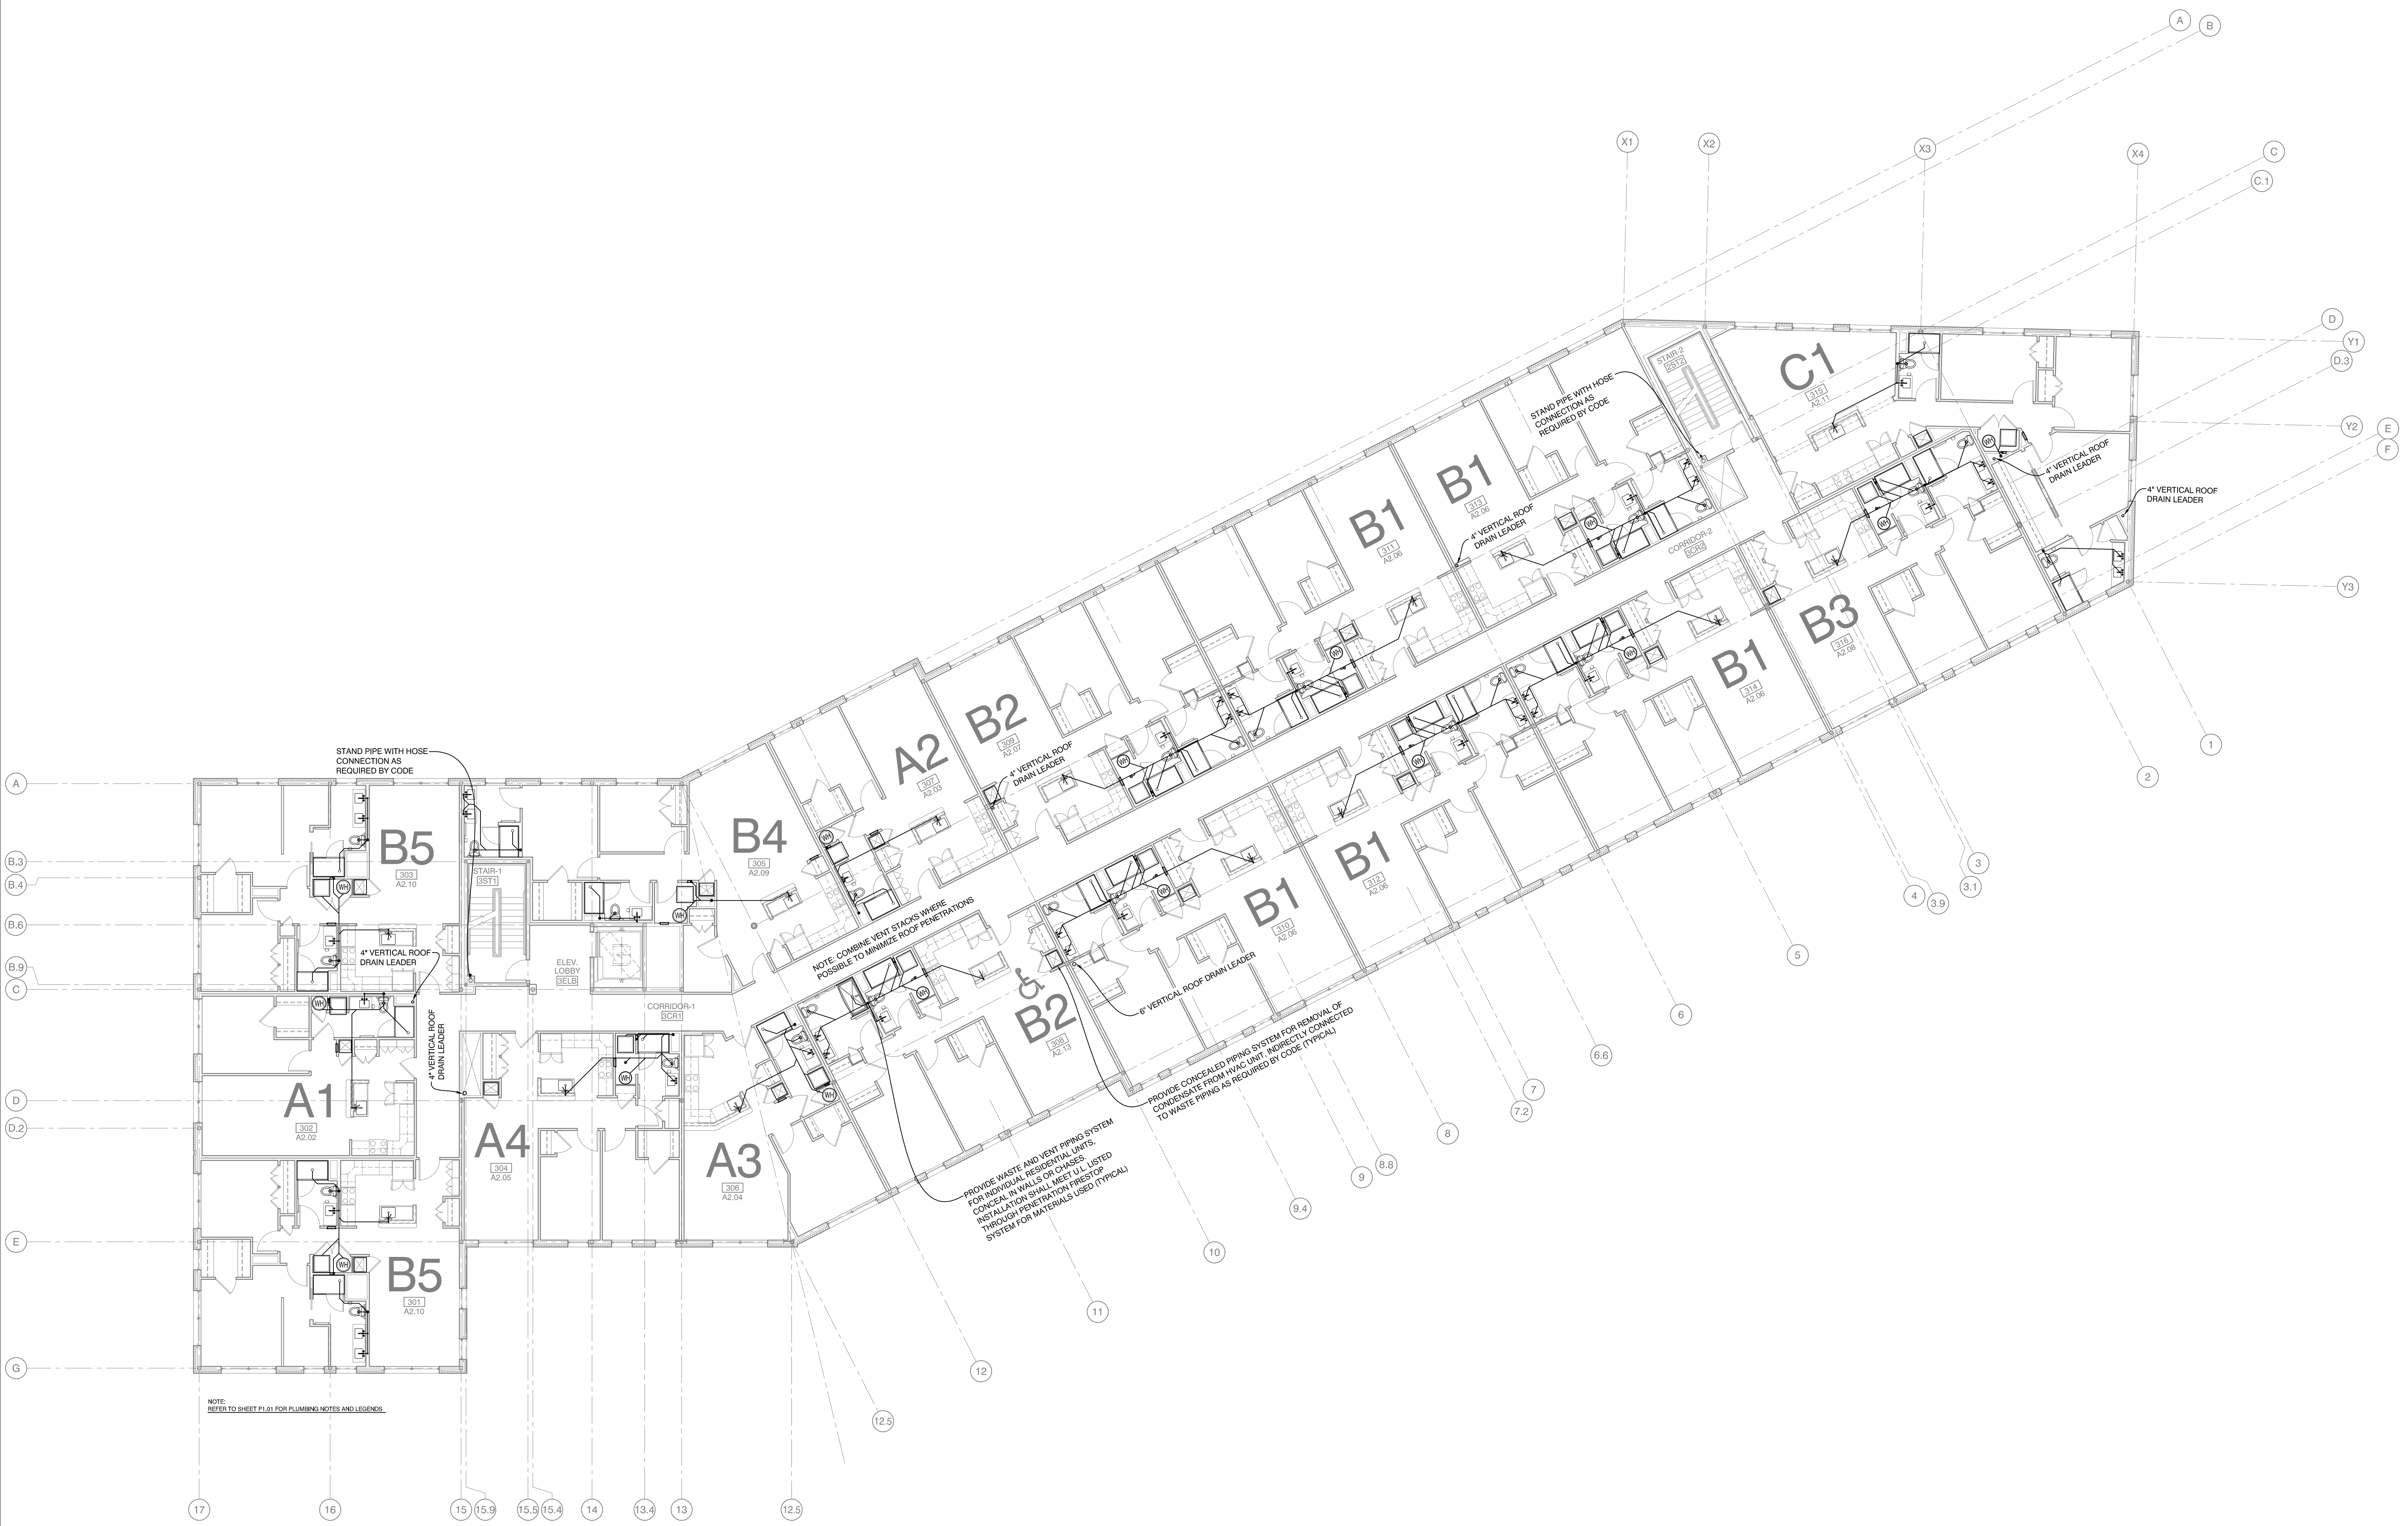

NOTE: REFER TO SHEET P1.01 FOR PLUMBING NOTES AND LEGENDS

PLAN NORTH 1 THIRD LEVEL PLUMBING PLAN 3/32" = 1'-0"

REVISION:

06-09-16	ROOF DRAINS RELOCATED
06-20-16	ROOF DRAINS RELOCATED
08-15-16	SHOWERS @ 2 BEDROOM UNITS
09-02-16	SHOWER DOORS & DRAINS

ISSUED:

project architect: KAK
drawn by: JJD

THIRD LEVEL
PLUMBING
PLAN

sheet number:

P1.03