

Copyright 2016 Opechee Construction Corporation  
Wednesday, August 31, 2016 2:25:47 PM

**Mixed Use Development**  
York & High Street  
Portland, Maine


REVISION:
06-09-16 ROOF DRAINS RELOCATED
06-20-16 ROOF DRAINS RELOCATED
08-15-16 SHOWERS @ 2 BEDROOMS UNITS
09-02-16 SHOWER DOORS & DRAINS

ISSUED:
.....

project architect: KAK  
drawn by: JJD

**FOURTH LEVEL  
PLUMBING  
PLAN**

sheet number:  
**P1.04**

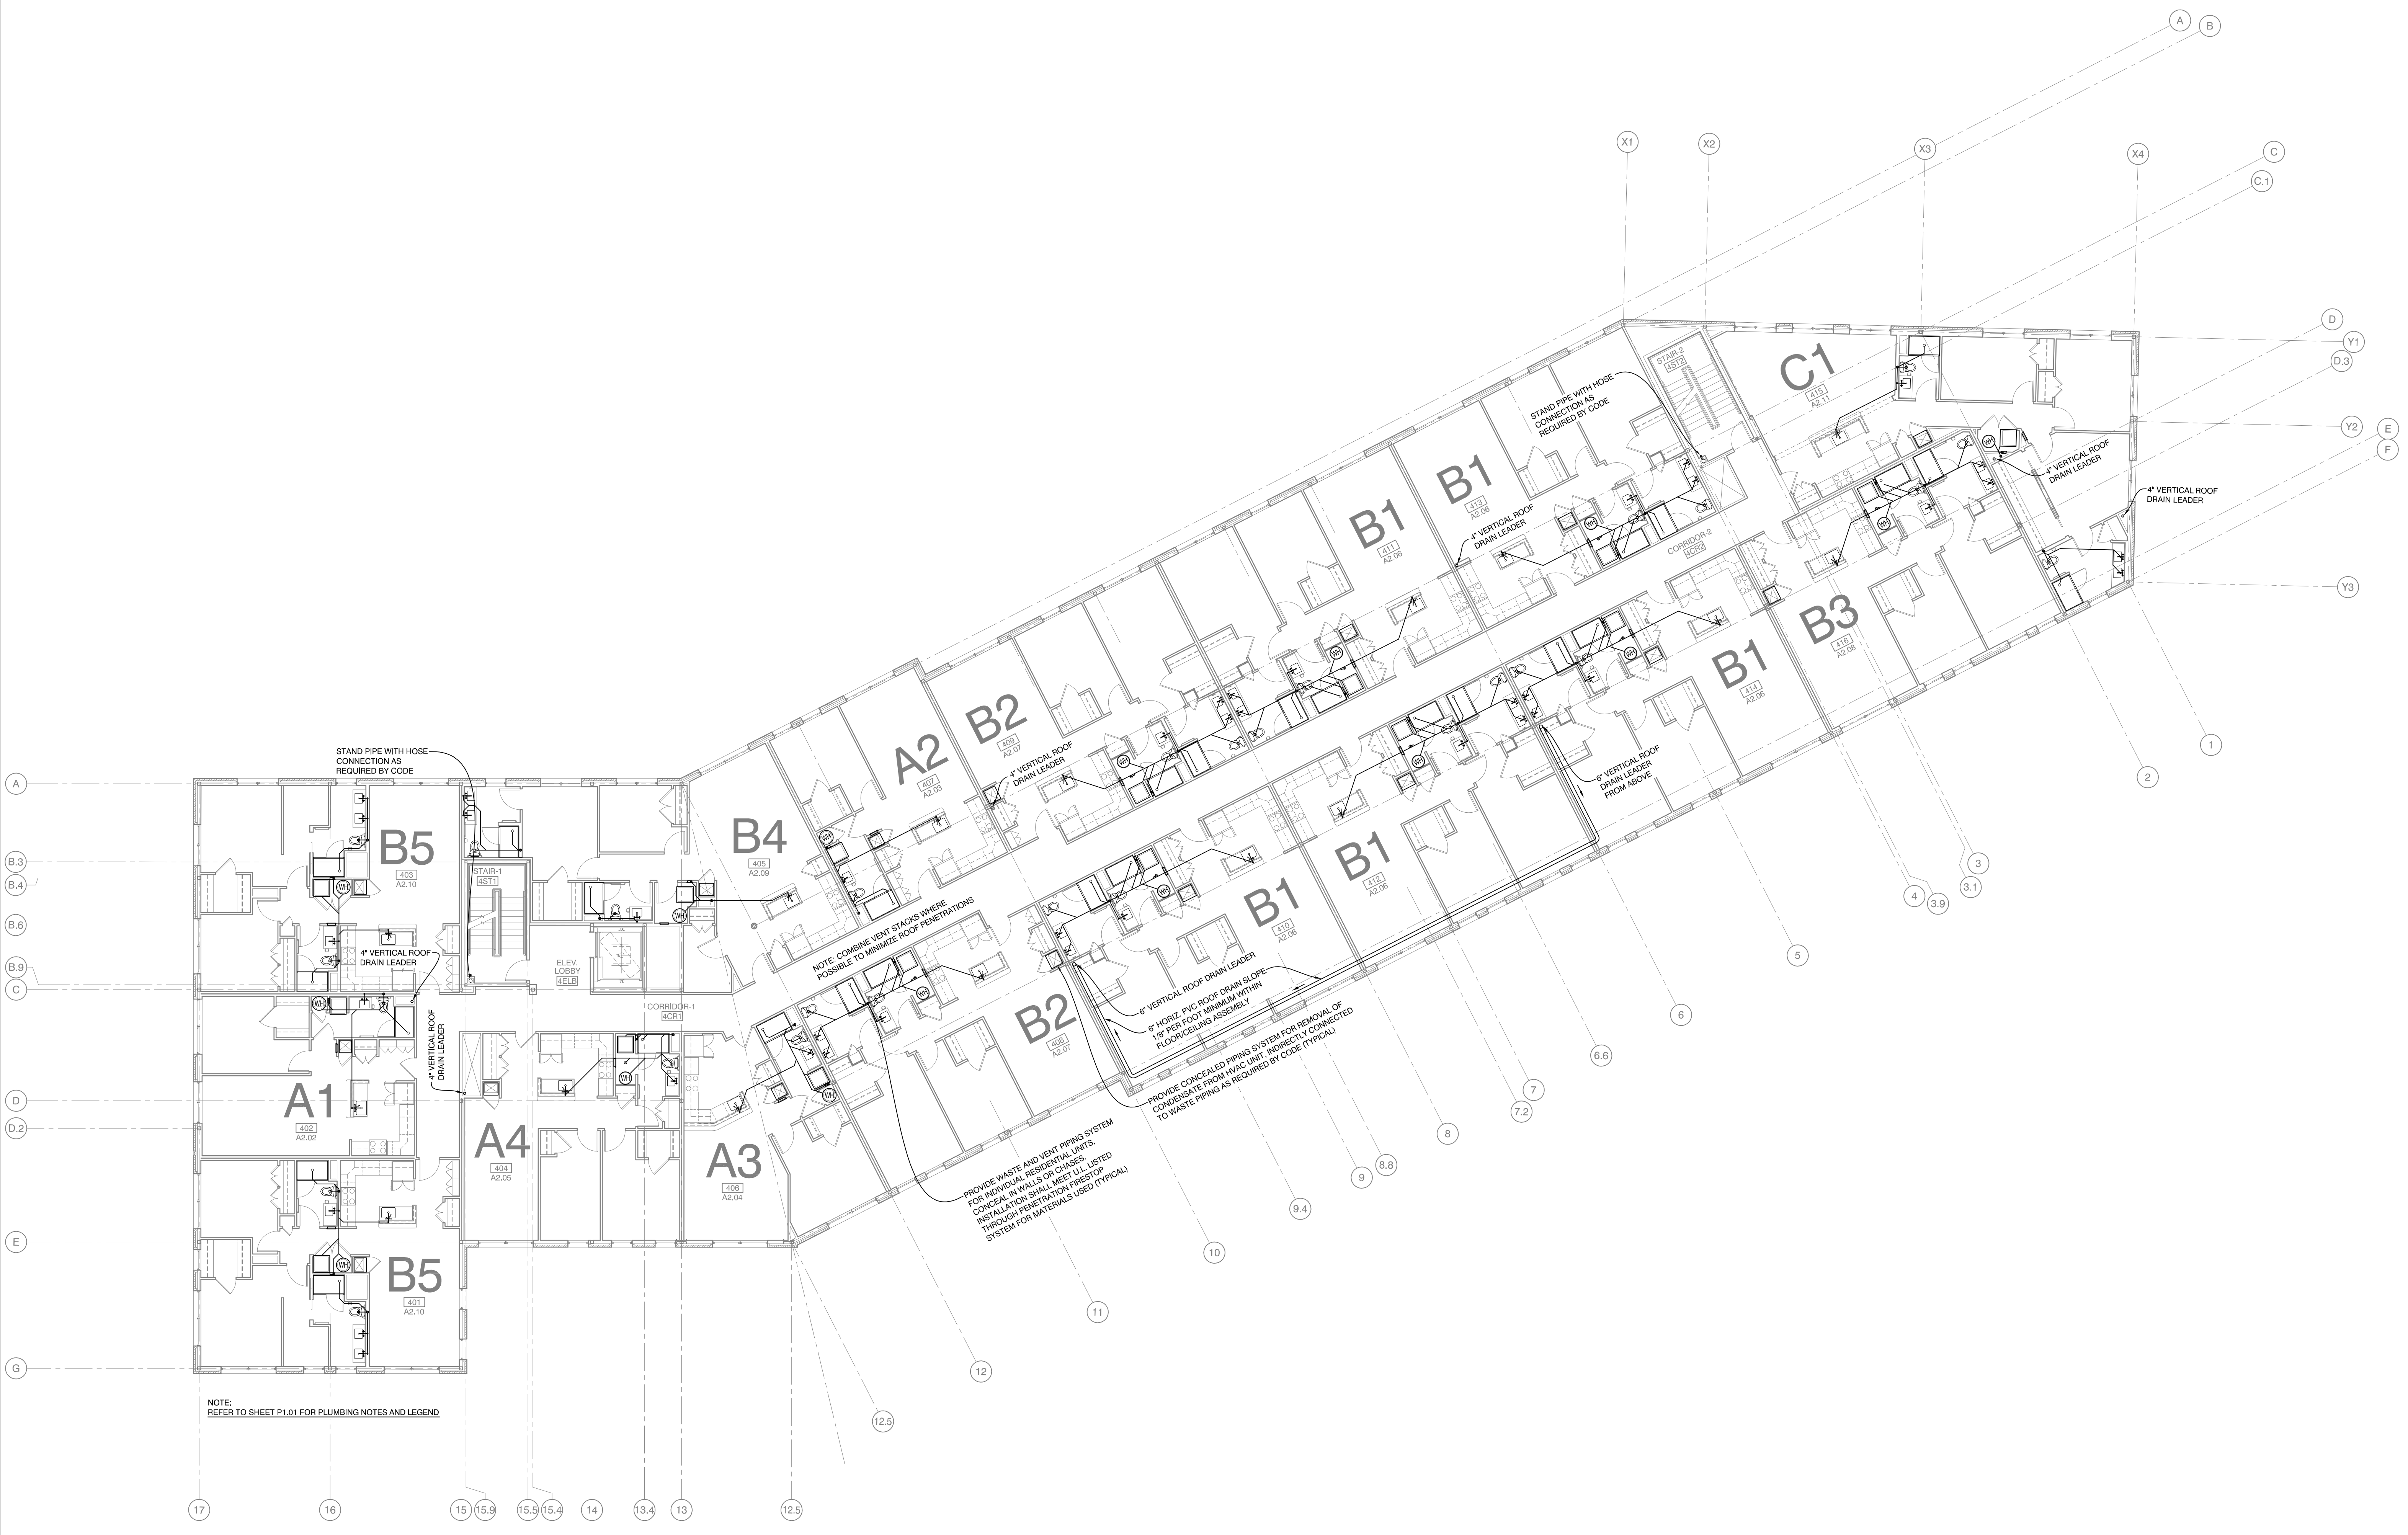

**1** FOURTH LEVEL PLUMBING PLAN  
3/32" = 1'-0"

