

Copyright 2016 Opechee Construction Corporation
Wednesday, August 31, 2016 2:26:09 PM

Mixed Use Development
York & High Street
Portland, Maine


REVISION:
06-08-16 ROOF DRAINS RELOCATED
06-20-16 ROOF DRAINS RELOCATED
08-15-16 SHOWERS @ 2 BEDROOM UNITS
09-02-16 SHOWER DOORS & DRAINS


ISSUED:
.....

project architect: KAK
drawn by: JJD

**FIFTH LEVEL
PLUMBING
PLAN**

sheet number:
P1.05

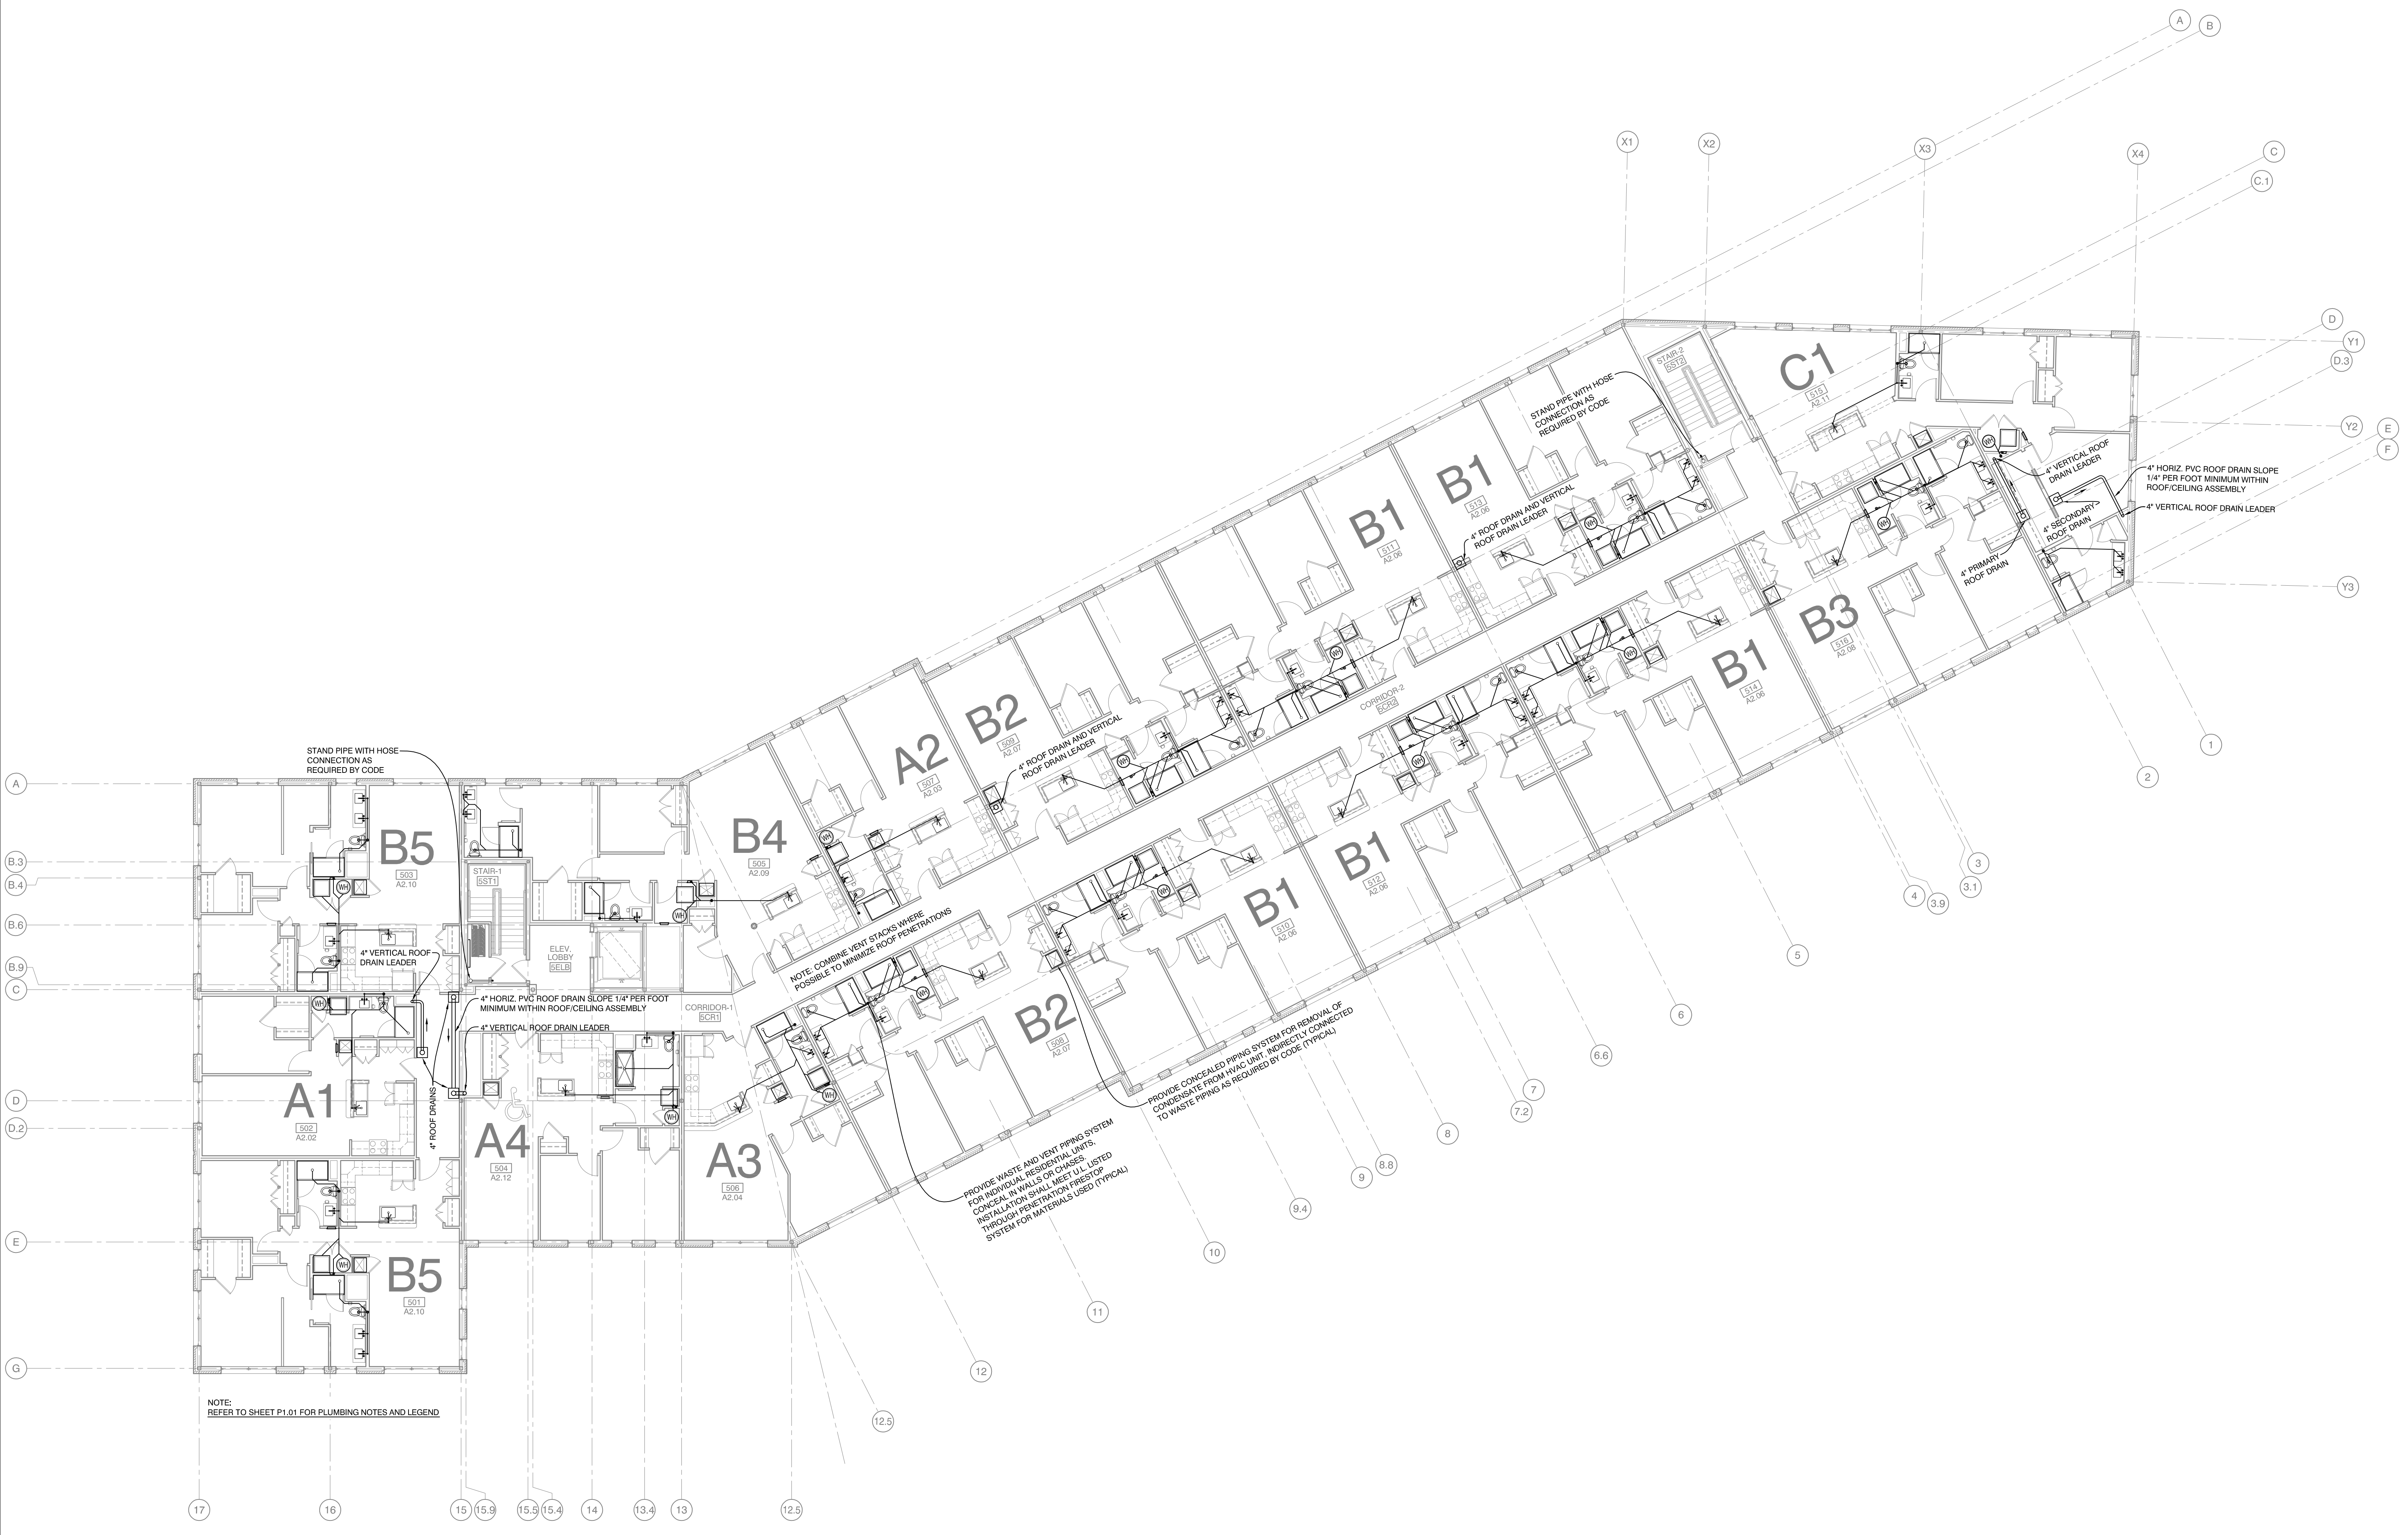

PLAN  NORTH
1 FIFTH LEVEL PLUMBING PLAN
3/32" = 1'-0"