

Copyright 2016 Opechee Construction Corporation
Wednesday, March 23, 2016 3:57:14 PM

REVISION:


ISSUED:


project architect: KAK
drawn by: JJD

**SECOND LEVEL
PLUMBING
PLAN**

sheet number:

P1.02

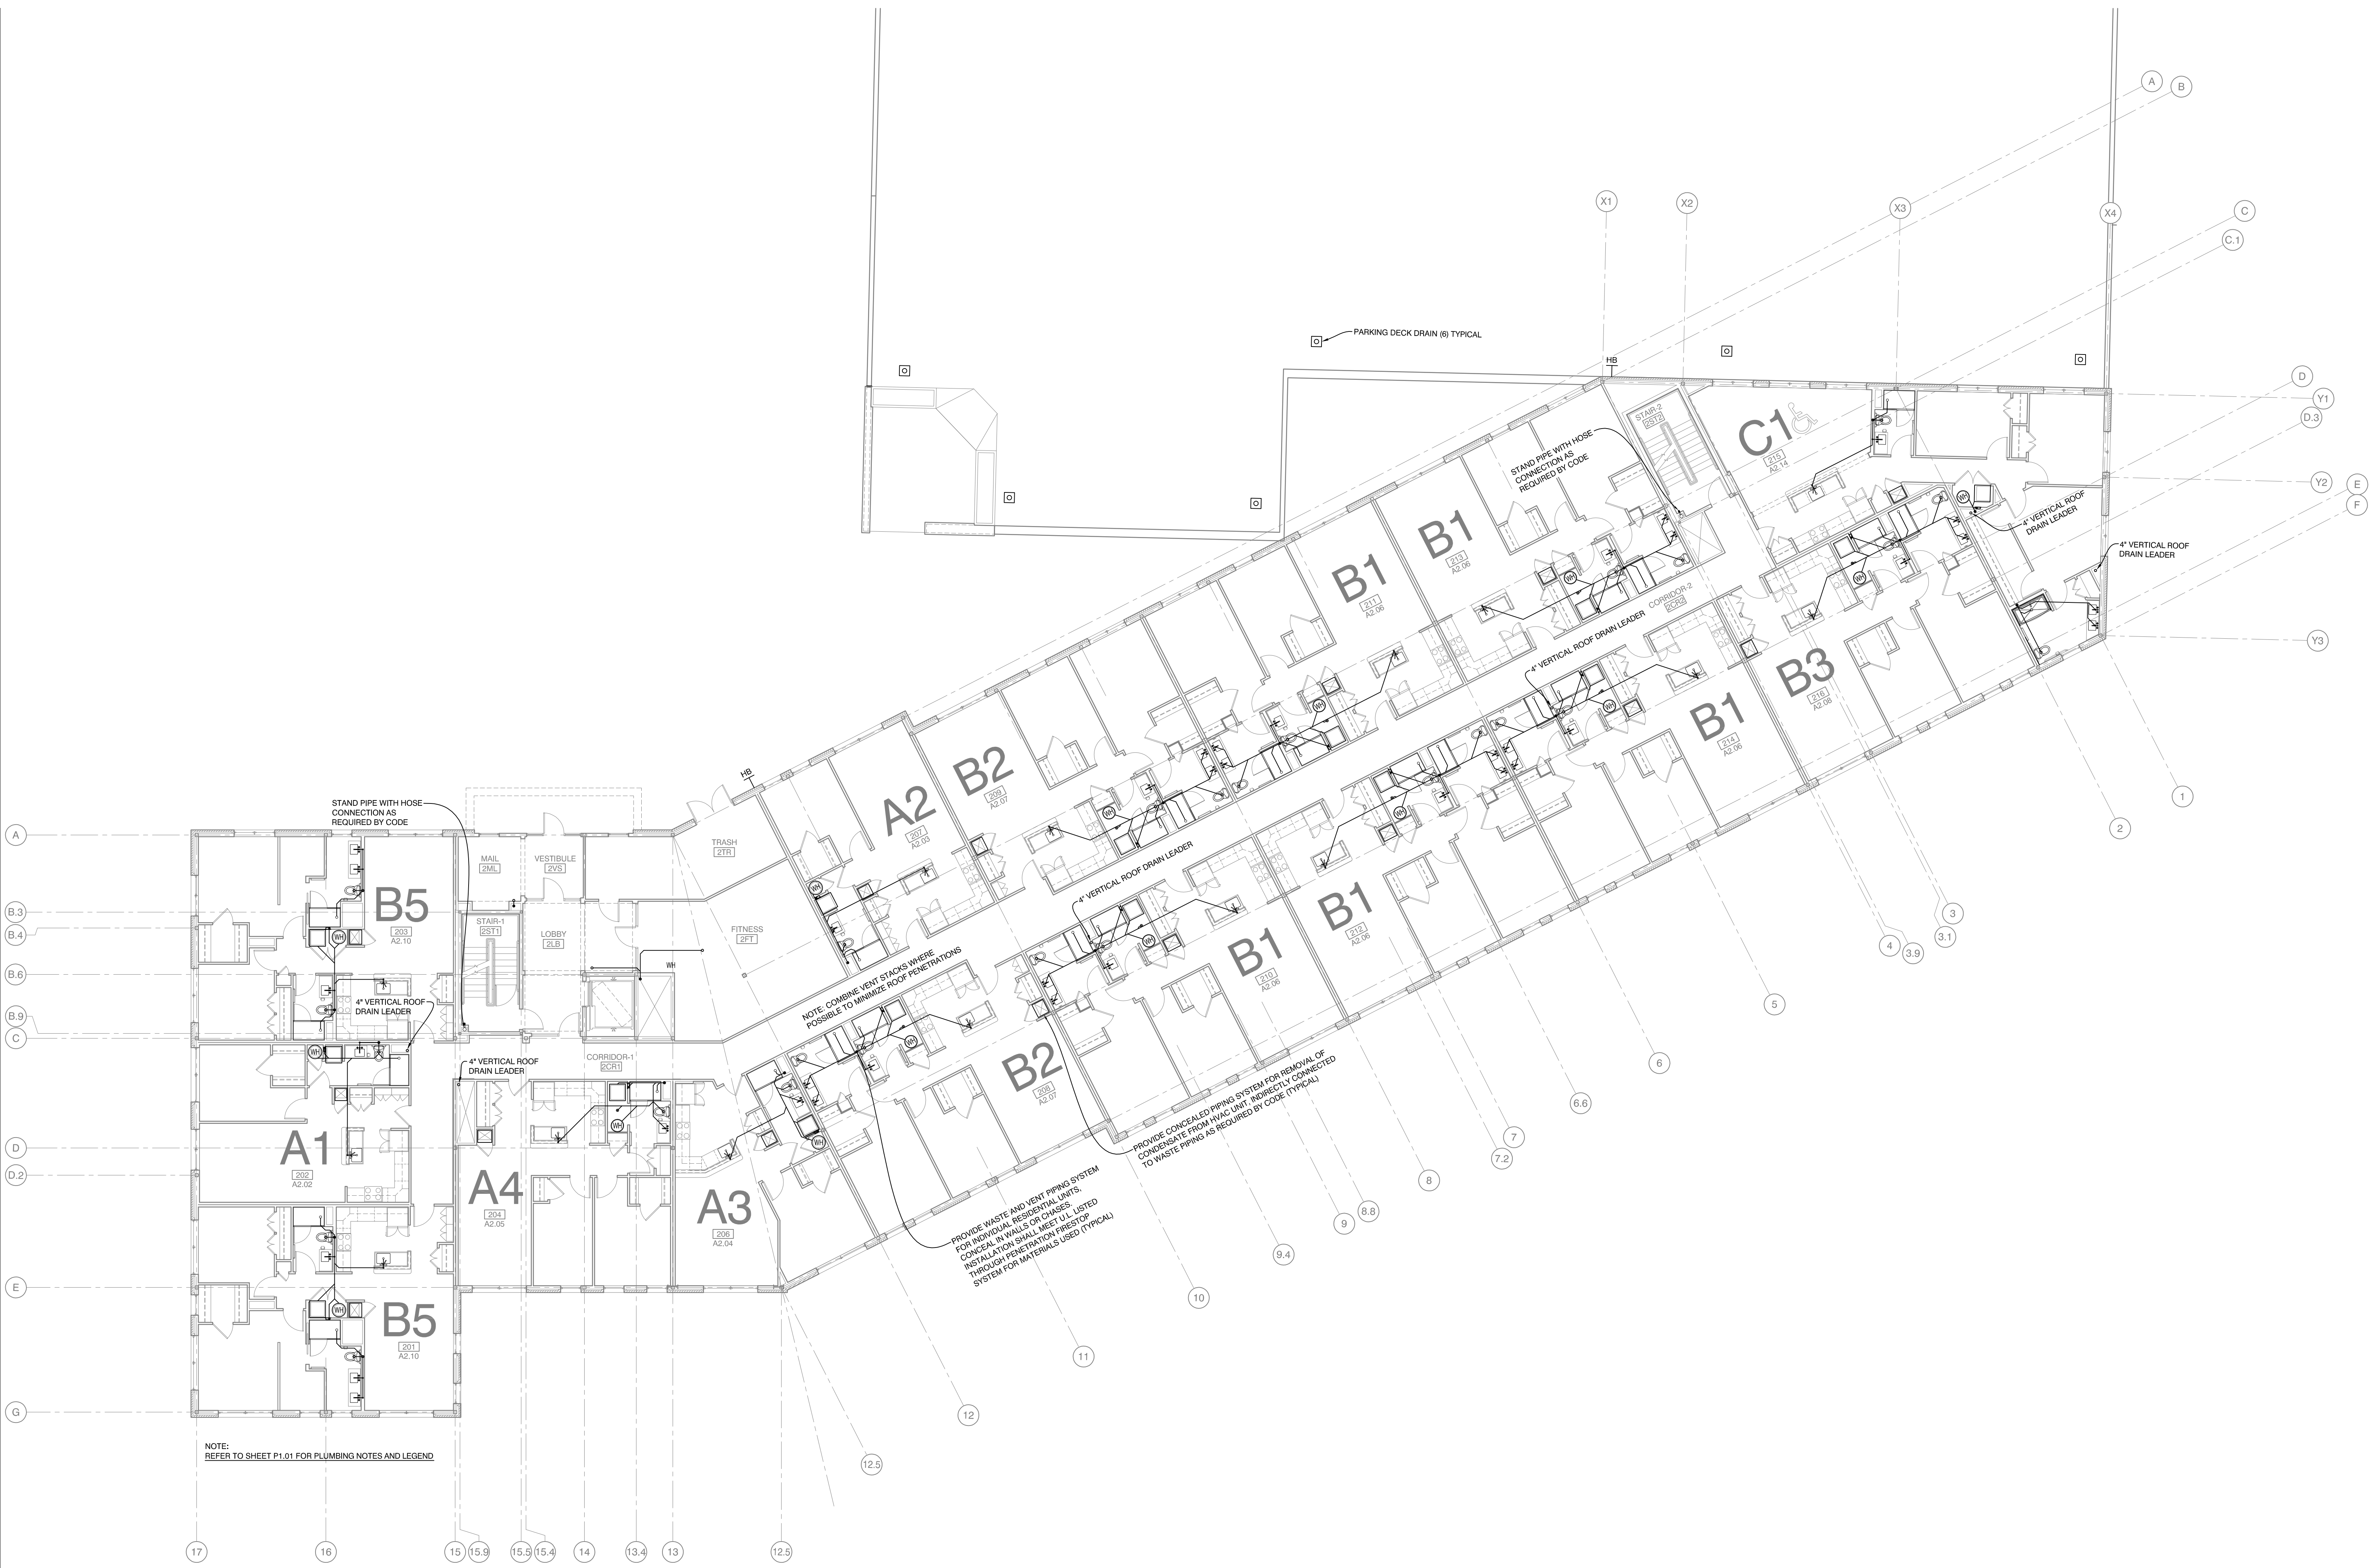

PLAN  NORTH **1** SECOND LEVEL PLUMBING PLAN
3/32" = 1'-0"