


NOTE:
 PRE-CAST BED ON SH. ROOF.
 SEE SHEET 7.
 NOTES ARE SUBJECT TO ANY CHANGES
 EXCEPTED TO THE CONTRACT AND SPECIFICATIONS
 AND TO THE LATEST REVISIONS THEREOF.

4TH LEVEL PLAN
 7/8" = 1'-0"
 UNIT CEILINGS 8'-0" AFF
 CORRIDOR CEILINGS 8'-0" AFF
 COMMON AREA CEILINGS 8'-0" AFF
 WIRE RUNG HANGING UNIT (OVER 10' BELOW CEILING)
 SINKING UNIT 5'-4" - 6'-0"

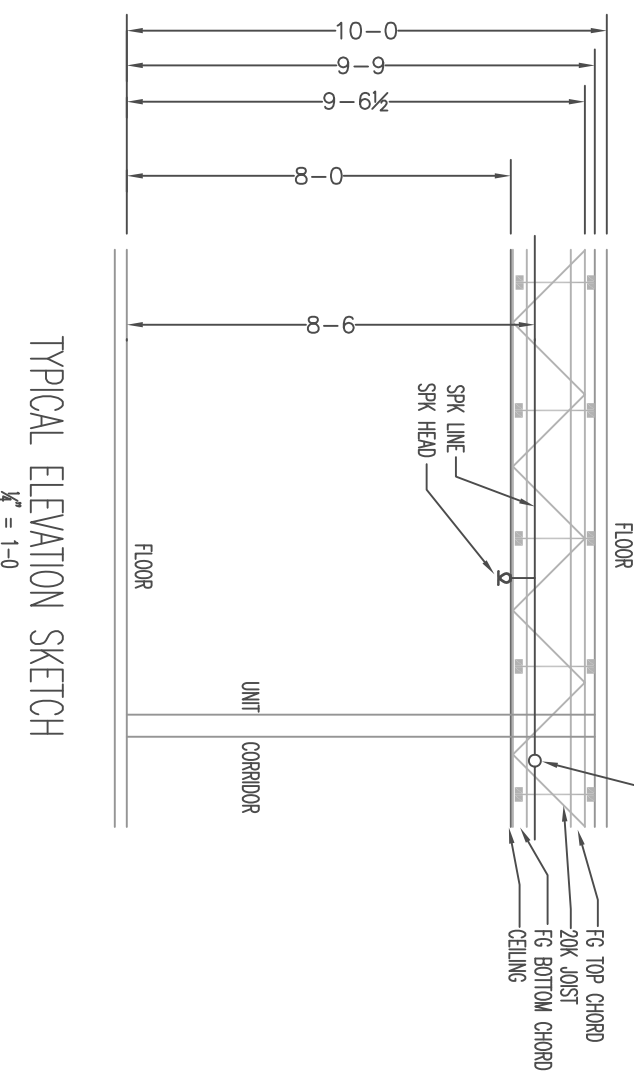

PLANS PREPARED BY:
 BRIAN BENNETT
 NICET LEVEL 3 CERT #075934

SCALE 7/8"=1'-0"

Hamppshire
FIRE PROTECTION
 8 NORTH WENTWORTH AVENUE LEONCONCERNY, NH 03253
 PH: (603) 432-8221 FAX: (603) 434-3194
 WEBSITE: HAMPSHIRE.COM
 MASS VERMONT CERTIFIED

WATER SUPPLY DATA		SPRINKLERS		DRAWING		PROJECT	
Static pressure	100	psf	psf	From This Job	Sheet 6, 4th Level	Contract No.	48303HE
Pressure loss	100	psf	psf	From This Job	Sheet 1	Contractor	Opreshee Construction
Location	See Site Plan	Direction	237	REINFORCE CONCRETE FLOOR (SEE SHEET 10)	DATE	11 Corporate Drive	Belmont, NH 03220
Elevation	3.101 FT	Description	REINFORCE CONCRETE FLOOR (SEE SHEET 10)	Scale	1/8" = 1'-0"	Contractor	Opreshee Construction
Date	2/13/16	Time	10 AM	Drawn By	Bennett	11 Corporate Drive	Belmont, NH 03220
Information by	Pauline Water Dept. Maine Dept.	Approved by	ME SPMCO	Check			