


STAIR 2
1/8" = 1'-0"

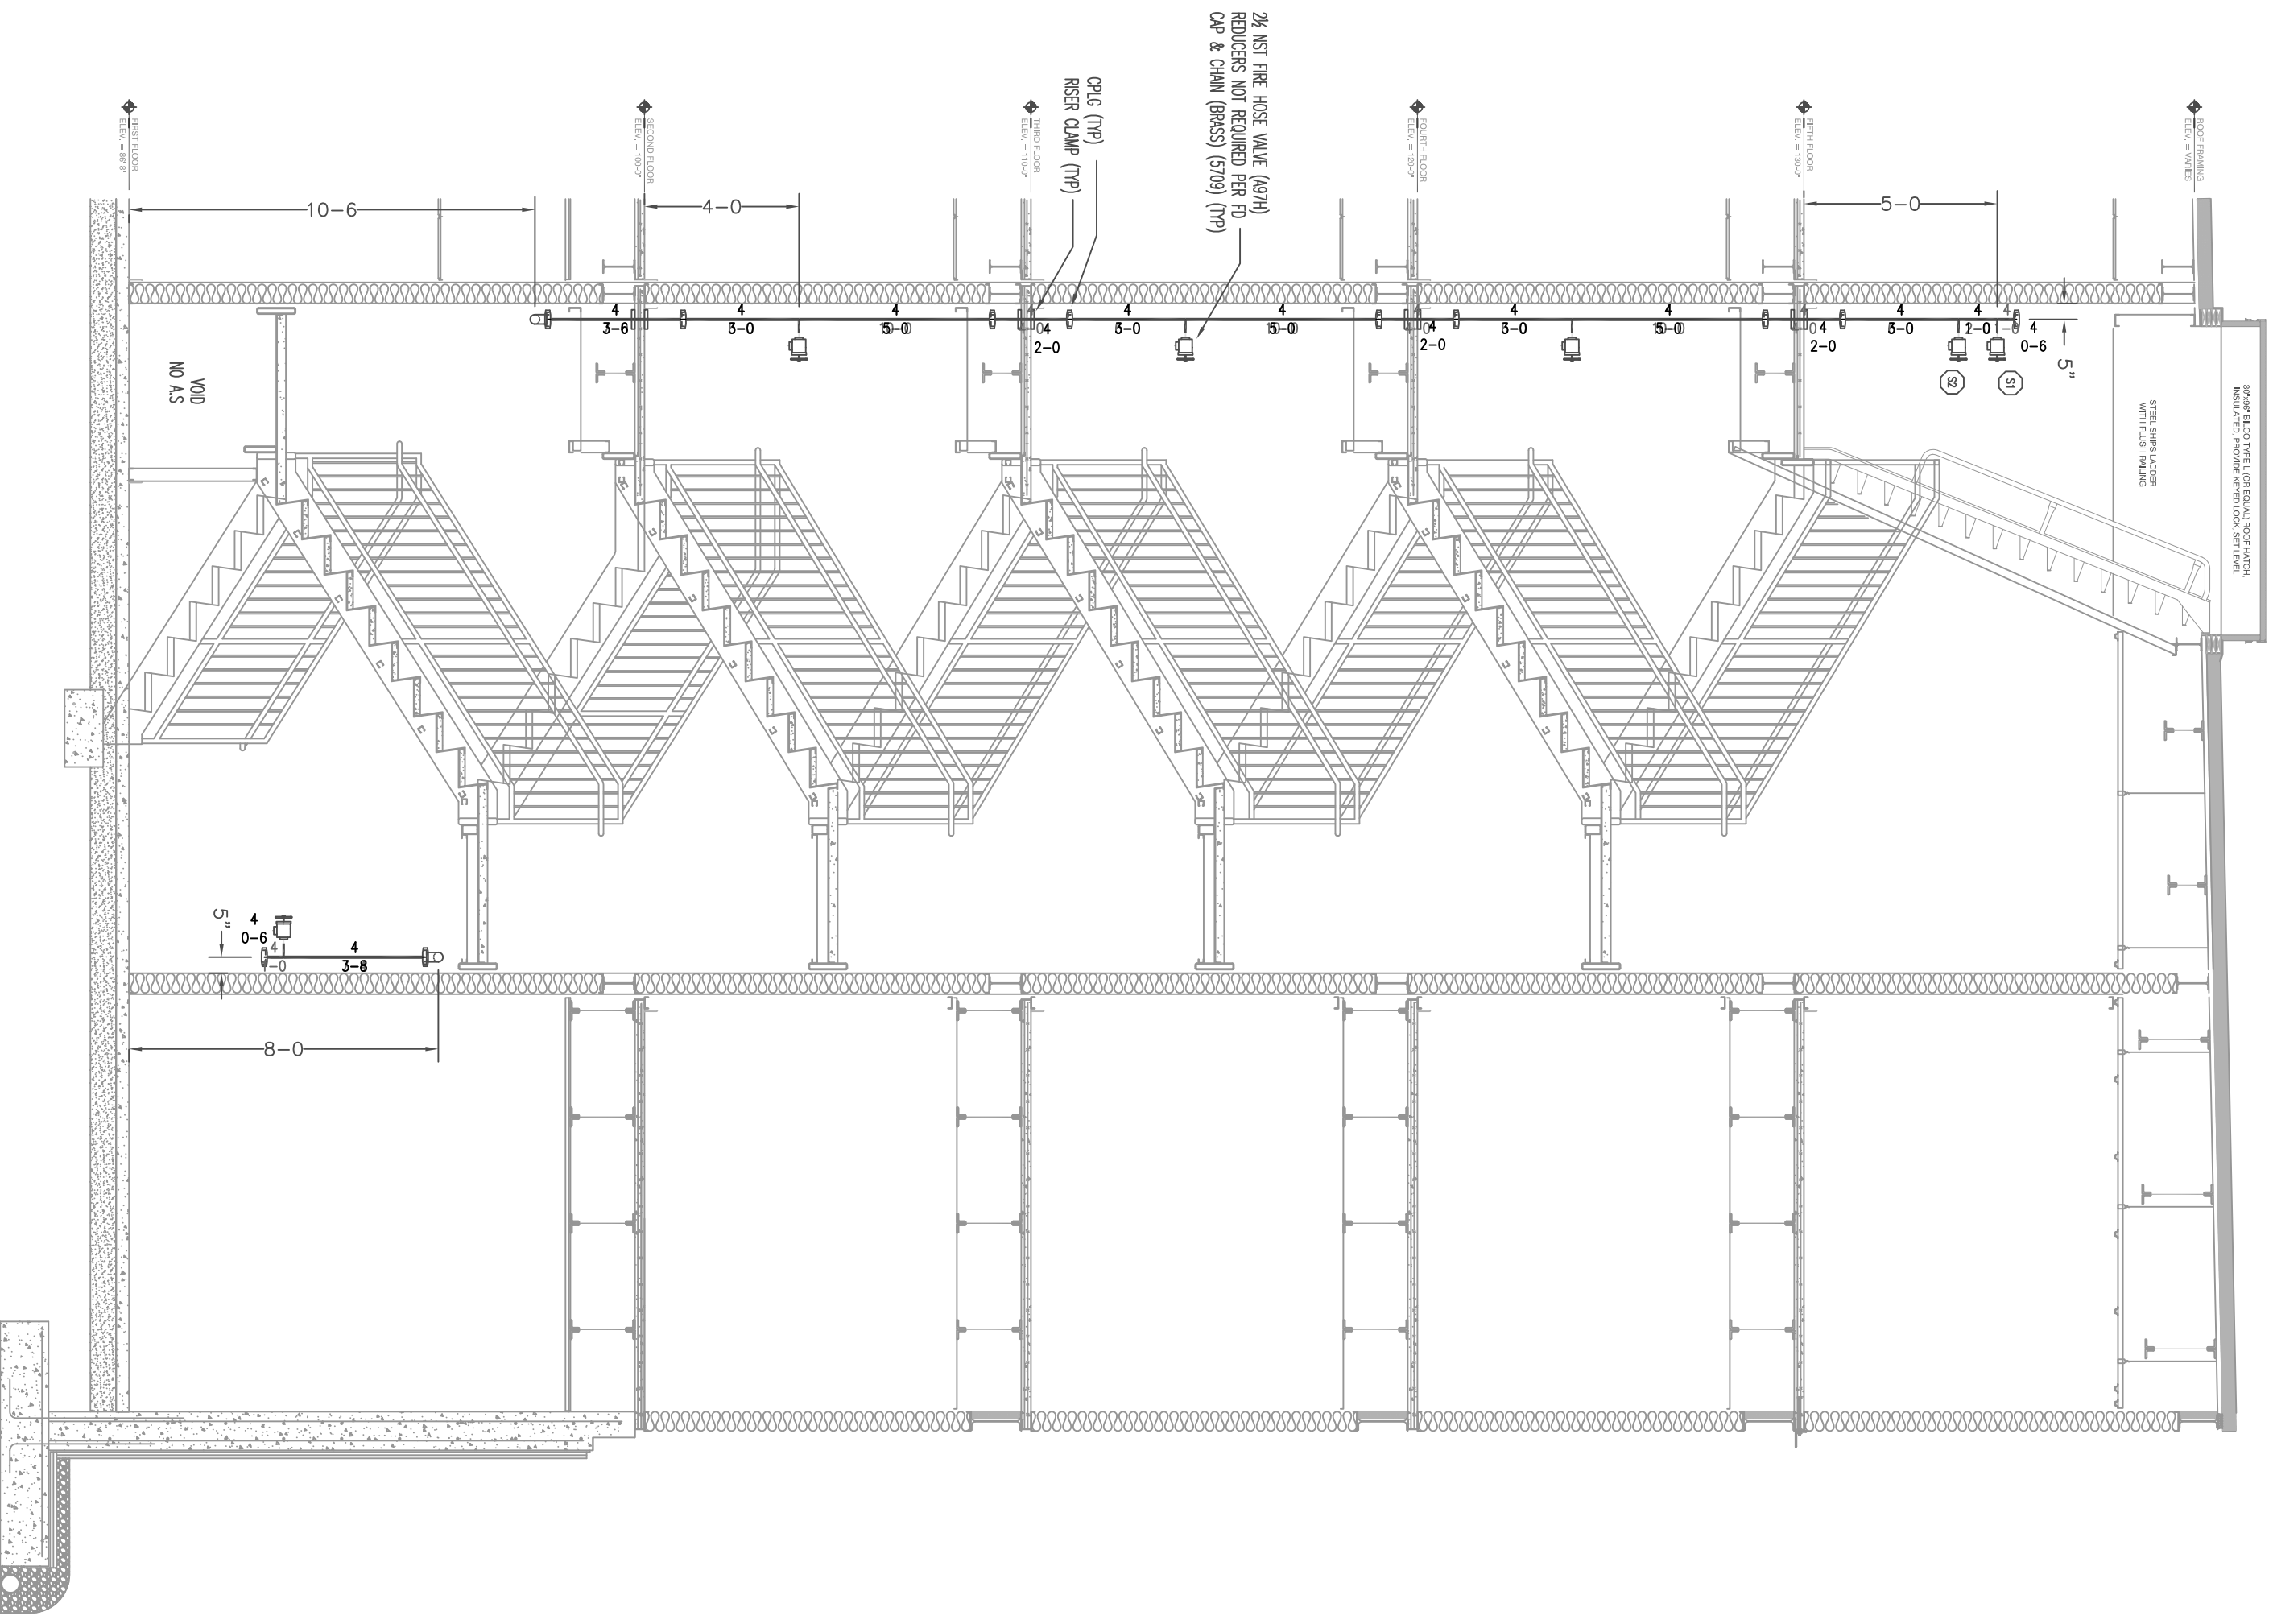


STAIR 1
1/8" = 1'-0"

NOTE:
STAIRS ARE CALCULATED ASSUMING A REG. 300# CONCRETE
SLAB WITH 10# REINFORCING BARS @ 12" O.C.
SPACING. THE DESIGN IS IN ACCORDANCE WITH THE PORTLAND
CEMENT CONCRETE AND REINFORCING BARS INSTITUTE
(ACI) 318-11 CODE. THE DESIGN MEETS THE REQUIREMENTS FOR "NET WEIGHT"
(2) WORKER IS TO PROVIDE THE REINFORCING BARS TO BE PROVIDED.

PLANS PREPARED BY:
BRIAN BENOIT
NICET LEVEL 3 CERT. #0759344

 THESE PLANS ARE SUBJECT TO ANY
DEVIATIONS, DUE TO COORDINATION AND/OR
FIELD CONDITIONS, NOT AFFECTING SCOPE OF
WORK OR CODE COMPLIANCE.



WATER SUPPLY DATA

| | | |
|-------------------|----------------------------------|-----------|
| Static pressure | 100 | psi |
| Residual pressure | 30 | psi |
| Location | 100' | depth |
| Flow | See Site Plan | |
| Elevation | 3'-10" EOT | |
| Date | 2/13/16 | Time 10AM |
| Information by | Portland Water Dept. Maine Dept. | |

SPRINKLERS

| | |
|------------------|---------------------------|
| Total This Sheet | 0 |
| Description | From This Job See Sheet 1 |

Drawing


| | |
|---------------------|--------------|
| Sheet 8, Standpipes | |
| Contract No. | 48302HE |
| Drawn By | Benoit |
| Scale | 1/8" = 1'-0" |
| Date | 8/17/16 |
| Approved by | ME SPNO |

| | |
|------------|-------|
| Revisions: | Date: |
| 1 | |
| 2 | |
| 3 | |
| 4 | |
| 5 | |
| 6 | |
| 7 | |

Project:
York Street
101 York Street
Portland, ME 04101

Contract with:
Opeshee Construction
11 Corporate Drive
Bethel, NH 03220

FIRE PROTECTION ENGINEER'S STAMP

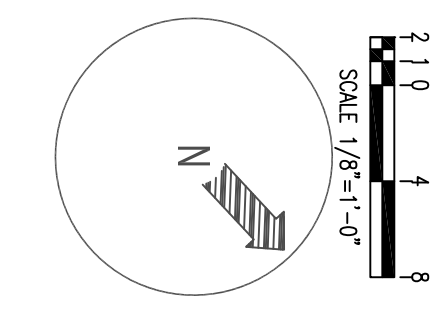

Hamppshire
FIRE PROTECTION
8 NORTH WENTWORTH AVENUE, LEONCONQUERRY, NH 03059
PH: (603) 432-8221 FAX: (603) 434-3194
WEBSITE: HAMPSHIRE.FIRE.COM
MASS VERMONT CERTIFIED