


1 PROPOSED SITE PLAN
SCALE: 1" = 10'

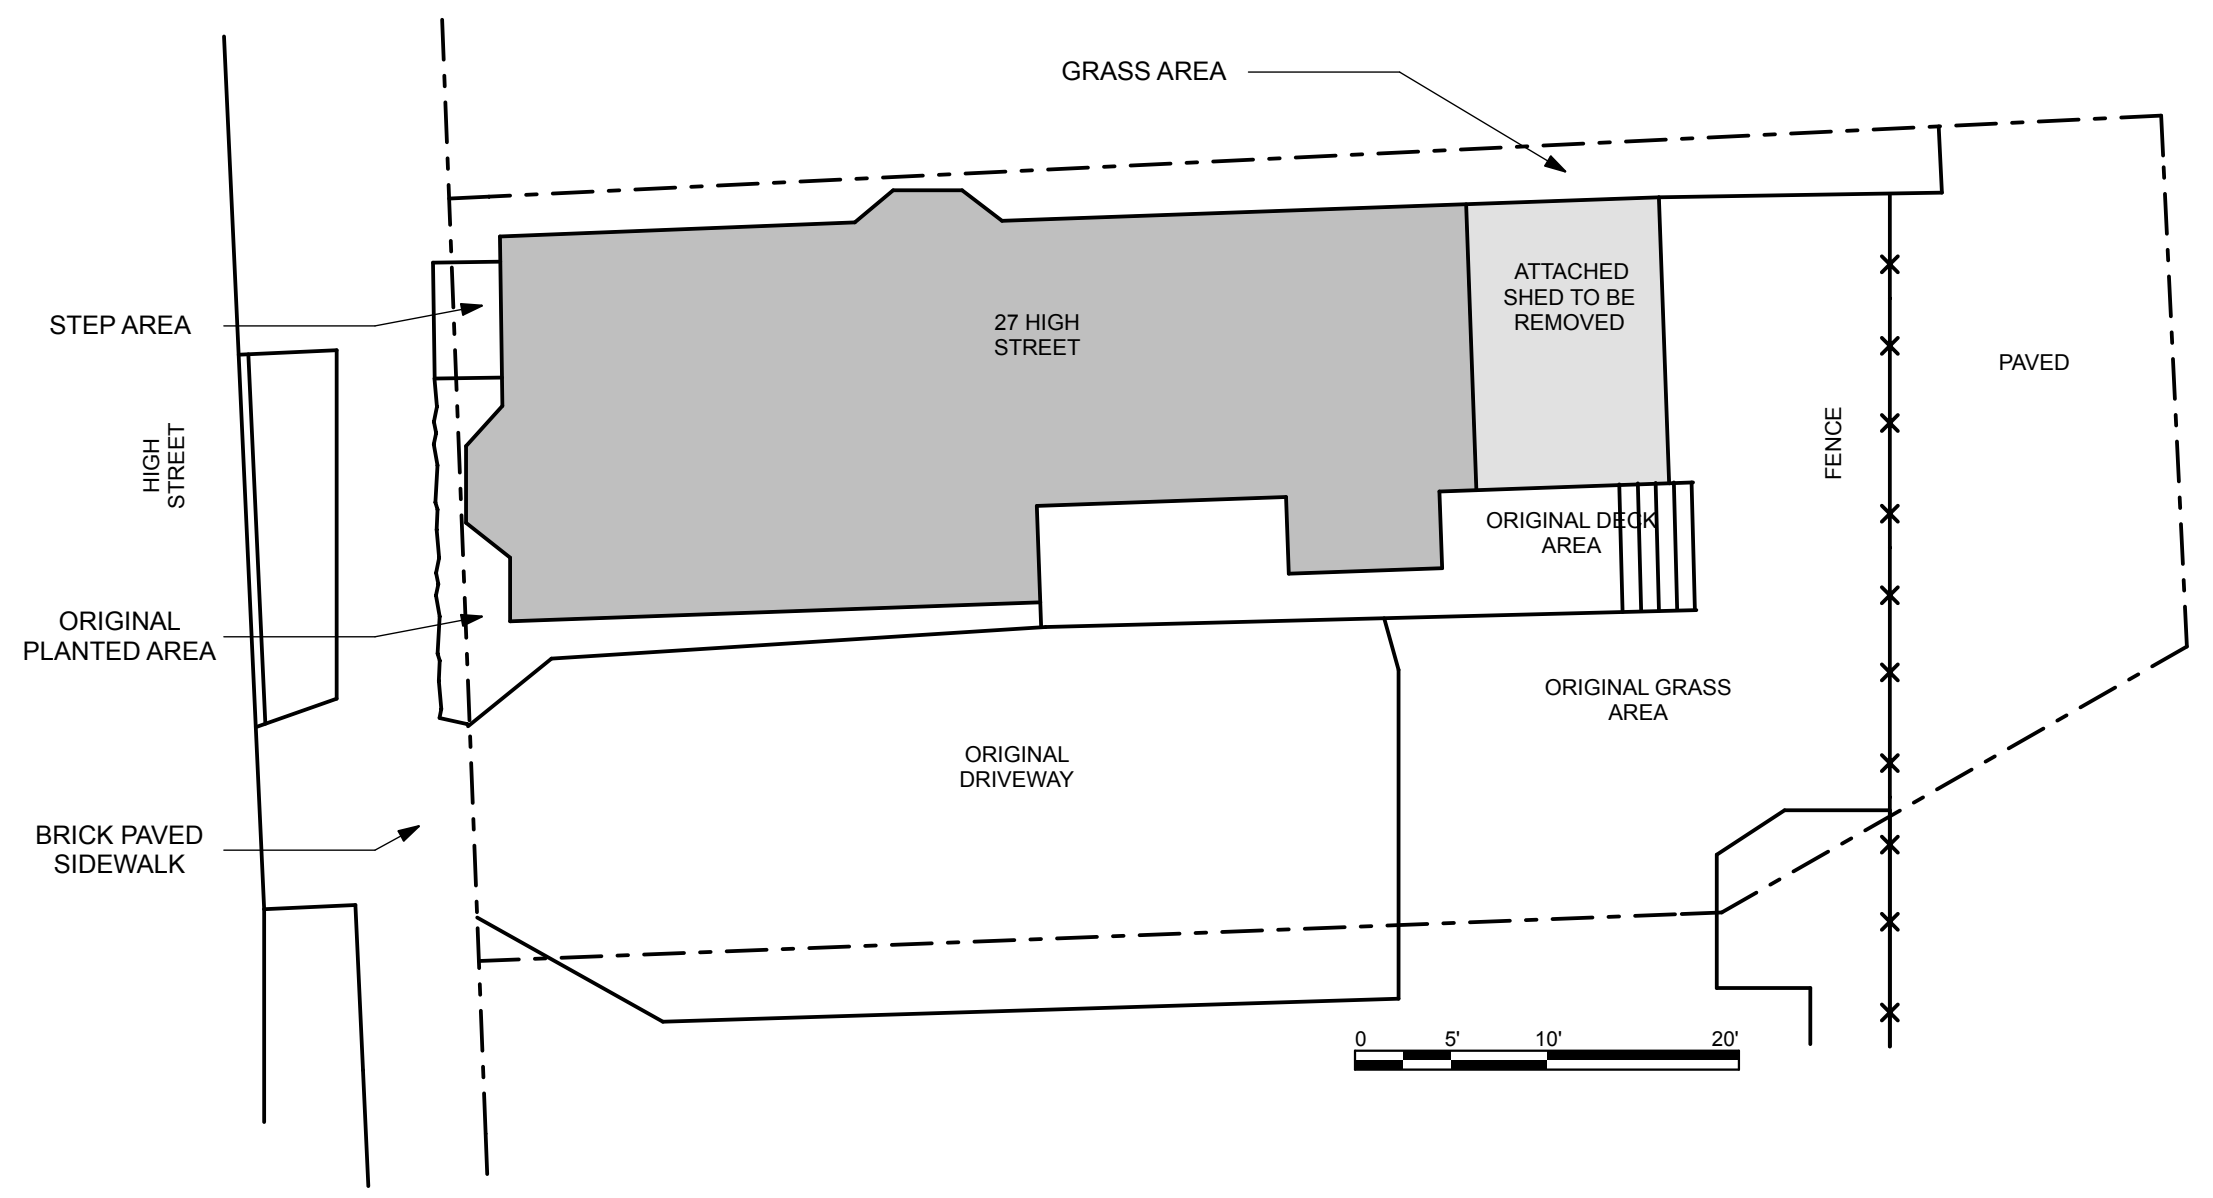

2 ORIGINAL SITE PLAN
SCALE: 1" = 10'

ABBREVIATIONS

AB	ANCHOR BOLT	LAB	LABORATORY
AB	AIR BARRIER	LAM	LAMINATE(D)
AC	AIR CONDITIONING	LAV	LAVATORY
ADDL	ADDITIONAL	LB	POUND(S)
ADJ	ADJUSTABLE	LCC	LEAD COATED COPPER
AFF	ABOVE FINISHED FLOOR	LF	LINEAR FOOT
AH	AIR HANDLER	LH	LEFT HAND
AIB	AIR INFILTRATION BARRIER	LOC'N	LOCATION
ALT	ALTERNATE	LW	LIGHTWEIGHT (CMU)
ALUM	ALUMINIUM	MS	MASONRY
AOR	AREA OF REFUGE	MATL	MATERIAL
APPROX	APPROXIMATE	MAX	MAXIMUM
ARCH	ARCHITECT(URAL)	MC	MEDICINE CABINET
ARND	AROUND	MCWF	MULTICOLOR WALL FINISH
AWP	ACOUSTICAL WALL PANEL	MDO	MEDIUM DENSITY OVERLAY
BD	BOARD	MECH	MECHANICAL
BF	BARRIER FREE	MF	MEMBRANE FLASHING
BIT	BITUMINOUS	MFR	MANUFACTURER
BLDG	BUILDING	MH	MANHOLE
BLKG	BLOCKING	MIN	MINIMUM
BM	BENCHMARK	MISC	MISCELLANEOUS
BOT	BOTTOM	MLDG	MOULDING
BO	BOTTOM OF	MO	MASONRY OPENING
BRK	BRICK	MR	MOISTURE RESISTANT
BRG	BEARING	MRGB	MOISTURE RESISTANT GYPSUM BOARD
BS	BRICK SHELF	MS	MOP SINK
BSMT	BASEMENT	MSF	METAL STUD FRAMING
C.CRS	COURSE	MTL	METAL
CAB	CABINET	NA	NORTH
CB	CATCH BASIN	N	NOT APPLICABLE
CC	CENTER TO CENTER	NIC	NOT IN CONTRACT
CF	CUBIC FOOT	NO	NUMBER
CFMF	COLD FORMED METAL FRAMING	NOM	NOMINAL
CJ	CONTROL JOINT	NRC	NOISE REDUCTION COEFFICIENT
CL	CENTER LINE	NTS	NOT TO SCALE
CLG	CEILING	O/	OVER
CLR	CLEAR	OC	ON CENTER
CMT	CERAMIC MOSAIC TILE	OD	OUTSIDE DIAMETER
CMU	CONCRETE MASONRY UNIT	OFS	OVERFLOW SCUPPER
CO	CLEAN-OUT	OP	OPAQUE
COL	COLUMN	OH	OVERHEAD
CONC	CONCRETE	OPH	OPPOSITE HAND
CONC/C	COLORED CONCRETE	OPNG	OPENING
CONT	CONTINUOUS OR CONTINUE	OPP	OPPOSITE
CONTR	CONTRACTOR	OPS	OPERABLE PANEL SYSTEM
CPT	CARPET	P.PTD	PAINT
CS	COUNTERSINK	PC	PRECAST CONC.
CSMT	CASEMENT	PERF	PERFORATED
CT	CERAMIC TILE	PERIM	PERIMETER
CWT	CERAMIC WALL TILE	PRKG	PARKING
CUH	CABINET UNIT HEATER	PL	PLATE
CY	CUBIC YARD	PLAM	PLASTIC LAMINATE
DBL	DOUBLE	PLYWD	PLYWOOD
DC	DISPLAY CASE	PSF	POUNDS PER SQUARE FOOT
DEMO	DEMOLISH, DEMOLITION	PSI	POUNDS PER SQUARE INCH
DF	DRINKING FOUNTAIN	PT	PRESSURE TREATED
DIA, DIAM	DIAMETER	PTD	PAPER TOWEL DISPENSER
DIM	DIMENSION	PTN	PARTITION
DIV	DIVISION	PVC	POLYVINYL CHLORIDE
DMP	DEMOUNTABLE PARTITION	PVMT	PAVEMENT
DN	DOWN	PWDR	POWDER ROOM
DR	DOOR	QR	QUARTER ROUND
DTL	DETAIL	QT	QUARRY TILE
DWG	DRAWING	QZ	QUARTZ TILE
DWR	DRAWER	RE:	REFERENCE
E	EAST	REF	REFRIGERATOR
EA	EACH	REQD	REQUIRED
EF	EXHAUST FAN	REV	REVISION(S), REVISED
EMHO	ELECTRO MAGNETIC HOLD OPEN	RL	RAIN LEADER
EIFS	EXTERIOR INSULATION FINISH SYSTEM	RF	RUBBER FLOOR
EJ	EXPANSION JOINT	RH	RIGHT HAND
EL	ELEVATION	RM	ROOM
EP	EPOXY PAINT	RO	ROUGH OPENING
ELEC	ELECTRICAL	ROW	RIGHT OF WAY
ELEV	ELEVATOR	S	SOUTH
EMER	EMERGENCY	SAT	SUSPENDED ACOUSTICAL TILE
ENCL	ENCLOSED/ENCLOSURE	SC	SOLID CORE
EQ	EQUAL	SCONC	SEALED CONCRETE
EQUIP	EQUIPMENT	SCHED	SCHEDULE
EXH	EXHAUST	SD	STORM DRAIN, SOAP DISPENSER
EXIST	EXISTING	SECT	SECTION
EXT	EXTERIOR	SF	SQUARE FOOT
EW	EYEWASH	SGL	SAFETY GLASS
EWG	ELECTRIC WATER COOLER	SH	SHOWER
FB	FIRE BLANKET	SHT	SHEET
FBO	FURNISHED BY OWNER	SHTHG	SHEATHING
FCS	FLOOR COATING SYSTEM	SIM	SIMILAR
FD	FLOOR DRAIN	SLNT	SEALANT
FE	FIRE EXTINGUISHER	SNR	SANITARY NAPKIN RECEPTOR
FEC	FIRE EXTINGUISHER AND CABINET	SP	SPECIAL PAINT
FEE	FINISHED FLOOR ELEVATION	SPEC	SPECIFICATION
FG	FIBERGLASS	SPKR	SPEAKER
FHVC	FIRE HOSE AND VALVE CABINET	SQ	SQUARE
FIN	FINISHED(ED)	SS	STAINLESS STEEL
FIN GR	FINISH GRADE	STC	SOUND TRANSMISSION CLASS
FNDN	FOUNDATION	STD	STANDARD
FP	FIREPROOFING	STL	STEEL
FQ	FACE OF	STR	STRUCTURAL
FRMG	FRAME(ING)	STRUC	STRUCTURES/STRUCTURAL
FRP	FIBER REINFORCED PLASTIC	SUPT	SUPPORT
FRT	FIRE RETARDANT TREATED	SUSP	SUSPENDED
FS	FRAME SIZE	SV	SHEET VINYL
FSR	FLEXIBLE SHEET ROOFING	T	TOILET
FT	FOOT(FEET)	TB	TOWEL BAR
FTG	FOOTLONG	TB	TACK-BOARD
FTR	FIN TUBE RADIATION	T&G	TONGUE & GROOVE
FUR	FURREDDING	TGL	TEMPERED GLASS
FV	FIELD VERIFY	THK	THICK(NESS)
FWC	FABRIC WALL COVERING	TO	TOP OF
GA	GAUGE	TP	TOILET PARTITION
GALV	GALVANIZED	TPD	TOILET PAPER DISPENSER
GB	GRAB BAR	TV	TELEVISION
GBF	GROUND FACE CMU	TYP	TYPICAL
GL	GLASS, GLAZING	UCR	UNDER COUNTER REFRIGERATOR
GWB	GYPSUM WALLBOARD	UNO	UNLESS NOTED OTHERWISE
HARD	HARDENER	VB	VAPOR BARRIER/VINY BASE
HB	HOSE BIBS	VC	VALVE CABINET
HC	HOLLOW CORE	VCT	VINYL COMPOSITION TILE
HD	HEAD	VERT	VERTICAL
HDO	HIGH DENSITY OVERLAY	VPW	VENEER PLYWOOD
HDWD	HARDWOOD	WVC	VINYL WALL COVERING
HDWR	HARDWARE	W	WEST
HM	HOLLOW METAL	WJ	WATER CLOSET
HORIZ	HORIZONTAL	WD	WOOD
HR	HAND RAIL	WGL	WIRE GLASS
HS	HIGH SCHOOL	WH	WATER HEATER
HT	HEIGHT	W/O	WITHOUT
HTG	HEATING	WS	WATERSTOP
HVAC	HEATING/VENTILATION/AIR CONDITIONING	WP	WATERPROOF
IBC	INSTALLED BY CONTRACTOR	WWF	WELDED WIRE FABRIC
ID	INSIDE DIAMETER	WWM	WELDED WIRE MESH
IN	INCH(S)	YD	YARD
INCL	INCLUDE(D), (ING)	ZCC	ZINC-COATED COPPER
INFO	INFORMATION		
INSUL	INSULATED		
INT	INTERIOR		
INV	INVERT		
JT	JOINT		
KIT	KITCHEN		

LEGEND

MATERIALS

- GRAVEL
- CONCRETE MASONRY UNIT
- BRICK
- CONCRETE
- SOIL
- STEEL
- WOOD FRAMING
- WOOD BLOCKING
- PLYWOOD
- GYPSUM BOARD
- BATT INSULATION
- RIGID INSULATION
- EXPANSION MATERIAL
- FINISH WOOD

FIRE RATING

- 2 HOUR RATED FIRE SEPARATION
- 1 HOUR RATED FIRE SEPARATION
- SMOKE PARTITION

SYMBOLS

- PLUMBING FIXTURE
- BARRIER FREE FIXTURE
- ROOM NUMBER
- DOOR NUMBER
- WINDOW TYPE; LETTER DESIGNATES EXTERIOR
- BORROWED LITE TYPES; DESIGNATED BY NUMBER
- FLOOR LEVEL CHANGE
- BUILDING SECTION
- WALL SECTION
- DETAIL REFERENCE
- WALL OR ROOF TYPE
- ELEVATION REFERENCE
- VERTICAL ELEVATION
- COLUMN CENTERLINE

Room Name

101

DOOR NUMBER

101

WINDOW TYPE; LETTER DESIGNATES EXTERIOR

11

BORROWED LITE TYPES; DESIGNATED BY NUMBER

11

FLOOR LEVEL CHANGE

1/RT1

BUILDING SECTION

1/RT1

WALL SECTION

1/RT1

DETAIL REFERENCE

11

WALL OR ROOF TYPE

REF

ELEVATION REFERENCE

REF A101

VERTICAL ELEVATION

REF


COLUMN CENTERLINE

0

PROJECT NORTH

TRUE NORTH

EXTERIOR RENOVATION - 27 HIGH STREET
PORTLAND, MAINE
27 HIGH ST.

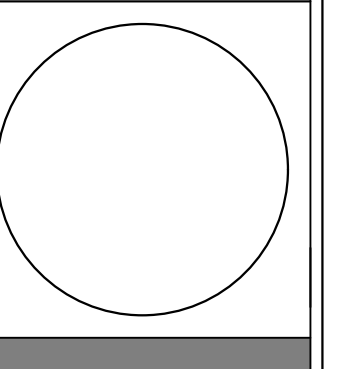

WHIPPLE CALLENDER ARCHITECTS

136 PLEASANT AVE.
PORTLAND, ME 04103
P 207.775.2696
F 207.775.3631
www.whipplecallender.com

DATE	DESCRIPTION

DATE: 3/20/18
CHECKED BY: JAD
DRAWN BY: JAD/ CLBC
JOB: 2017- 27 HIGH
SHEET TITLE: GENERAL NOTES & SITE PLANS

A0.1