


NOTES

1. ALL WORK MUST BE PERFORMED IN ACCORDANCE WITH THE MAINE STATE PLUMBING CODE.
2. INCLUDE RELOCATION OF PIPES TO SUPPORT NEW FIXTURE INSTALLATION.

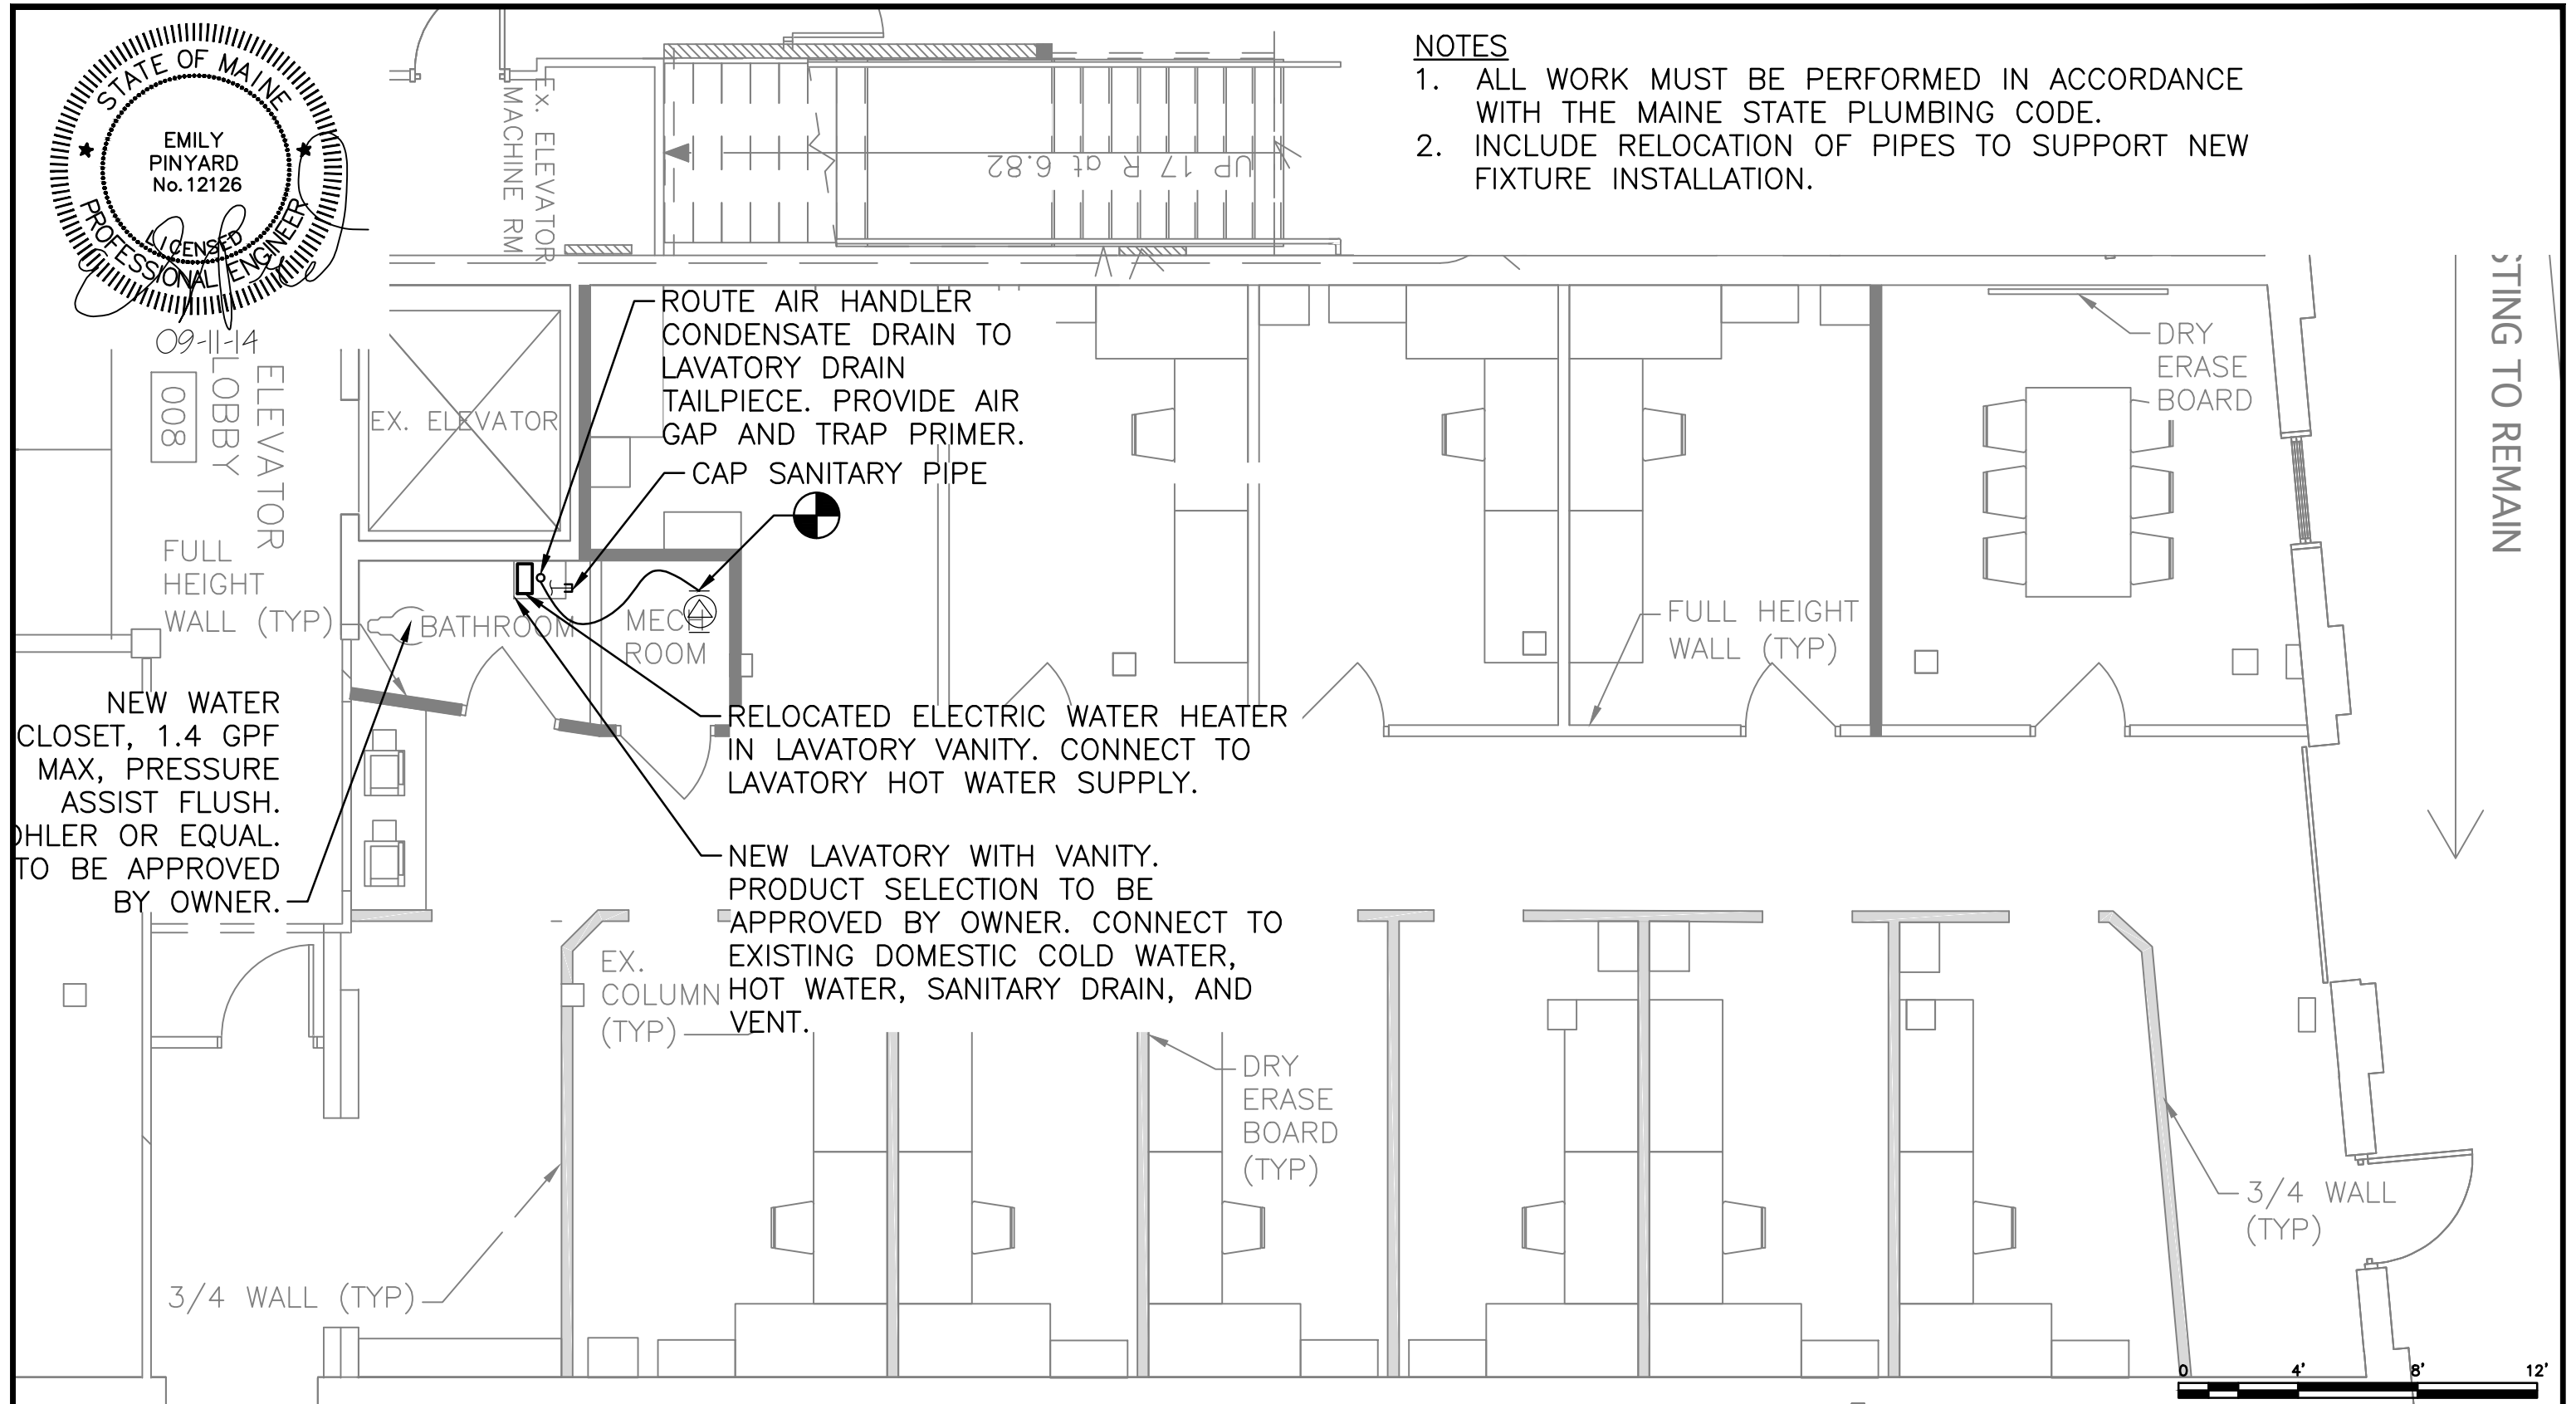

PLUMBING PLAN - NEW
SCALE: 3/16" = 1'-0"



				COLBY COMPANY ENGINEERING 47A YORK STREET, PORTLAND, ME			
				OFFICE EXPANSION 45 YORK STREET			
				PLUMBING PLAN - NEW			
0	ISSUE FOR PERMIT	CSS	ERP	ERP	9/11/14		
REV	DESCRIPTION	DWN BY	CKD BY	APP BY	DATE		

PLEASE NOTE: THIS DOCUMENT MAY NOT ACCURATELY REPRESENT THE FINAL DOCUMENT. ONLY AN ENGINEER, ARCHITECT OR SURVEYOR SIGNED, SEALED AND DATED PAPER COPY PROVIDED BY THIS OFFICE, MAY BE UTILIZED FOR BIDDING OR CONSTRUCTION PURPOSES.

47A York Street
Portland, Maine 04101
207.553.7753
colbycoengineering.com

SIZE:	AS NOTED
DATE:	9/11/2014
DES BY:	ERP
DWN BY:	CSS
CKD BY:	CBC

PROJECT NO.	1.006.001
SHEET	X OF X

DRAWING NO.
P-101

STING TO REMAIN