


COLBY COMPANY ENGINEERING


47A York Street
Portland, Maine

OFFICE RENOVATION

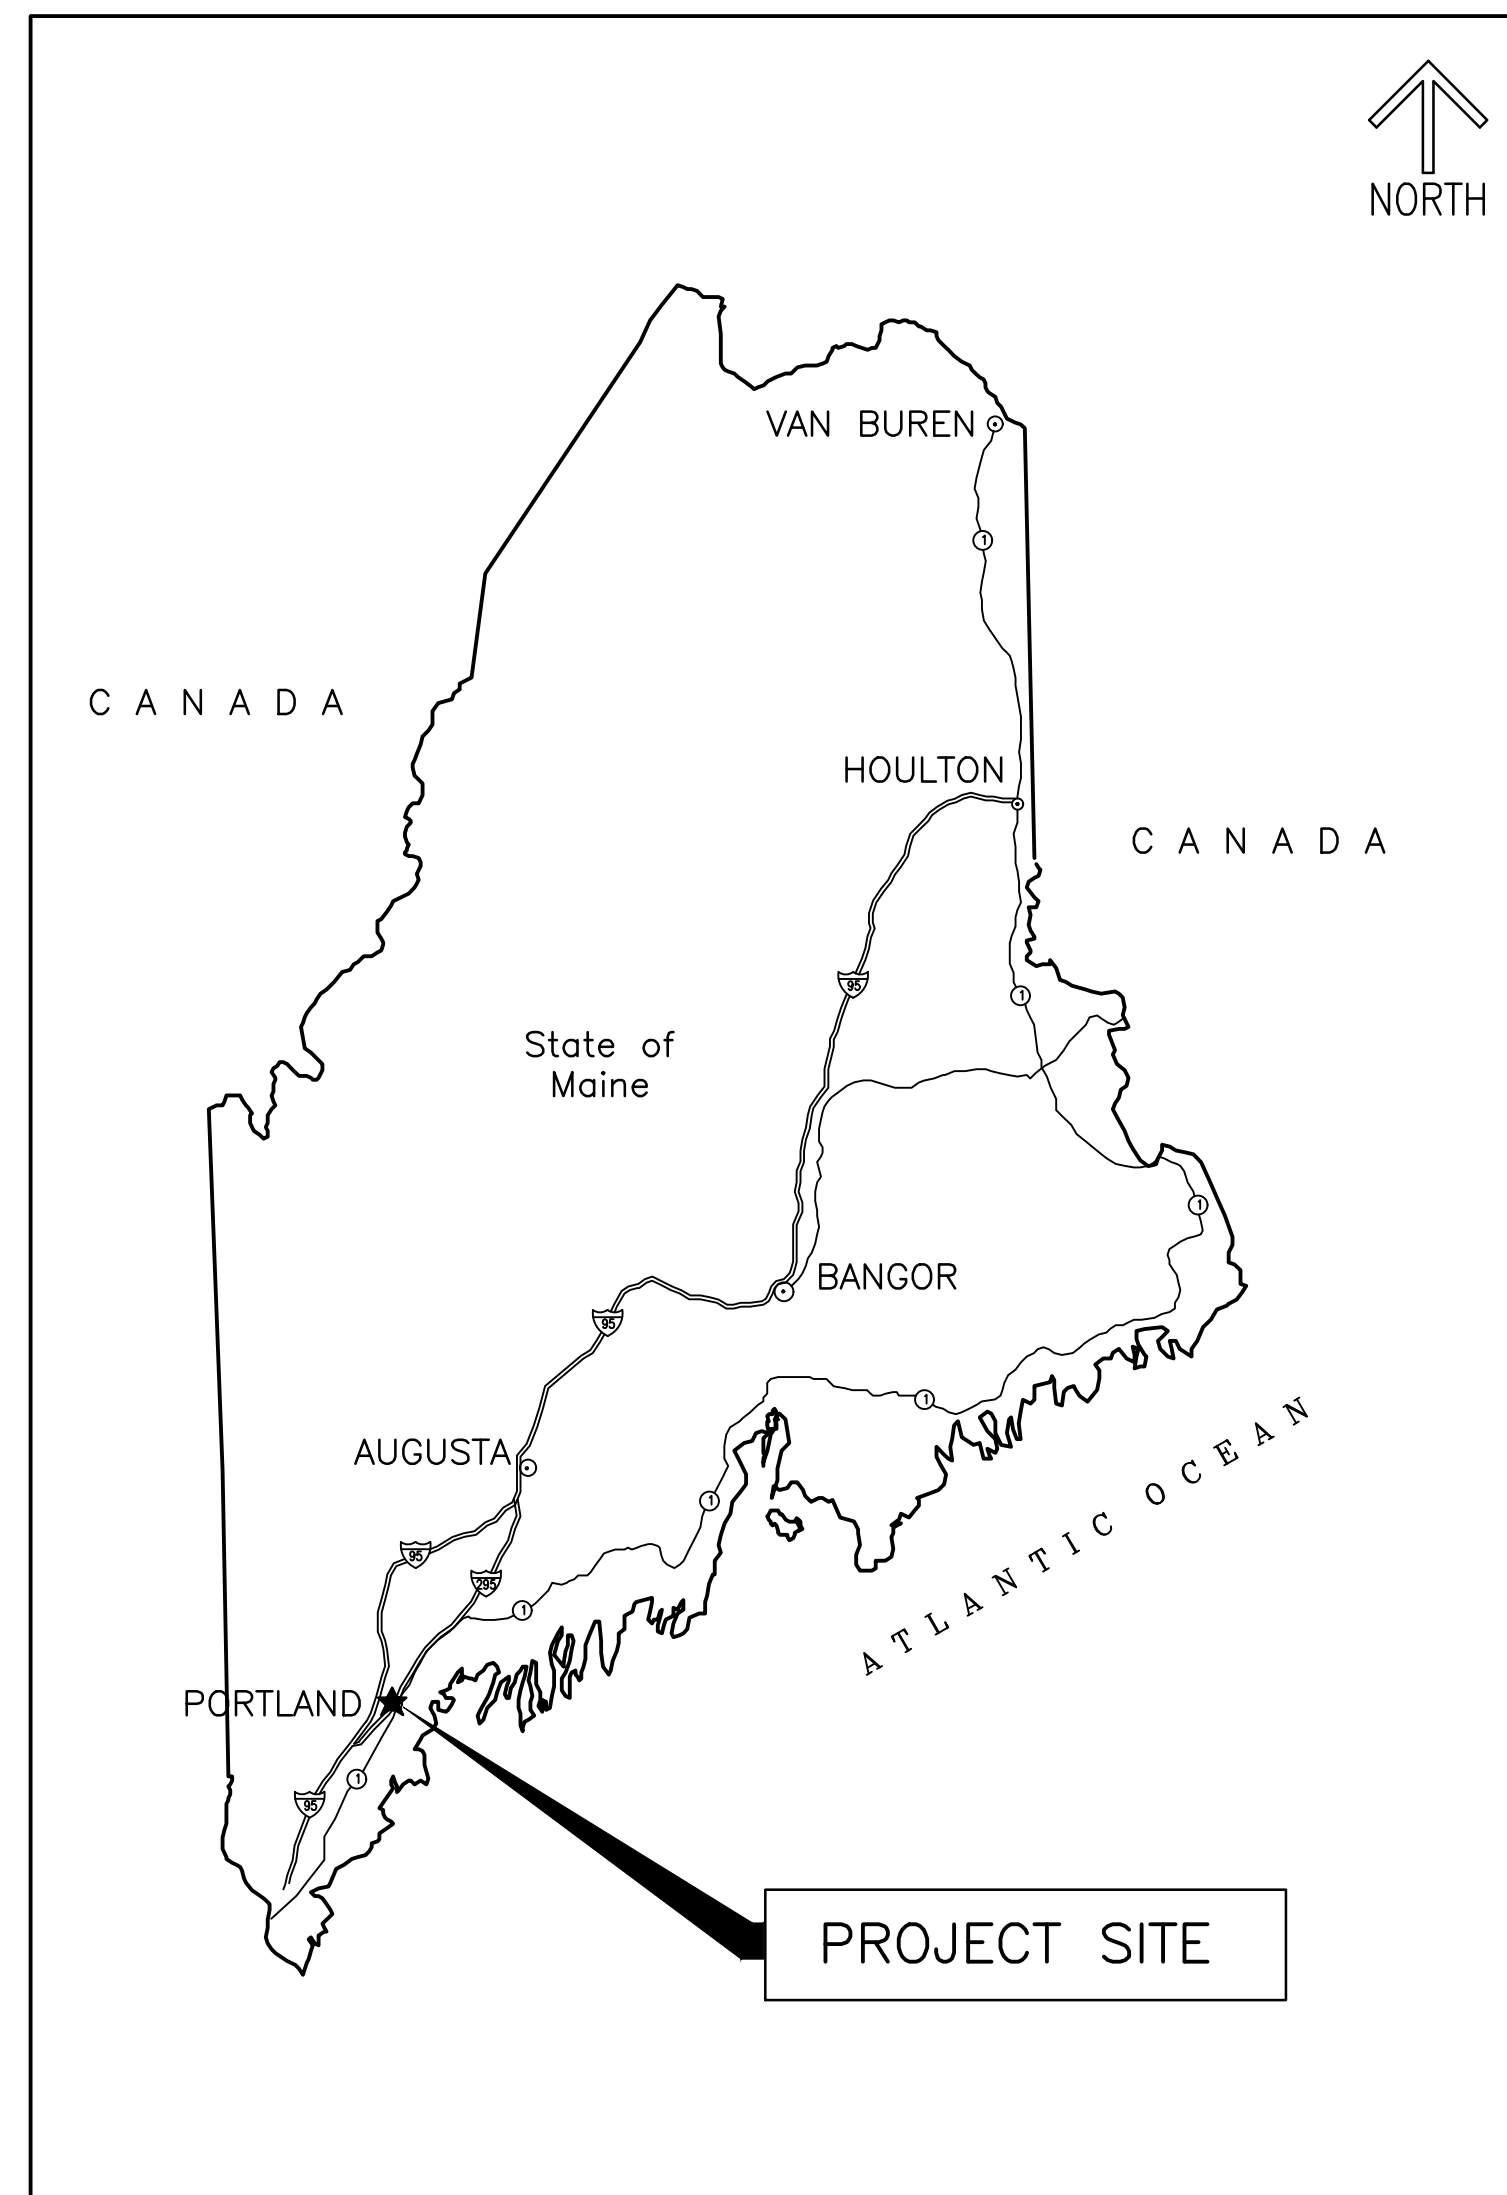


VICINITY MAP
SCALE: N.T.S.

| DRAWING LIST | | |
|--------------|--------------------------------------------------------------|--------------|
| DRAWING | DRAWING TITLE | SHEET NUMBER |
| G-001 | COVER SHEET, PLOT PLAN, AND DRAWING LIST | 1 |
| LS-101 | FIRST FLOOR LIFE SAFETY PLAN | 2 |
| A-001 | GENERAL NOTES, ABBREVIATIONS, DETAILS AND SYMBOLS | 3 |
| AD-101 | FIRST FLOOR DEMOLITION PART PLAN - FRONT OFFICE | 4 |
| AD-102 | FIRST FLOOR DEMOLITION PART PLAN - INTER OFFICE | 5 |
| AD-103 | FIRST FLOOR DEMOLITION REFLECTED CEILING PLAN - FRONT OFFICE | 6 |
| A-101 | FIRST FLOOR PART PLAN - FRONT OFFICE | 7 |
| A-102 | FIRST FLOOR PART PLAN - INTER OFFICE | 8 |
| A-103 | FIRST FLOOR REFLECTED CEILING PLAN - FRONT OFFICE | 9 |
| A-201 | INTERIOR ELEVATIONS | 10 |
| A-501 | PARTITION AND CEILING TYPES AND DETAILS | 11 |
| A-601 | DOOR SCHEDULE AND DETAILS | 12 |
| MD-101 | MECHANICAL DEMOLITION PLAN | 13 |
| M-101 | MECHANICAL PLAN | 14 |
| FP-101 | FIRE PROTECTION PLAN - FRONT OFFICE | 15 |
| FP-102 | FIRE PROTECTION PLAN - INTER OFFICE | 16 |
| ED-101 | ELECTRICAL DEMOLITION PLAN | 17 |
| E-101 | ELECTRICAL POWER AND COMMUNICATIONS PLANS | 18 |
| E-102 | ELECTRICAL LIGHTING PLANS | 19 |

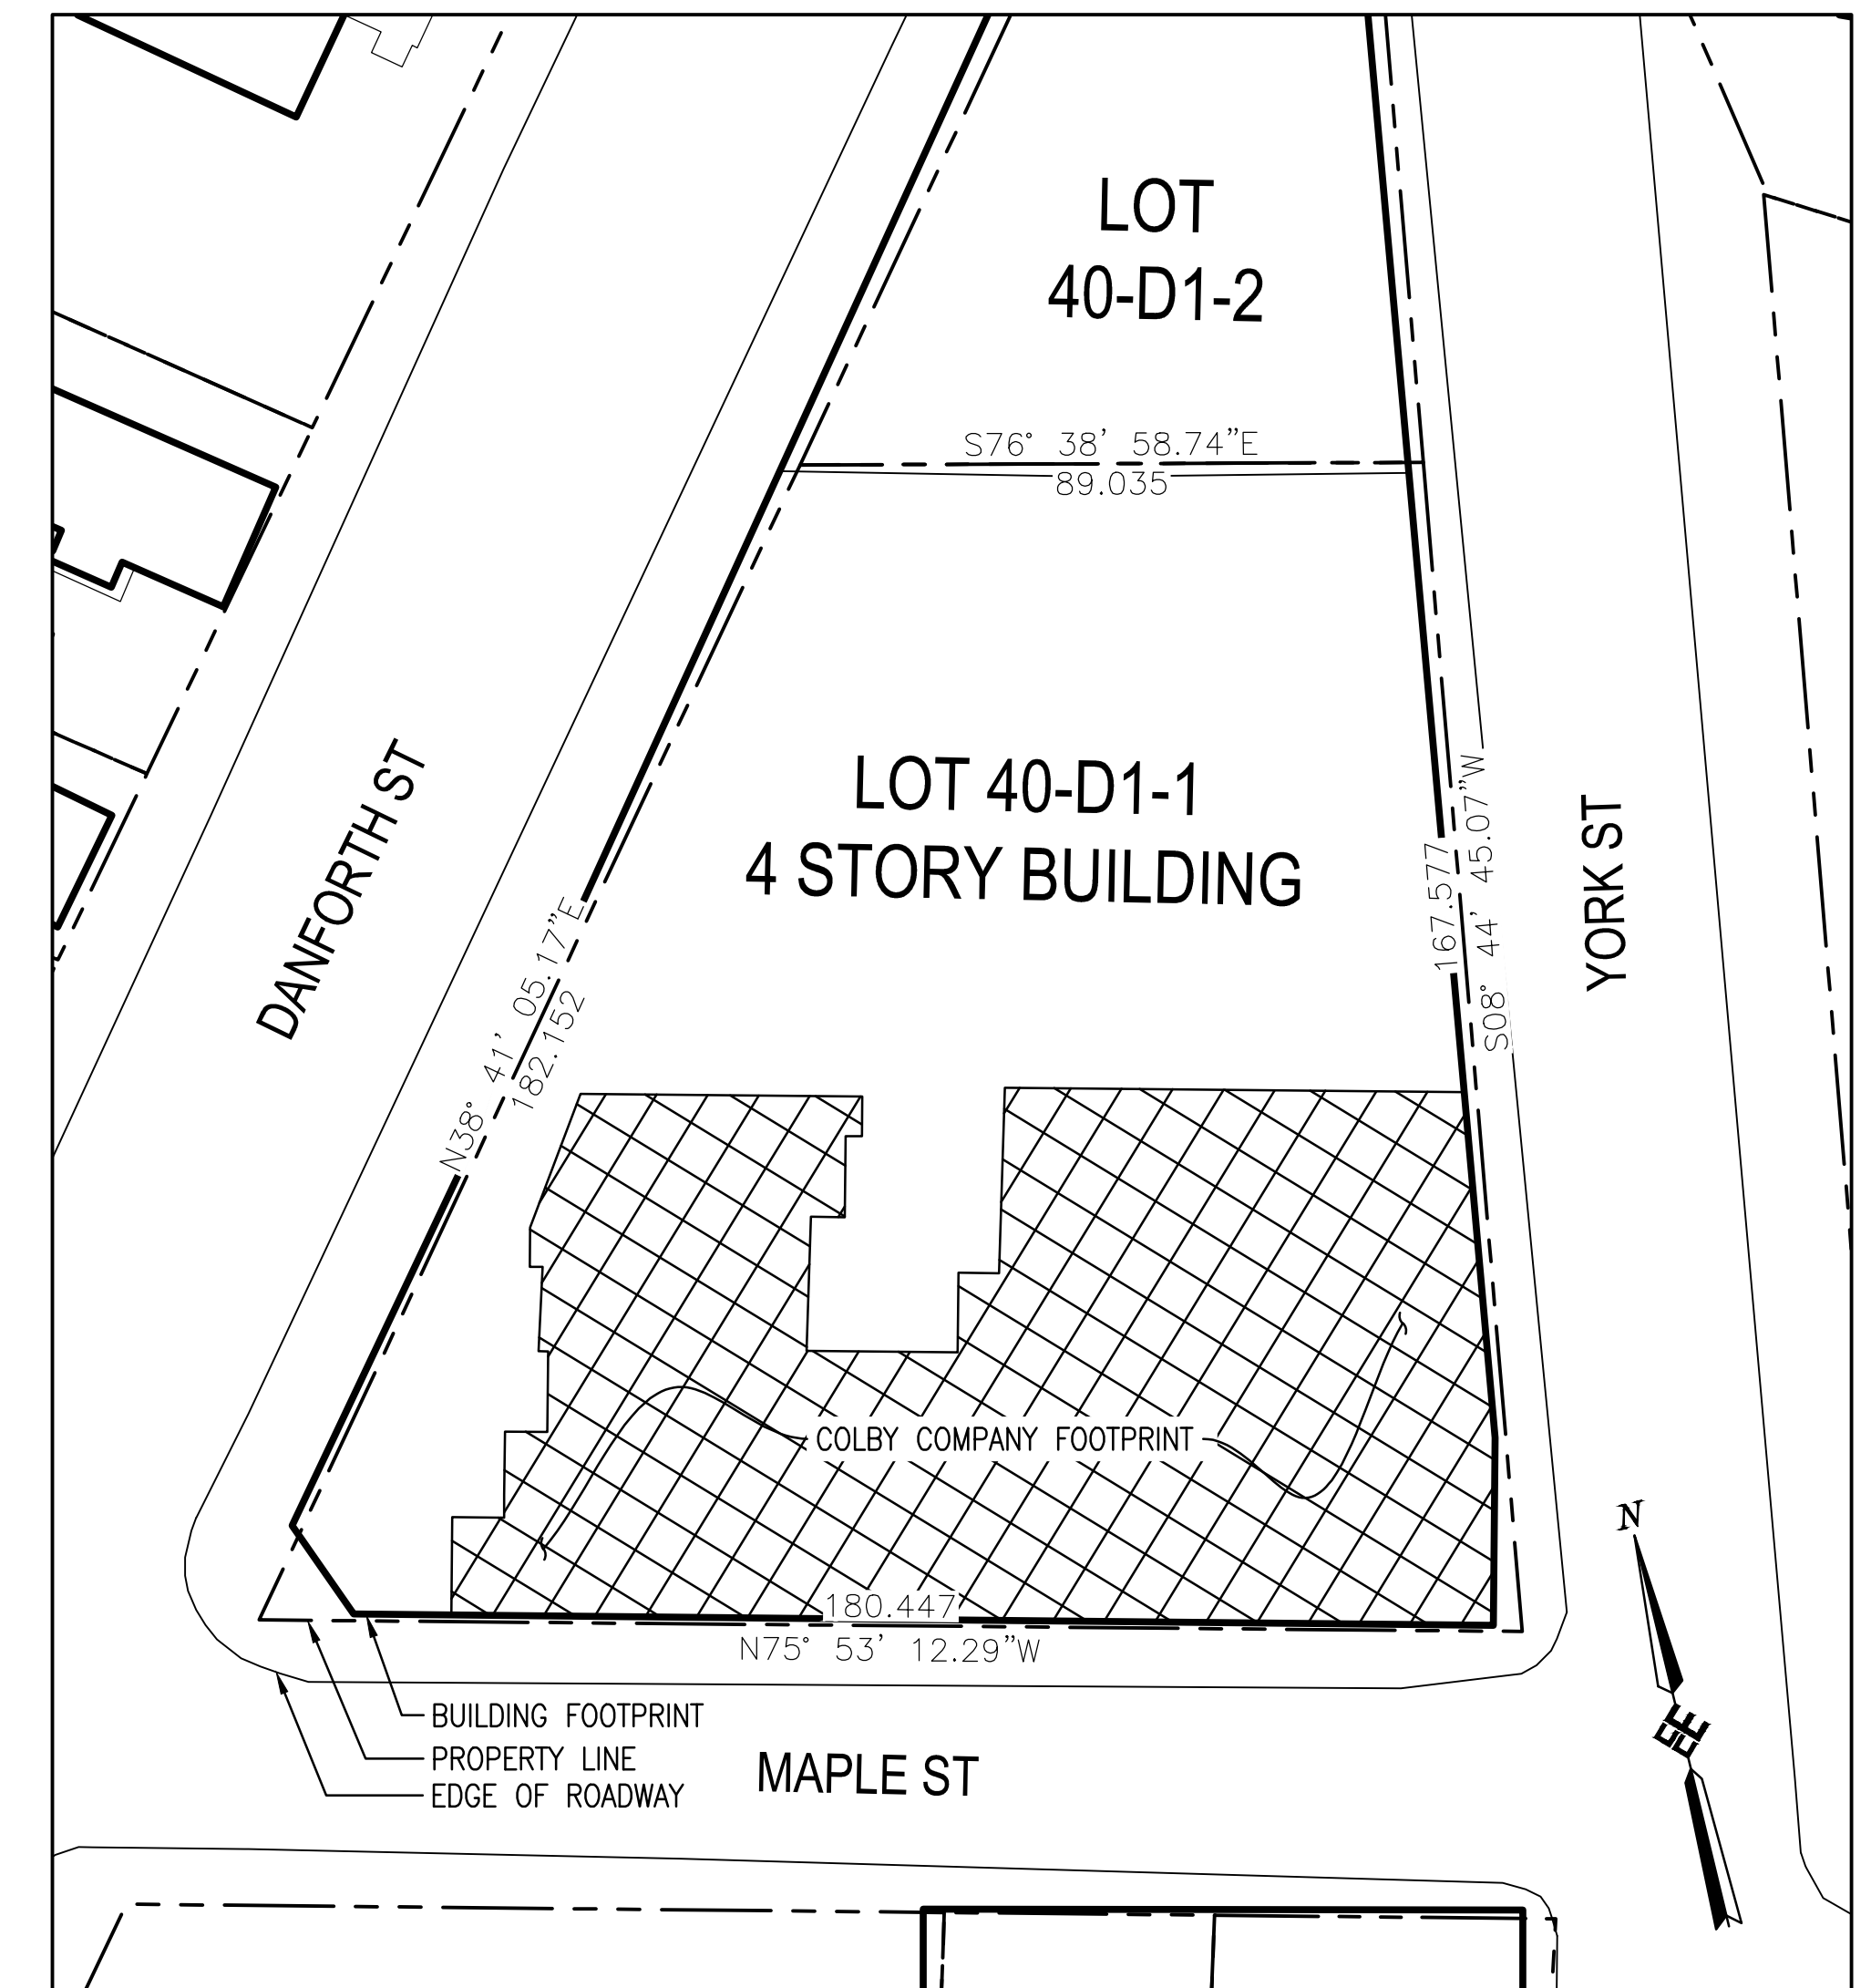

PLOT PLAN
SCALE: 1"=300'-0"
0 300' 600'
Scale: 1" = 300'-0"

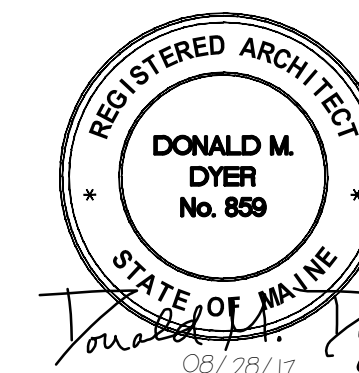

| | | | | | |
|-----------------------------------------------------------------------------------------------------------------------------------------------------------------------------------------------------------------------------------------|--------------------|-----|----------|-----------------------------------------------------------------------------|------------------------------------------------------------------------------------|
| | | | | COLBY CO. ENGINEERING 47A YORK STREET, PORTLAND MAINE | |
| | | | | NEW CUBICLE FIT-OUT/ OFFICE EXPANSION | |
| | | | | COVER SHEET, PLOT PLAN, AND DRAWING LIST | |
| 0 | ISSUED FOR BIDDING | CBC | 08/28/17 | PROJECT NO. 262.002.001 | DRAWING NO. G-001 |
| REV | DESCRIPTION | DWN | APP | DATE | SHEET 1 OF 19 |
| PLEASE NOTE: THIS DOCUMENT MAY NOT ACCURATELY REPRESENT THE FINAL DOCUMENT. ONLY AN ENGINEER, ARCHITECT OR SURVEYOR SIGNED, SEALED AND DATED PAPER COPY, PROVIDED BY THIS OFFICE, MAY BE UTILIZED FOR BIDDING OR CONSTRUCTION PURPOSES. | | | | SIZE: ANSI D DATE: AUG 2017 DES BY: MAB DWN BY: MAB CKD BY: BLB | 47A York Street Portland, Maine 04101 207.553.7753 colbycoengineering.com |