

REVISION	SCHEDULE	REVISION DESCRIPTION	DATE	BY

OPENEDGE
CONSTRUCTION CORPORATION
11 CORPORATE DRIVE, BELMONT, NH 03220
PHONE (603) 327-9090 FAX (603) 327-5191

**SECOND FLOOR
HVAC PLAN**


PROJECT: **COMMERCIAL &
MAPLE STREET
MIXED USE DEVELOPMENT**
PORTLAND, ME.

DATE: 06-06-2013
SCALE: 1/8" = 1'-0"
DRAWN BY:


SHEET: **M2**



COPYRIGHT 2012 BY O.C.C.

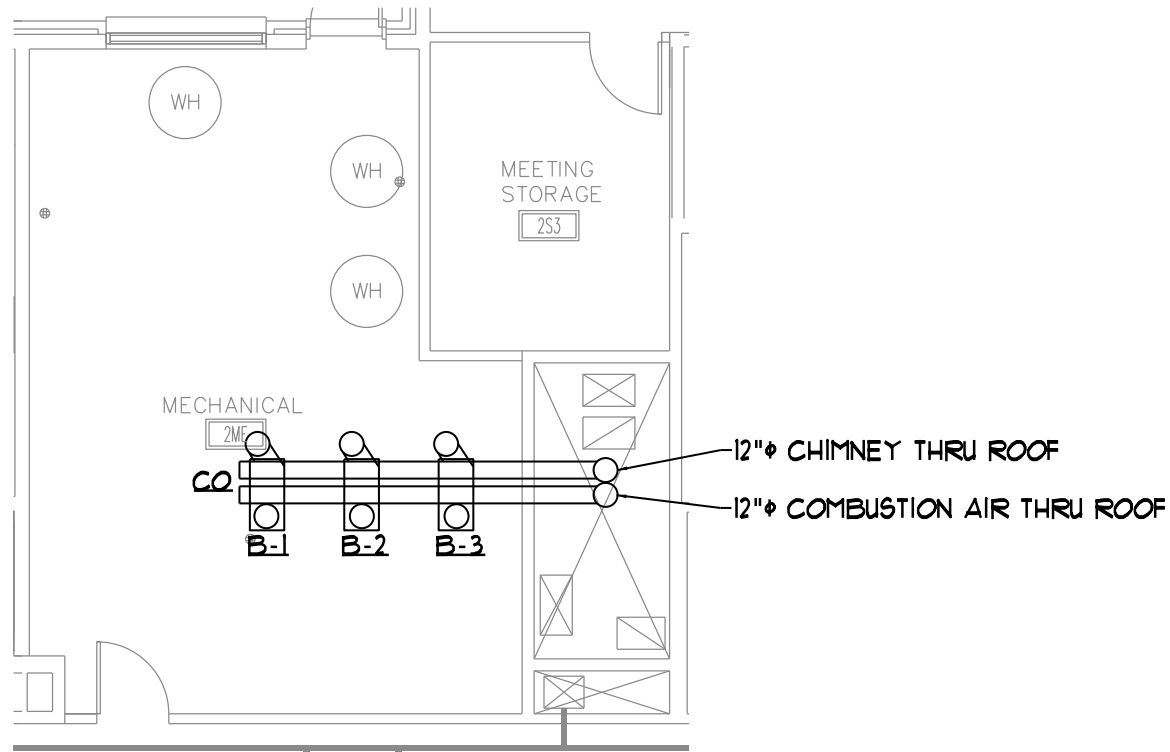

MECHANICAL ROOM PART PLAN
SCALE: 1/8" = 1'-0"

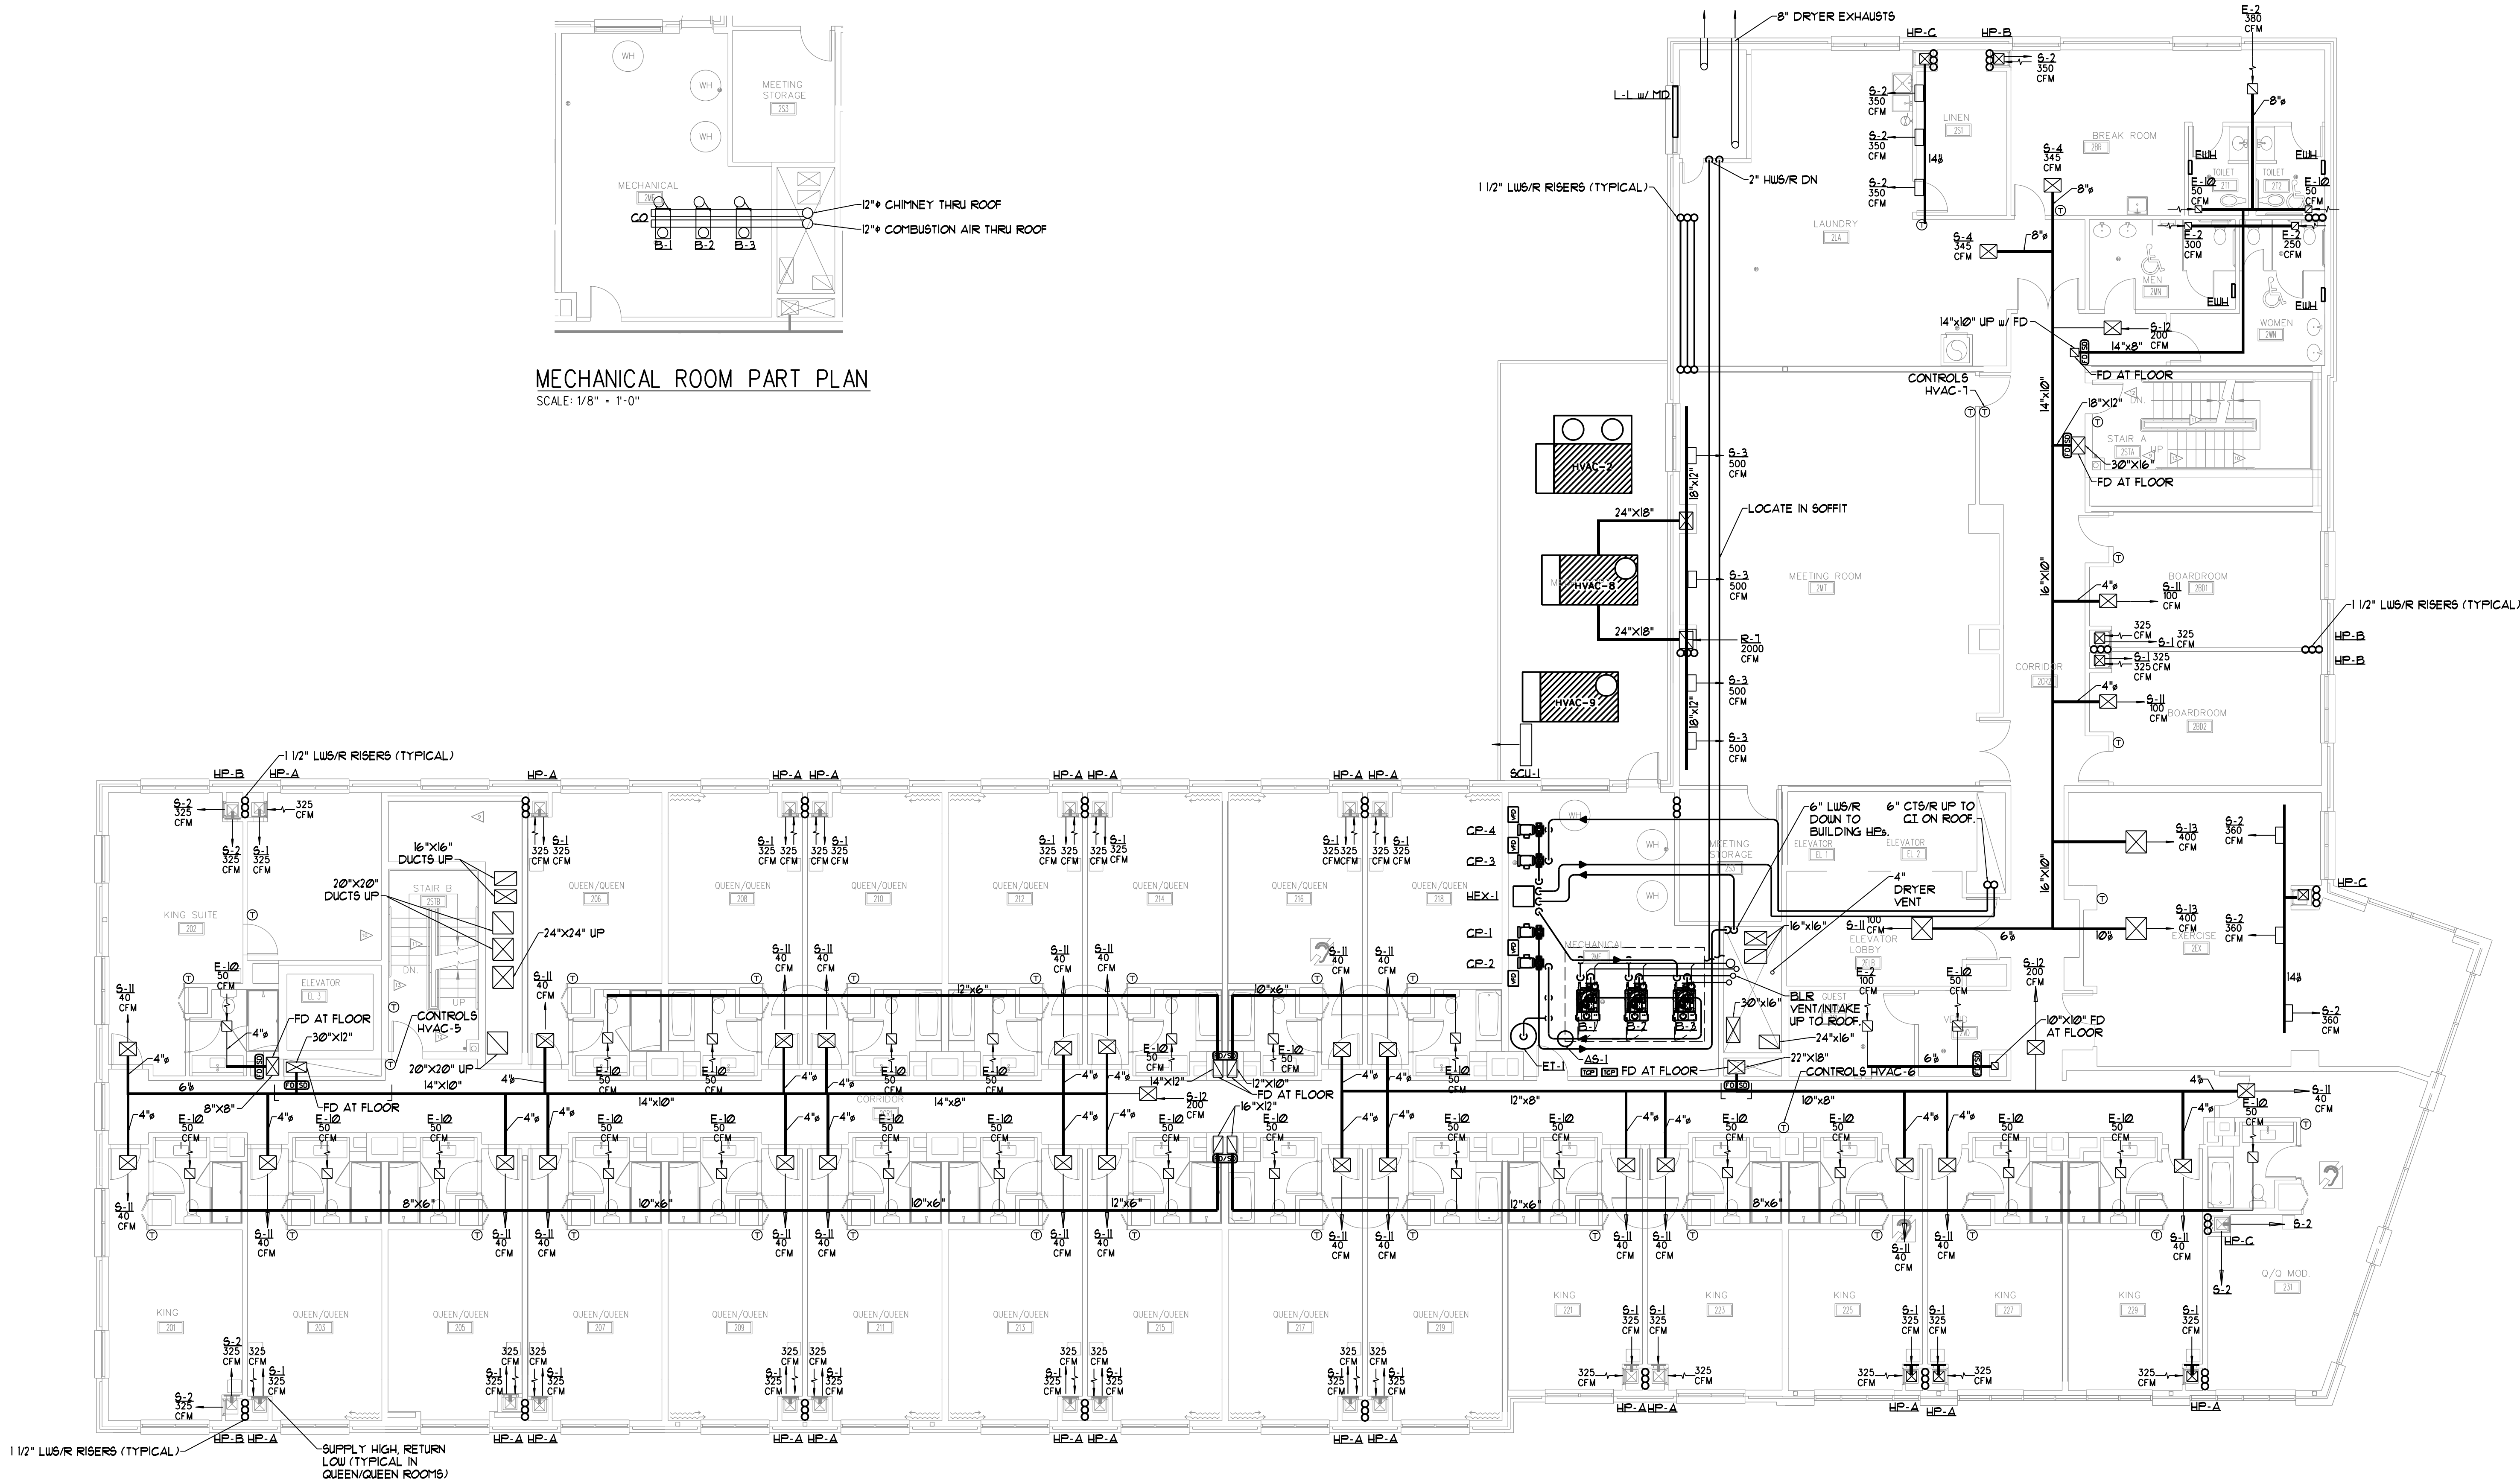

SECOND FLOOR PLAN
SCALE: 1/8" = 1'-0"