

REVISION	SCHEDULE	REVISION DESCRIPTION	DATE	BY

OPEGCHCE
CONSTRUCTION CORPORATION
11 CORPORATE DRIVE, BELMONT, NH 03220
PHONE (603) 321-2000 FAX (603) 321-5191


**THIRD THRU FIFTH FLOOR TYPICAL
HVAC PLAN**

PROJECT: **COMMERCIAL &
MAPLE STREET
MIXED USE DEVELOPMENT**
PORTLAND, ME.

DATE: 06-06-2013
SCALE: 1/8" = 1'-0"
DRAWN BY:
M3
SHEET:



COPYRIGHT 2012 BY O.C.C.

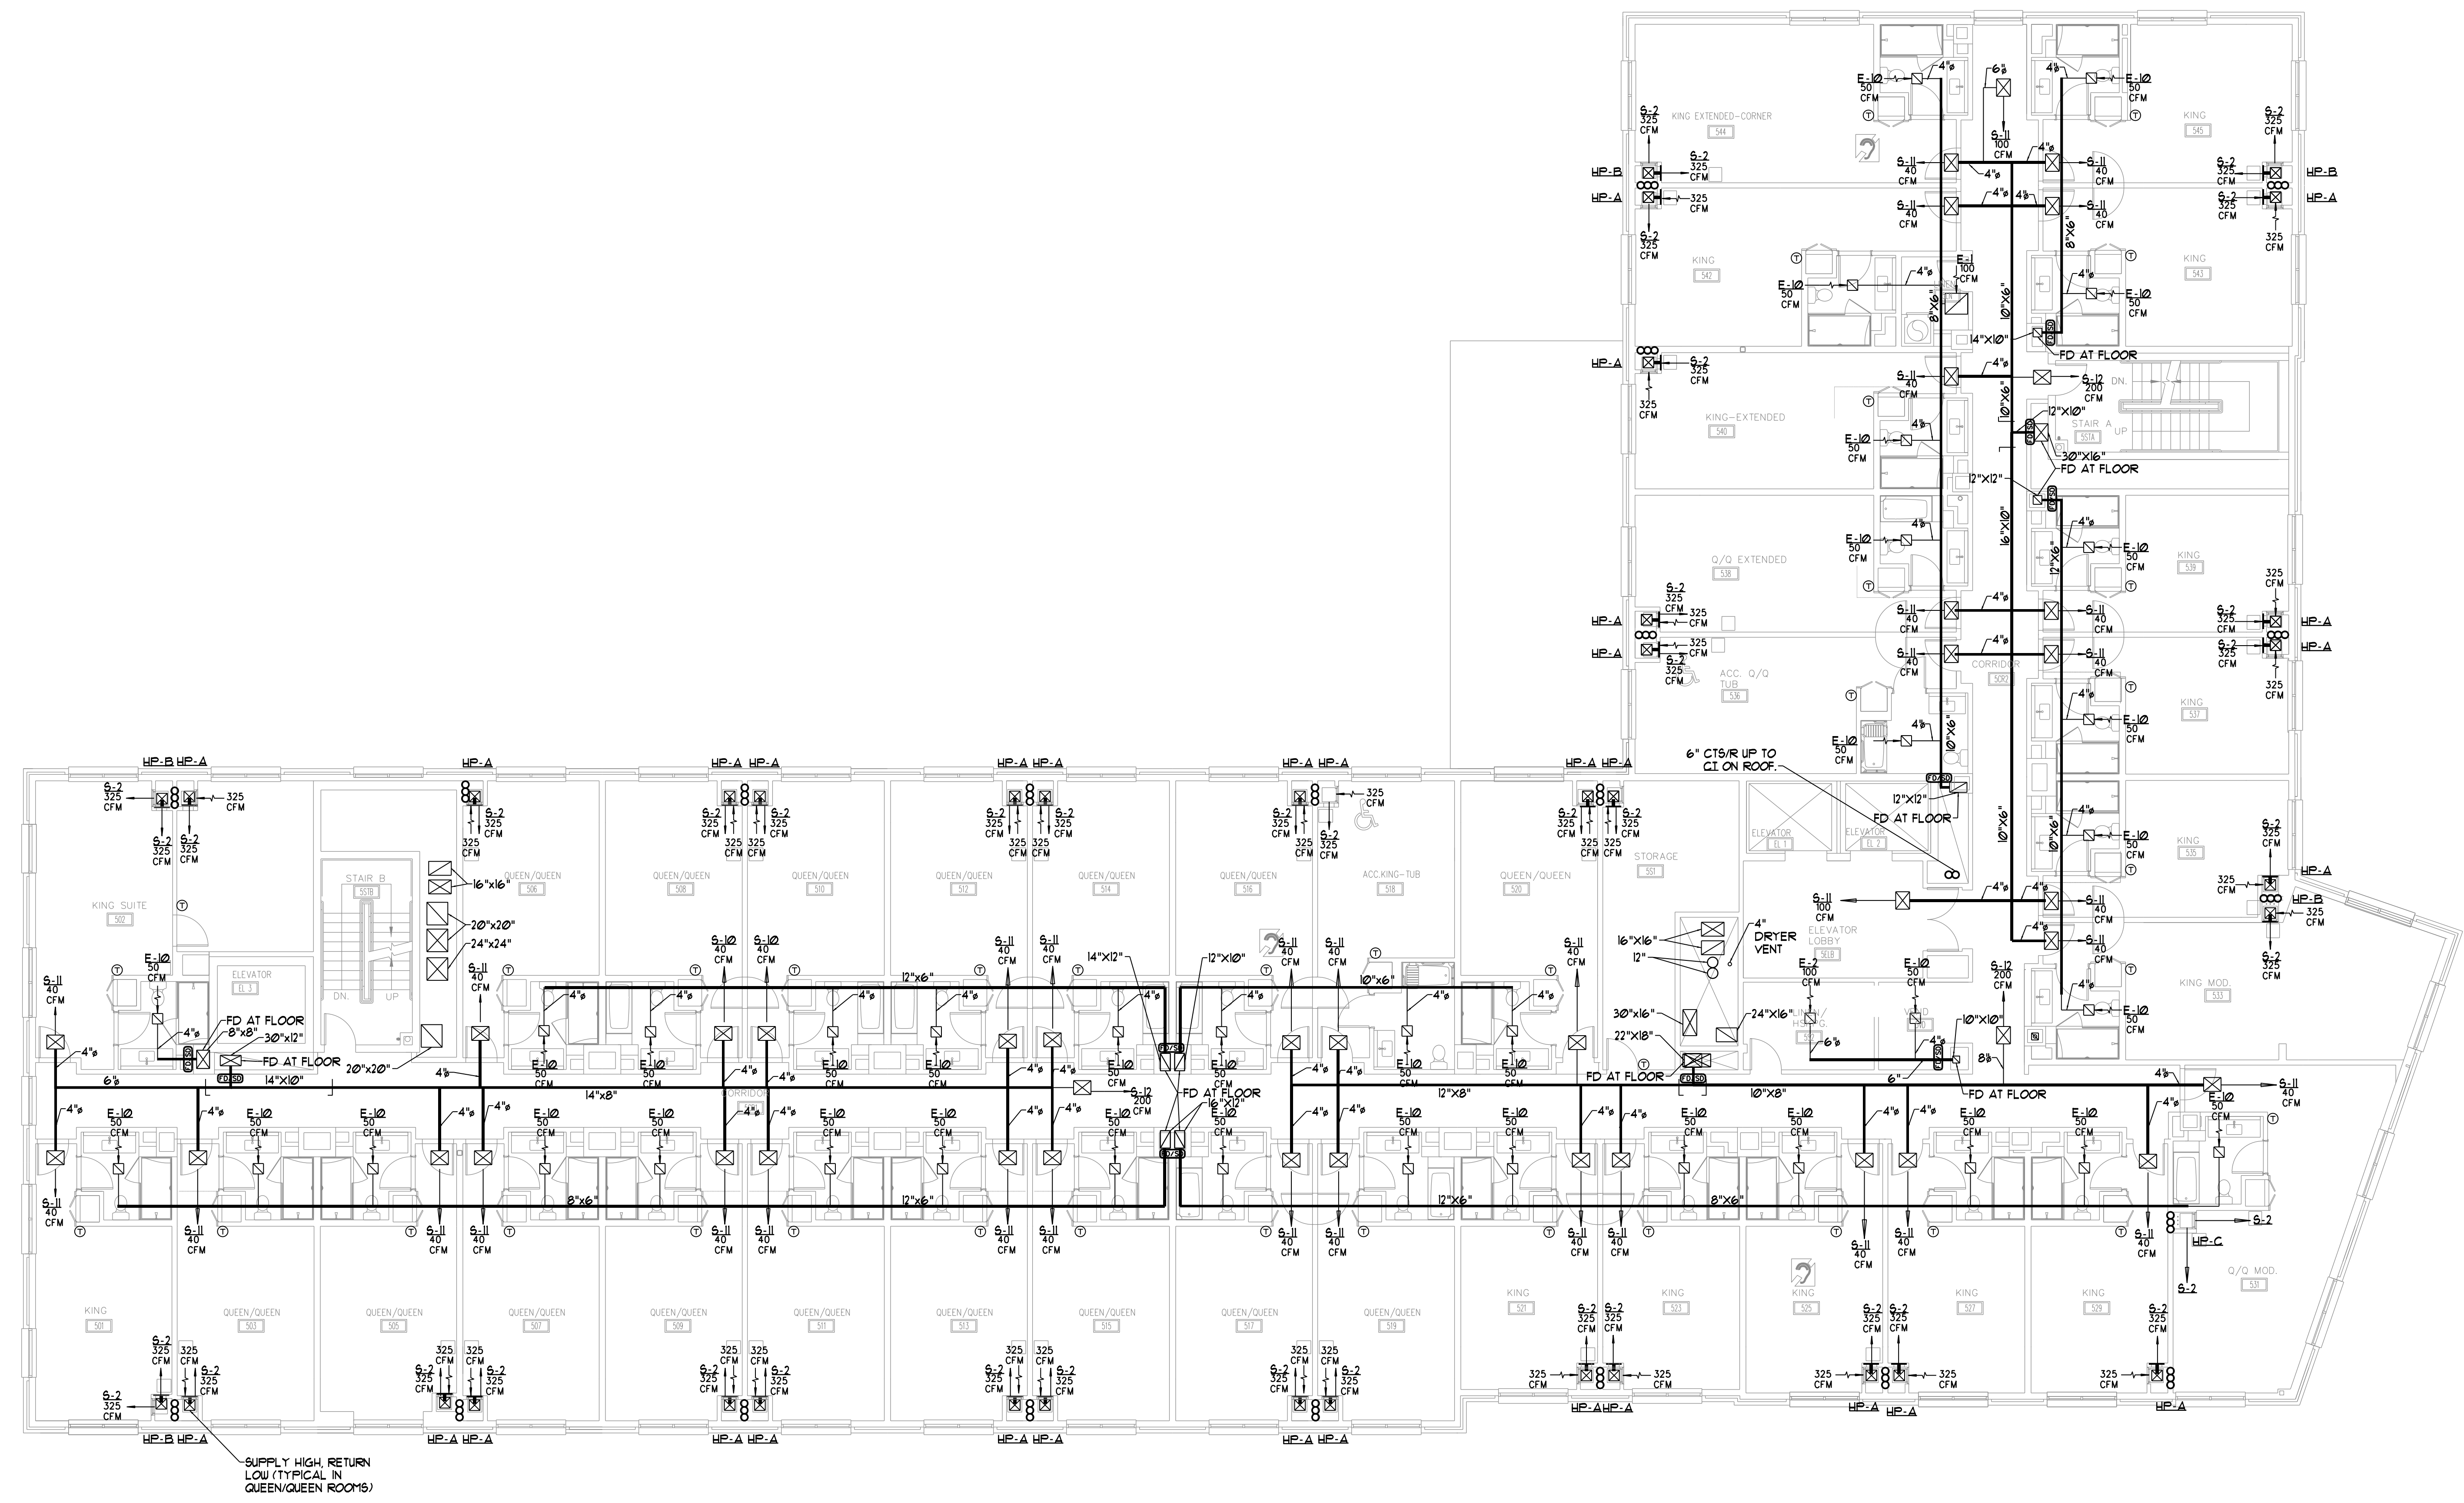

THIRD THRU FIFTH FLOOR PLAN
SCALE: 1/8" = 1'-0"