
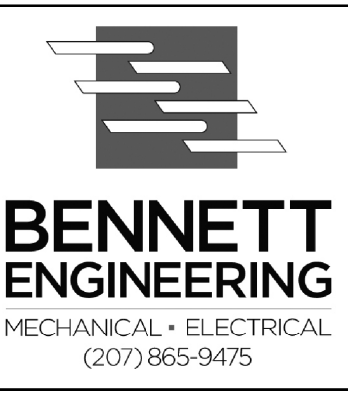


NOTES:

BIDIRECTIONAL AMPLIFIER SYSTEM TO BE PROVIDED AND INSTALLED BY SIDEBAND SYSTEMS.
 CONTACT INFORMATION AT SIDEBAND IS AS FOLLOWS:
 JACK DAVIS, CEO/PRESIDENT SIDEBAND SYSTEMS
 PHONE: (978) 922-4298 EXT. 301
 FAX: (978) 922-4462
 EMAIL: JDAVIS@SIDEBANDSYS.COM

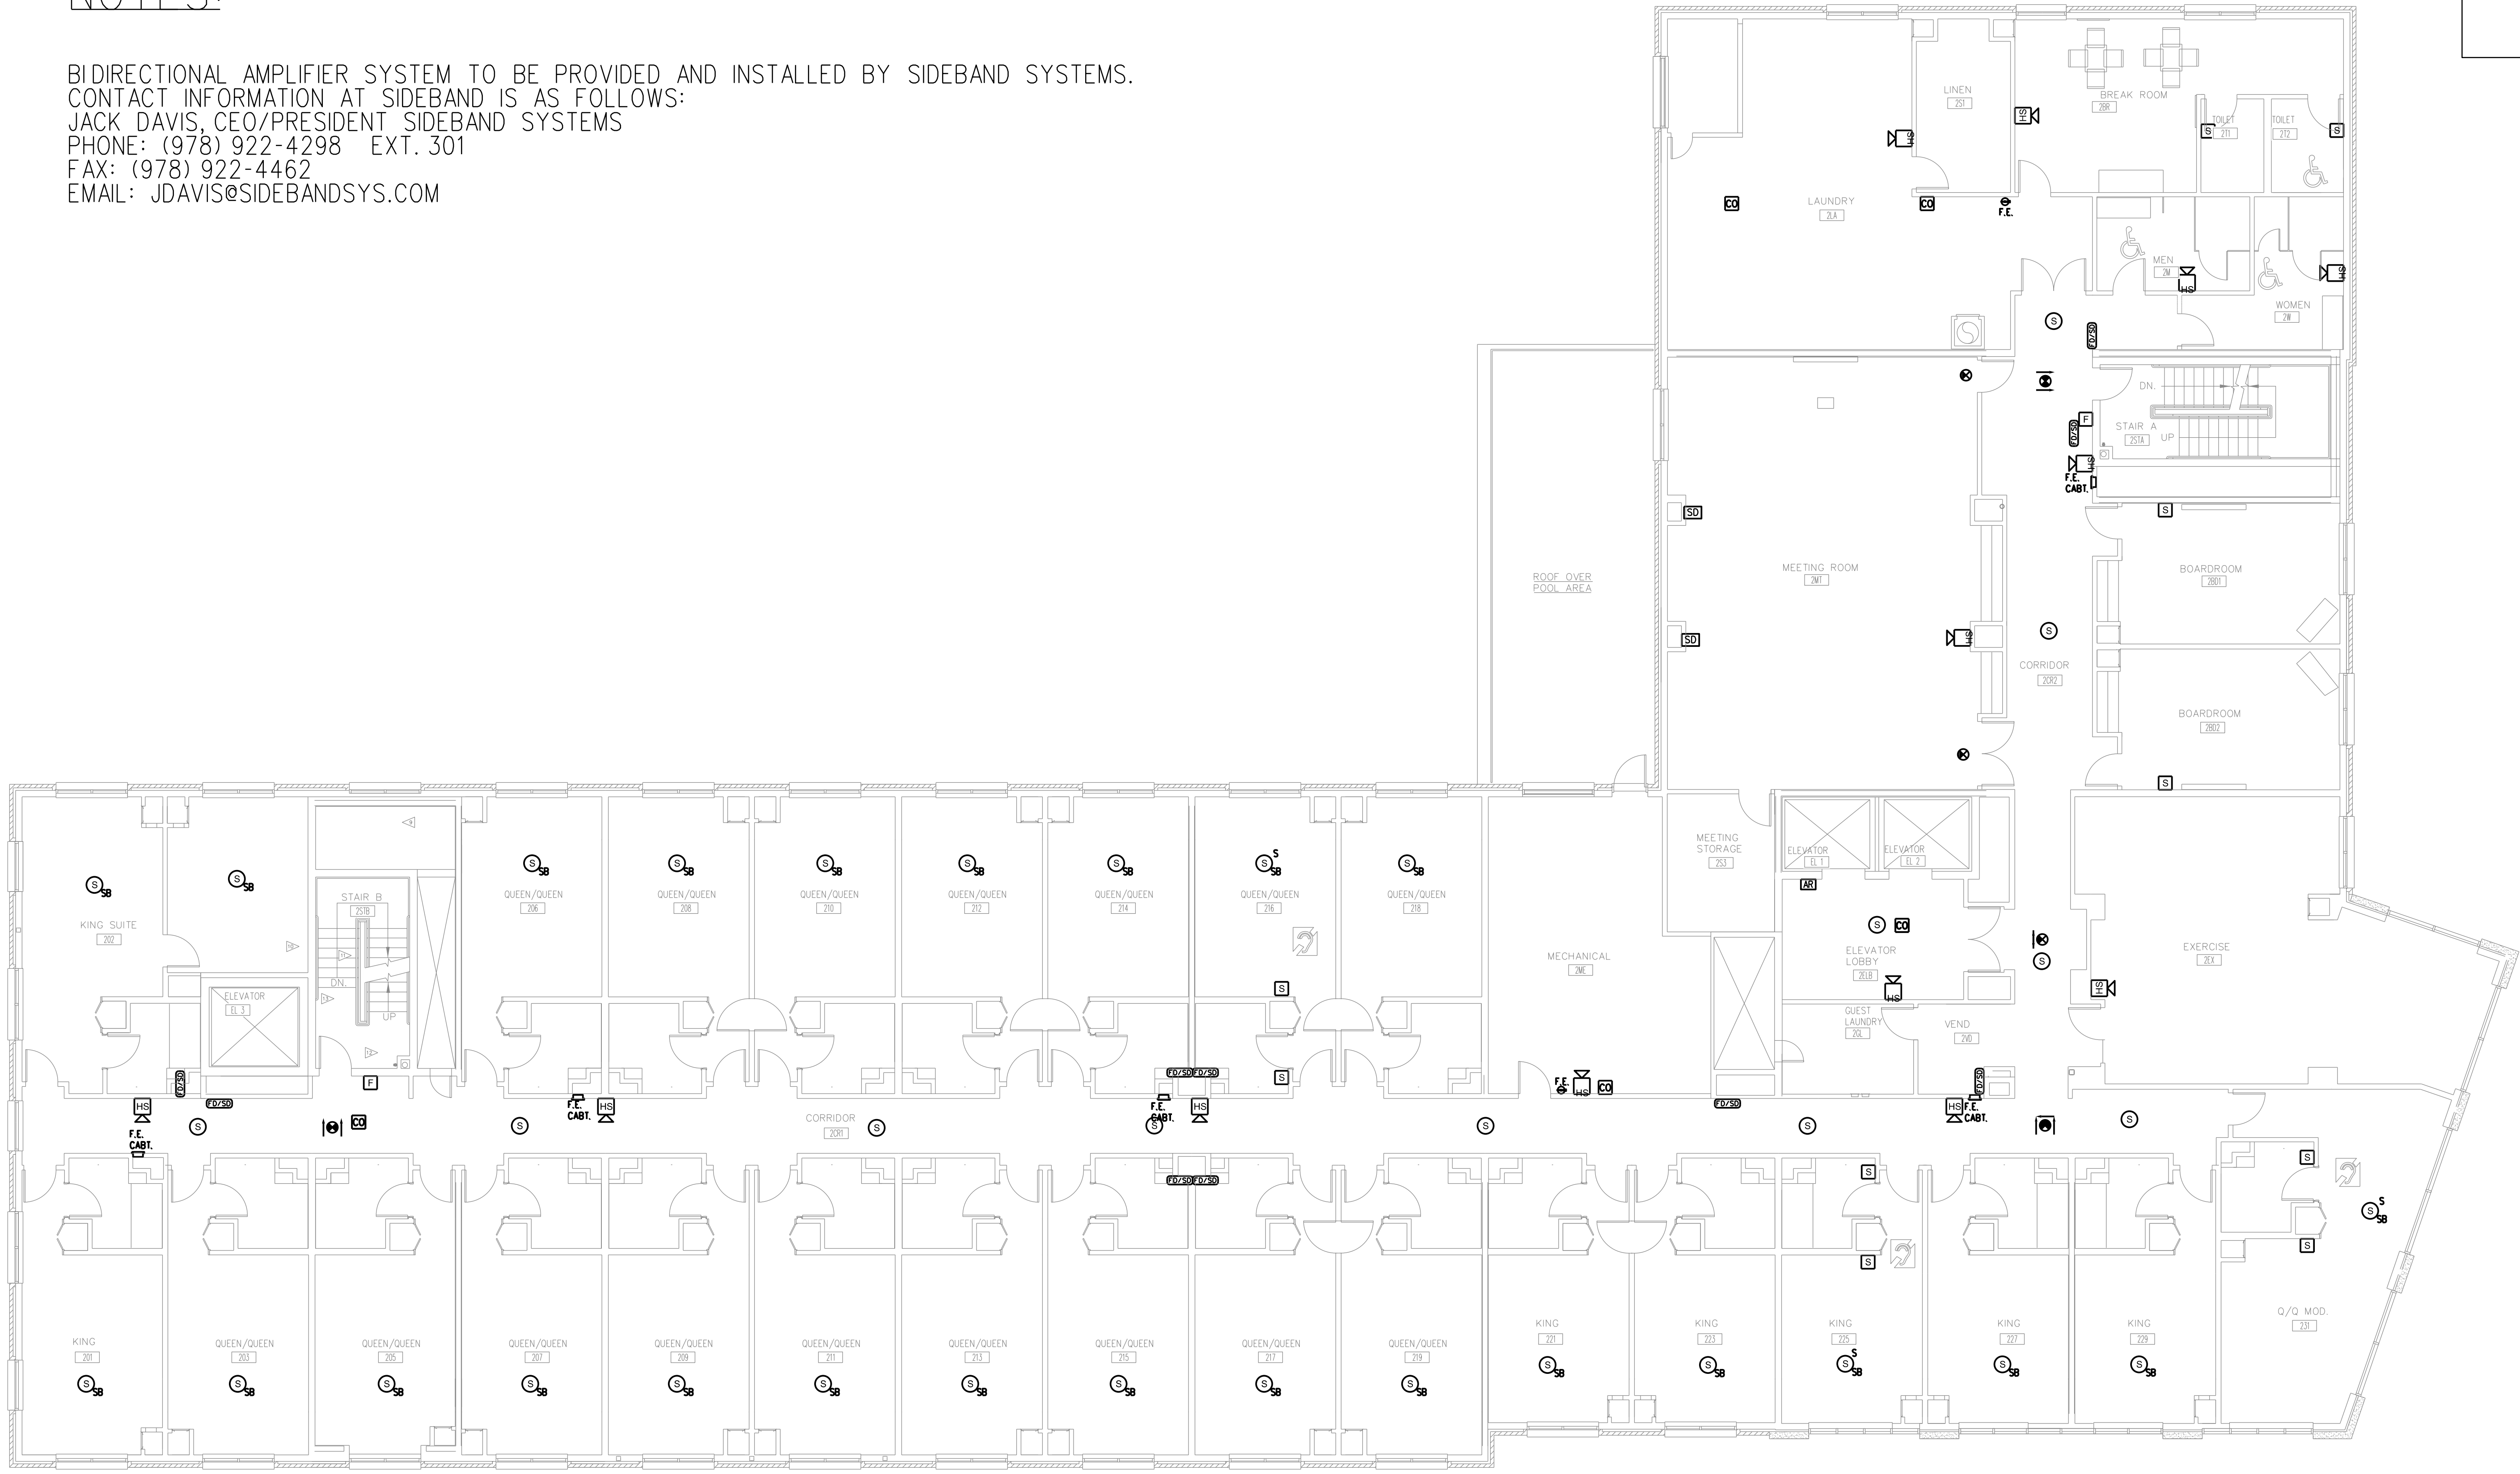

REVISION SCHEDULE REVISION DESCRIPTION	BY	
	DATE	

LOPECHEE
 CONSTRUCTION CORPORATION
 11 CORPORATE DRIVE, BELMONT NH 03220
 PHONE (603) 527-9090 FAX (603) 527-9191

SECOND FLOOR
 FIRE ALARM PLAN

PROJECT: COMMERCIAL &
 MAPLE STREET
 MIXED USE DEVELOPMENT
 PORTLAND, ME.

DATE: 05-20-2013
 SCALE: 1/8" = 1'-0"
 DRAWN BY: PMC

FA2
 SHEET:

1 SECOND FLOOR FIRE ALARM
 FA2 1/8" = 1'-0"