


NOTES:

BIDIRECTIONAL AMPLIFIER SYSTEM TO BE PROVIDED AND INSTALLED BY SIDEBAND SYSTEMS.
 CONTACT INFORMATION AT SIDEBAND IS AS FOLLOWS:
 JACK DAVIS, CEO/PRESIDENT SIDEBAND SYSTEMS
 PHONE: (978) 922-4298 EXT. 301
 FAX: (978) 922-4462
 EMAIL: JDAVIS@SIDEBANDSYS.COM

SIXTH FLOOR UNIT FIRE ALARM NOTES:

1. SUPERVISED CENTRAL SYSTEM ACTIVATION ALL SYSTEM AUDIO/VISUAL AND VISUAL ONLY DEVICES SHALL ALARM.
2. WHEN UNIT SMOKE DETECTOR GOES INTO ALARM ALL SINGLE STATION AUDIO/VISUAL AND VISUAL ONLY DEVICES WITHIN THAT UNIT WILL ACTIVATE. THIS WILL NOT ACTIVATE THE ENTIRE BUILDING SYSTEM.
3. THE WALL MOUNTED HORN/STROBES WITHIN THE LIVING UNITS SHALL BE CONNECTED TO THE SUPERVISED CENTRAL SYSTEM.
4. INTERCONNECT ALL 120 VOLT SINGLE STATION SMOKE DETECTORS WITHIN EACH LIVING UNIT. ALL INTERCONNECTED SMOKE DETECTORS SHALL BE ON THE SAME CIRCUIT FOR PROPER OPERATION. REFER TO MANUFACTURER'S INSTALLATION MANUAL AND MOUNT DETECTORS IN ACCORDANCE WITH MANUFACTURER'S RECOMMENDATIONS.
5. CARBON MONOXIDE DETECTORS (120V) IN RESIDENCES SHALL BE INSTALLED AT LEAST 10 FEET FROM ANY HEAT SOURCE.
6. INTERCONNECT ALL 120 VOLT CARBON MONOXIDE (CO) DETECTORS WITHIN EACH LIVING UNIT. ALL INTERCONNECTED CO DETECTORS SHALL BE ON THE SAME CIRCUIT FOR PROPER OPERATION. REFER TO MANUFACTURER'S INSTALLATION MANUAL AND MOUNT DETECTORS IN ACCORDANCE WITH MANUFACTURER'S RECOMMENDATIONS. CO DETECTORS SHALL HAVE AN ALARM SOUND THAT IS DIFFERENT THAN THE LIVING UNIT SMOKE DETECTORS AND FIRE ALARM SYSTEM ALARMS.
- AUDIBLE ALARM Db LEVELS SHALL COMPLY WITH NFPA 72.
8. A/V DEVICES IN BEDROOMS SHALL BE 75db AND 15 Cd. STROBES SHALL BE 110 Cd FOR HEARING IMPAIRED.

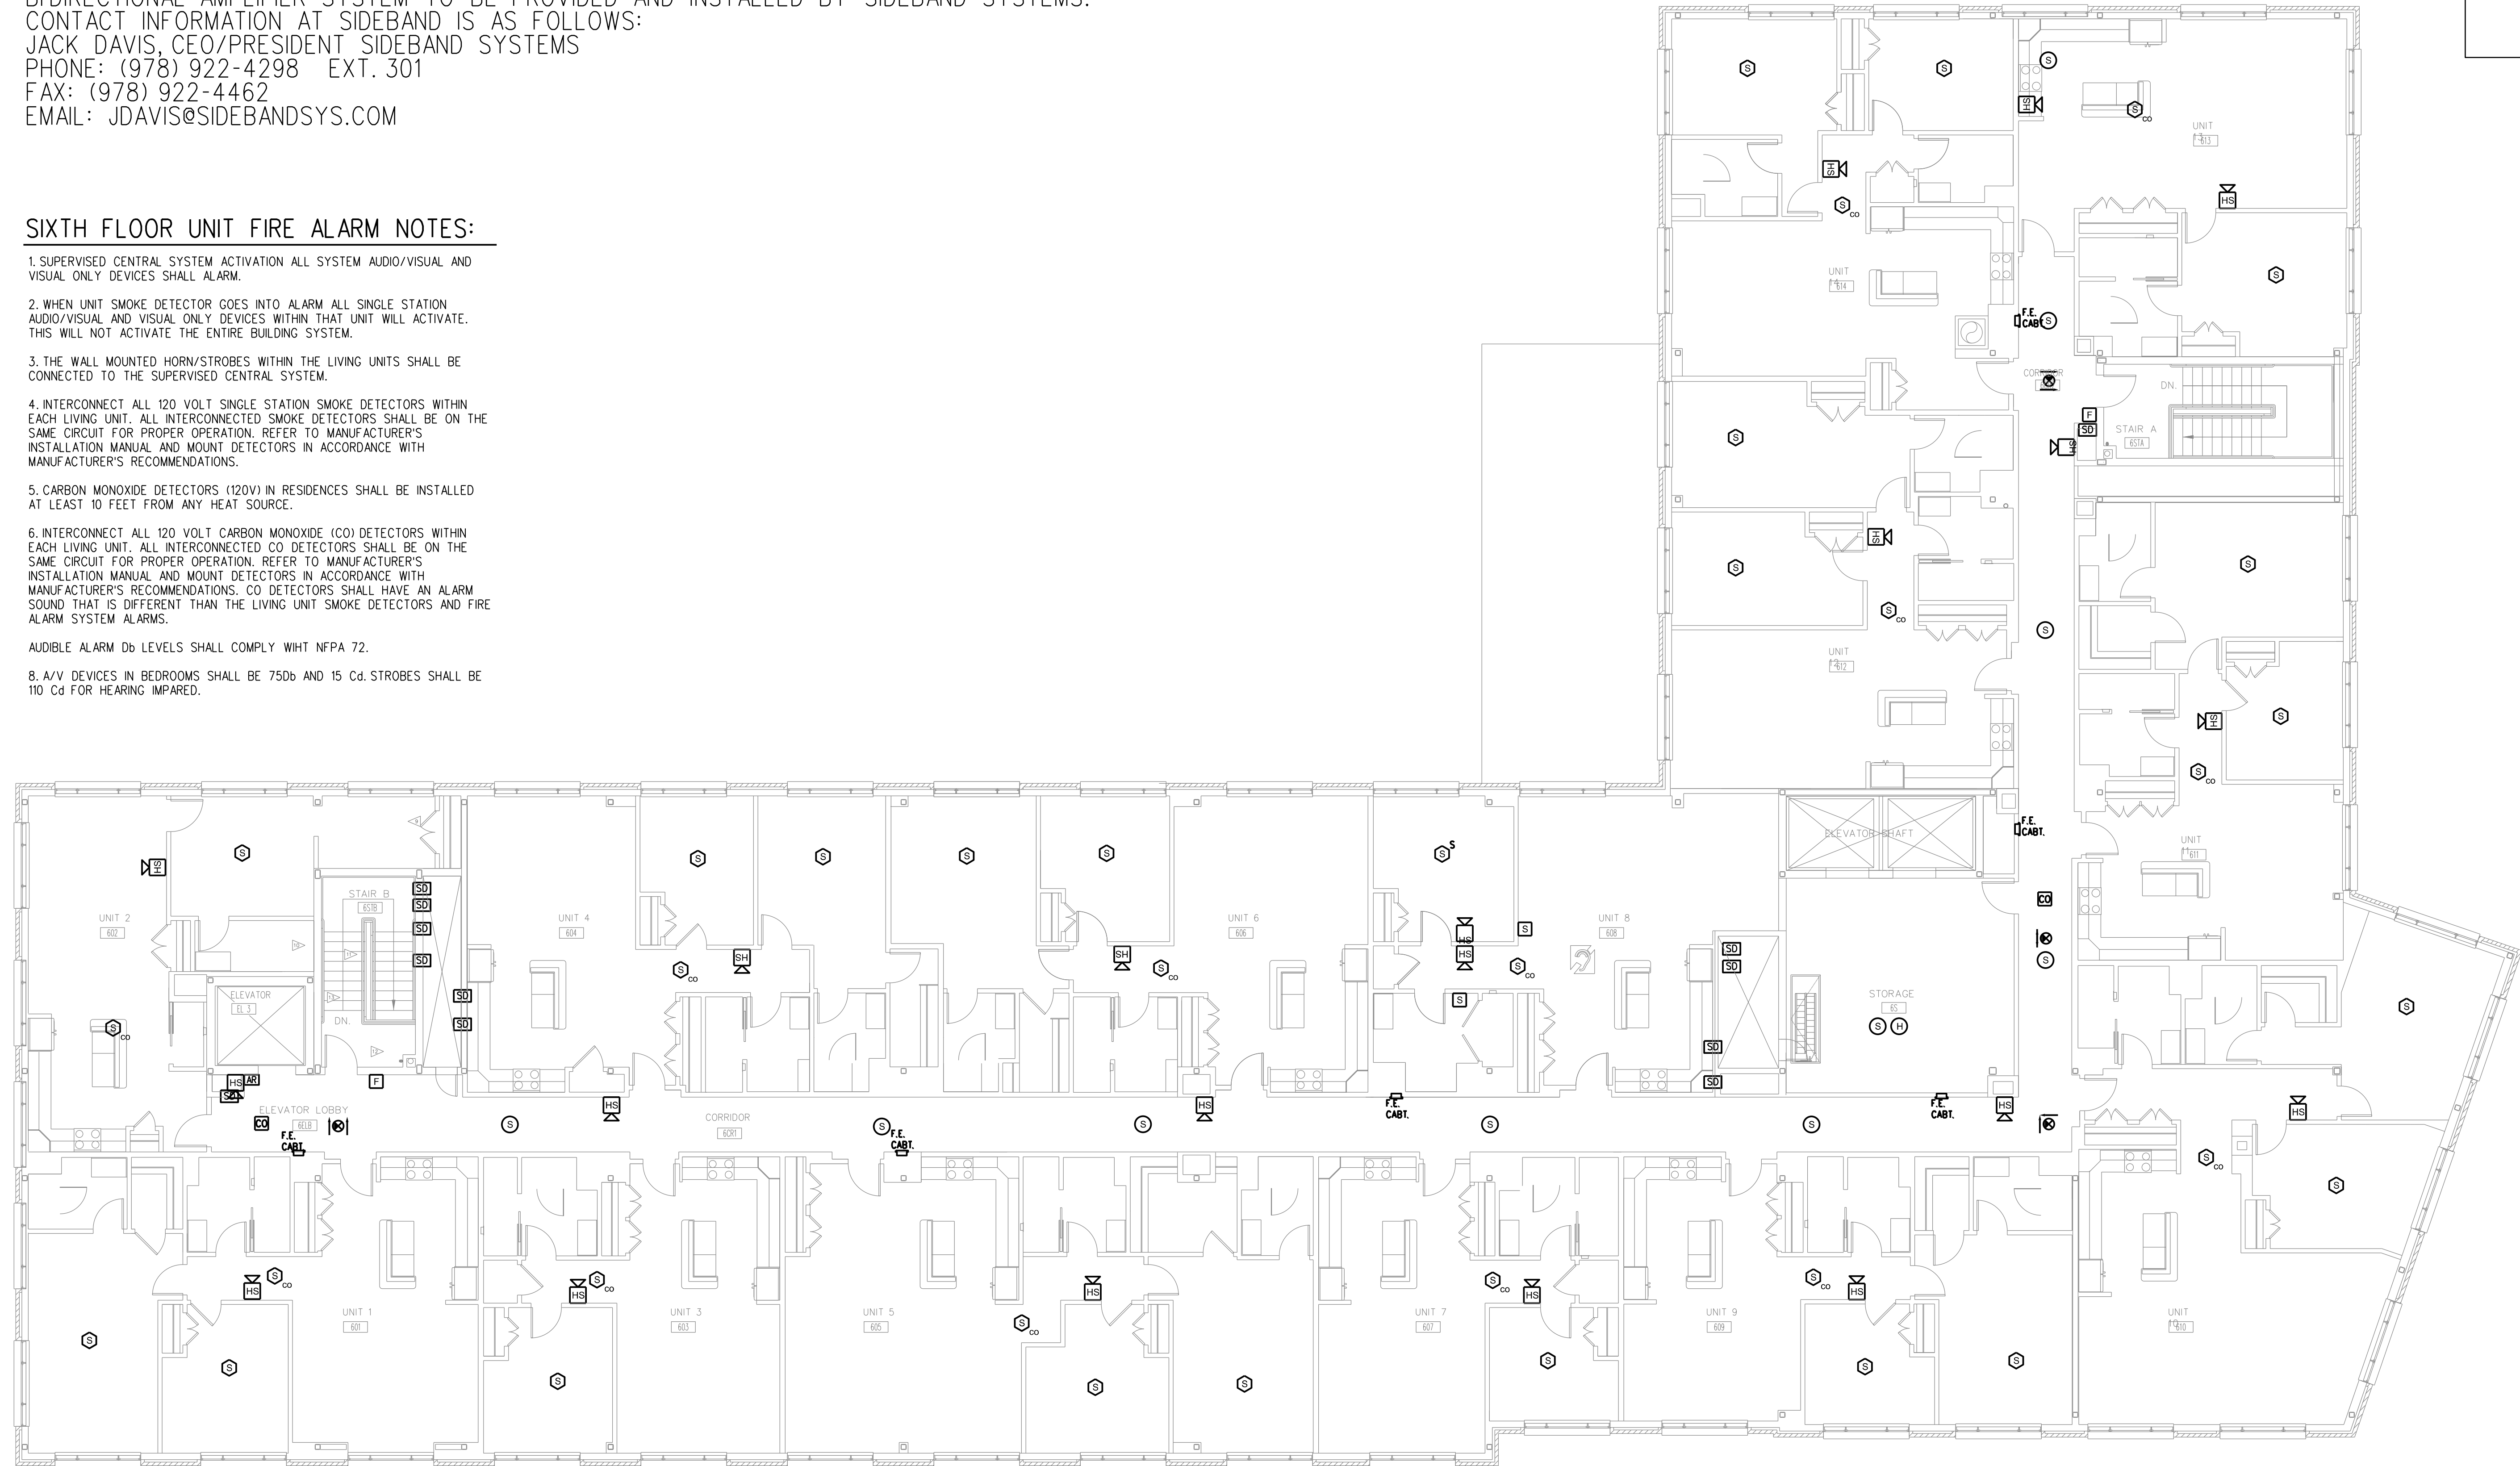

BENNETT ENGINEERING
 MECHANICAL • ELECTRICAL
 (207) 865-9475

REVISION	SCHEDULE	REVISION DESCRIPTION	DATE	BY

LOPECHEE
 CONSTRUCTION CORPORATION
 11 CORPORATE DRIVE, BELMONT NH 03220
 PHONE (603) 527-9090 FAX (603) 527-9191

**SIXTH FLOOR
 FIRE ALARM PLAN**

**PROJECT: COMMERCIAL &
 MAPLE STREET
 MIXED USE DEVELOPMENT
 PORTLAND, ME.**

DATE: 05-20-2013
 SCALE: 1/8" = 1'-0"
 DRAWN BY: PMC

FA6
 SHEET:

1 SIXTH FLOOR FIRE ALARM
 FA6 1/8" = 1'-0"