

REVISION	SCHEDULE	REVISION DESCRIPTION


OPEGCHGE
CONSTRUCTION CORPORATION
11 CORPORATE DRIVE, BELMONT, NH 03220
PHONE: (603) 527-9000 FAX: (603) 527-9191

SECOND FLOOR PLAN
HVAC PLAN


PROJECT: **COMMERCIAL & MAPLE STREET MIXED USE DEVELOPMENT**
PORTLAND, ME.

DATE: 05-2013
SCALE: 1/8" = 1'-0"
DRAWN BY:
SHEET: M2

PROGRESS PRINT
NOT FOR CONSTRUCTION

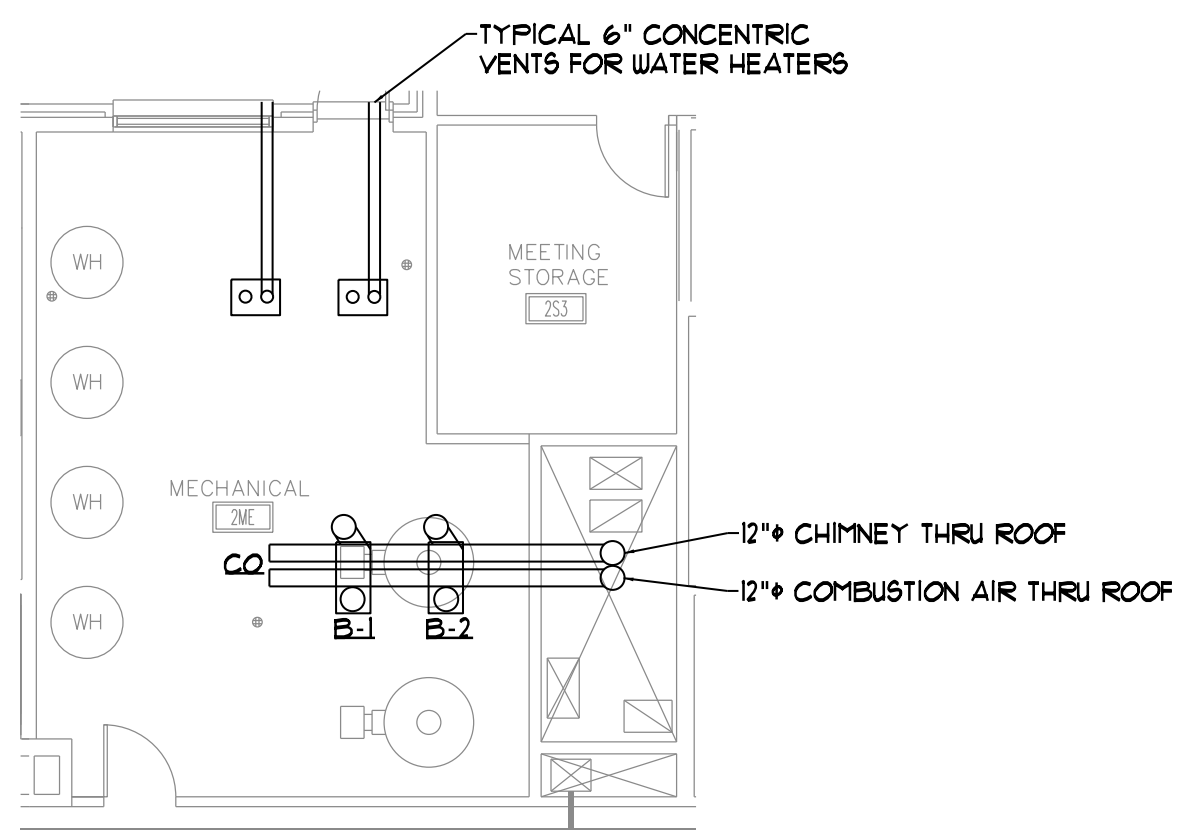

MECHANICAL ROOM PART PLAN
SCALE: 1/8" = 1'-0"

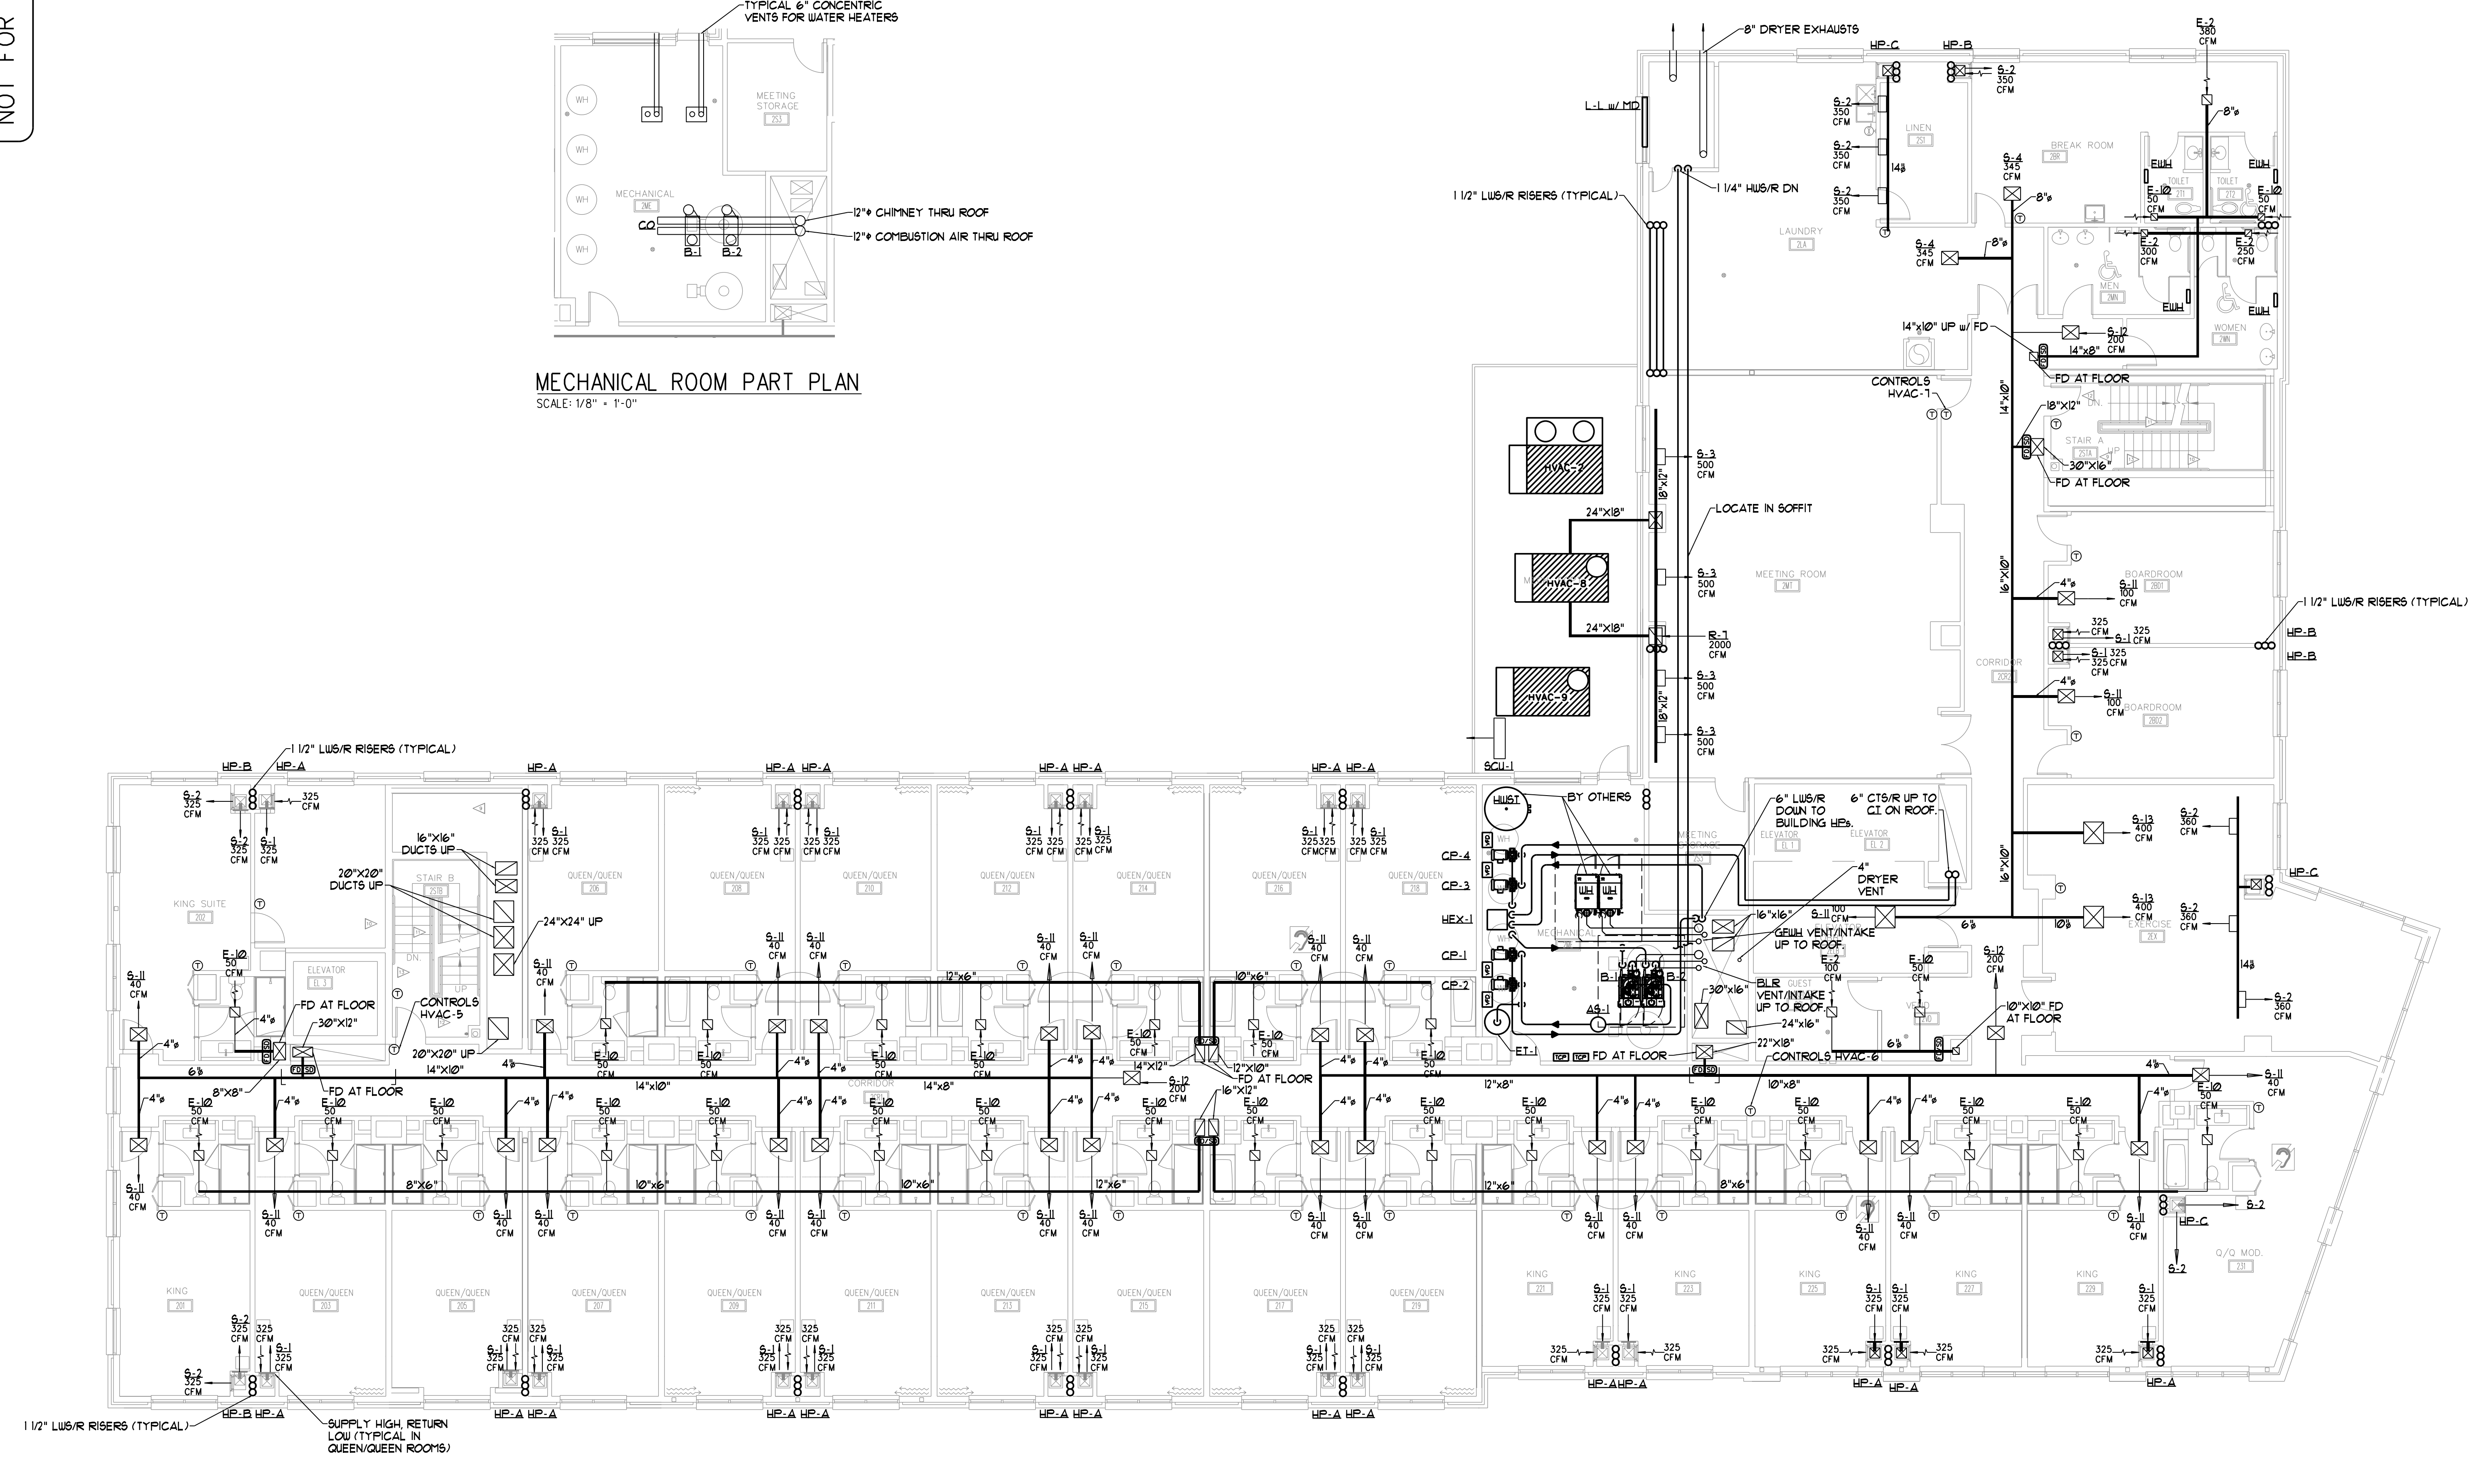

SECOND FLOOR PLAN
SCALE: 1/8" = 1'-0"