

PROGRESS PRINT  
NOT FOR CONSTRUCTION

| REVISION | SCHEDULE | REVISION DESCRIPTION |
|----------|----------|----------------------|
|          |          |                      |
|          |          |                      |
|          |          |                      |
|          |          |                      |


**OPENEDGE**  
CONSTRUCTION CORPORATION  
11 CORPORATE DRIVE, BELMONT, NH 03220  
PHONE: (603) 527-9090 FAX: (603) 527-9191

# SIXTH FLOOR HVAC PLAN

PROJECT: **COMMERCIAL & MAPLE STREET MIXED USE DEVELOPMENT**  
PORTLAND, ME.

DATE: 05-2013  
SCALE: 1/8" = 1'-0"  
DRAWN BY: **M4**

COPYRIGHT 2012 BY O.C.C.

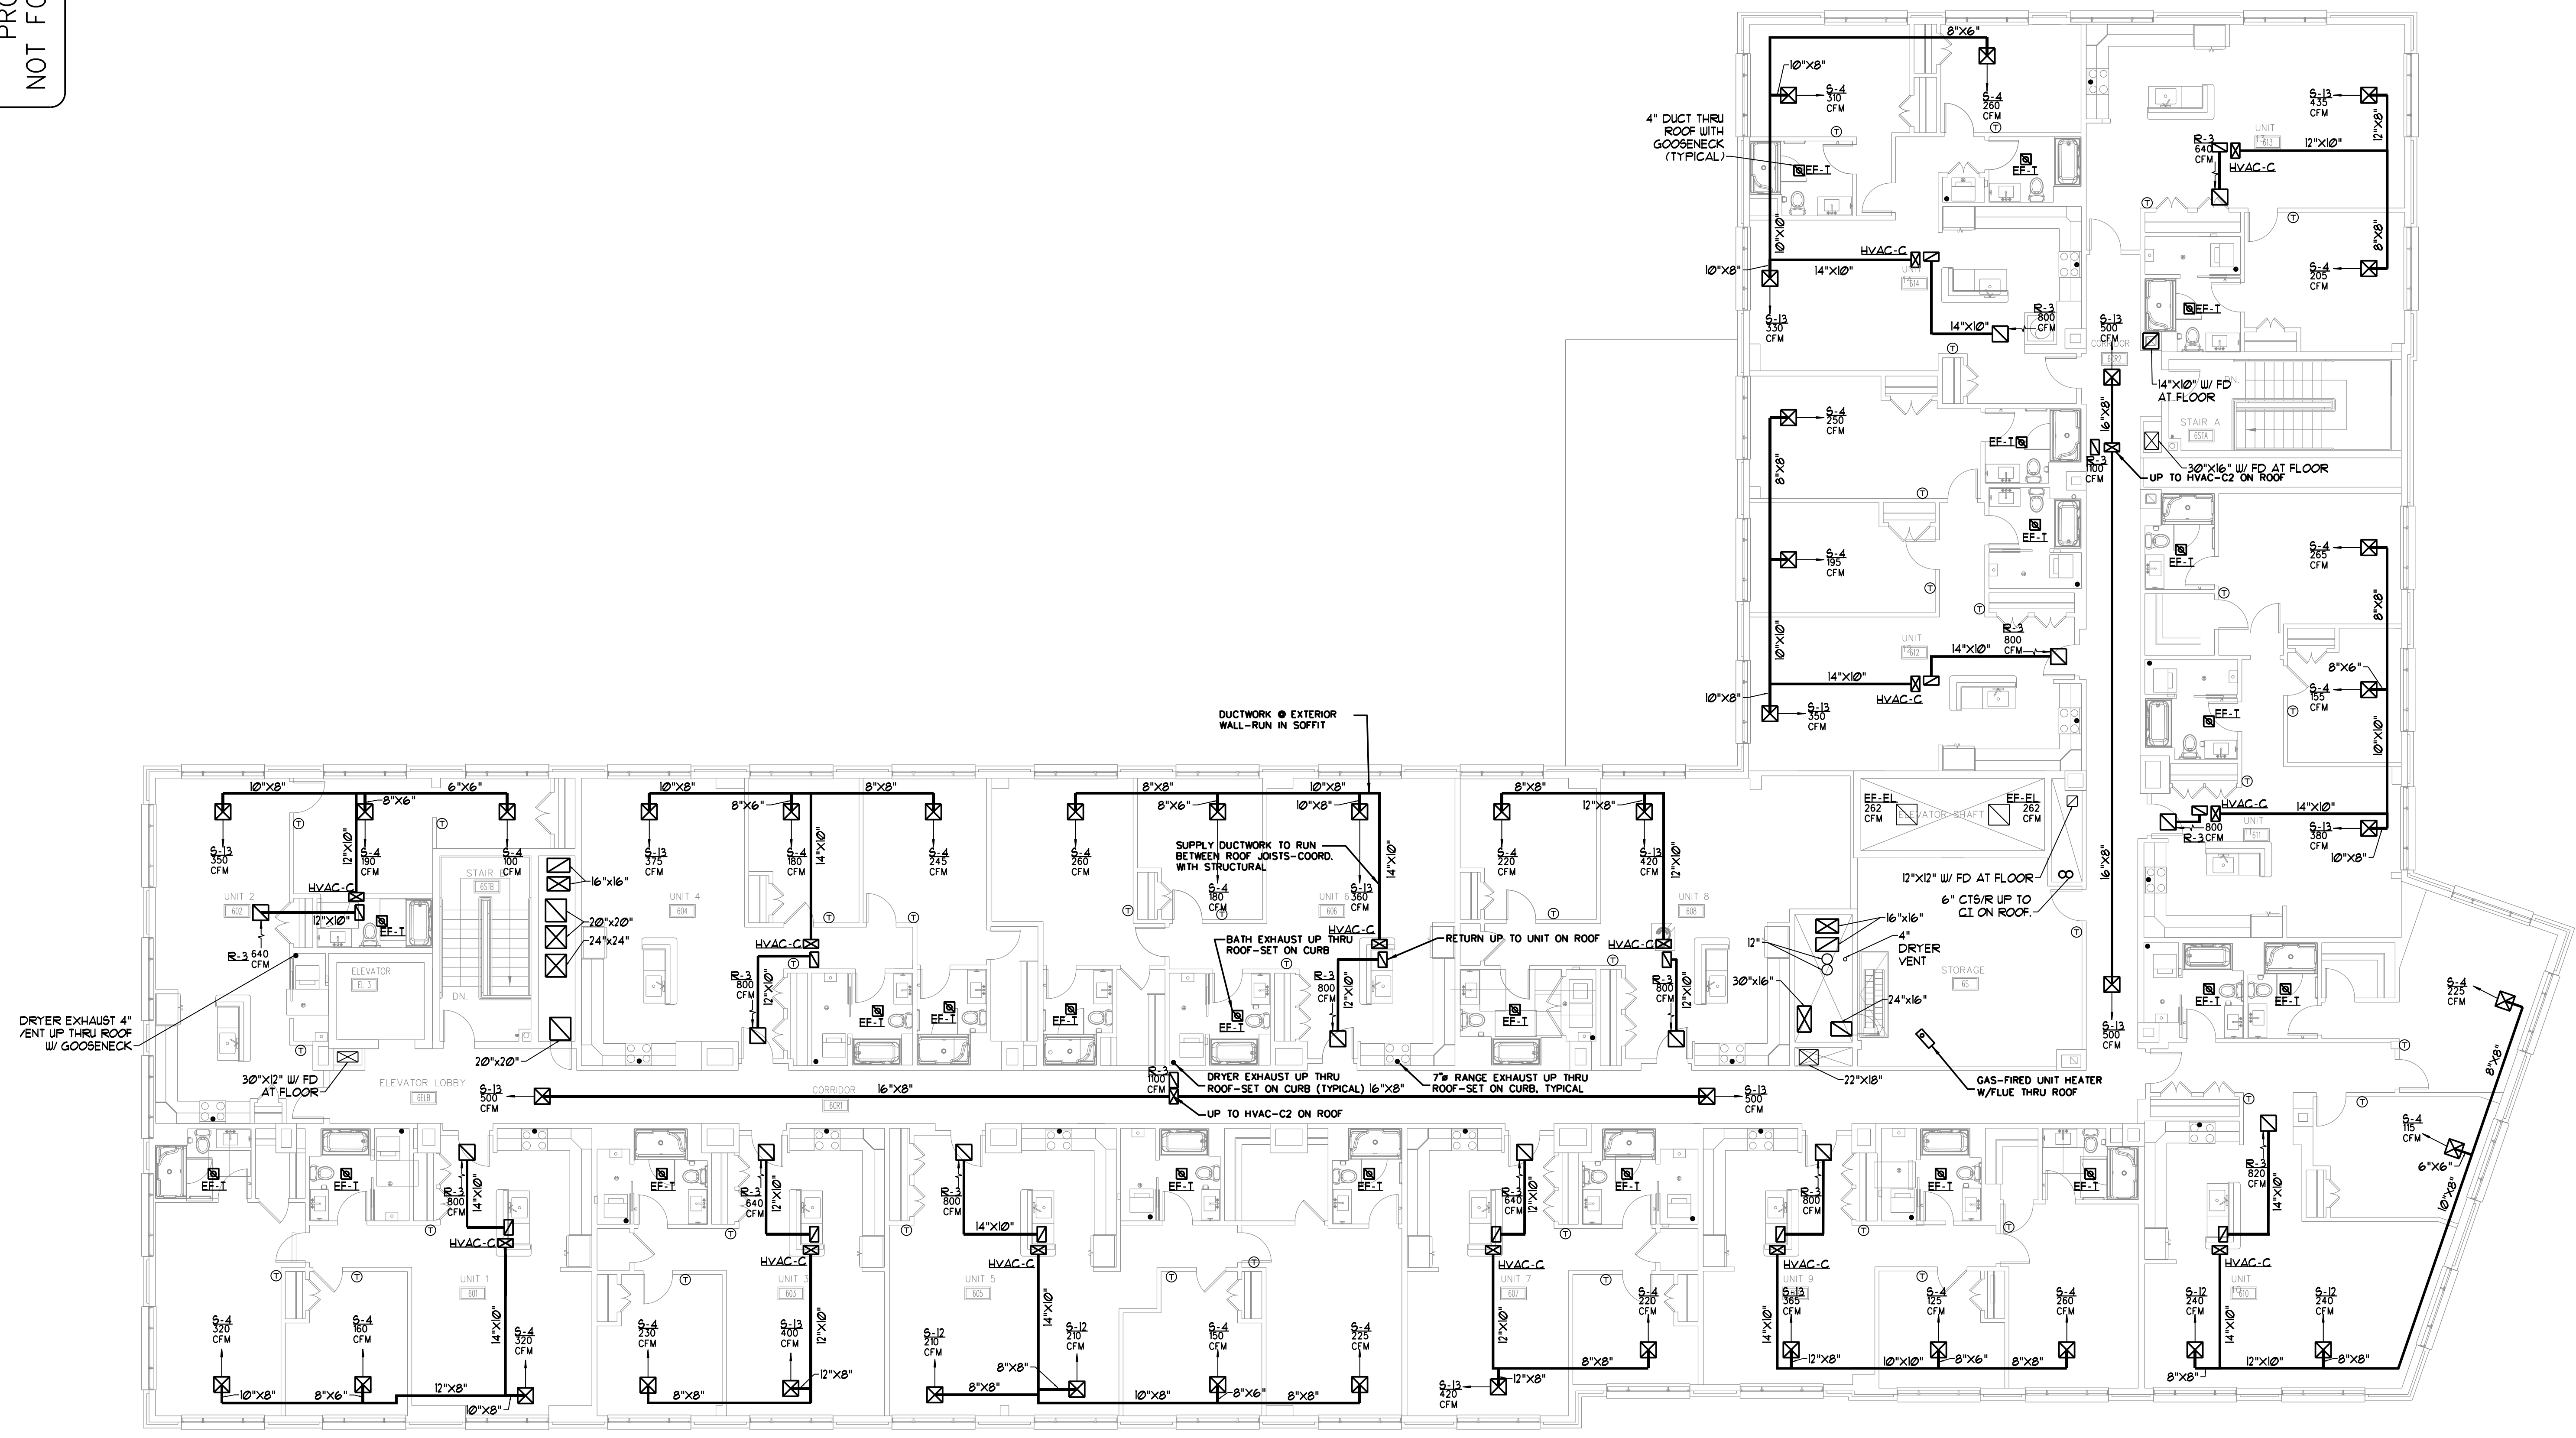

SIXTH FLOOR PLAN  
SCALE: 1/8" = 1'-0"