



CLIENT LOGO

STAMP

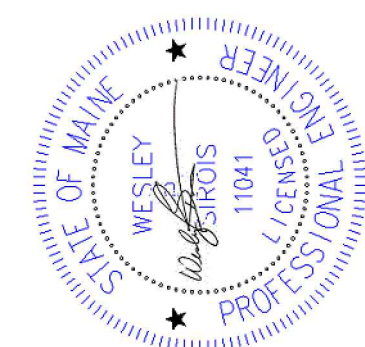

DISCLAIMER

THIS SERIES OF DRAWINGS HAS BEEN PREPARED BY UPONOR USA, INC. OR ITS AFFILIATES. UPONOR HAS REVIEWED AND APPROVED THE DESIGN AND CONSTRUCTION OF THE PUMP, VALVES, AND PIPING SYSTEMS SHOWN HEREON. UPONOR HAS CONDUCTED VISUAL CHECKS OF THE DRAWINGS AND HAS FOUND THEM TO BE IN ACCORDANCE WITH THE DESIGN AND CONSTRUCTION STANDARDS OF DESIGN AND CONSTRUCTION. BEFORE STARTING ALL WORK, THE CONTRACTOR SHALL VERIFY THE ACCURACY OF ALL DIMENSIONS, MATERIALS, PLUMBING AND/OR FIRE CODES. THE CONTRACTOR SHALL BE RESPONSIBLE FOR OBTAINING ALL NECESSARY PERMITS AND FOR OBTAINING THE DESIGN REVIEW FROM THE LOCAL AUTHORITY HAVING JURISDICTION. UPONOR SHALL NOT BE RESPONSIBLE FOR THE DESIGN REVIEW. UPONOR SHALL NOT BE RESPONSIBLE FOR THE DESIGN REVIEW. UPONOR SHALL NOT BE RESPONSIBLE FOR THE DESIGN REVIEW. UPONOR SHALL NOT BE RESPONSIBLE FOR THE DESIGN REVIEW.

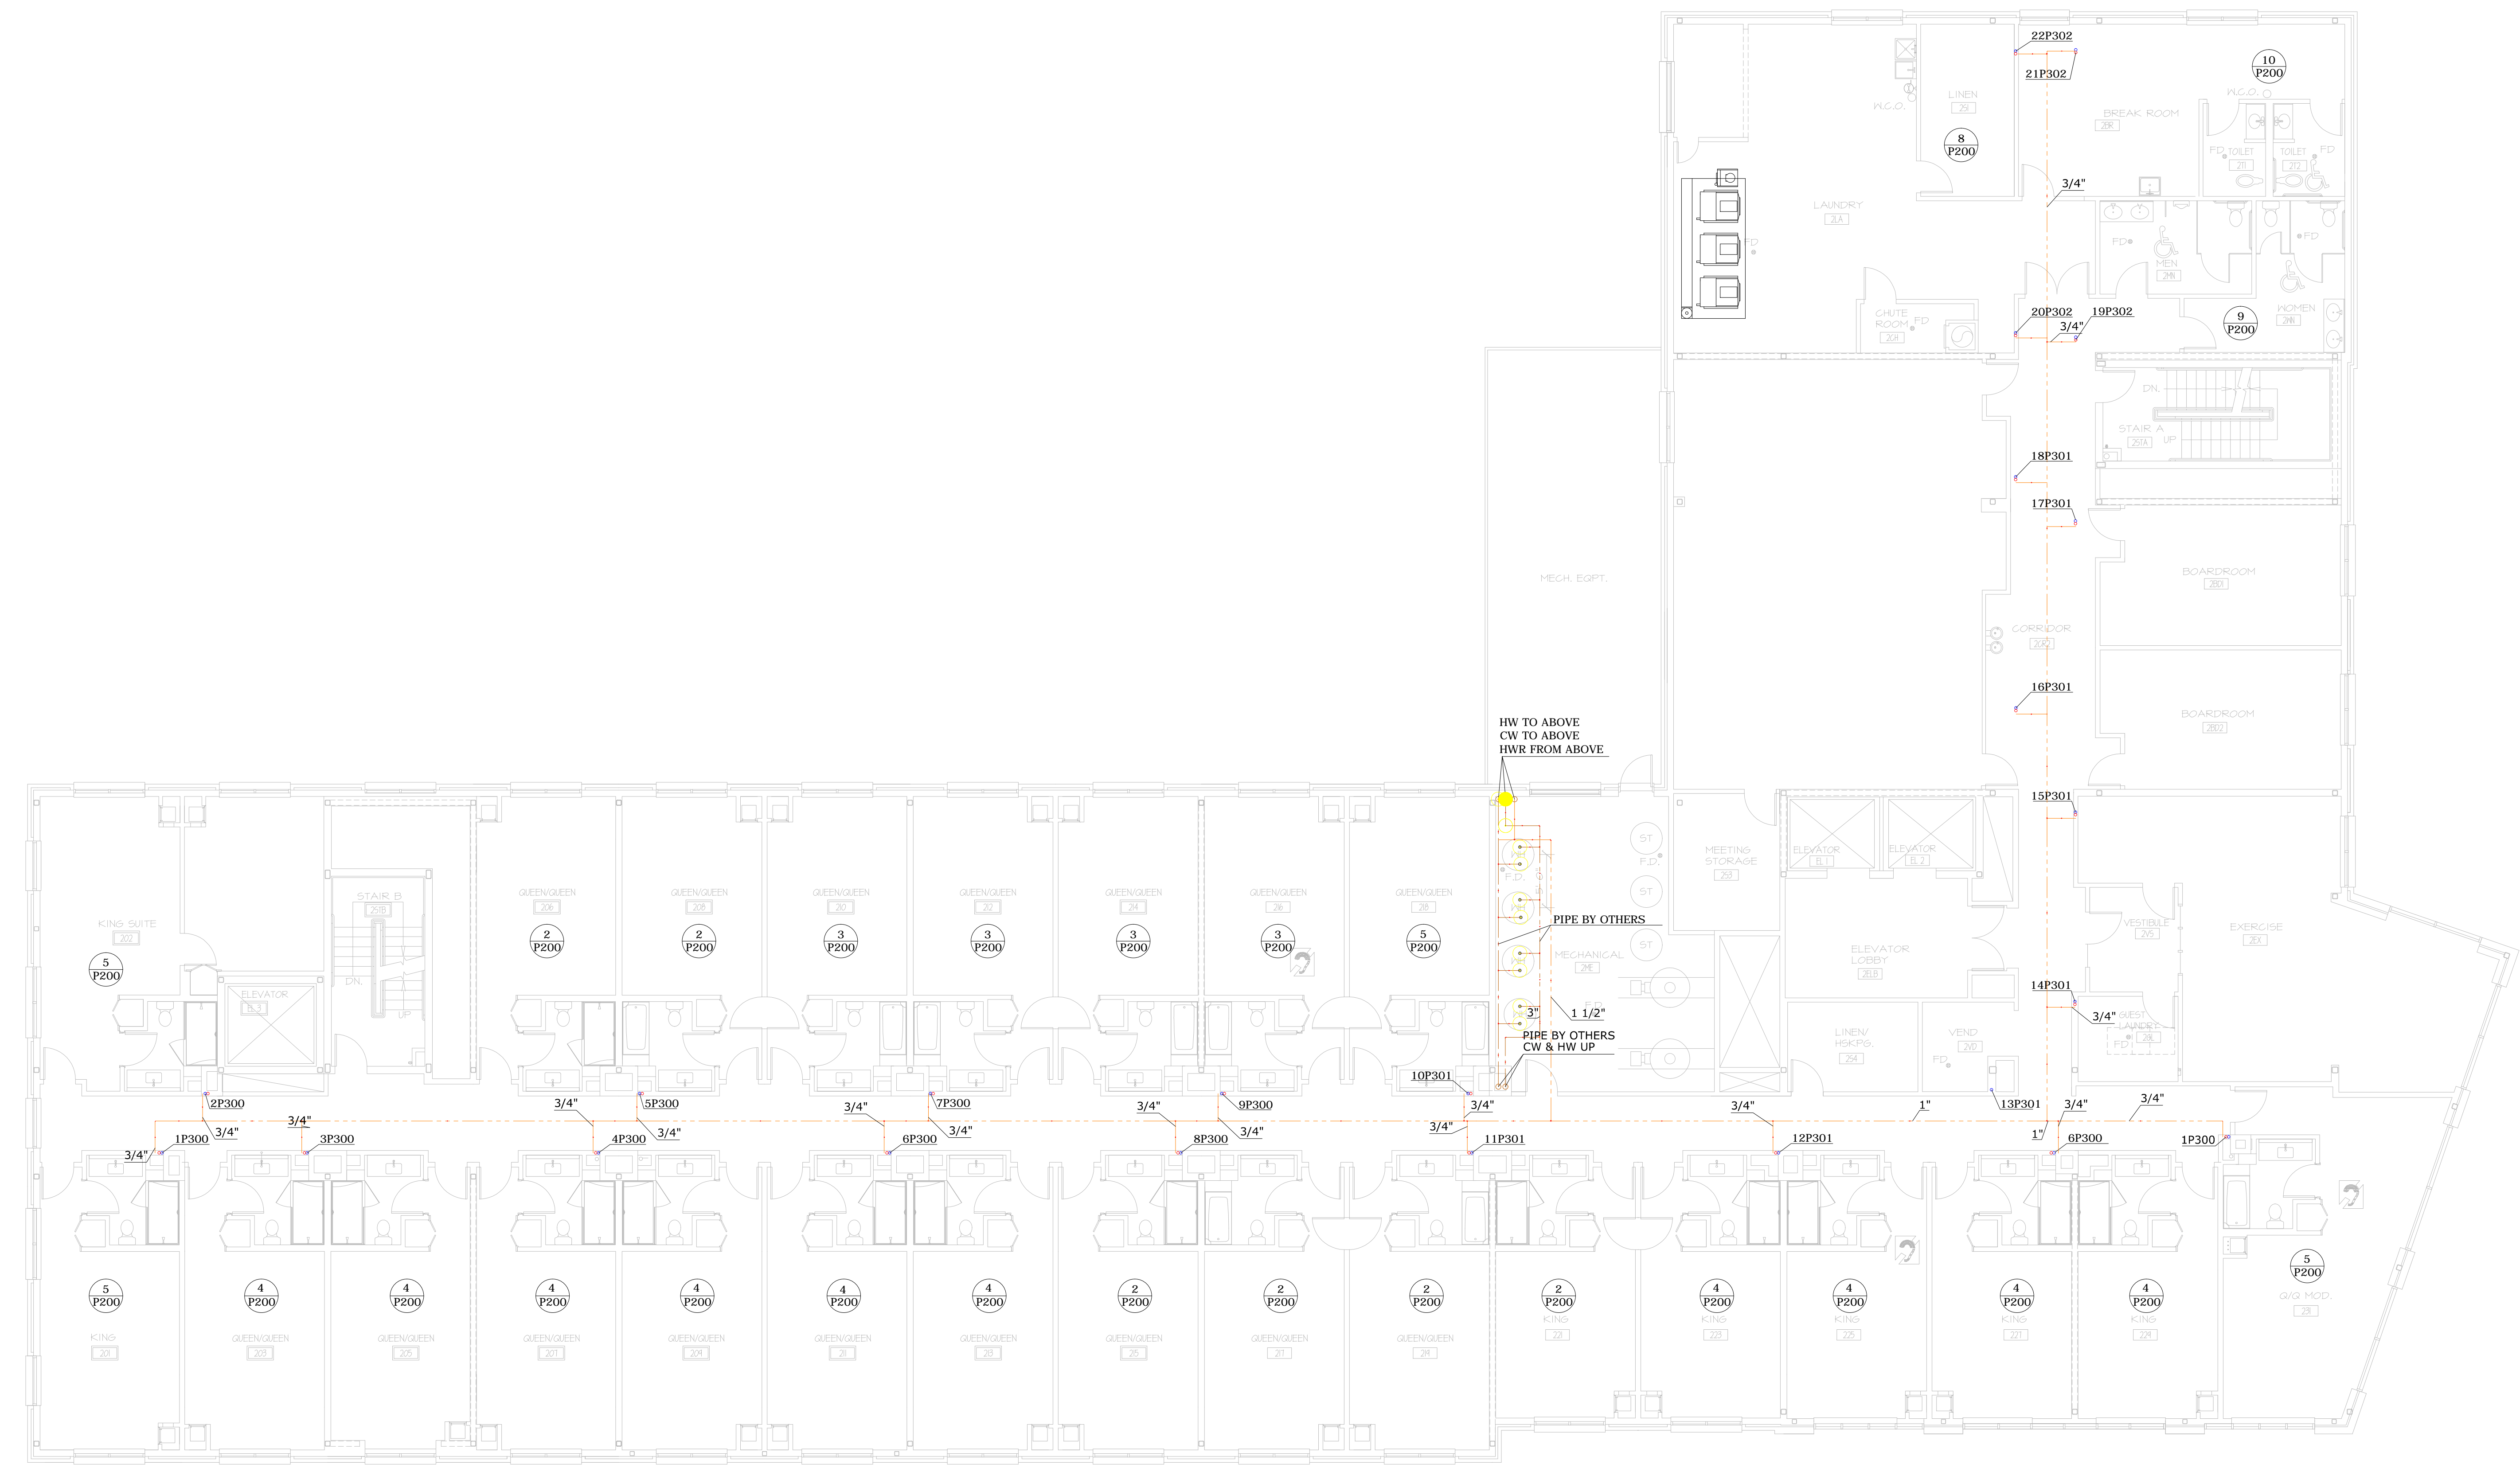

**MARRIOTT COURTYARD-PORTLAND
 COMMERCIAL & MAPLE STREET
 PORTLAND, ME**

REVISIONS CONTINUED		REVISIONS CONTINUED	
NO.	DATE	NO.	DATE

SHEET DESCRIPTION
 SECOND FLOOR PLAN

SHEET NUMBER

P101

1 SECOND FLOOR PLAN
 P101 1/8" = 1'-0"