



Consultants

Revisions

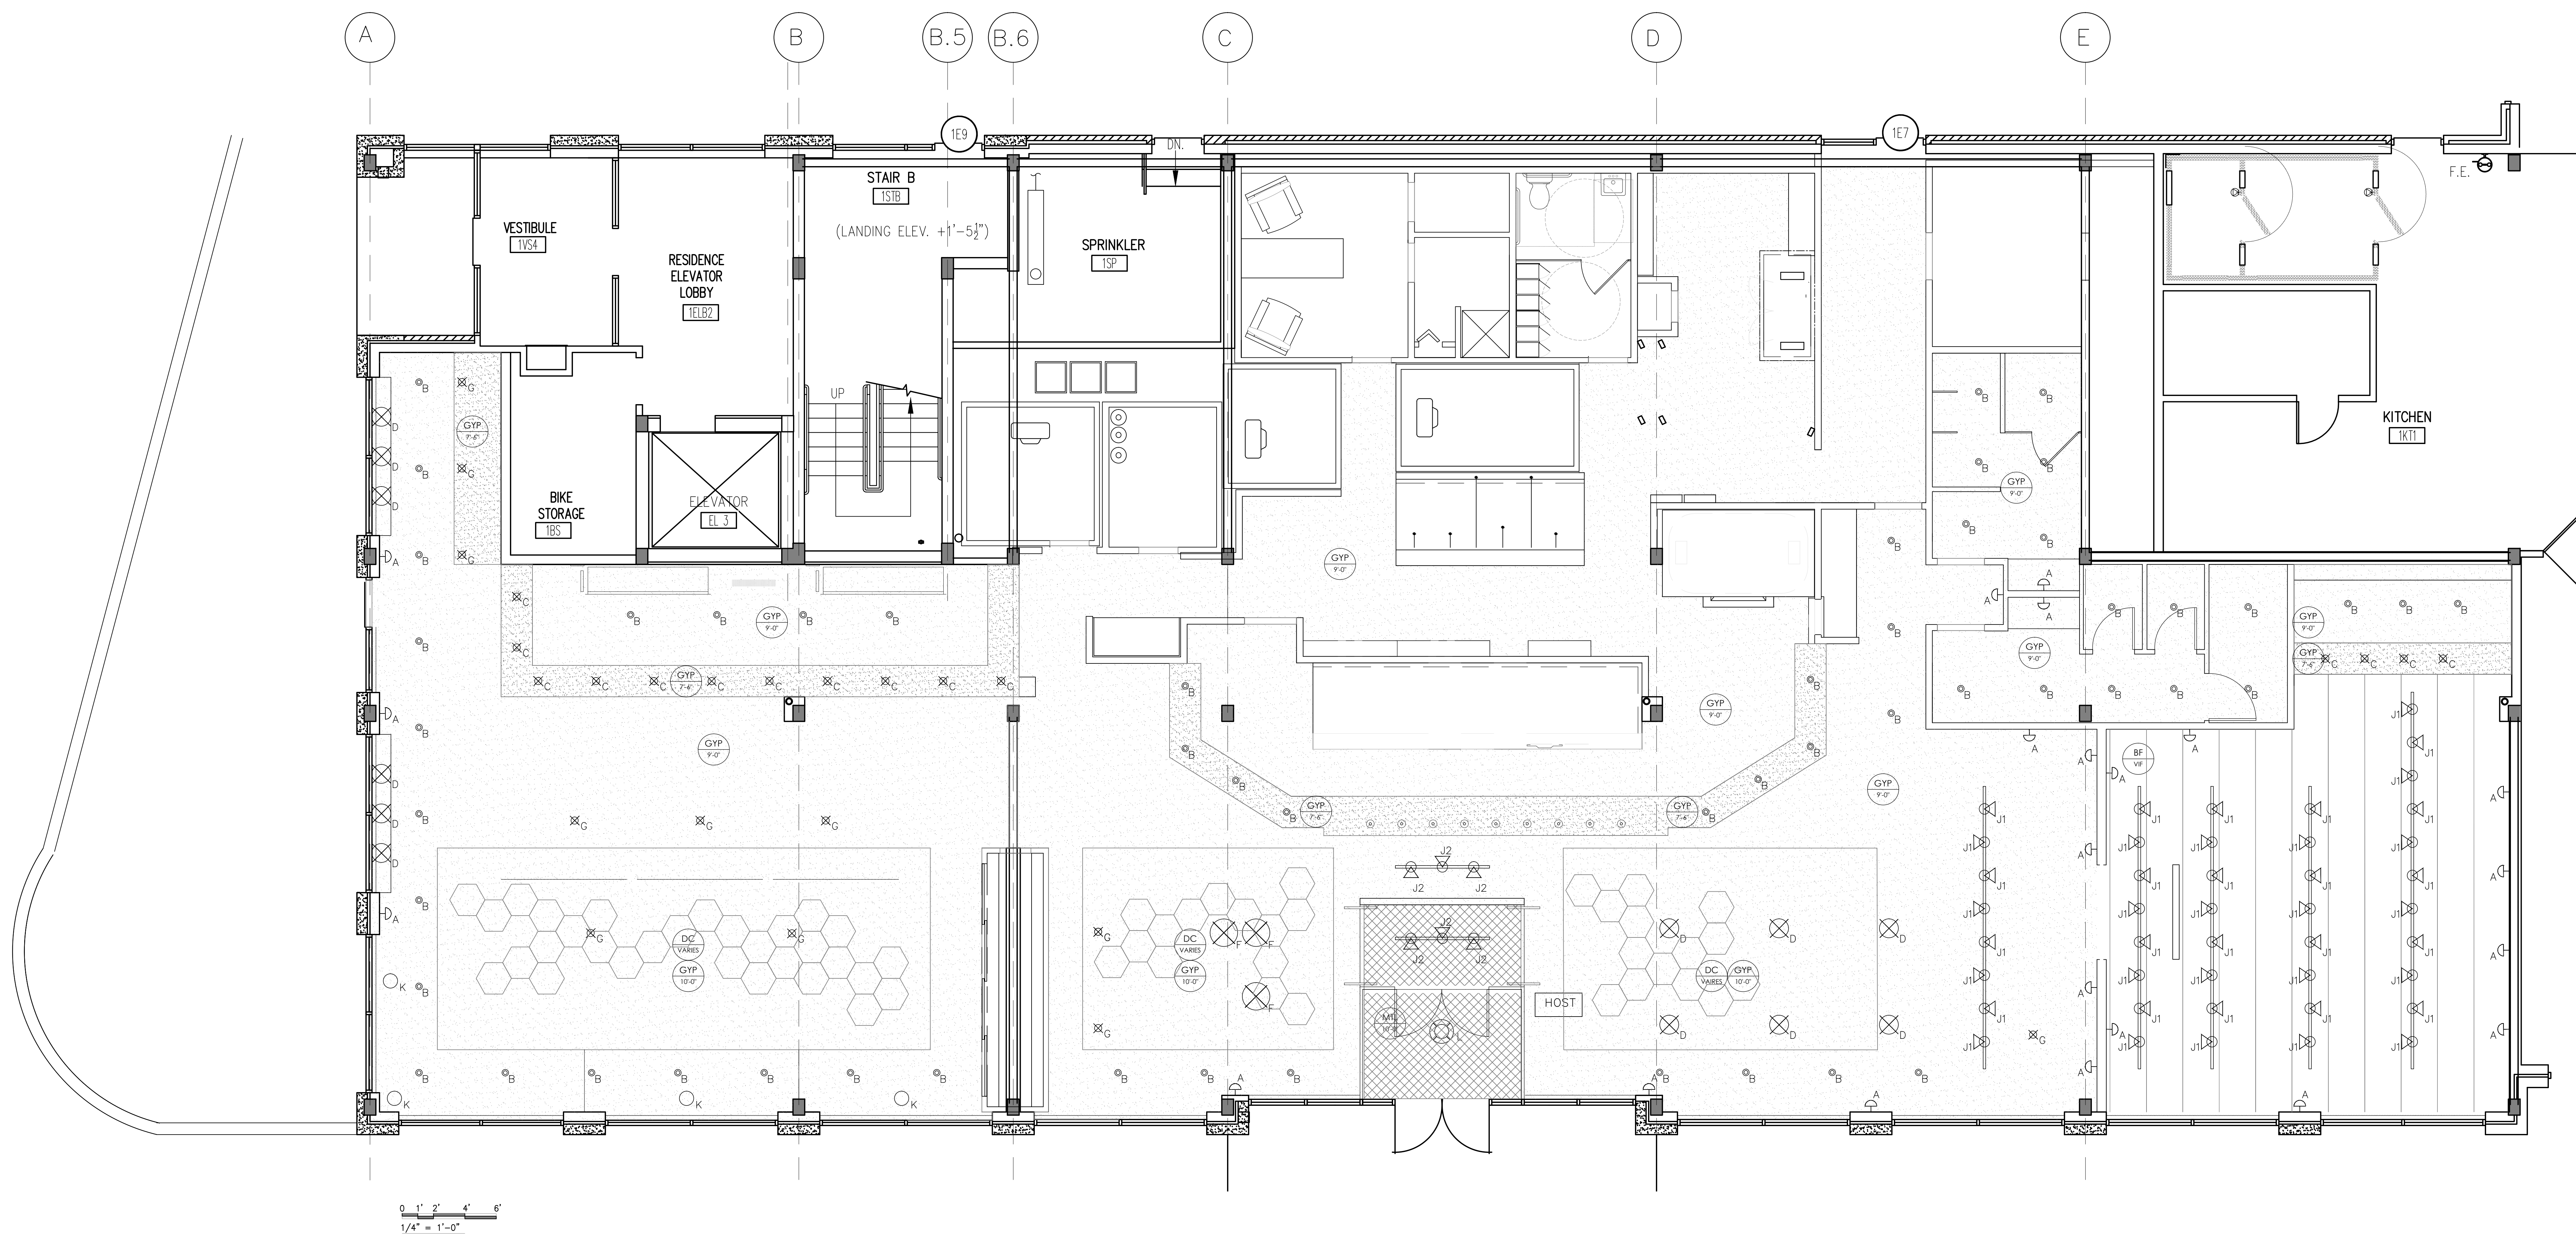


1 GROUND FLOOR REFLECTED CEILING PLAN
Scale: 1/4"=1'-0"


REFLECTED CEILING PLAN LEGEND	
(Symbol)	SYMBOL DENOTES COLUMN LINE NUMBER OR LETTER
(Symbol)	NEW GYP. 8D CEILING
(Symbol)	NEW 24"x24" DECORATIVE CEILING PANELS BY BUZZSPACE: BUZZLE 30 HEXA; MOUNTED AT VARYING HEIGHTS, COORDINATE WITH INTERIOR DESIGNER
(Symbol)	NEW PERFORATED METAL
(Symbol)	NEW CUSTOM HANGING PANEL OF FRITZELT; COLOR 408, 10 MM, HUNG FROM CEILING, LENGTHS TO VARY SEE ELEVATION 4/A-2
(Symbol)	NEW WALL SCONCE LIGHT FIXTURE BY ARTERIORS: SAHARA SCONCE, 46651
(Symbol)	NEW 3" LED RECESSED DOWN LIGHT BY WAC LIGHTING: HR-LED309-4-W
(Symbol)	NEW PENDANT LIGHT FIXTURE BY ARTERIORS: TRESOR OCTAGONAL PENDANT, DK42056
(Symbol)	NEW PENDANT LIGHT FIXTURE BY ARTERIORS: CHAINMAIL PENDANT, DK42043
(Symbol)	NEW PENDANT LIGHT FIXTURE BY ARTERIORS: EDOM PENDANT, 44057
(Symbol)	NEW LIGHT FIXTURE BY TECH LIGHTING: BRIOLETTE LOW VOLTAGE HS49-AM
(Symbol)	NEW TRACK LIGHT FIXTURE WITH PENDANT LIGHTS, SPEC TBD
(Symbol)	NEW WAC TRACK LIGHTING, H-SERIES: HB-DB LIGHT FIXTURE TRACK WITH LEDMIE TRACK LUMINAIRE WITH 24" STEM
(Symbol)	NEW WAC TRACK LIGHTING, H-SERIES: HB-DB LIGHT FIXTURE TRACK WITH LEDMIE TRACK LUMINAIRE WITH 24" STEM
(Symbol)	NEW FLOOR LAMP BY LITE SOURCE, REAVE, LS-82213
(Symbol)	NEW CHANDELIER BY RESTORATION: FRENCH EMPIRE CHANDELIER, 21" PEWTER
(Symbol)	NEW HEAT LAMPS, COORDINATE WITH KITCHEN DESIGNER
(Symbol)	NEW TRACK AND HANGING DECORATIVE HEAVY DUTY CURTAIN
(Symbol)	NEW 3% OPEN SOLAR SHADE BY MECHOSHADE OR EQUAL
(Symbol)	NEW 8'W x 10'H CUSTOM HANGING PANEL OF FRITZELT; COLOR 408, 10 MM, TO BE SECURED TO THE FLOOR AND CEILING.

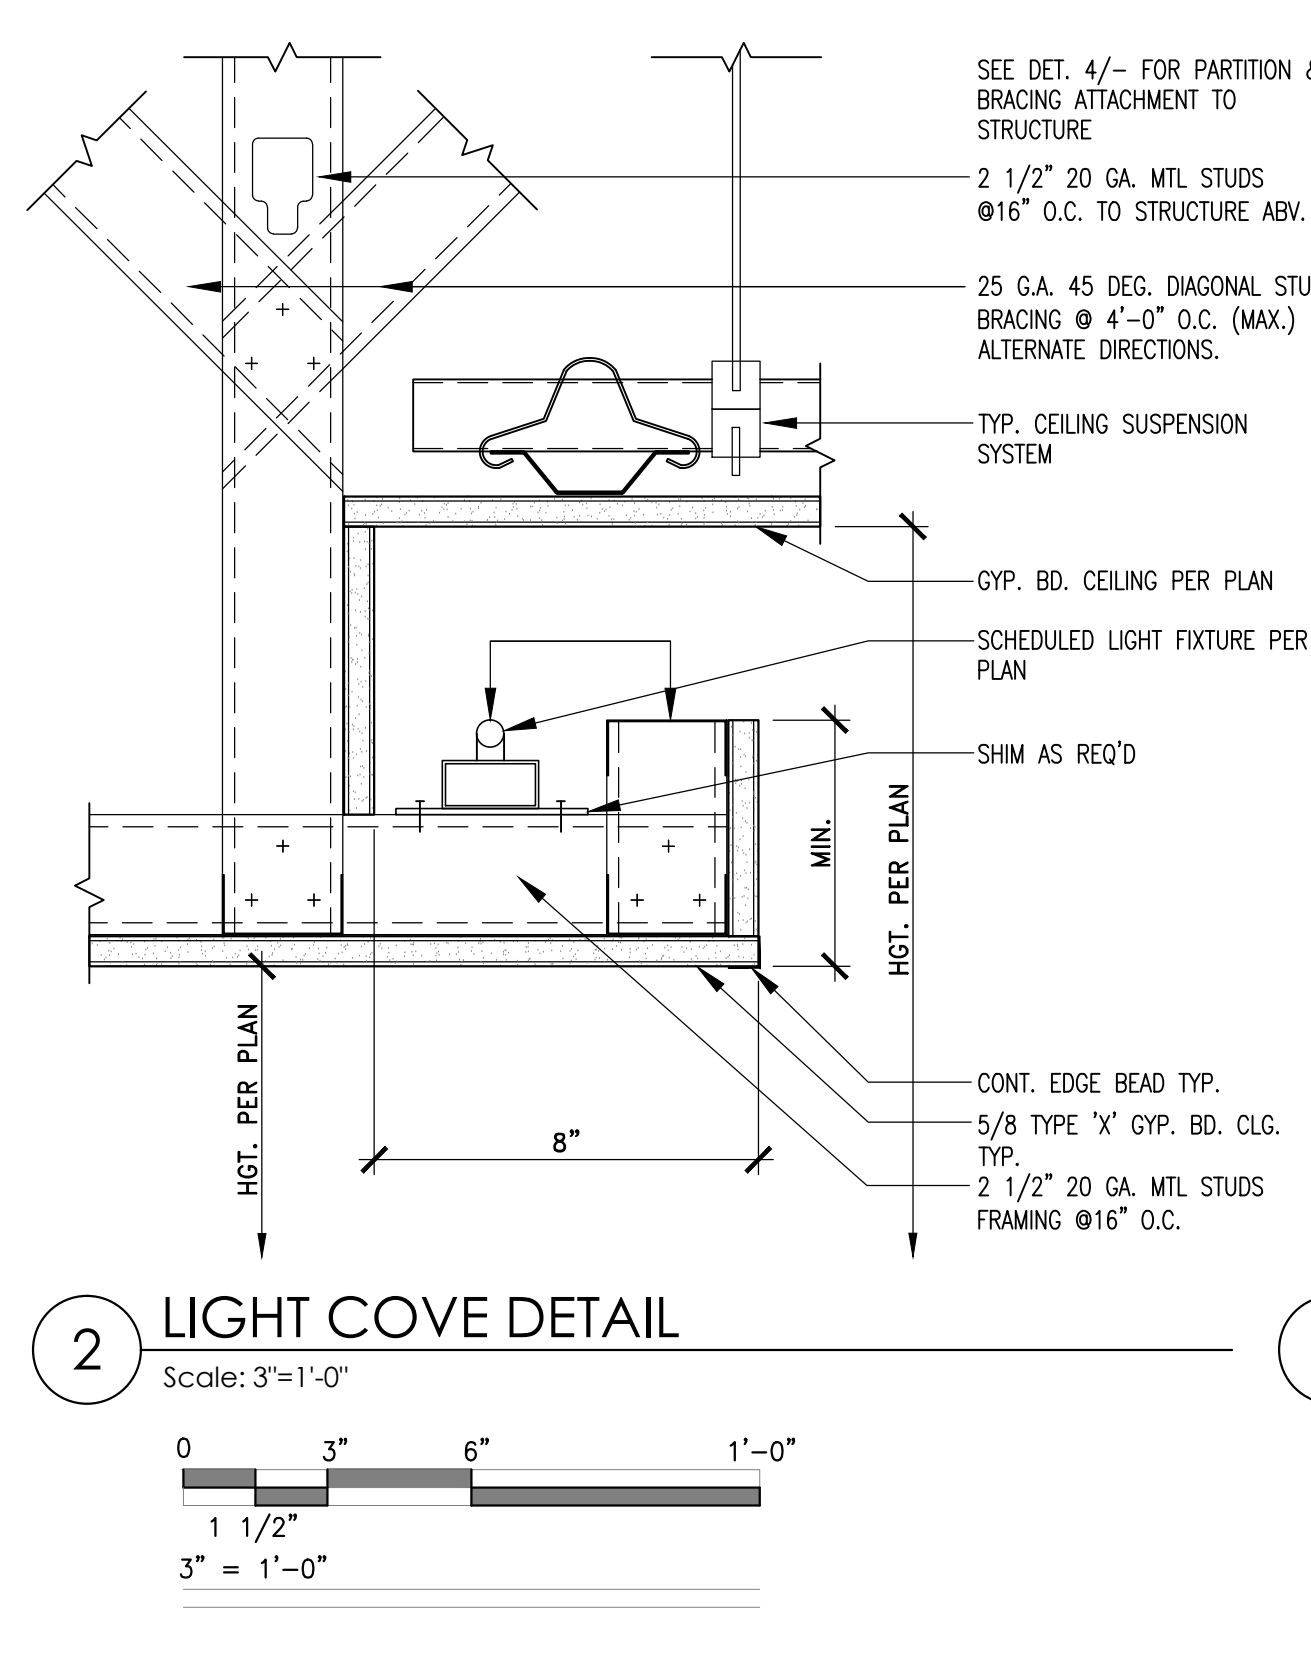

2 LIGHT COVE DETAIL
Scale: 3"=1'-0"

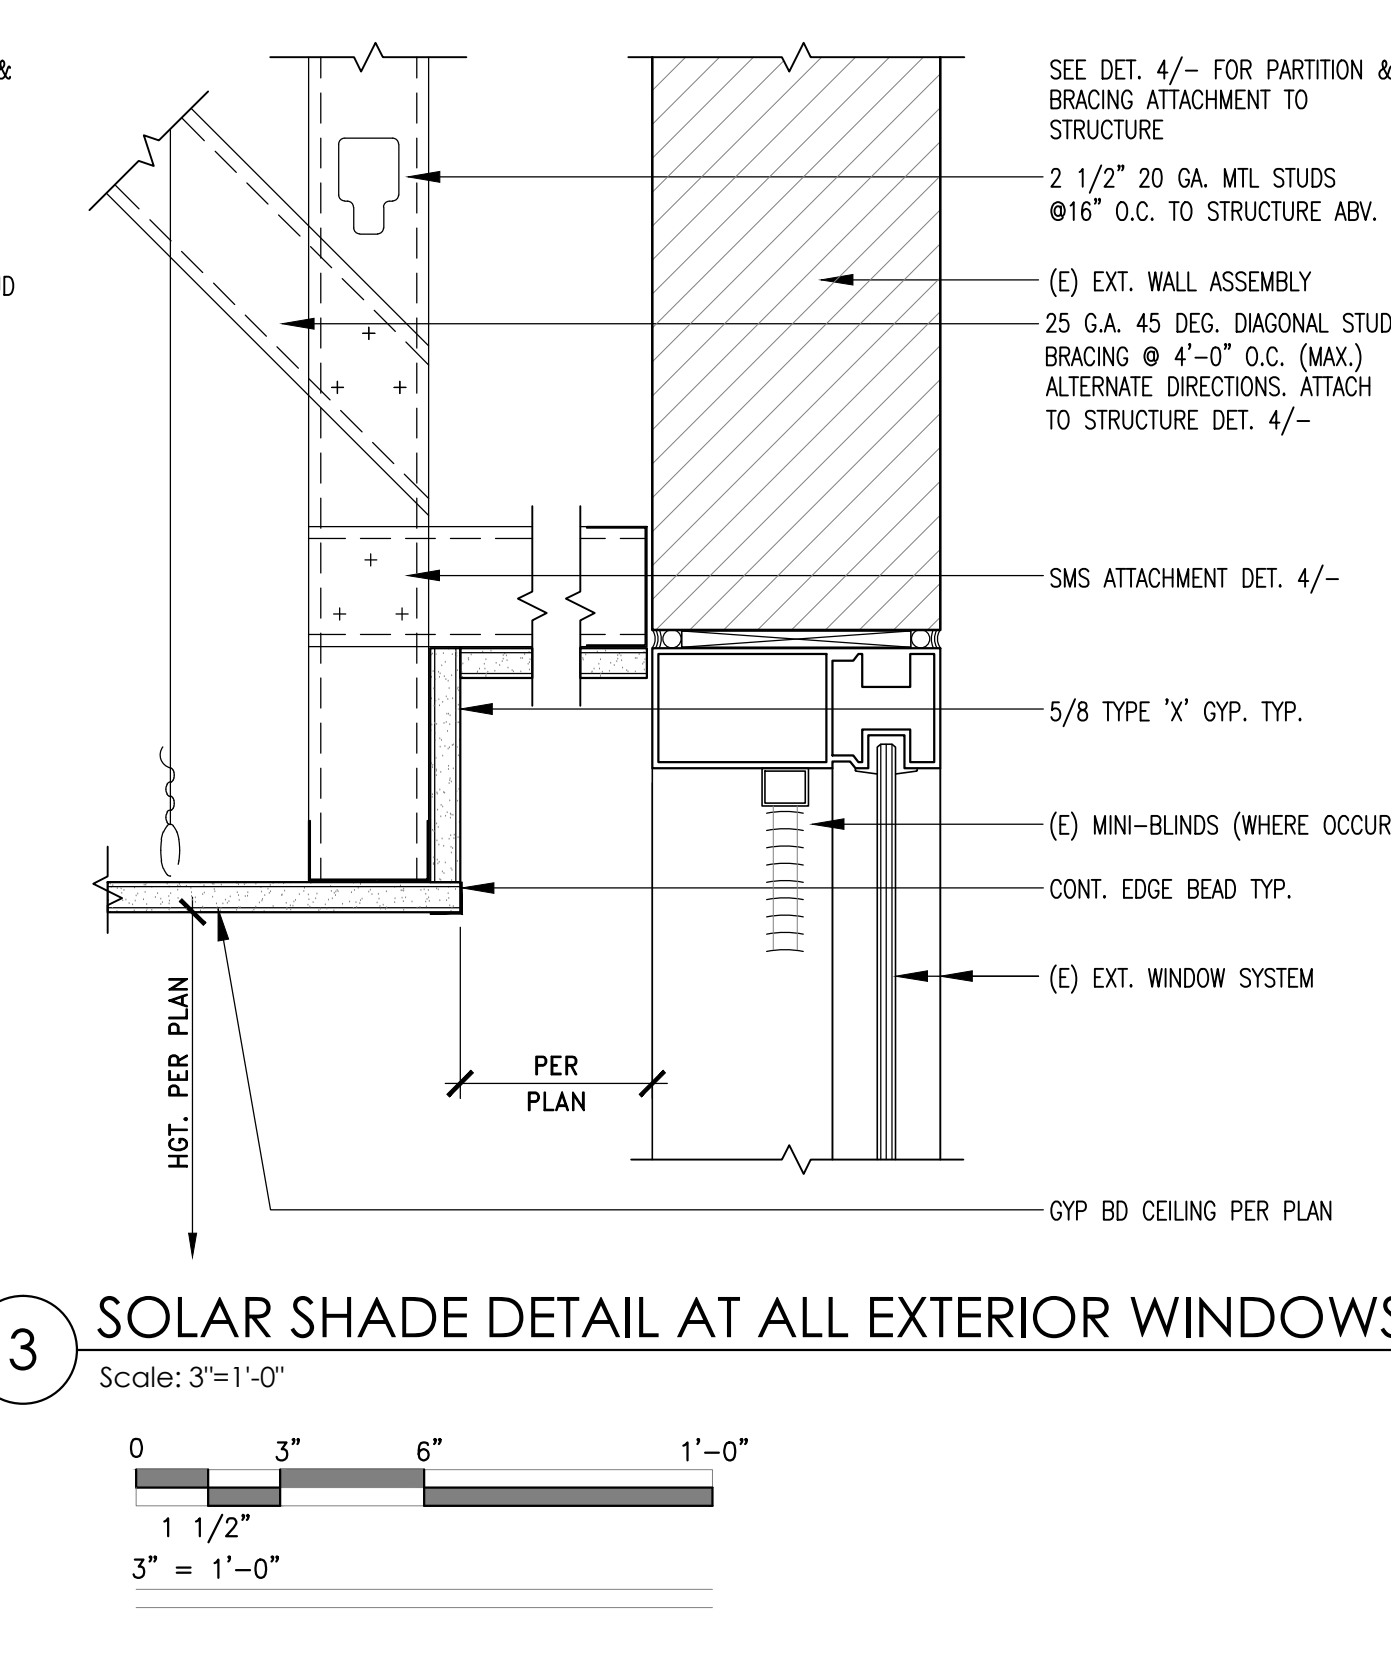


3 SOLAR SHADE DETAIL AT ALL EXTERIOR WINDOWS
Scale: 3"=1'-0"

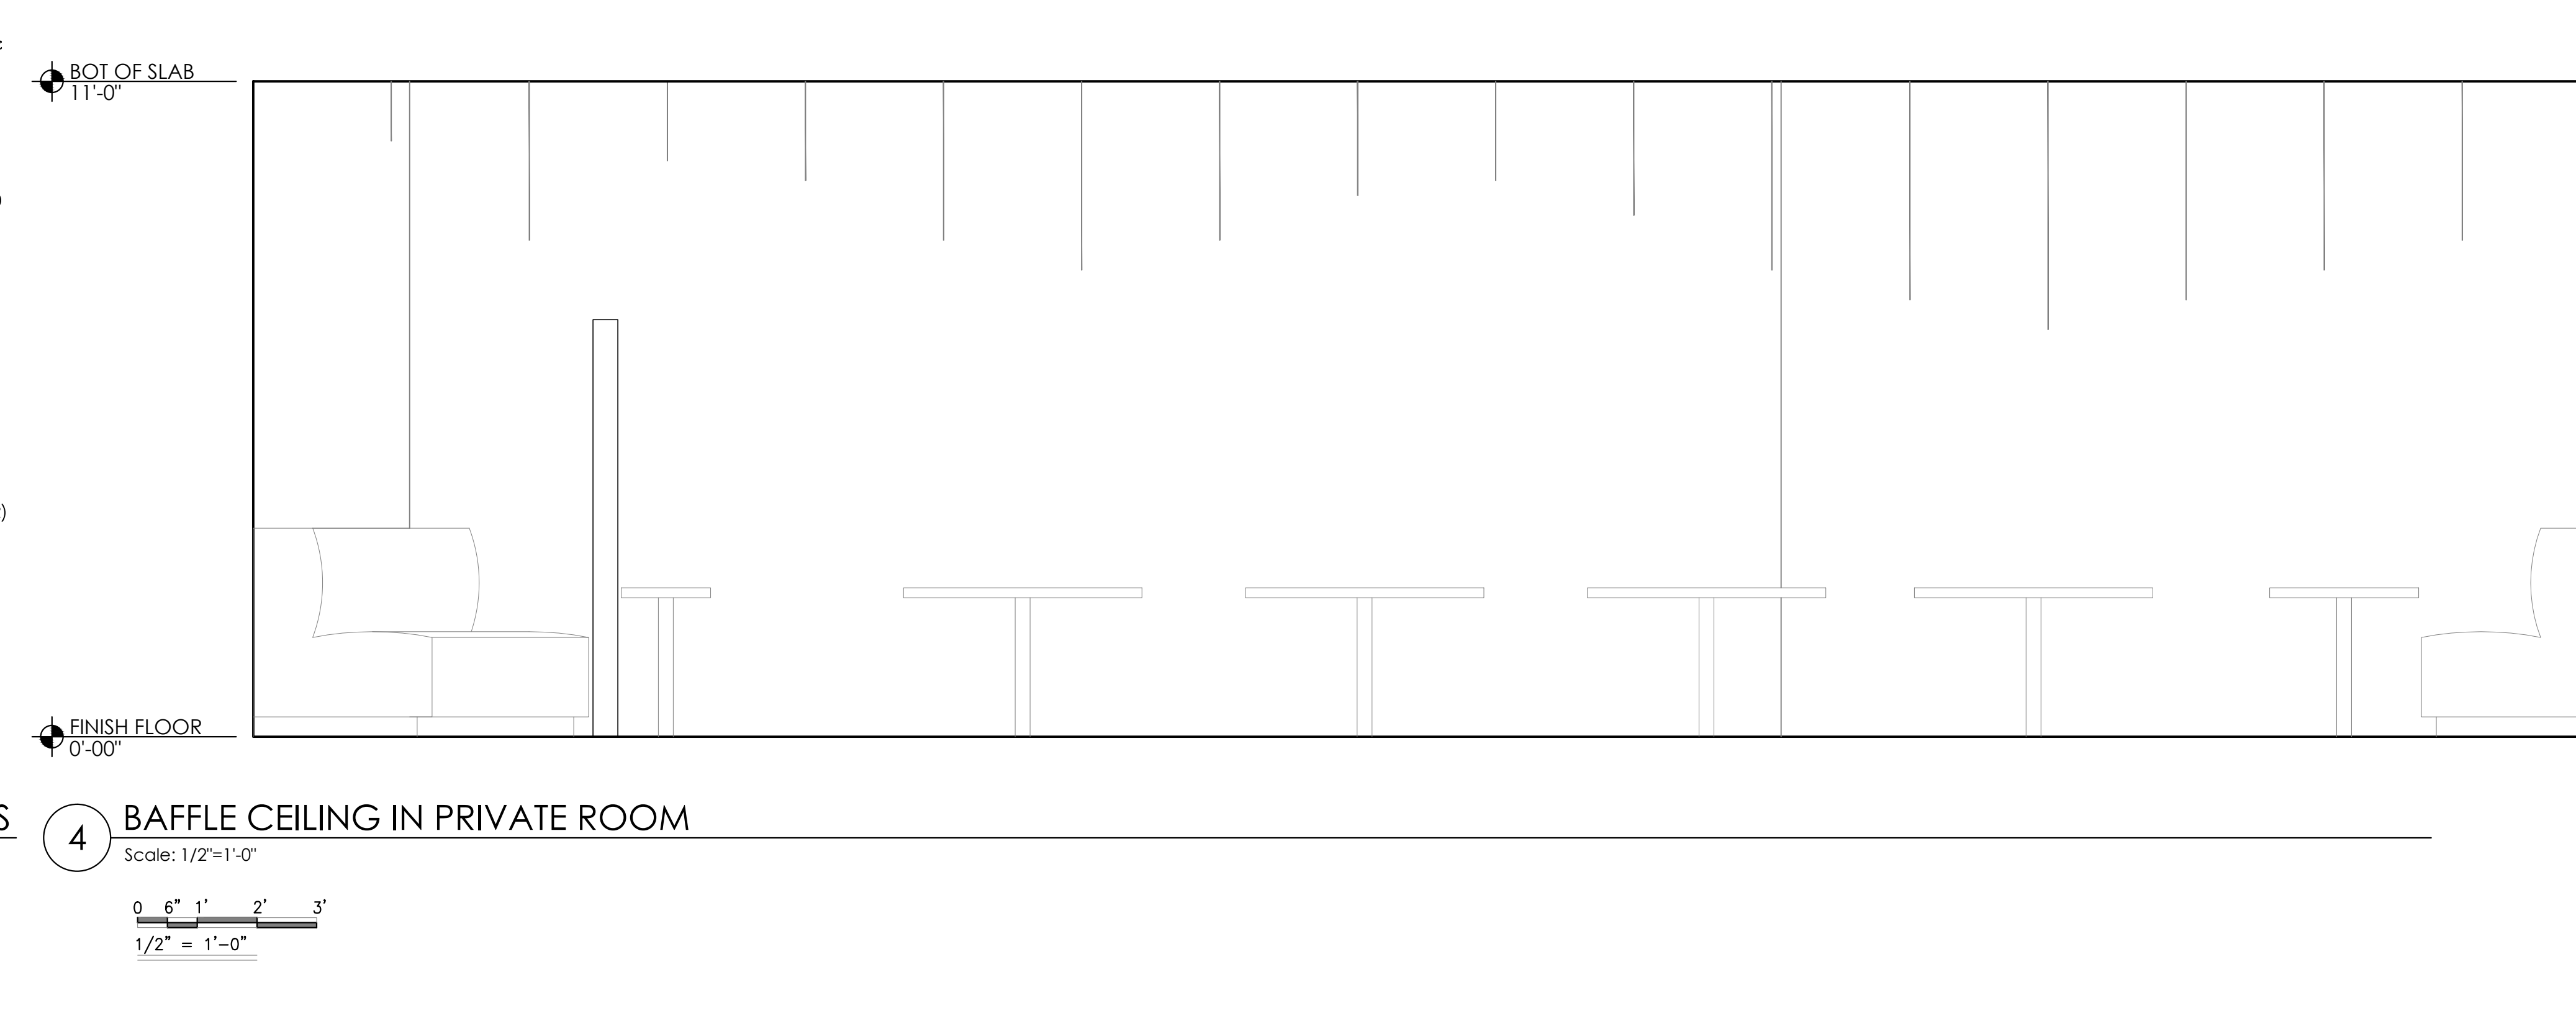

4 BAFFLE CEILING IN PRIVATE ROOM
Scale: 1/2"=1'-0"

LIGHTING LEGEND		
(Symbol)	'A' WALL SCONCE LIGHT FIXTURE BY ARTERIORS: SAHARA SCONCE, 46651	'J' WAC TRACK LIGHTING, H-SERIES: HB-DB LIGHT FIXTURE TRACK WITH LEDMIE TRACK LUMINAIRE
(Symbol)	'B' 3" LED RECESSED DOWN LIGHT BY WAC LIGHTING: HR-LED309-4-W	'K' FLOOR LAMP BY LITE SOURCE, REAVE, LS-82213
(Symbol)	'C' PENDANT LIGHT FIXTURE BY ARTERIORS: TRESOR OCTAGONAL PENDANT, DK42056	'L' CHANDELIER BY RESTORATION: FRENCH EMPIRE CHANDELIER, 21" PEWTER
(Symbol)	'D' PENDANT LIGHT FIXTURE BY ARTERIORS: CHAINMAIL PENDANT, DK42043	
(Symbol)	'E' PENDANT LIGHT FIXTURE BY ARTERIORS: EDOM PENDANT, 44057	
(Symbol)	'G' PENDANT LIGHT FIXTURE BY TECH LIGHTING: BRIOLETTE LOW VOLTAGE, HS49-AM	

TIGA
311 Commercial Street
Portland, Maine

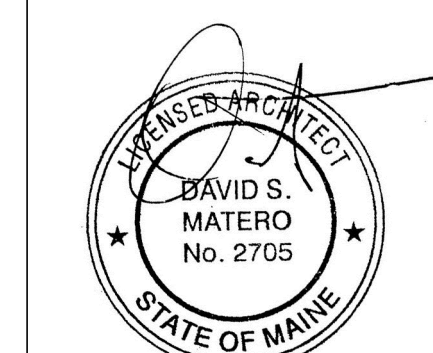

Job Number: 14.000
Date: 09.30.14
Scale: As Noted
Drawing Title:

Reflected Ceiling Plan

A.2
Issued for Permit