 



NOTE: HEARING IMPAIRED/ACCESSIBLE GUEST ROOM STROBE WALL MOUNTING HEIGHTS SHALL BE IN ACCORDANCE WITH NFPA 72, 2010 TABLE 18.5.4.6.2.

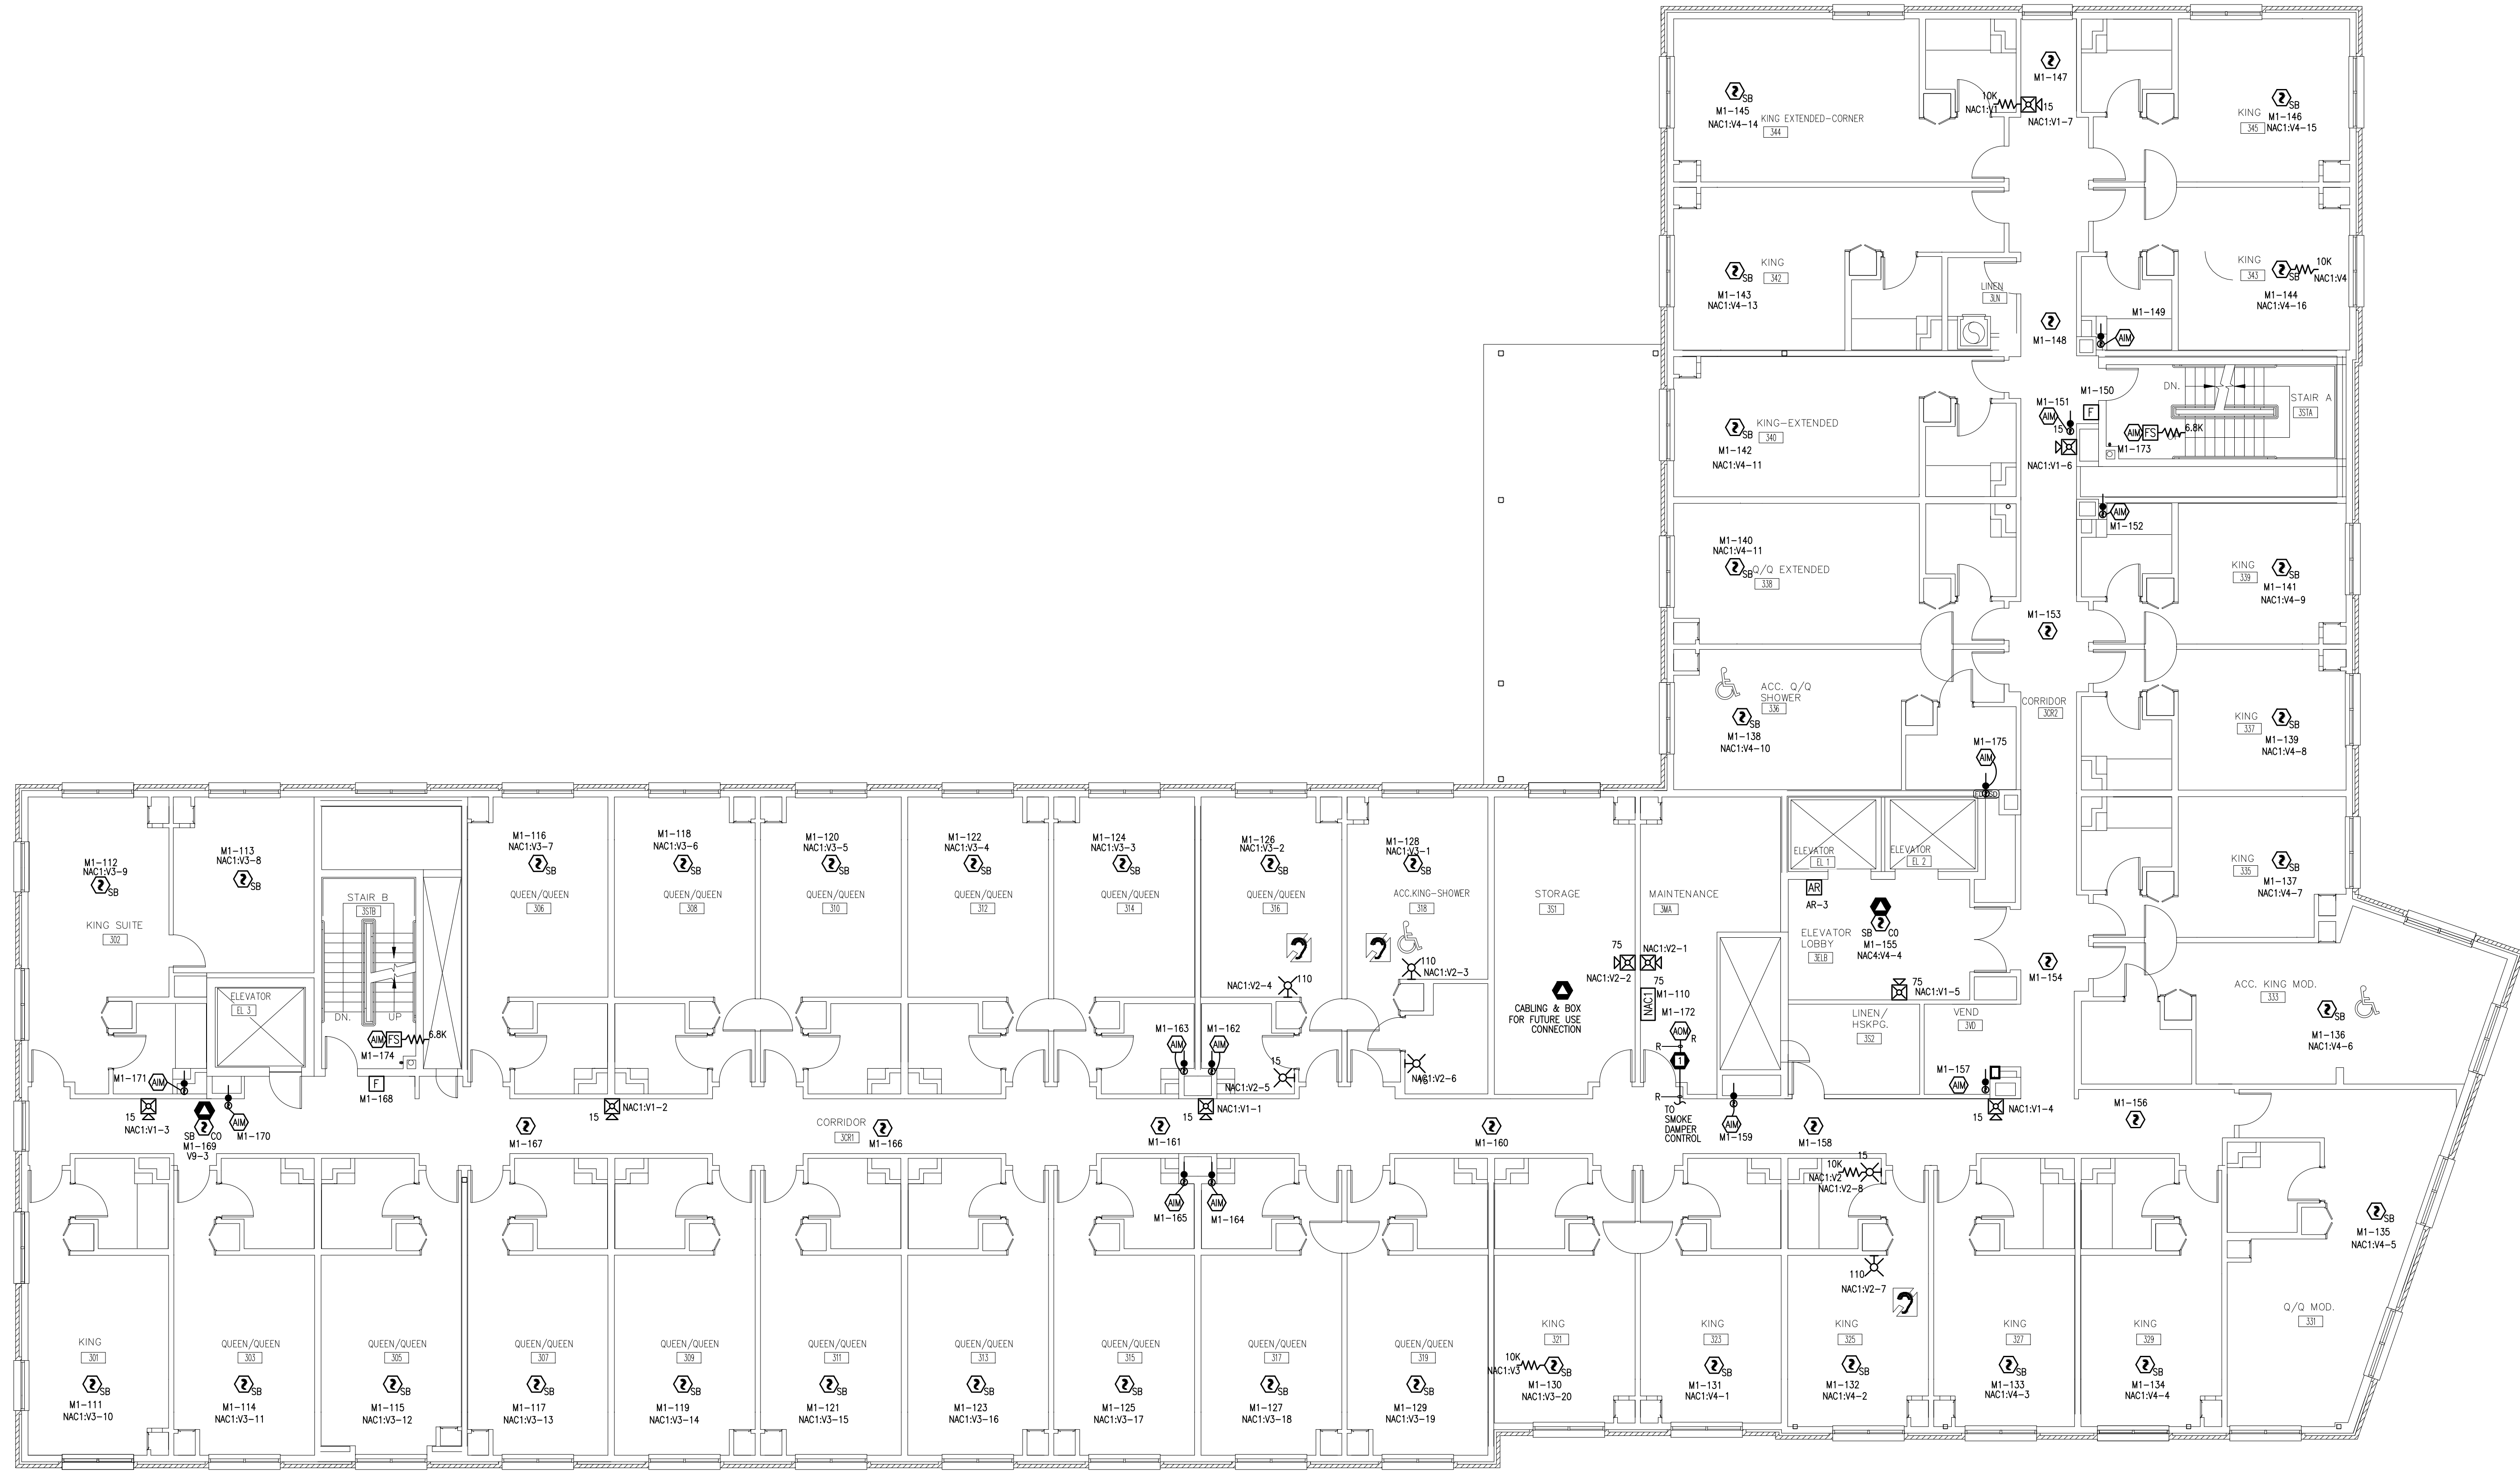

**tyco**  
SimplexGrinnell

20 THOMAS DRIVE  
WESTBROOK, ME 04092  
207-842-6440  
SALES  
207-842-6440  
SERVICE  
207-842-6439  
FAX  
© 2013 SIMPLEX GRINNELL LP  
ALL RIGHTS RESERVED

| NO. | DATE     | REVISION DESCRIPTION                |
|-----|----------|-------------------------------------|
| 1   | 11/18/13 | PER SUBMITTAL REVIEW DATED 10/31/13 |

**FIRE ALARM & AREA OF RESCUE SYSTEMS**

**THIRD FLOOR PLAN**

**MARRIOTT COURTYARD**

PORTLAND MAINE

|   |                  |
|---|------------------|
| DRAWN BY:<br>STEPHENS                                 | DATE:<br>8/27/13 |
| CHECKED BY:<br>KALAFARSKI                             | DATE:<br>9/4/13  |
| PROJECT NUMBER:<br>972833401                          |                  |
| SHEET TITLE:<br>FIRE ALARM SYSTEM<br>THIRD FLOOR PLAN |                  |
| SHEET NUMBER:<br>FA-103                               |                  |