 



1

NOTE: HEARING IMPAIRED/ACCESSIBLE GUEST ROOM STROBE WALL MOUNTING HEIGHTS SHALL BE IN ACCORDANCE WITH NFPA 72, 2010 TABLE 18.5.4.6.2.

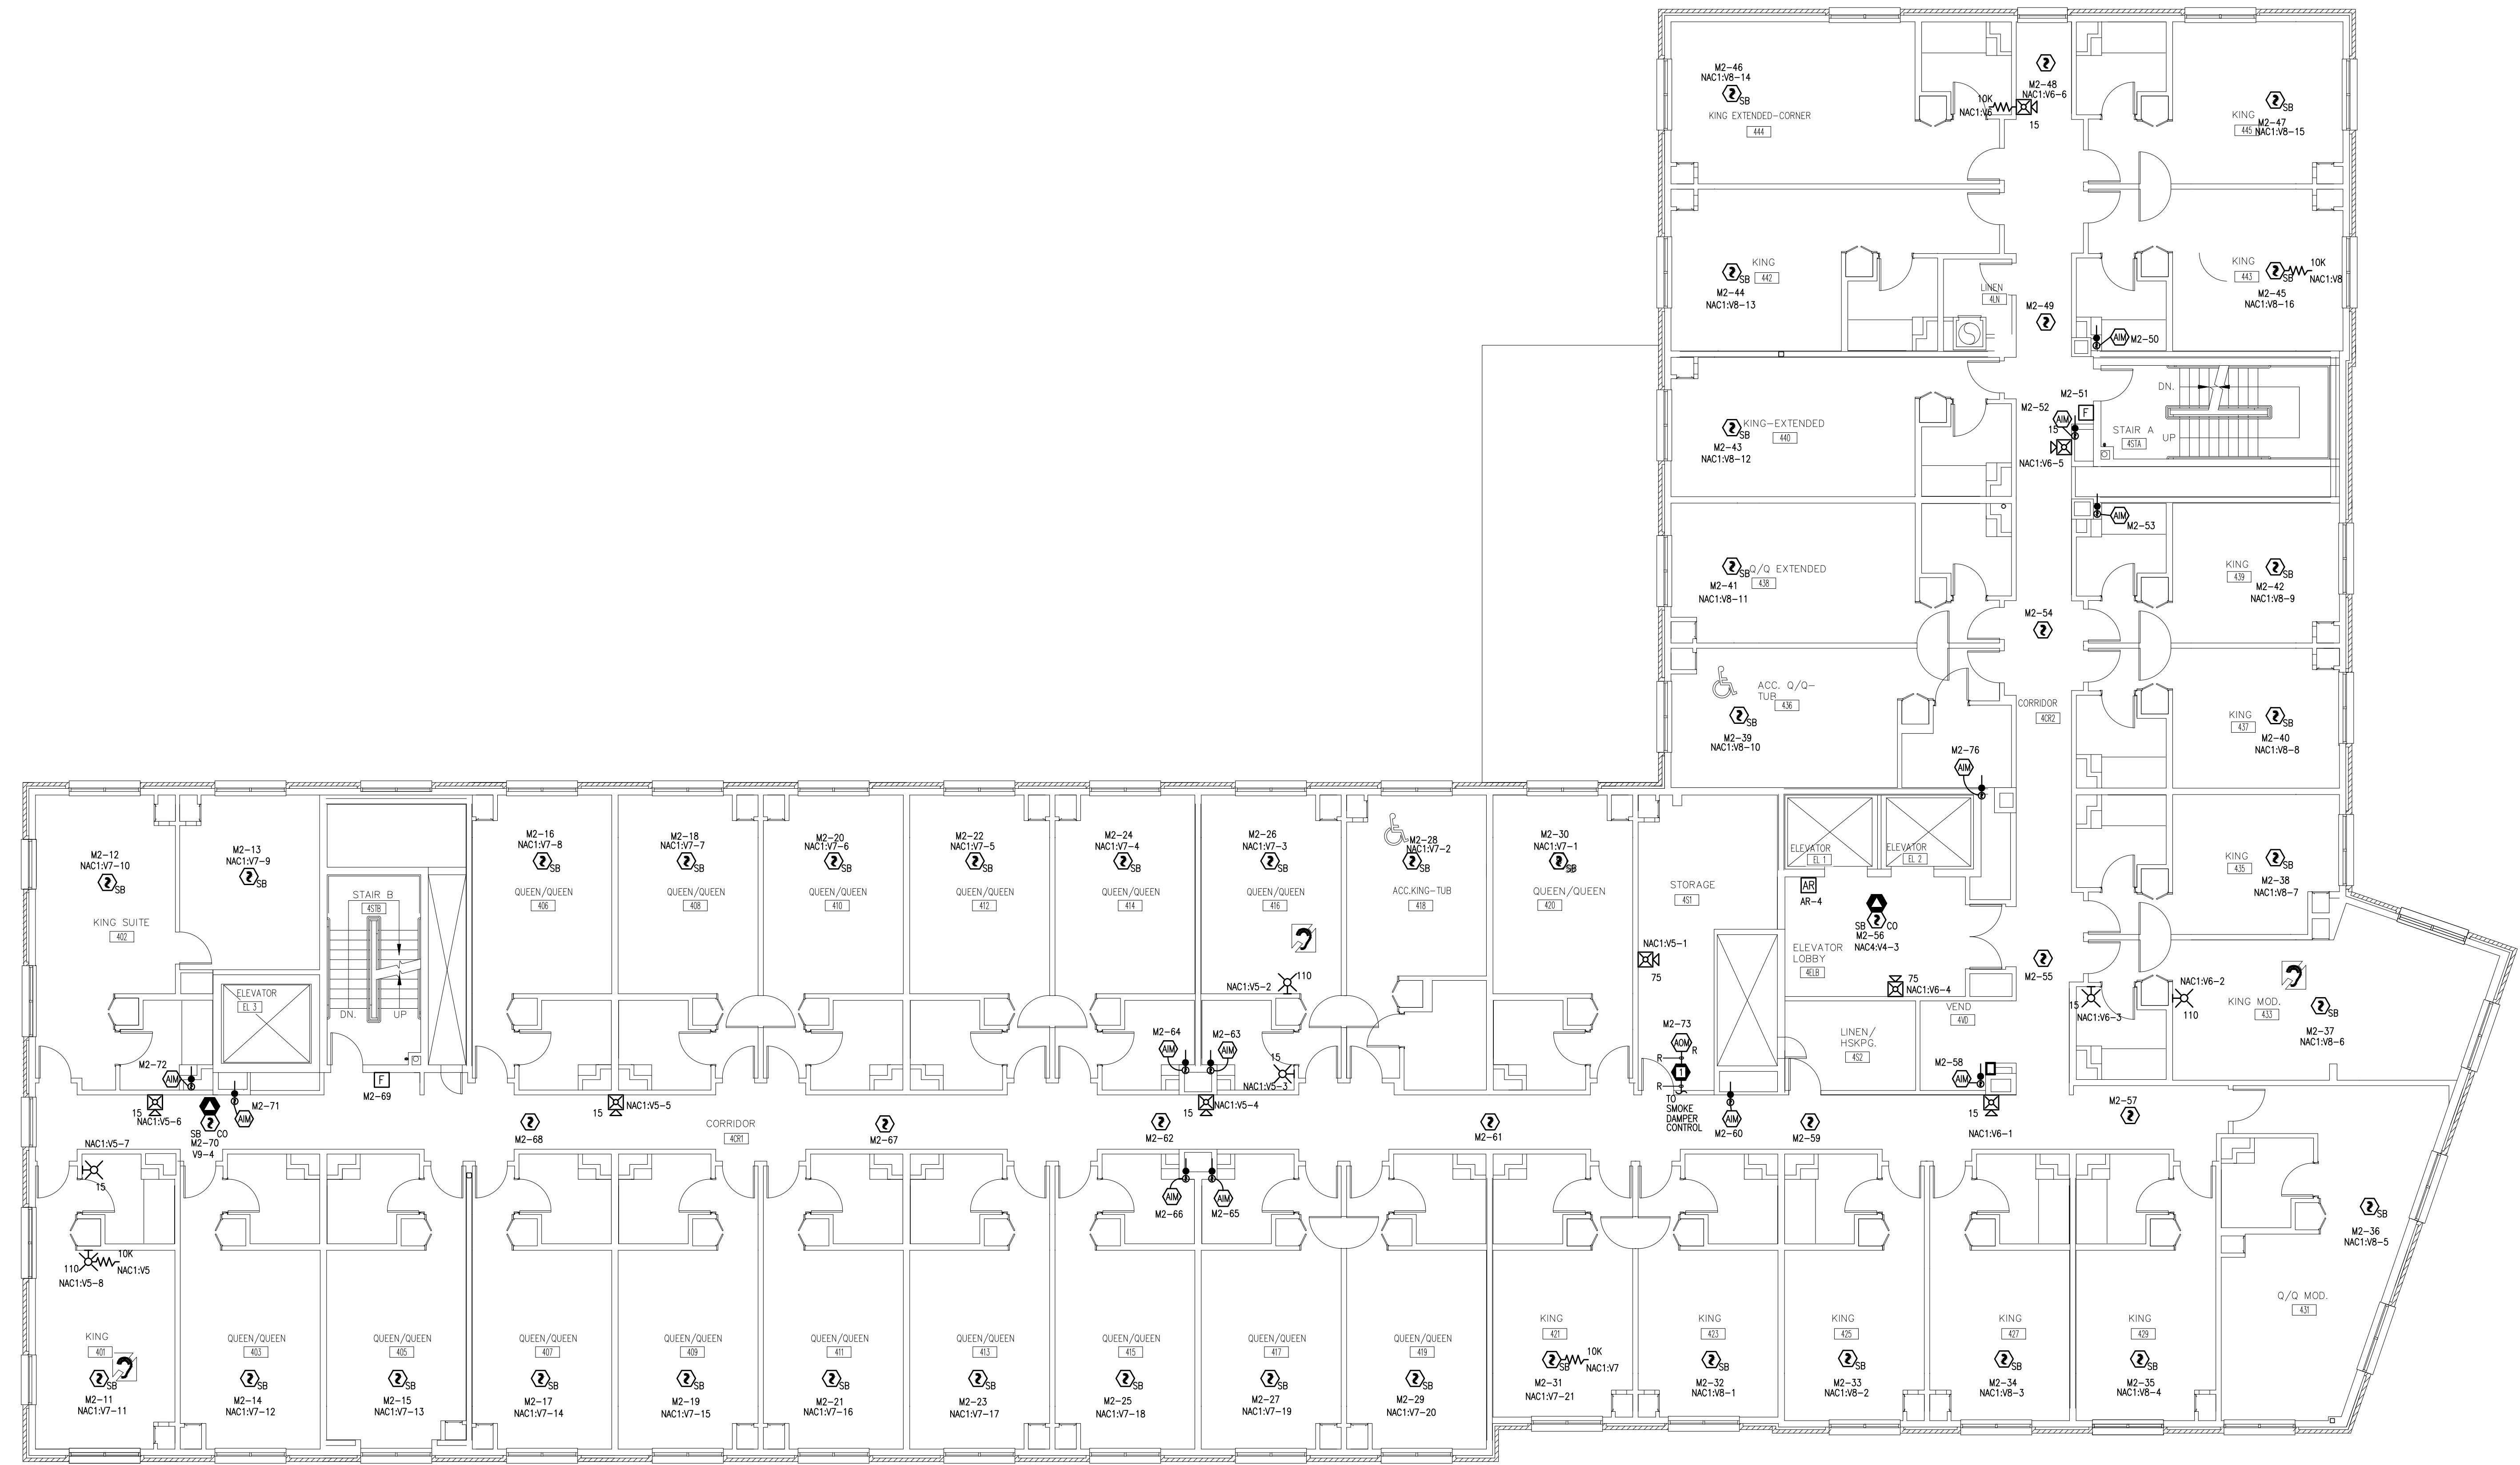

tyco
SimplexGrinnell

20 THOMAS DRIVE
WESTBROOK, ME 04092
207-842-6440
SALES
207-842-6440
FAX
207-842-6439

© 2013 TYCO SIMPLEXGRINNELL LP
ALL RIGHTS RESERVED

NO.	DATE	REVISION DESCRIPTION
1	11/08/13	PER SUBMITTAL REVIEW DATED 10/31/13

FIRE ALARM & AREA OF RESCUE SYSTEMS
FOURTH FLOOR PLAN
MARRIOTT COURTYARD
PORTLAND MAINE

DRAWN BY: STEPHENS DATE: 8/27/13

CHECKED BY: KALAFARSKI DATE: 9/4/13

PROJECT NUMBER: 972833401

SHEET TITLE: FIRE ALARM SYSTEM FOURTH FLOOR PLAN

SHEET NUMBER: FA-104