 

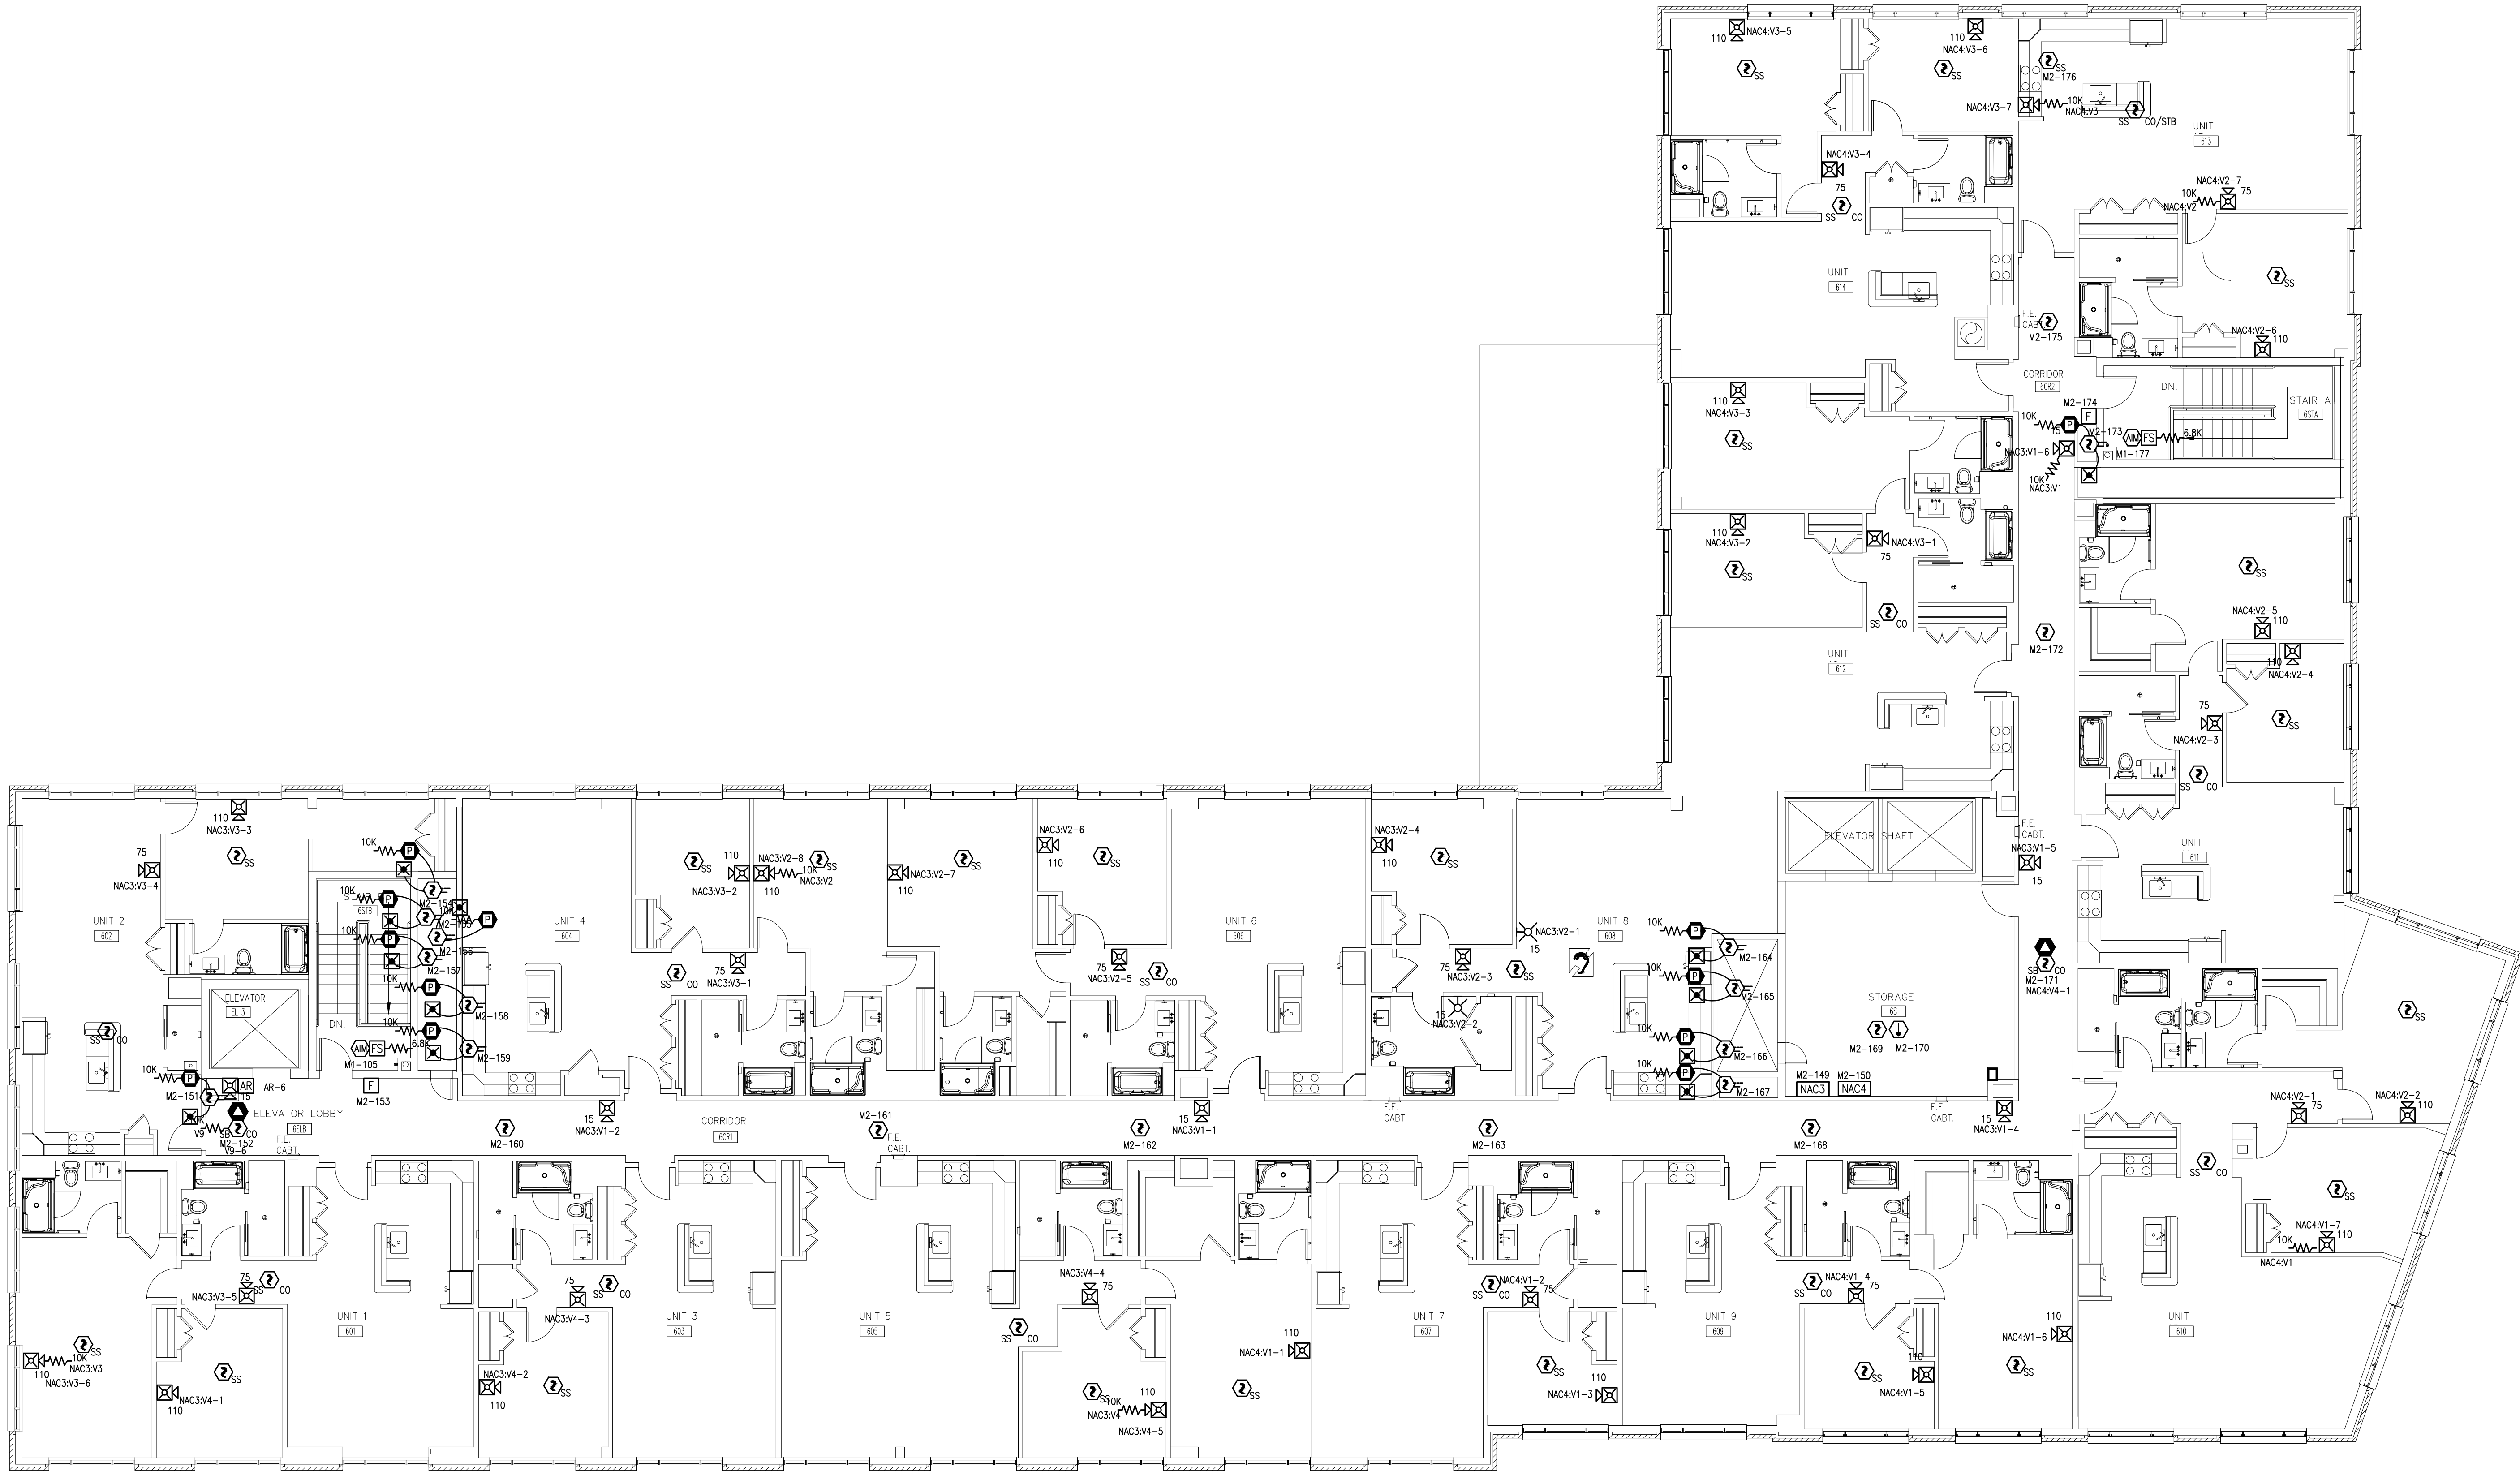


NOTE: HEARING IMPAIRED/ACCESSIBLE GUEST ROOM STROBE WALL MOUNTING HEIGHTS SHALL BE IN ACCORDANCE WITH NFPA 72, 2010 TABLE 18.5.4.6.2.

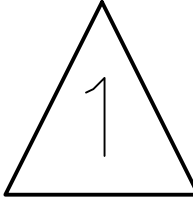

tyco SimplexGrinnell
20 THOMAS DRIVE
WESTBROOK, ME 04092
207-842-6440
207-842-6440
SALES OFFICE: 207-842-6439
FAX: 207-842-6439
© 2013 SIMPLEXGRINNELL LP
ALL RIGHTS RESERVED

CHG BY	SK	REVISION DESCRIPTION
		PER SUBMITTAL REVIEW DATED 10/31/13
NO.	DATE	
1	11/08/13	

FIRE ALARM & AREA OF RESCUE SYSTEMS	
SIXTH FLOOR PLAN	
MARRIOTT COURTYARD	
PORTLAND MAINE	
DRAWN BY:	DATE:
STEPHENS	8/27/13
CHECKED BY:	DATE:
KALAFARSKI	9/4/13
PROJECT NUMBER:	972833401
SHEET TITLE:	FIRE ALARM SYSTEM SIXTH FLOOR PLAN
SHEET NUMBER:	FA-106
	FA-106.dwg