


SEE FA-202 FOR CONTINUATION

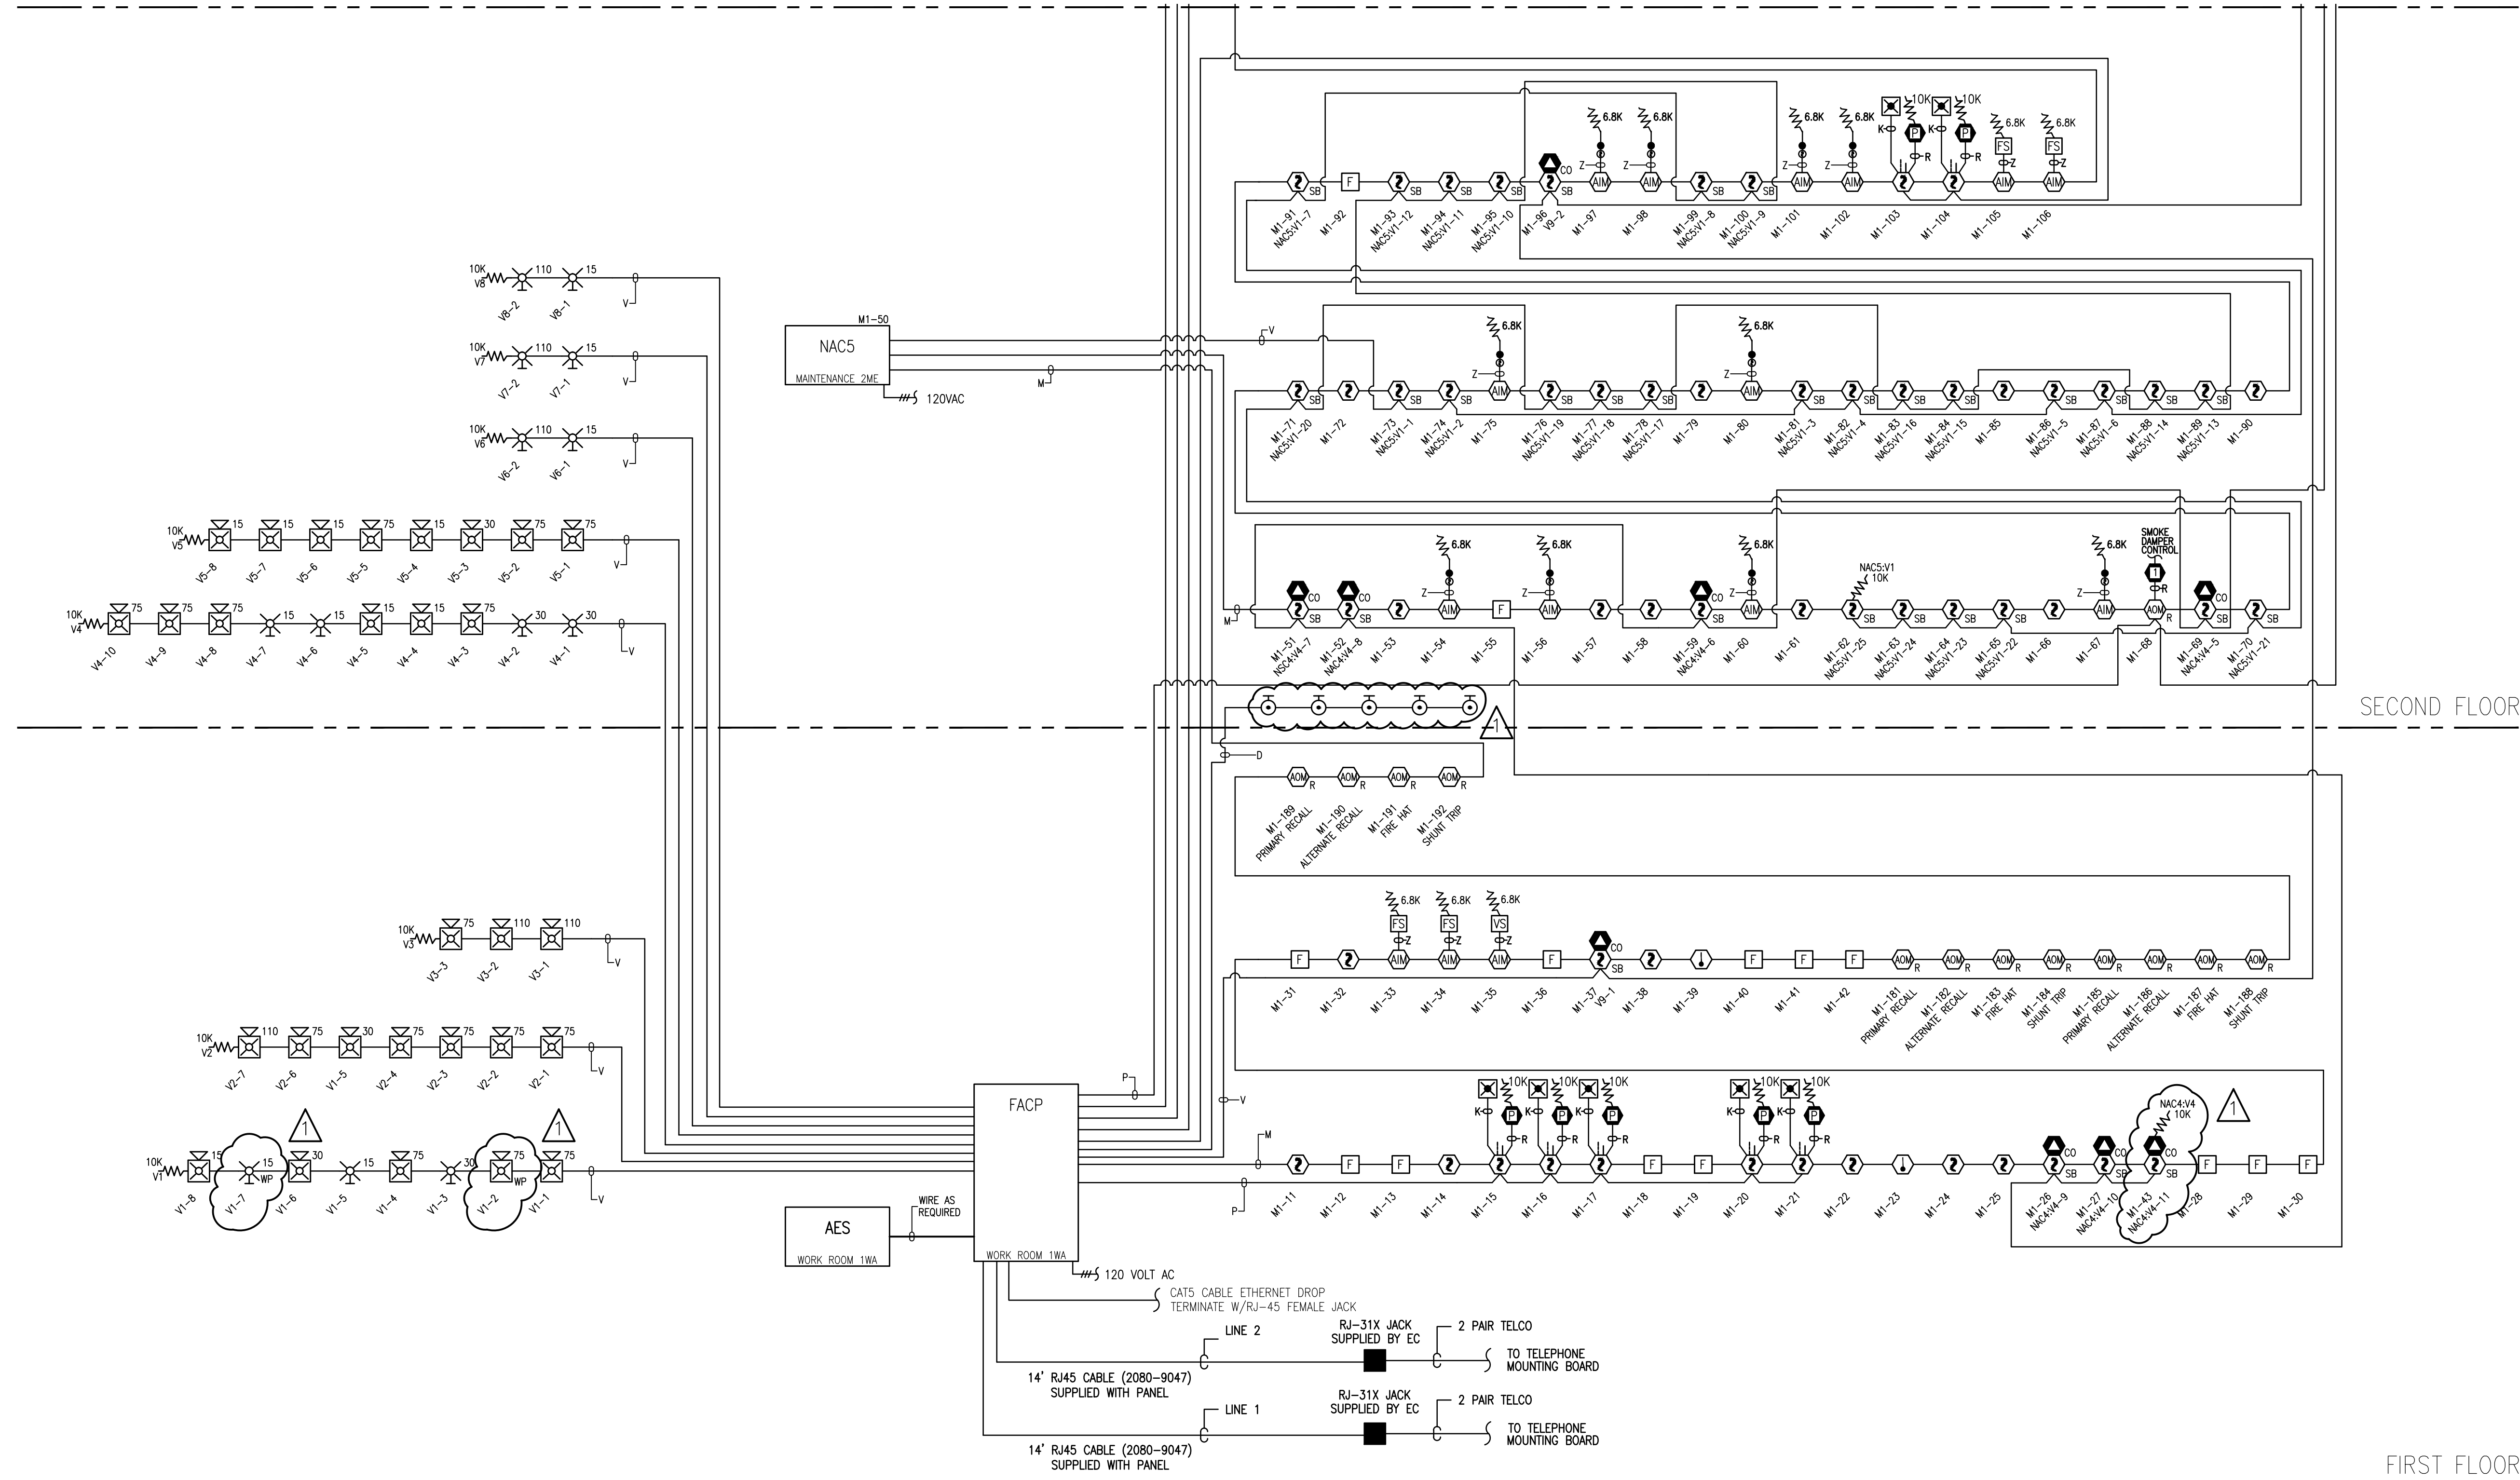

NO.	DATE	REVISION DESCRIPTION
1	11/18/13	PER SUBMITAL REVIEW DATED 10/31/13

FIRE ALARM & AREA OF RESCUE SYSTEMS
 RISER DIAGRAM - FIRST & SECOND FLOORS
 MARRIOTT COURTYARD
 PORTLAND MAINE

DRAWN BY: STEPHENS	DATE: 8/27/13
CHECKED BY: KALAFARSKI	DATE: 9/4/13
PROJECT NUMBER: 972833401	
SHEET TITLE: FIRE ALARM SYSTEM RISER DIAGRAM	
SHEET NUMBER: FA-201	