


FILE PATH: P:\2013\147\Courtyard\REV1 CAD\FA-201\_FA-203.dwg

LAST PRINTED: 11/11/2013 2:54:35 PM LAST SAVED BY: GLORION

24" x 36"

SEE FA-203 FOR CONTINUATION

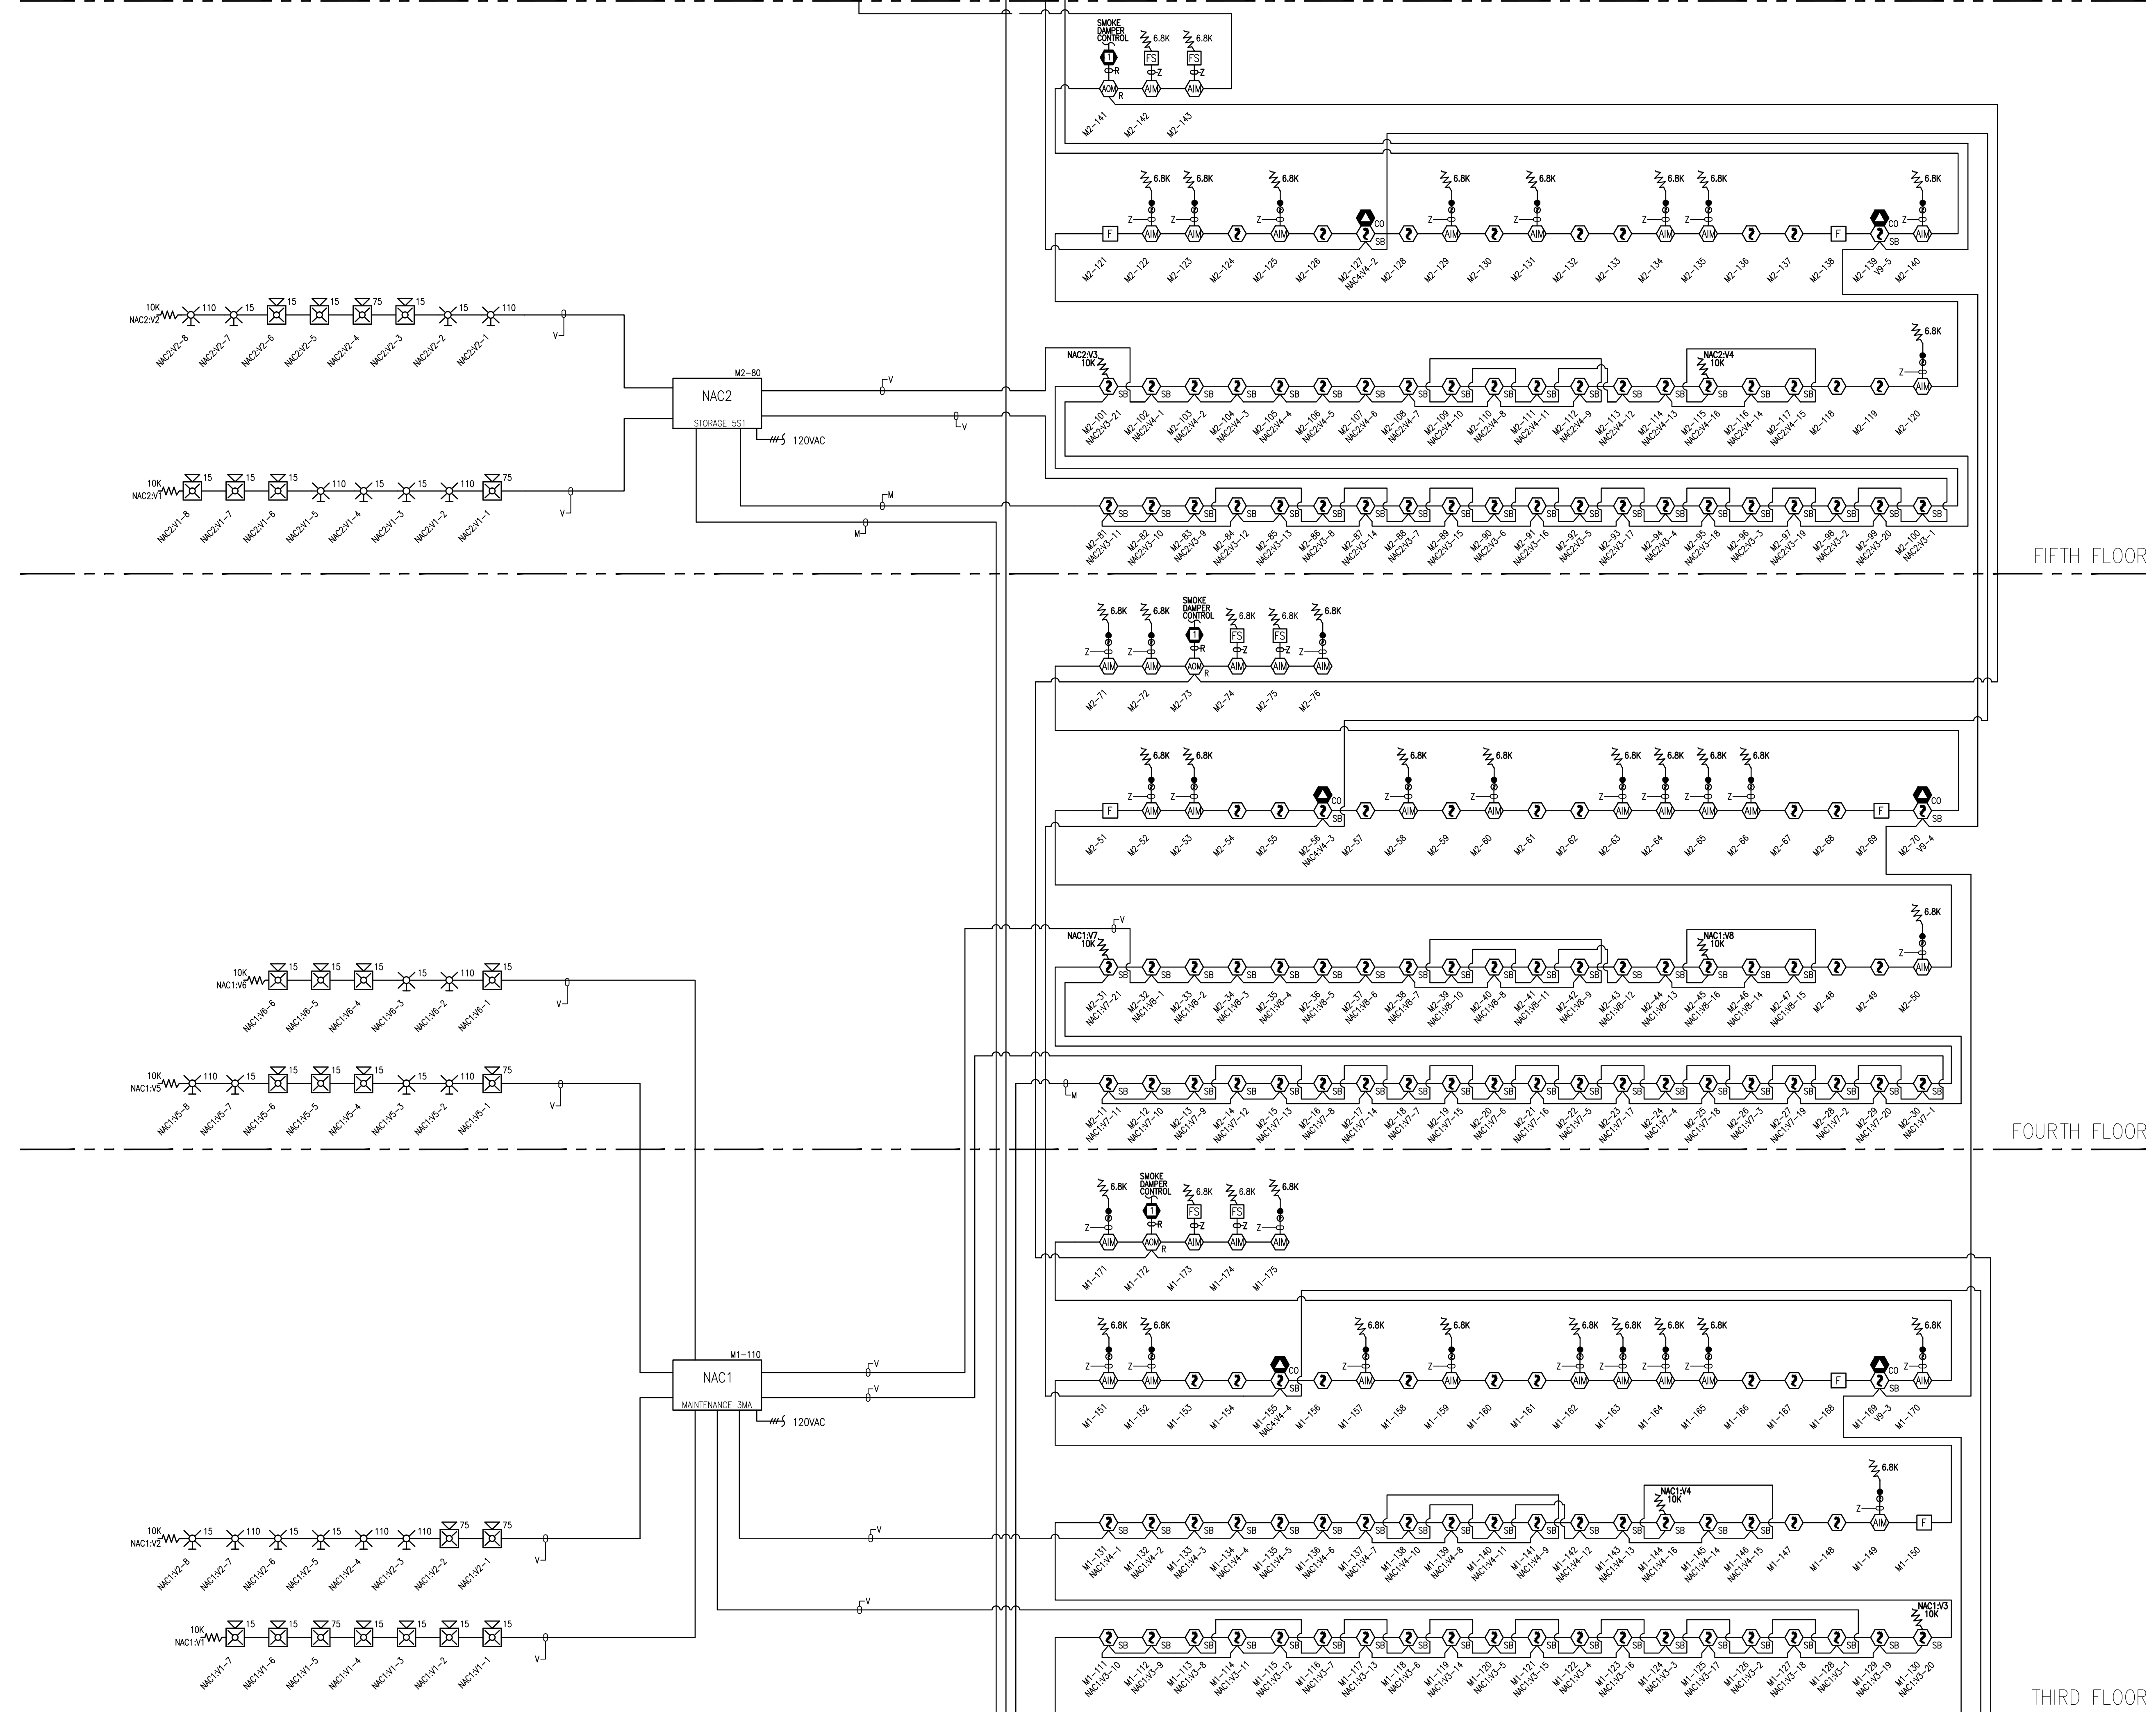

SEE FA-201 FOR CONTINUATION

**tyco**  
SimplexGrinnell

20 THOMAS DRIVE  
WESTBROOK, ME 04092  
SALES: 207-842-6440  
SERVICE: 207-842-6440  
FAX: 207-842-6439  
© 2013 SIMPLEX GRINNELL LP  
ALL RIGHTS RESERVED

NO.	DATE	REVISION DESCRIPTION
1	11/08/13	PER SUBMITTAL REVIEW DATED 10/31/13

CHG BY	SK

FIRE ALARM & AREA OF RESCUE SYSTEMS  
RISER DIAGRAM - THIRD, FOURTH & FIFTH FLOORS  
MARRIOTT COURTYARD  
PORTLAND MAINE

DRAWN BY: STEPHENS	DATE: 8/27/13
CHECKED BY: KALAFARSKI	DATE: 9/4/13
PROJECT NUMBER: 972833401	
SHEET TITLE: FIRE ALARM SYSTEM RISER DIAGRAM	
SHEET NUMBER: FA-202	
FA-201_FA-103.dwg	