


3/27/2015 9:06:09 AM

AJK

C:\Revit 2015 Local Files\14\_26\_York-Central 2015\_klein.rvt

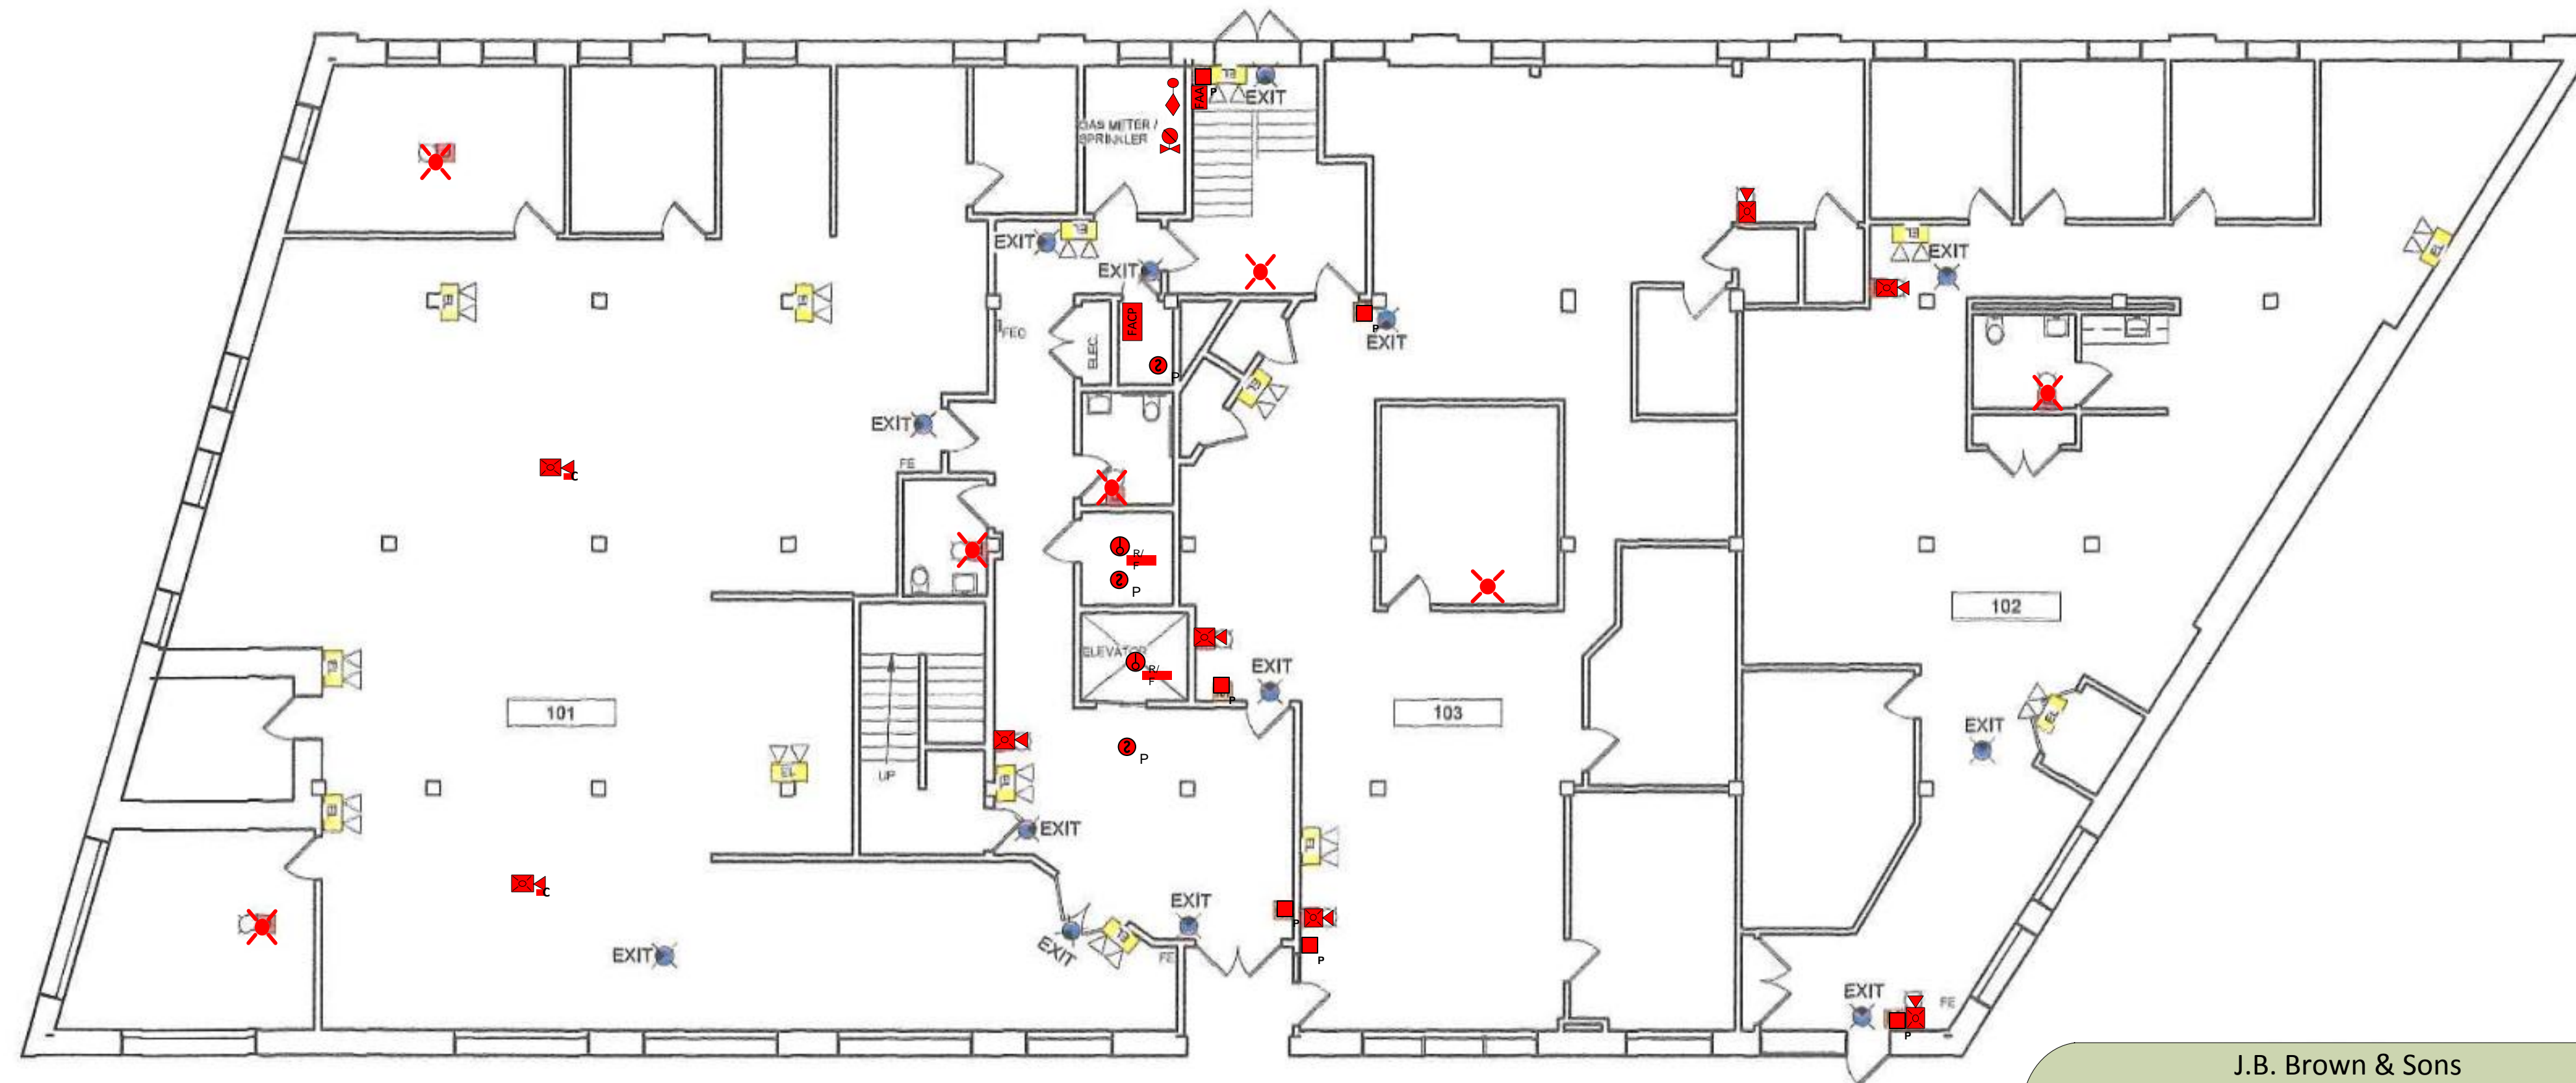

J.B. Brown & Sons  
14-26 York Street  
Portland, Maine 04101

**LS1 First Floor Fire Alarm Layout**

Symbol	Count	Description
	1	Fire Alarm Control Panel
	1	Annunciator Panel
	1	Flow Switch
	1	Valve with Tamper
	6	Manual Station
	3	Smoke Detector Photo
	2	Heat Detector
	2	Ceiling Horn w/Light
	6	Horn Strobe
	6	Strobe

1 EXISTING FIRST FLOOR PLAN  
1" = 10'-0"



Robin Russell, Certified Engineering Technician, NICET Cert. # 110826

10 Manuel Drive, Portland, Maine 04103 (207) 347-5327 11/18/16



**PDT ARCHITECTS**

49 DARTMOUTH STREET  
PORTLAND, MAINE 04101  
207-775-1059  
www.pdtarchts.com

COPYRIGHT 2012  
PDT Architects

Reuse or reproduction of the  
contents of this document is not  
permitted without written  
permission of PDT Architects.

J.B. Brown & Sons  
14-26 York Street, Portland, Maine

JOB NO.  
15034

DRWN. CHK  
AJK

SCALE:  
As indicated

ISSUE  
SAFETY DEVICES  
3/26/15

TITLE  
FIRST FLOOR  
PLAN

SHEET  
A100