


3/27/2015 9:06:09 AM

AJK

C:\Revit 2015 Local Files\14\_26\_York-Central 2015\_klein.rvt

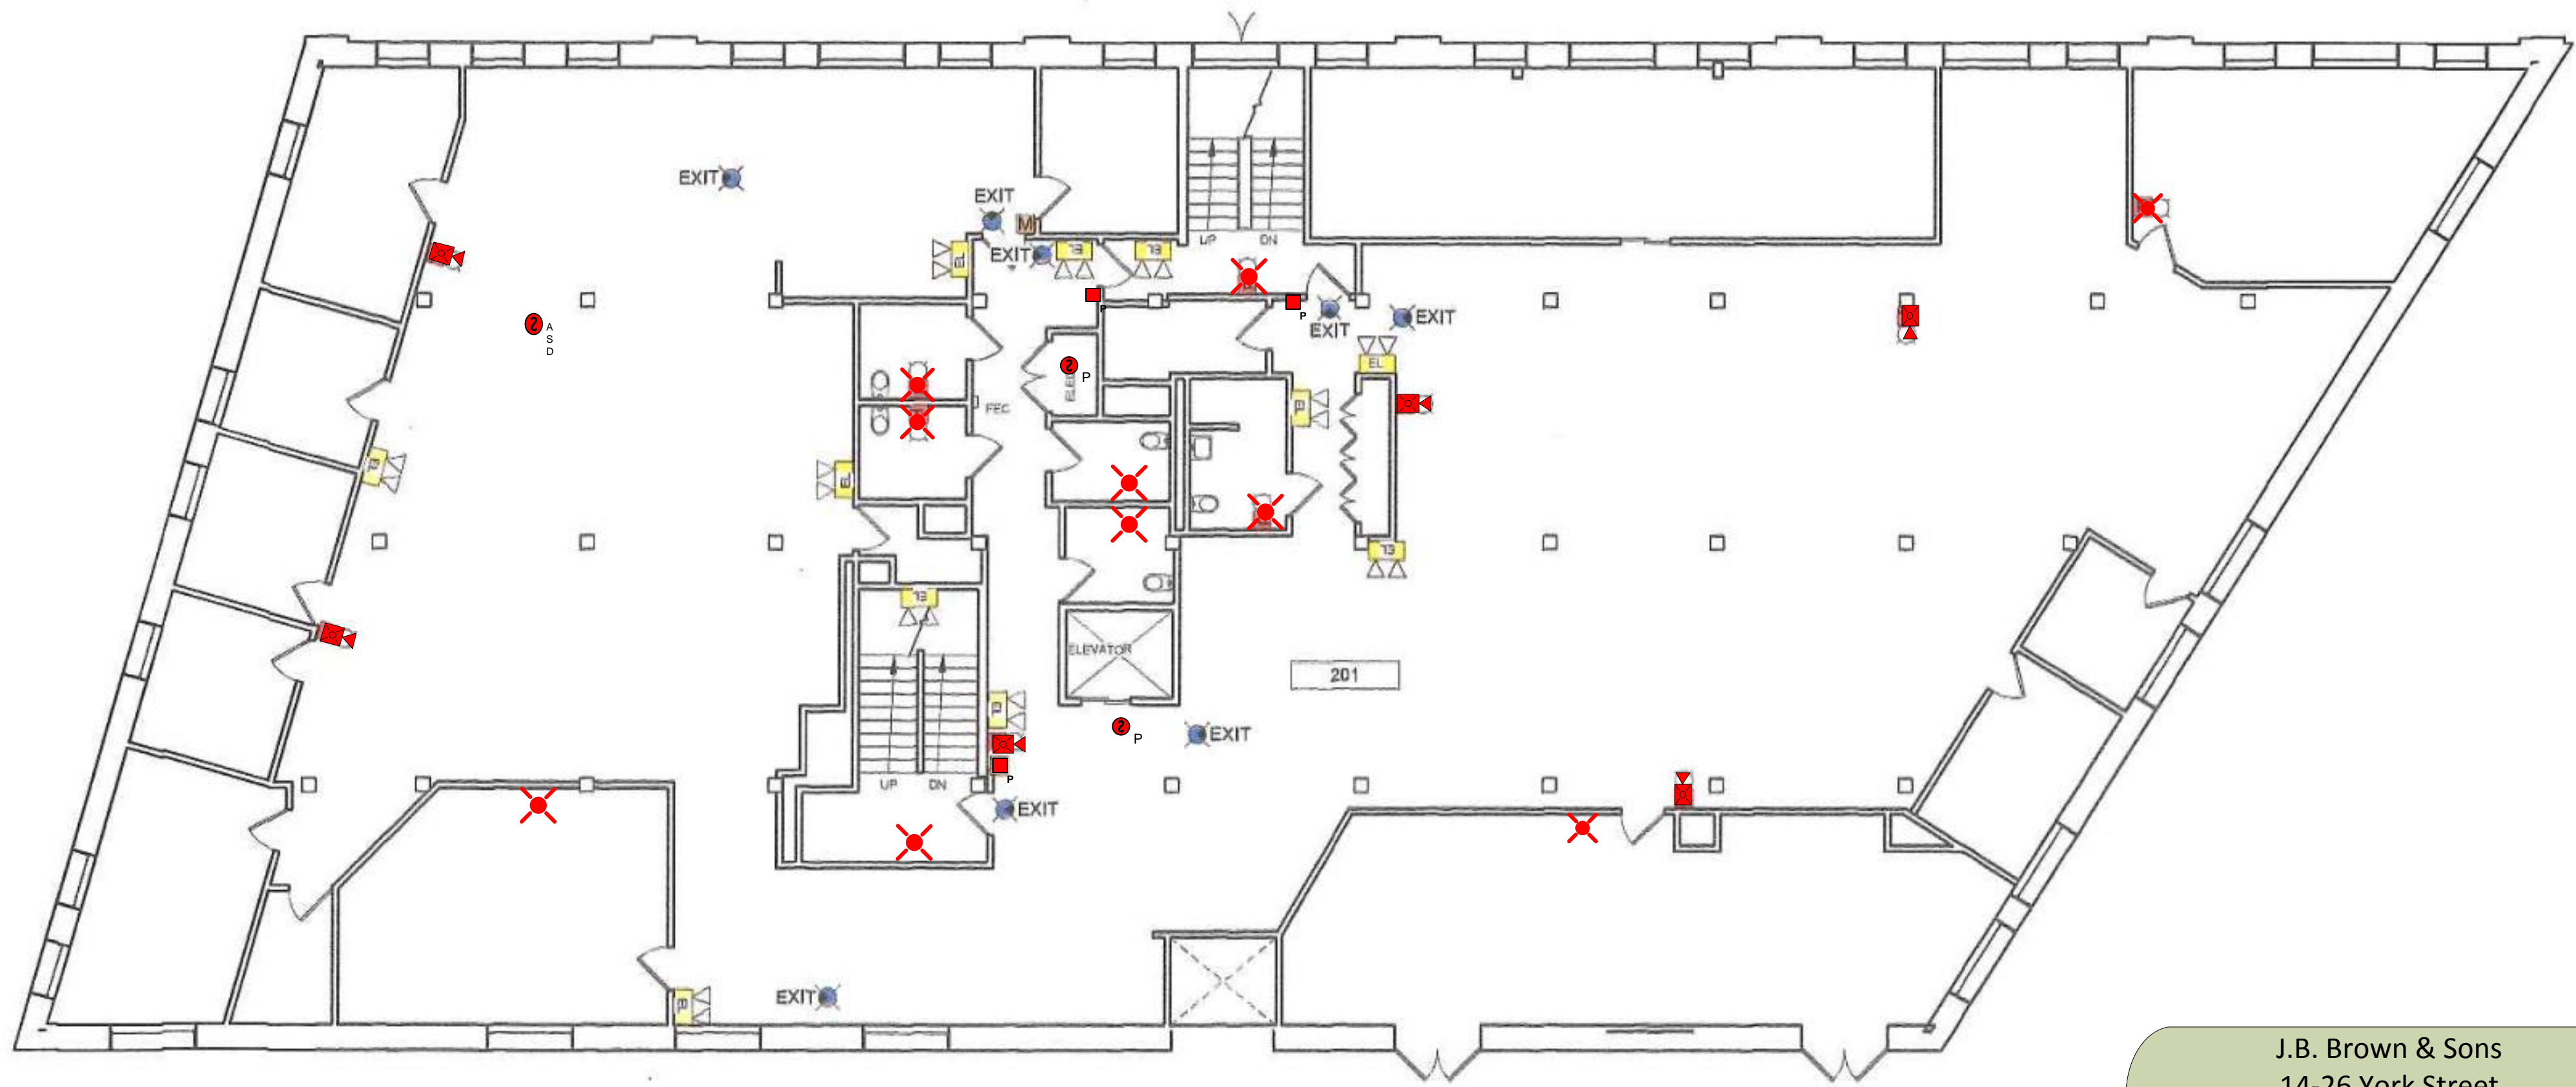

J.B. Brown & Sons  
14-26 York Street  
Portland, Maine 04101

**LS2 Second Floor Fire Alarm Layout**

Symbol	Count	Description
•	2	Smoke Detector Photo
◼	6	Horn Strobe
×	10	Strobe
◼	3	Manual Station
⋮	1	Duct Detector

① EXISTING SECOND FLOOR PLAN  
1" = 10'-0"



COPYRIGHT 2012  
PDT Architects  
Reuse or reproduction of the  
contents of this document is not  
permitted without written  
permission of PDT Architects.

**J.B. Brown & Sons**  
14-26 York Street, Portland, Maine

JOB NO.  
15034

DRWN. CHK  
AJK

SCALE:  
As Indicated

ISSUE  
SAFETY DEVICES  
3/26/15

TITLE  
SECOND FLOOR  
PLAN

SHEET  
**A101**