


3/27/2015 9:06:10 AM

AJK

C:\Revit 2015 Local Files\14_26_York-Central 2015_Mlein.rvt

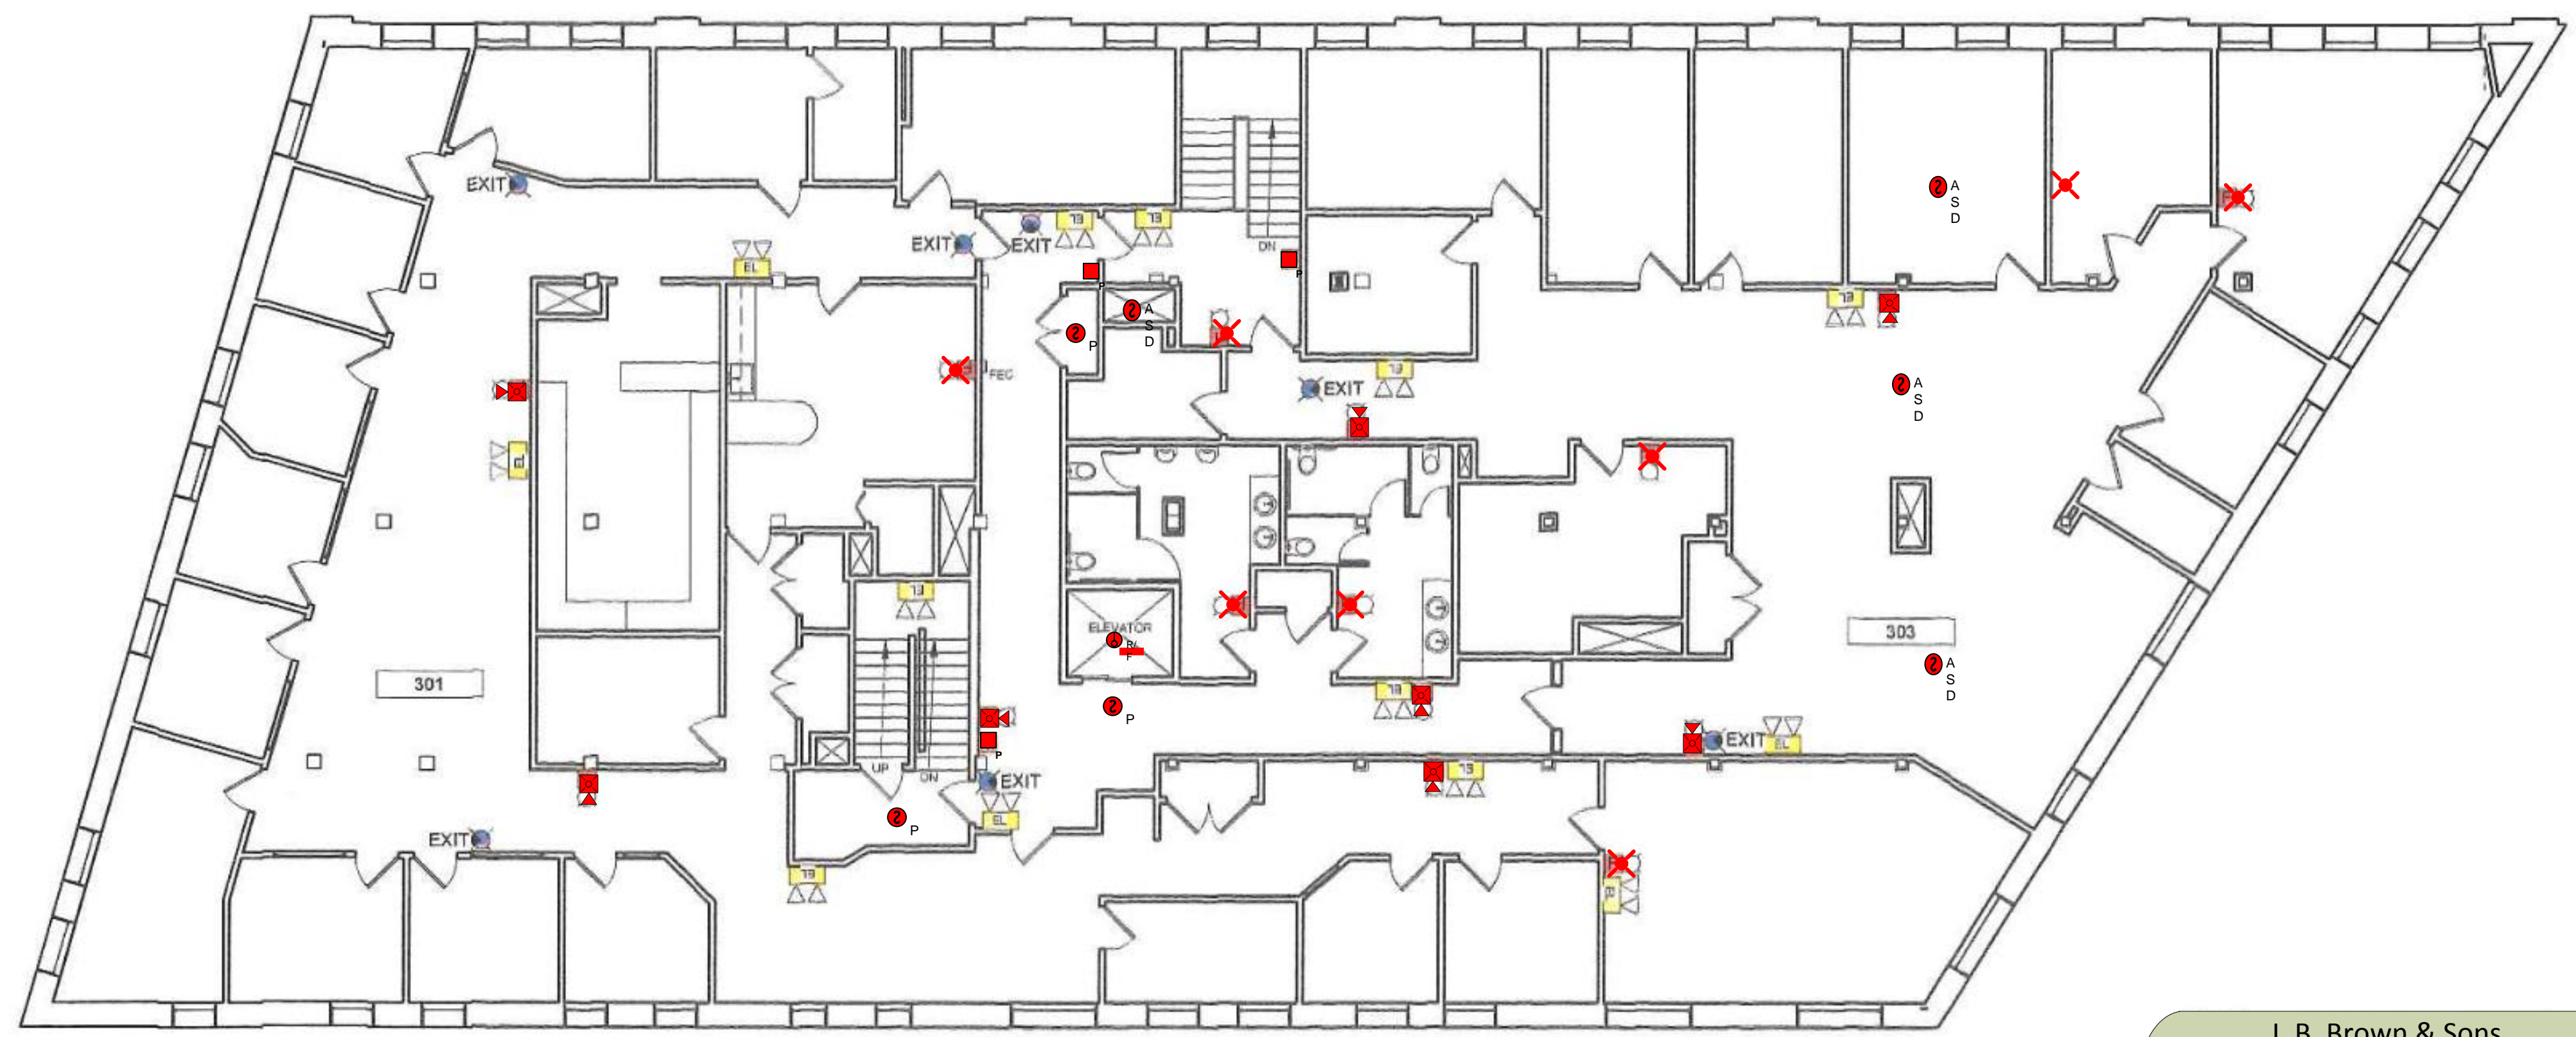


J. B. Brown & Sons
14-26 York Street
Portland, Maine 04101

LS3 3rd Floor Fire Alarm Layout

Symbol	Count	Description
•	4	Duct Detector
■	8	Horn Strobe
■	3	Manual Station
X	8	Strobe
●	3	Smoke Detector Photo
■	1	Heat Detector

1 EXISTING THIRD FLOOR PLAN
1" = 10'-0"

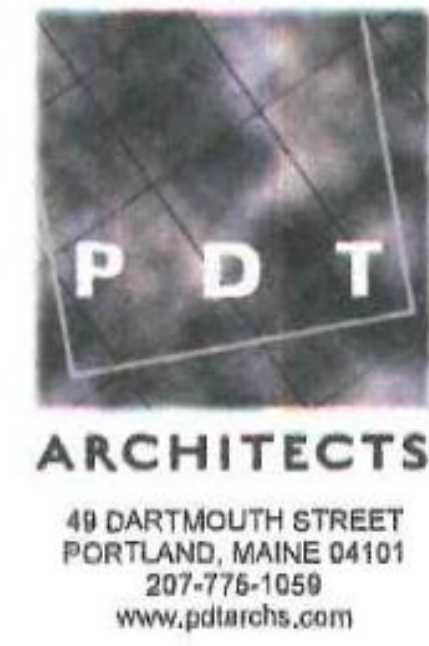

COPYRIGHT 2012
PDT Architects

Reuse or reproduction of the
contents of this document is not
permitted without written
permission of PDT Architects.

J.B. Brown & Sons
14-26 York Street, Portland, Maine

JOB NO.
15034

DRWN. CHK
AJK

SCALE:
As indicated

ISSUE
SAFETY DEVICES
3/26/15

TITLE
THIRD FLOOR
PLAN

SHEET
A102