

PROJECT

WELLS FARGO

254 COMMERCIAL ST. SECOND FLOOR
PORTLAND, ME 04101

ARCHITECT

THE SWITZER GROUP

3 EAST 54th STREET, 7th FLOOR
NEW YORK, NY 11022
Project Principal: KENT HIKIDA
T. 212.922.1313

CONSULTANTS


MEP
MECHANICAL SYSTEMS ENGINEERS
KURT MAGNUSSON
10 FOREST FALLS DRIVE
YARMOUTH, ME 04096 SUITE 10B
207-849-1441 X202

ELECTRICAL ENGINEER
BARTLETT DESIGN, INC.
LARRY BARTLETT
5 PALMER STREET
BATH, ME 04530
207-443-5447

ARCHITECT OF RECORD
TOMI KENT HIKIDA, AIA
c/o The Switzer Group, Inc.
3 East 54th Street
New York, NY 10022
T: 212.922.1313
State of Maine License No. ARC4456

DEPARTMENT OF BUILDINGS SCAN

SEAL

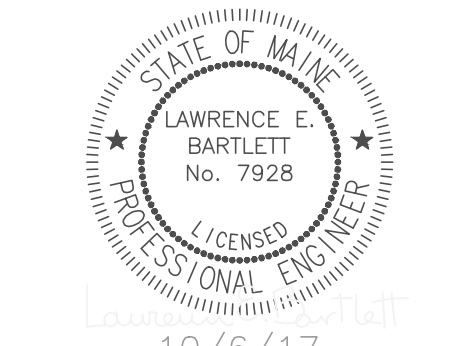

ISSUE

No.	Rev.	Issued for	Date
1		LANDLORD REVIEW	09.18.17
2		UPDATED REVIEW	09.25.17
3		ISSUED FOR CONSTRUCTION	10.06.17

PROJECT NUMBER

SHEET TITLE


**LIGHTING
FLOOR
PLAN**

SHEET NUMBER

E2

© 2017 The Switzer Group, Inc.

1. ALL LIGHT DIMMERS TO BE GANGED AND STACKED TOGETHER AS REQUIRED. DIMMERS SHALL BE MOUNTED 3'-6" AFF TO THE CENTERLINE UNLESS NOTED OTHERWISE.
2. ALL DIMMERS SHALL BE LUTRON "MAESTRO C-L SERIES". DIMMERS SHALL BE WHITE.
3. OPEN AREA LIGHTING SHALL BE CONTROLLED BY CEILING MOUNTED MOTION SENSORS AS MANUFACTURED BY LUTROM, MODEL "LOS-CDT-1000-WH". PROVIDE NECESSARY POWER PACK AND WALL MOUNTED LOW VOLTAGE OVER-RIDE SWITCH AT AREA ENTRANCE.
4. INSTALL ALL LIGHT FIXTURES IN ACCORDANCE WITH THE ARCHITECTURAL REFLECTED CEILING PLAN.

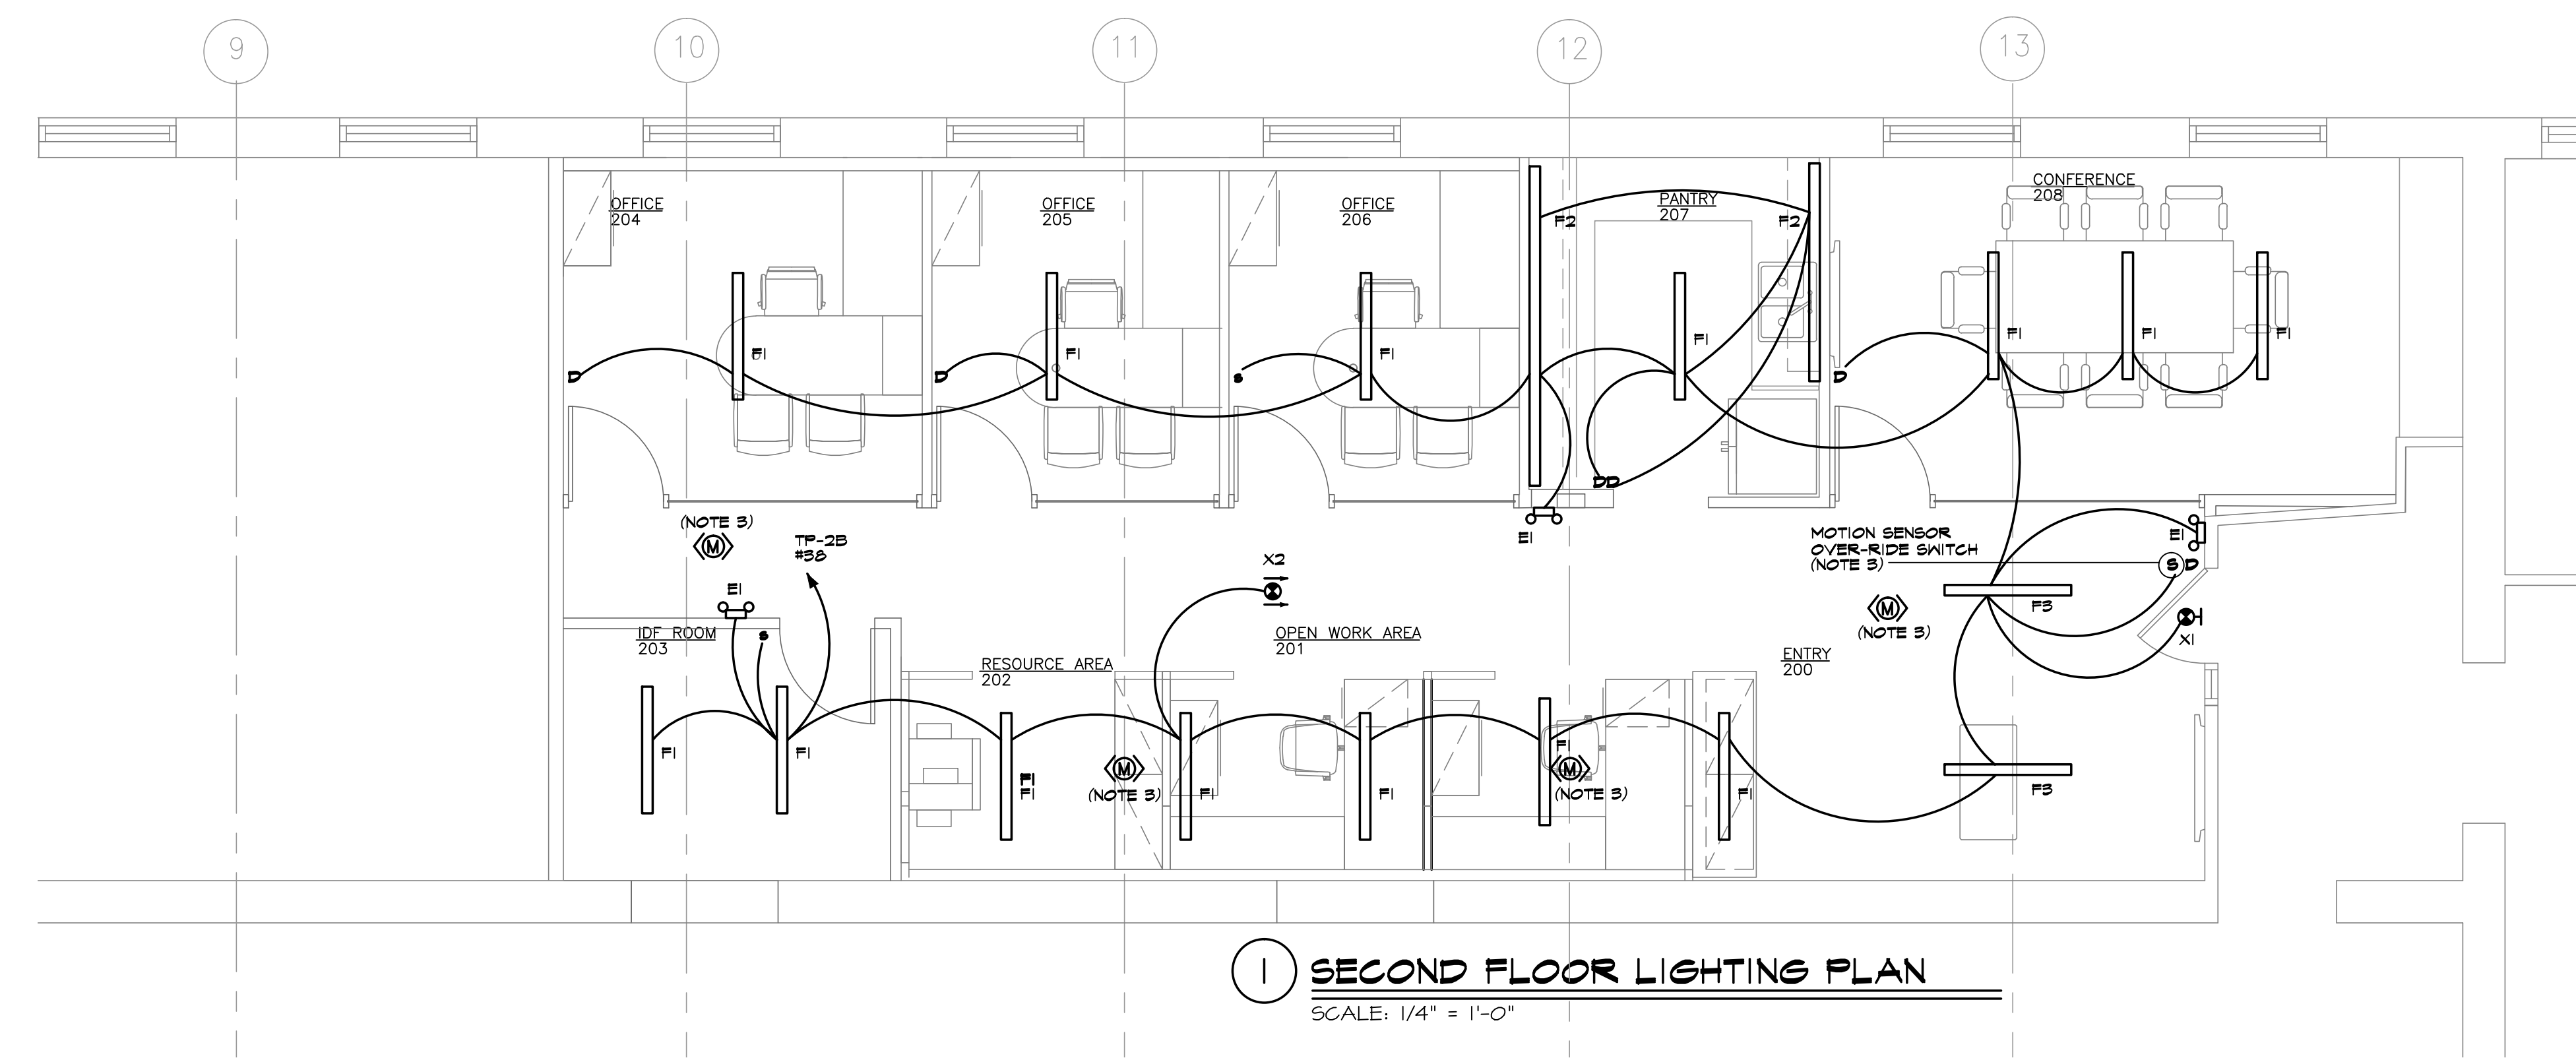

1 SECOND FLOOR LIGHTING PLAN
SCALE: 1/4" = 1'-0"

2 LIGHTING FIXTURE SCHEDULE

Type	Description	Manufacturer	Catalog No.	Lamps	Volts	Remarks
F1	LED PENDANT MOUNTED FIXTURE	COOPER LIGHTING	4SNLED-LD4-33SL-LW-UNV-L835-CD1-U-SCA-48-B	LED 3500K	120	GENERAL LIGHTING. CONTRACTOR TO COORDINATE WITH ARCHITECTURAL DRAWINGS.
F2	UNDER-CABINET LIGHT FIXTURE	TECH LIGHTING	700UCF-9-W-LED	LED 3500K	120	PANTRY UNDER-CABINET FIXTURE IN LENGTHS SHOWN.
F3	SURFACE MOUNTED FIXTURE	NEO-RAY	S122-DS-LO-35-ITG-0048-1-C-U-ED-1-W	LED 3500K	120	RECEPTION SURFACE MOUNTED FIXTURE.
E1	EMERGENCY LIGHT FIXTURE	SURE-LITES	SEL-25	LED 4000K	120	MOUNT ON WALL AT 7'-6" AFF.
X1	SINGLE SIDED WALL EXIT SIGN	ATLITE	TAC16RCWHAR	LED 4000K	120	MOUNT ON WALL IMMEDIATELY ABOVE DOOR HEAD.
X2	DOUBLE SIDED CEILING EXIT SIGN	ATLITE	TAC16RCWHAR	LED 4000K	120	CEILING MOUNTED WITH DIRECTIONAL ARROWS.



MECHANICAL SYSTEMS ENGINEERS
ROYAL RIVER CENTER, UNIT 10B
10 FOREST FALLS DRIVE, YARMOUTH, MAINE 04096
(207) 846-1441
FACEBOOK: MECHANICAL SYSTEMS ENGINEERS
© COPYRIGHT 2017
M.S.E. Proj. 1728