


**MECHANICAL MEZZANINE**  
1/4" = 1'-0"

**LIGHTING FIXTURES:**

- A1 COLUMBIA LIGHTING #VRW4-332-EU  
SURFACE MOUNTED FLUORESCENT LIGHT WITH WHITE FLUSH ALUMINUM FRAME, ACRYLIC PRISMATIC LENS AND ELECTRONIC NON-DIMMING BALLAST. SUITABLE FOR WET LOCATIONS.  
DIMENSIONS: 12-5/16"W x 48-3/4"L x 2-3/4"D  
LAMPS: (3) F32T8/3500K LINEAR FLUORESCENT
- A2 COLUMBIA LIGHTING #PM24-332-FA12-EU  
SURFACE MOUNTED FLUORESCENT LIGHT WITH WHITE FLUSH ALUMINUM FRAME, ACRYLIC PRISMATIC LENS AND ELECTRONIC NON-DIMMING BALLAST.  
DIMENSIONS: 24"W x 48"L x 3-1/2"D  
LAMPS: (3) F32T8/3500K LINEAR FLUORESCENT
- C1 AMERICAN SCIENTIFIC LIGHTING #CC1/2/26/2700K/HPF/RUST/17"/ES  
SURFACE CEILING LUMINAIRE WITH ALUMINUM HOUSING WITH RUST FINISH COLOR, AND WITH WHITE ACRYLIC DIFFUSER. LUMINAIRE SHALL INCLUDE AN ELECTRONIC NON-DIMMING BALLAST.  
DIMENSIONS: 3-1/2"H x 17"DIA  
LAMPS: (2) 26Q/2700K COMPACT FLUORESCENT
- E1 DUAL-LITE #EL-2-B  
SURFACE WALL MOUNTED EMERGENCY EXIT LIGHT WITH TWIN LED LAMPS. LUMINAIRE SHALL INCLUDE AN INTEGRAL BATTERY SUPPLY RATED TO OPERATE FIXTURE FOR 90 MINUTES UPON LOSS OF NORMAL POWER. LUMINAIRE COLOR SHALL BE BLACK.  
DIMENSIONS: 5"H x 8-1/2"L x 2-1/4"D  
LAMPS: (2) BY MANUFACTURER

- J1 COLUMBIA LIGHTING #WC4-232-EU  
SURFACE MOUNTED FLUORESCENT LIGHT WITH WHITE FLUSH ALUMINUM FRAME, ACRYLIC PRISMATIC LENS AND ELECTRONIC NON-DIMMING BALLAST.  
DIMENSIONS: 10"W x 48"L x 2-15/16"D  
LAMPS: (2) F32T8/3500K LINEAR FLUORESCENT
- W1 AMERICAN SCIENTIFIC LIGHTING #DSV/2/26/2700K/HPF/FW/ES  
WALL MOUNTED LUMINAIRE METAL END CAPS PAINTED WHITE AND WITH WHITE ACRYLIC DIFFUSER. LUMINAIRE SHALL INCLUDE AN ELECTRONIC, NON-DIMMING BALLAST. INSTALL LUMINAIRE ABOVE VANITY MIRROR.  
DIMENSIONS: 11"H x 15"L x 10"D  
LAMPS: (2) 26Q/2700K COMPACT FLUORESCENT
- X1 DUAL-LITE #EL-2-B  
SURFACE WALL MOUNTED EMERGENCY EXIT SIGN WITH LED LAMPS. LUMINAIRE SHALL INCLUDE AN INTEGRAL BATTERY SUPPLY RATED TO OPERATE FIXTURE FOR 90 MINUTES UPON LOSS OF NORMAL POWER. LUMINAIRE COLOR SHALL BE BLACK AND SHALL HAVE GREEN LETTERS.  
DIMENSIONS: 9"H x 13"L x 1-7/8"D  
LAMPS: LED BY MANUFACTURER


WHERE JUNCTION BOXES ARE SHOWN FOR LIGHTING, OWNER WILL PROVIDE LIGHTING FIXTURE.

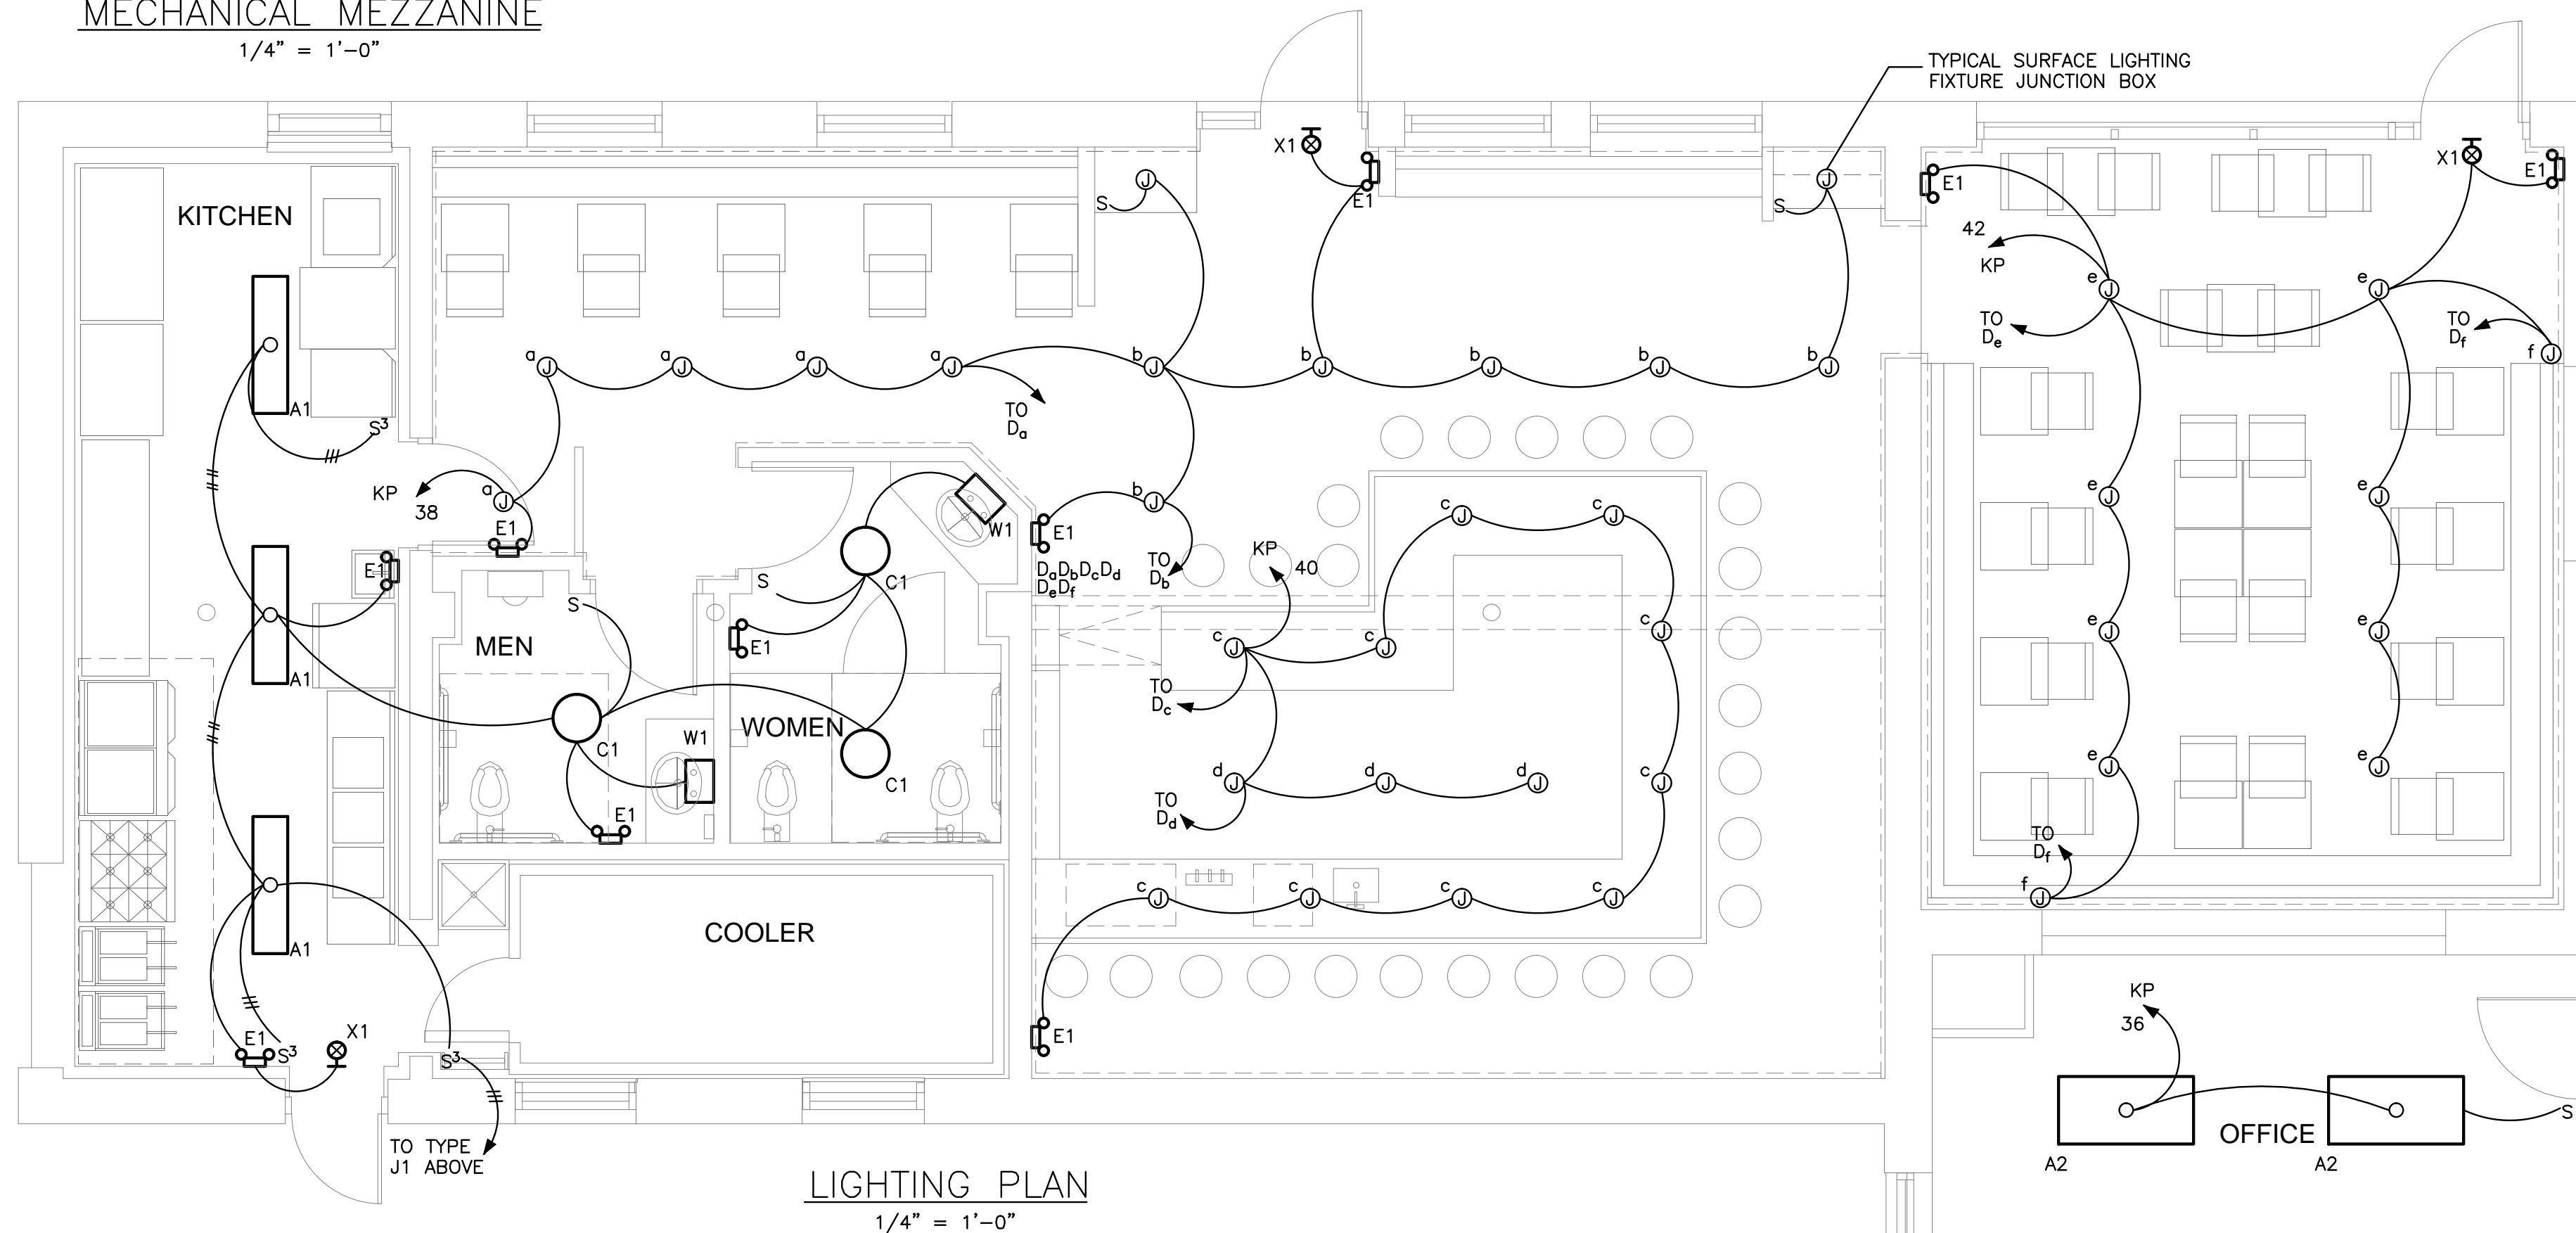

**LIGHTING PLAN**  
1/4" = 1'-0"



5 Milk Street  
Portland, Maine 04101  
207 774 4811  
www.wintonscott.com

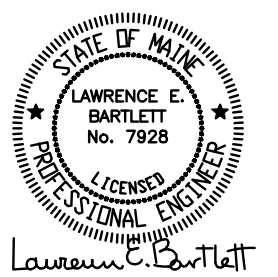

**KING'S HEAD**  
Tenant Fit Up

Merrill's Wharf  
Portland, Maine

REVISIONS

PERMIT DOCUMETS  
June 07, 2013

**Lighting Plan**

Scale: As Noted