


BASEMENT PLUMBING PLAN

SCALE: 1/8" = 1'-0"

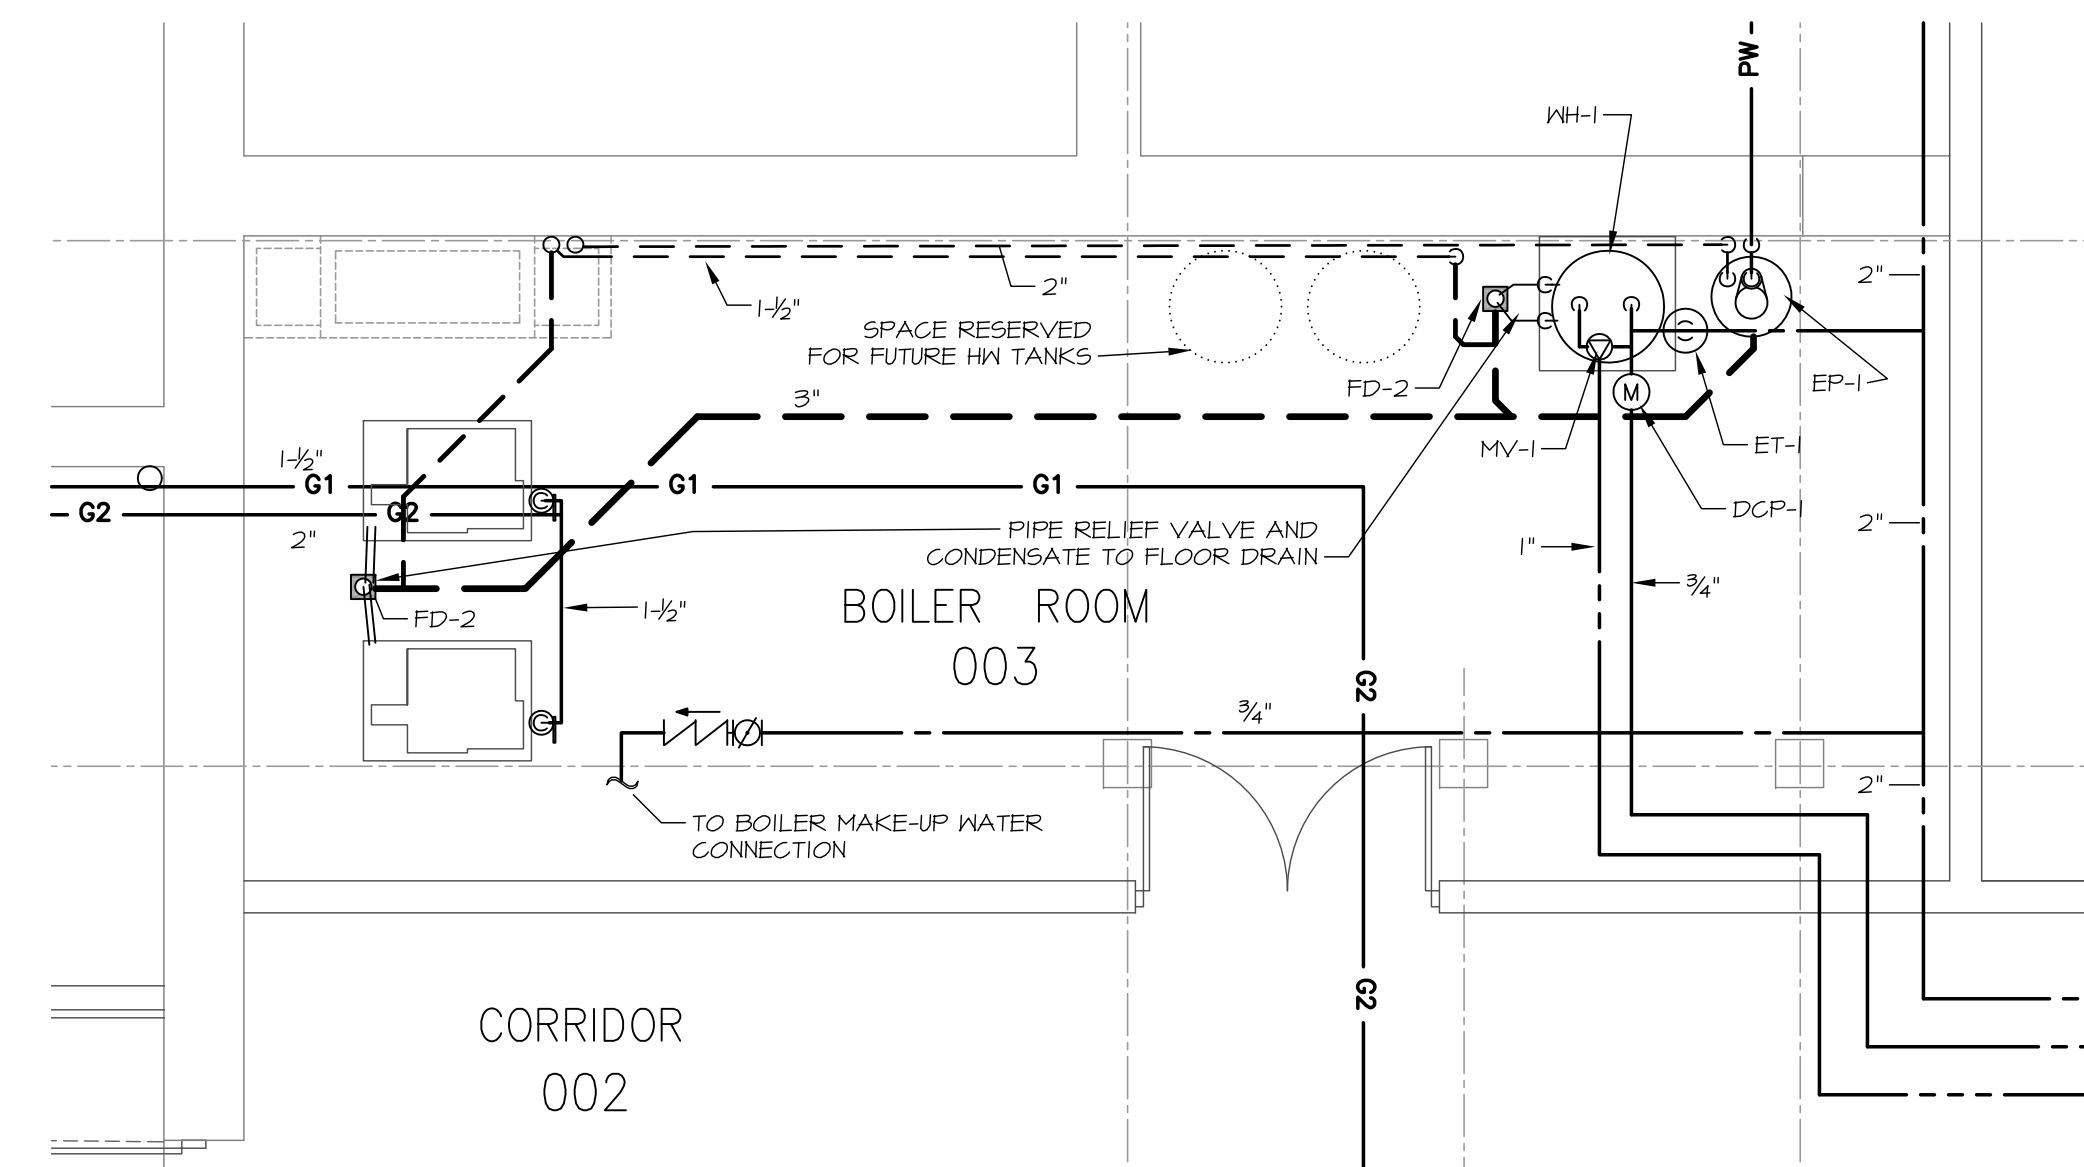



BOILER RM. PLUMBING PLAN

SCALE: 1/4" = 1'-0"



MECHANICAL SYSTEMS ENGINEERS
 ROYAL RIVER CENTER, UNIT #10
 10 FOREST FALLS DRIVE
 YARMOUTH, MAINE 04096
 VOICE: (207) 846-1441
 FAX: (207) 846-1443
 © COPYRIGHT 2010
 M.S.E. Proj. 1020

September 22, 2010 - 12:47 pm
 \\Merrill\Projects\1020 Cumberland Cold Storage Drawings\1020_P1-P7.dwg

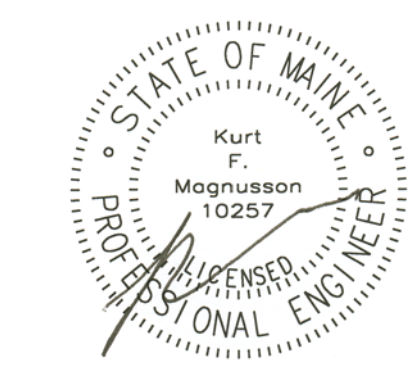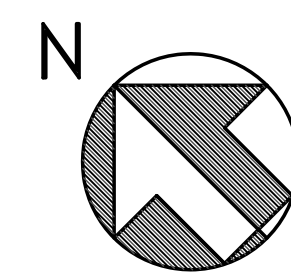

Blais Civil Engineers, PA
 780 Broadway
 South Portland, Maine 04106
 T. 207.767.7300
 sblaise@blaisece.com

Bartlett Design
 942 Washington Street
 Bath, Maine 04530
 T. 207.443.5447 F. 207.443.5560
 bartdes@blazenetme.net

Mechanical Systems Engineers
 Royal River Center, Unit #10
 10 Forest Falls Drive, Yarmouth, Maine 04096
 T. 207.846.1441 F. 207.846.1443

Carroll Associates Landscape Architects
 217 Commercial Street, Suite 200
 Portland, Maine 04101
 T. 207.772.1552 F. 207.772.0712

Becker Structural Engineers, Inc.
 75 York Street, Portland, Maine 04101
 T. 207.879.1838 F. 207.879.1822
 www.beckerstructural.com

Winton Scott Architects, PA
 5 Milk Street, Portland, Maine 04101
 207.774.4811 www.wintonscott.com

REV #	DATE	DESCRIPTION

Renovations To:
CUMBERLAND COLD STORAGE BUILDING
 Merrill's Wharf, Portland, Maine

BASEMENT PLUMBING PLAN

P1

9.23.2010