
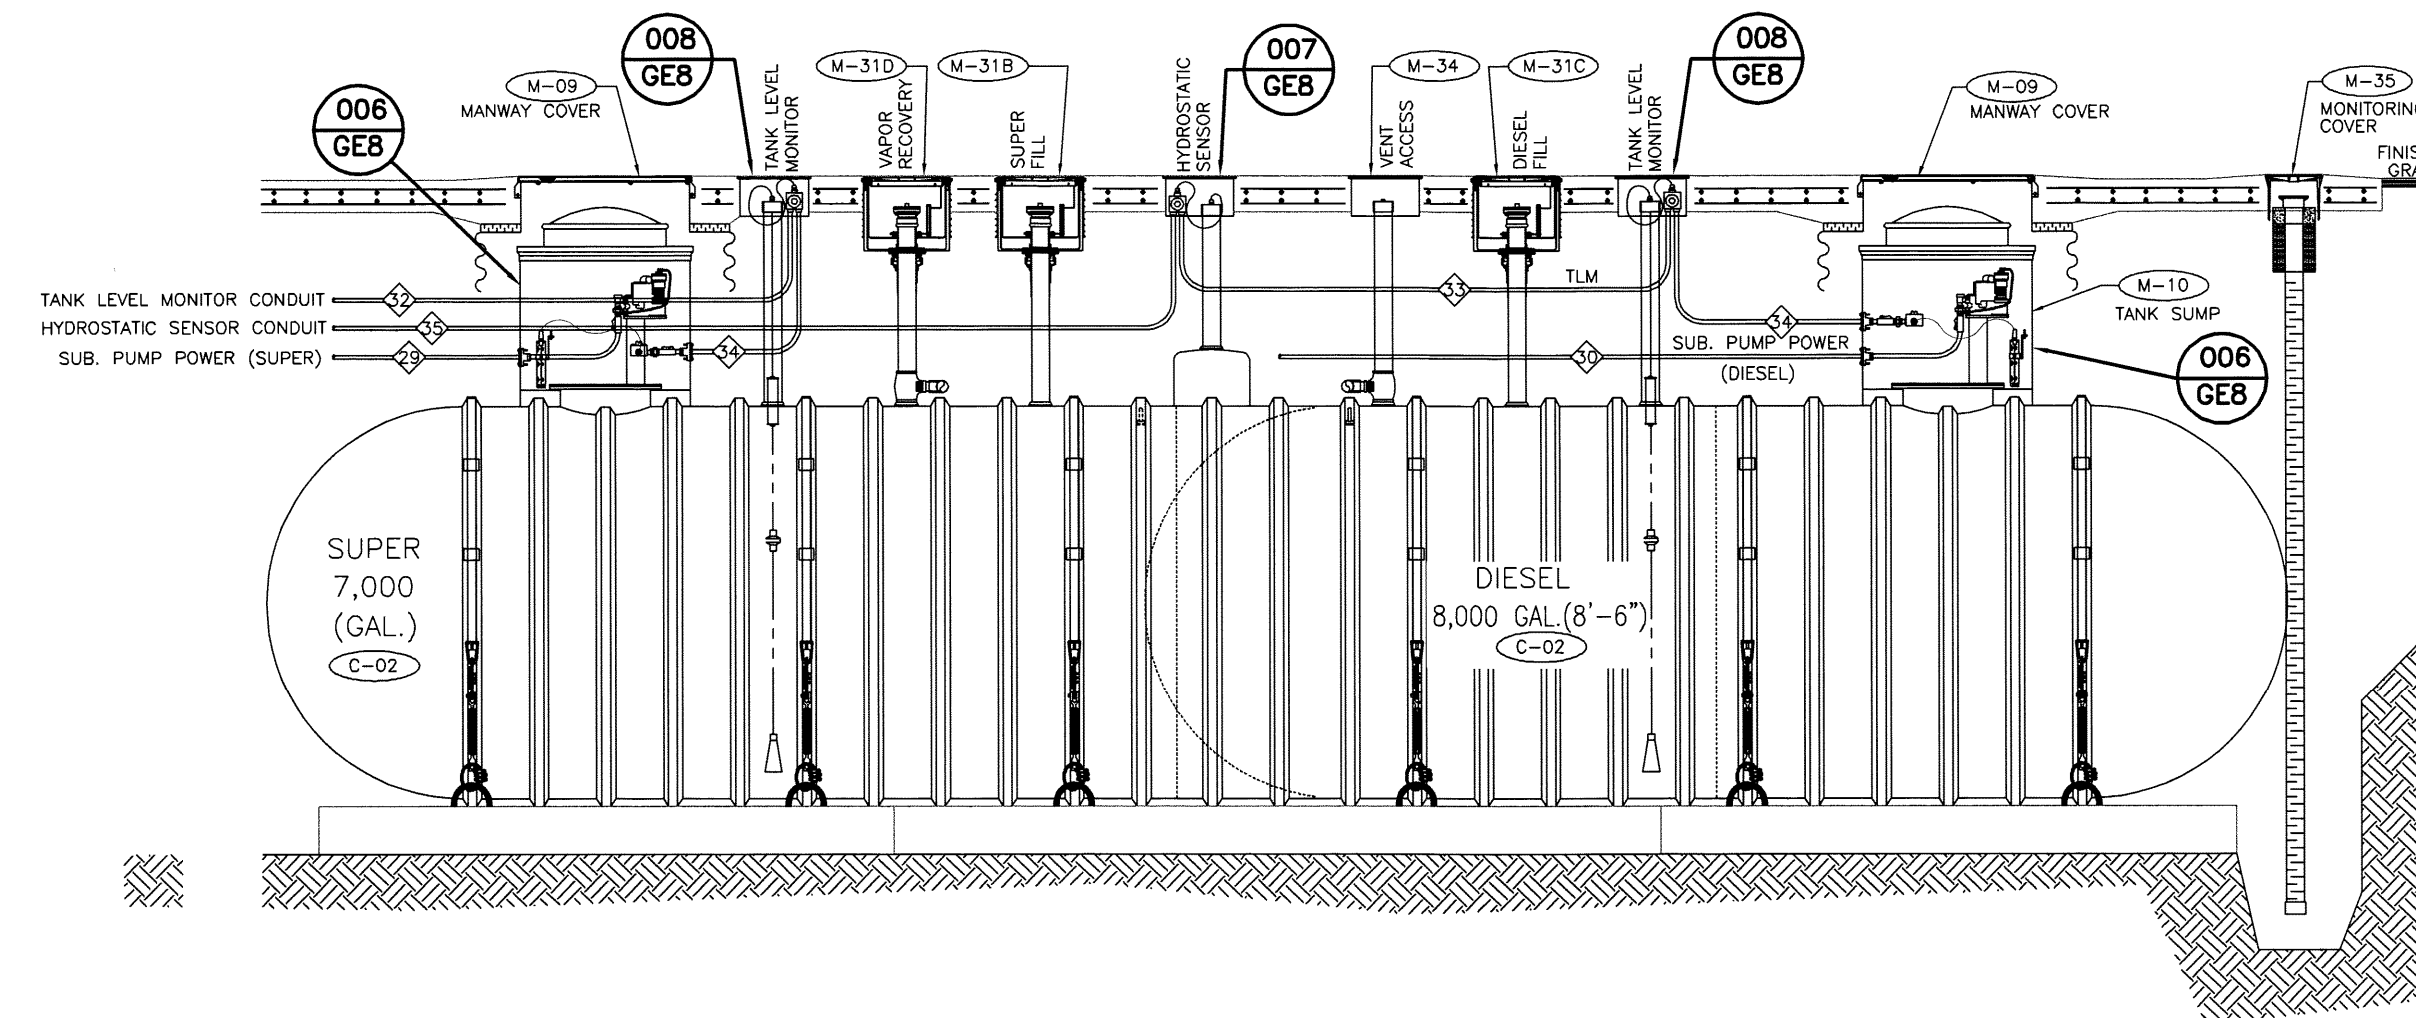
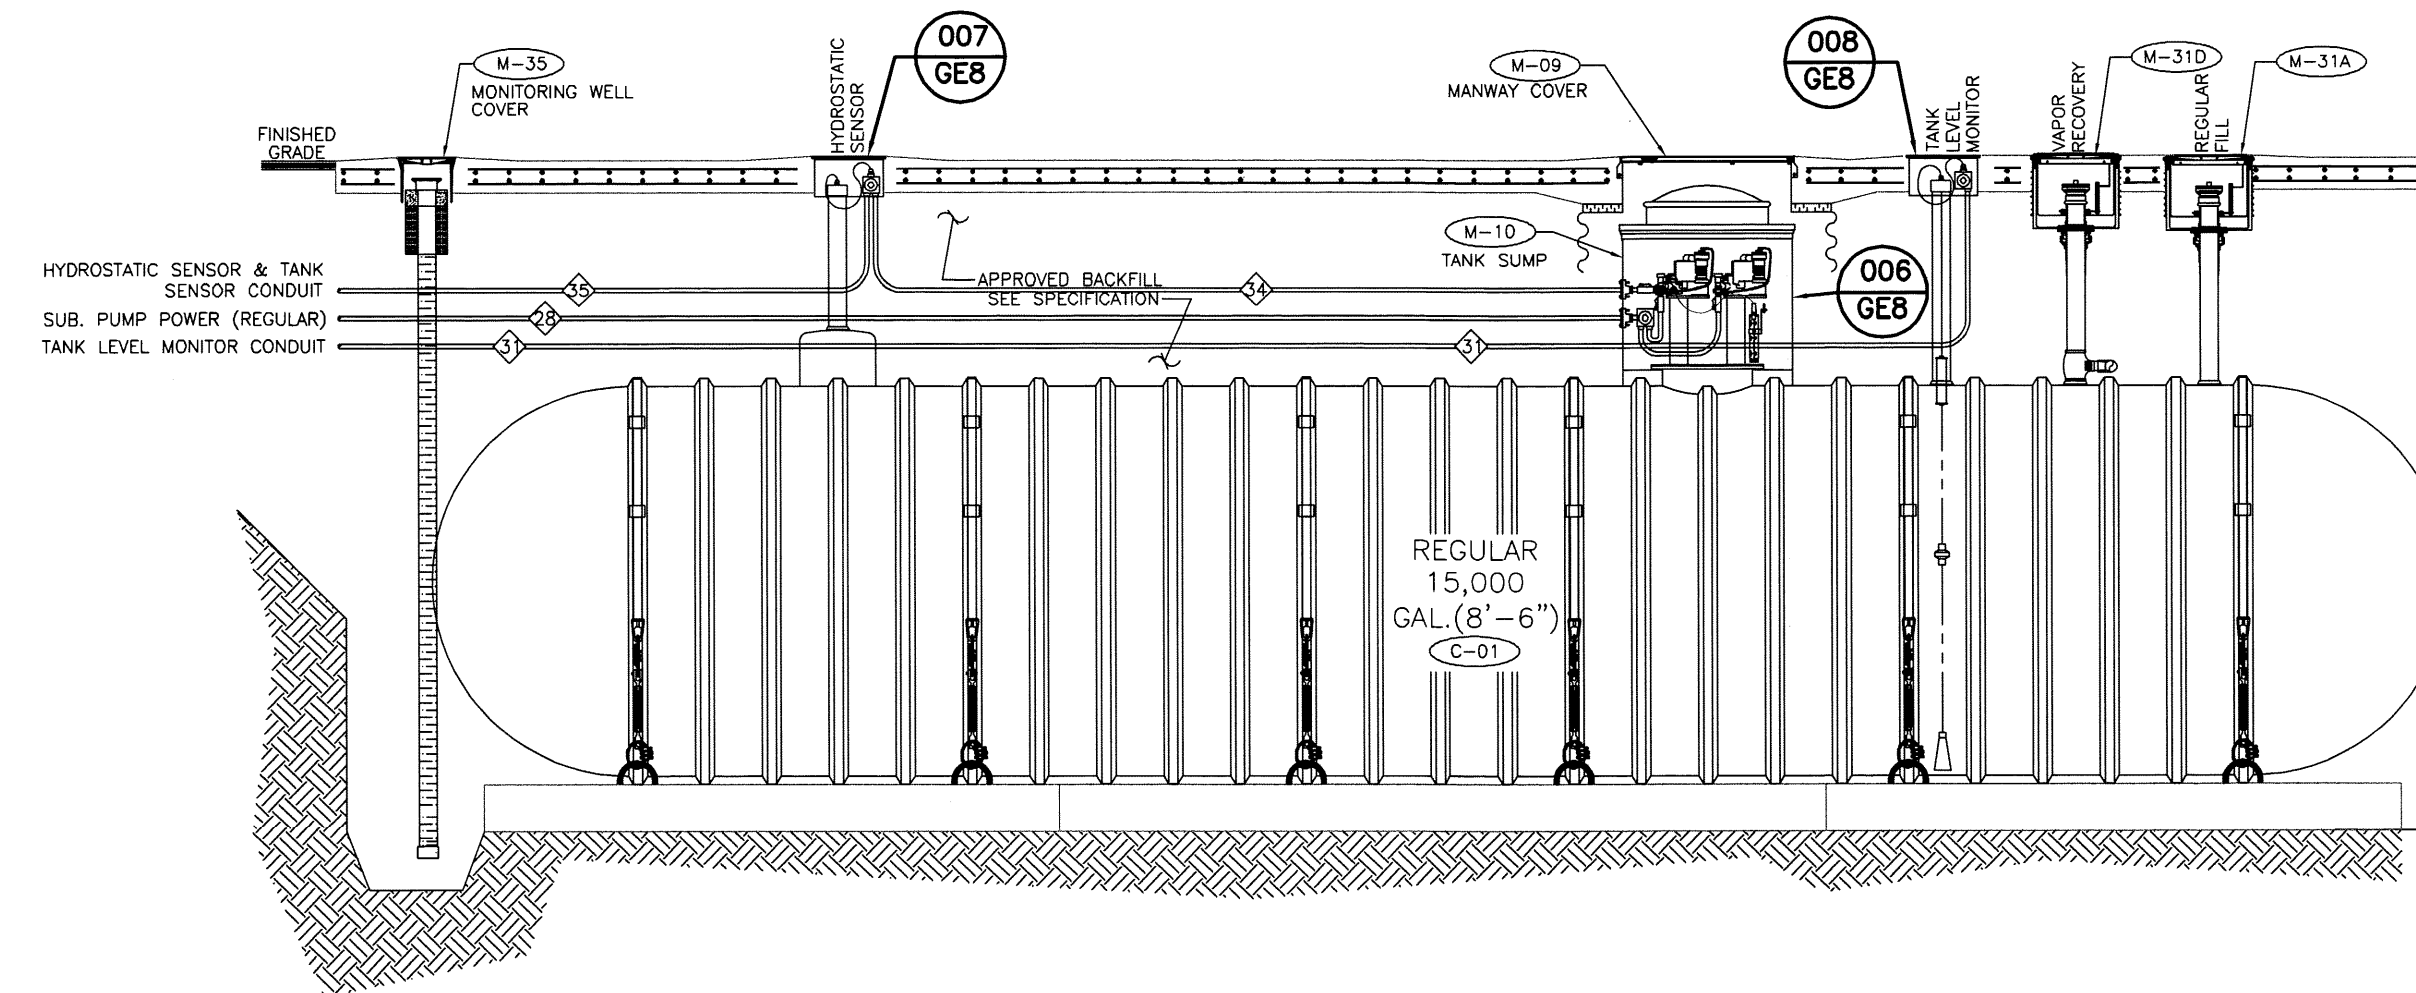


- SUPERSEDES ALL PREVIOUS ISSUES
- APPROVED FOR CONSTRUCTION
- PRELIMINARY-NOT FOR CONSTRUCTION
- ISSUED TO: \_\_\_\_\_


DATE \_\_\_\_\_

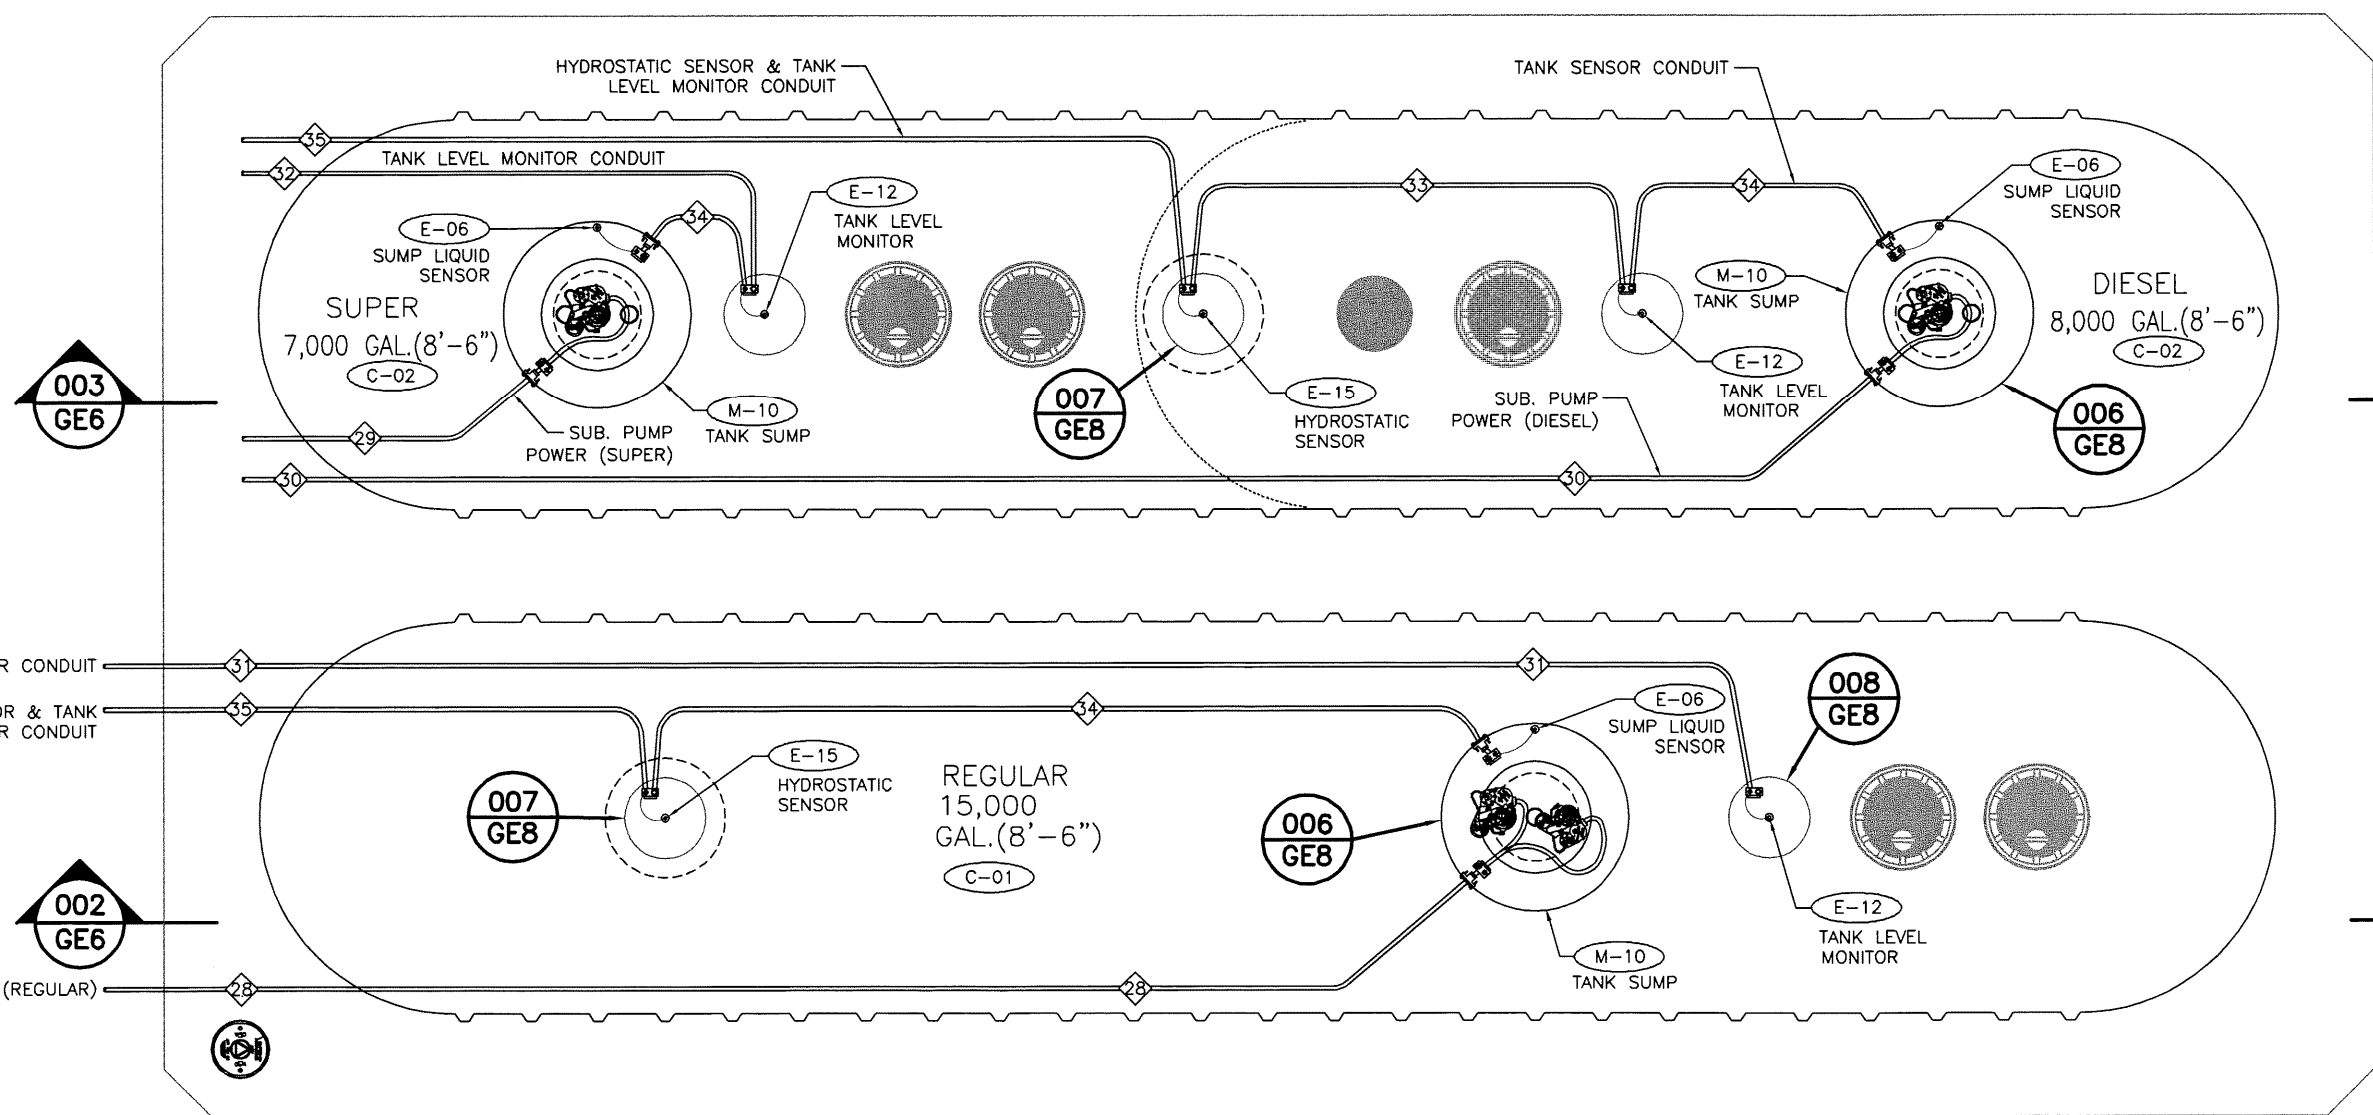

CONDUIT SCHEDULE			
INDIVIDUAL CONDUIT RUNS		INDIVIDUAL CONDUIT RUNS	
No.	USE	CONDUIT SIZE	WIRE SIZE
1	- DISPENSER SUMP SENSOR - HOME RUN	(1" ø)	4PR. #18 AWG INDIVIDUALLY SHIELDED
2	- DISPENSER SUMP SENSOR - IN LINE	(1" ø)	4PR. #18 AWG INDIVIDUALLY SHIELDED
3	- DISPENSER NO. 1 POWER / DATA - HOME RUN	(1" ø)	8C. #12 AWG THHN
4	- DISPENSER NO. 2 POWER / DATA - HOME RUN	(1" ø)	8C. #12 AWG THHN
5	- DISPENSER NO. 3 POWER / DATA - HOME RUN	(1" ø)	8C. #12 AWG THHN
6	- DISPENSER NO. 4 POWER / DATA - HOME RUN	(1" ø)	8C. #12 AWG THHN
7	- DISPENSER NO. 5 POWER / DATA - HOME RUN	(1" ø)	8C. #12 AWG THHN
8	- DISPENSER NO. 6 POWER / DATA - HOME RUN	(1" ø)	8C. #12 AWG THHN
9	- DISPENSER NO. 7 POWER / DATA - HOME RUN	(1" ø)	8C. #12 AWG THHN
10	- DISPENSER NO. 8 POWER / DATA - HOME RUN	(1" ø)	8C. #12 AWG THHN
11	- DISPENSER NO. 1 SPARE / (CATS) - HOME RUN	(1" ø)	(1/4" PULL ROPE)
12	- DISPENSER NO. 2 SPARE / (CATS) - HOME RUN	(1" ø)	(1/4" PULL ROPE)
13	- DISPENSER NO. 3 SPARE / (CATS) - HOME RUN	(1" ø)	(1/4" PULL ROPE)
14	- DISPENSER NO. 4 SPARE / (CATS) - HOME RUN	(1" ø)	(1/4" PULL ROPE)
15	- DISPENSER NO. 5 SPARE / (CATS) - HOME RUN	(1" ø)	(1/4" PULL ROPE)
16	- DISPENSER NO. 6 SPARE / (CATS) - HOME RUN	(1" ø)	(1/4" PULL ROPE)
17	- DISPENSER NO. 7 SPARE / (CATS) - HOME RUN	(1" ø)	(1/4" PULL ROPE)
18	- DISPENSER NO. 8 SPARE / (CATS) - HOME RUN	(1" ø)	(1/4" PULL ROPE)
19	- DISPENSER INTERCOM - HOME RUN	(1" ø)	4PR. #18 AWG UNSHIELDED TWISTED PAIR
20	- DISPENSER INTERCOM - IN LINE	(1" ø)	4PR. #18 AWG UNSHIELDED TWISTED PAIR
21	- CANOPY LIGHTING - HOME RUN	(1" ø)	12C. #12 AWG THHN
22	- FIRE SUPPRESSION - HOME RUN	(1" ø)	(1/4" PULL ROPE)
23	- CANOPY CAMERA - HOME RUN	(1" ø)	12C. #12 AWG THHN
24	- SPARE - HOME RUN	(1" ø)	(1/4" PULL ROPE)
25	-	-	-
26	-	-	-
27	-	-	-
100	-	-	-

REVISIONS

**MHF Design Consultants, Inc.**  
 44 Siles Road, Suite One  
 Salem, New Hampshire 03079  
 (603) 893-0720  
 ENGINEERS PLANNERS + SURVEYORS  
 www.mhfdesign.com

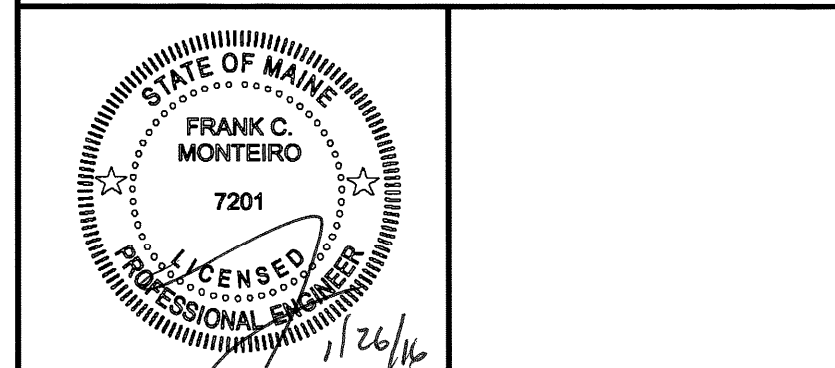

**IRVING**

DRAWN BY:	DESIGNED BY:
DSA	HS
SCALE:	APPROVED BY:
AS NOTED	
DATE:	PROPERTY NO.:
1/26/16	
CAD FILE: 3880 GEB.dwg	REF-BLK:
PLOTTED:	REF-BLK:

**IRVING OIL**  
 190 COMMERCE WAY  
 PORTSMOUTH, NH 03801

PROJECT:  
 393 COMMERCIAL STREET  
 PORTLAND, MAINE

SHEET TITLE:  
**TANK ELECTRICAL LAYOUT AND DETAILS**

PROJECT:	DRAWING NO.:	REVISION:
	<b>GEB6</b>	-

COMPANY SUPERVISOR AND CONTRACTOR TO VERIFY ALL MEASUREMENTS ON WORK OR AT SITE. THIS DRAWING IS THE PROPERTY OF IRVING OIL LTD. AND SHALL BE RETURNED ON COMPLETION OF WORK.

F:\Projects\CAD\388015\3880 GEB.dwg GEB 1/27/16 9:38am DSA