


SUPERSEDES ALL PREVIOUS ISSUES
 APPROVED FOR CONSTRUCTION
 PRELIMINARY—NOT FOR CONSTRUCTION
 ISSUED TO: _____
 DATE _____

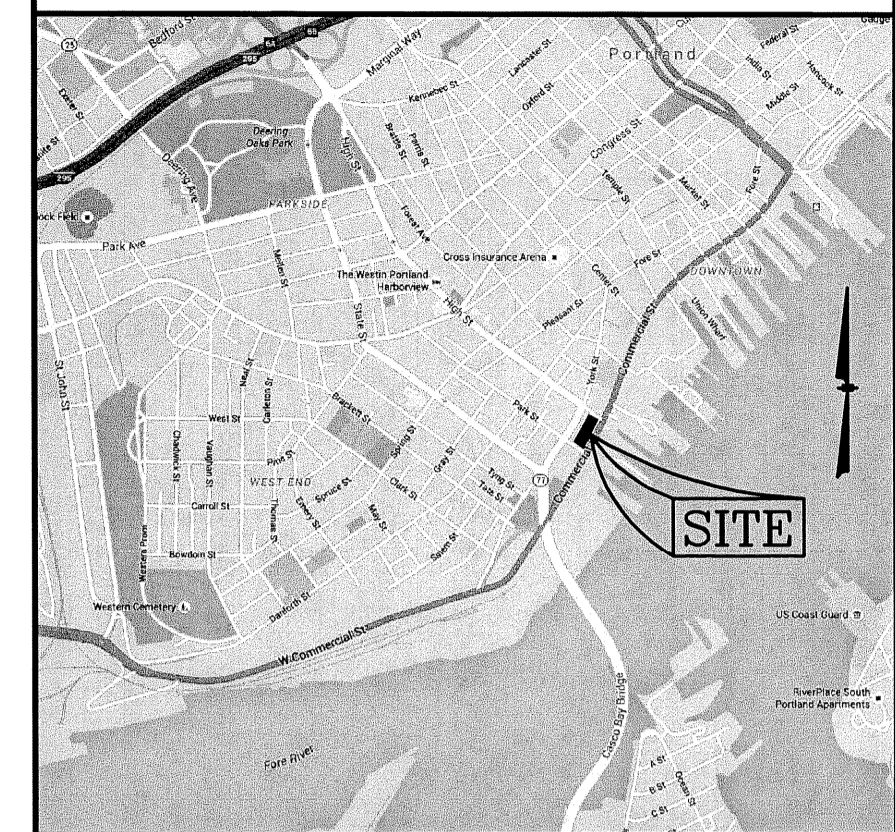

LOCATION MAP
NOT TO SCALE

REV	DATE	BY	REVISION

REVISIONS

MHF Design Consultants, Inc.
 44 Siles Road, Suite One
 Salem, New Hampshire 03079
 (603) 893-0720
 ENGINEERS • PLANNERS • SURVEYORS
 www.mhfdesign.com

STATE OF MAINE
 FRANK C. MONTEIRO
 7201
 LICENSED PROFESSIONAL ENGINEER

DRAWN BY: DSA
 DESIGNED BY: FCM
 SCALE: 1"=10'
 APPROVED BY:
 DATE: 1/26/16
 PROPERTY NO.:
 CAD FILE: 38801P.DWG
 PLOTTED: REF-BLK: REF-BLK: REF-BLK:


IRVING OIL
 190 COMMERCE WAY
 PORTSMOUTH, NH 03801

PROJECT: 393 COMMERCIAL STREET
 PORTLAND, MAINE

SHEET TITLE: **TANK & PIPING PLAN**

PROJECT: UST2
 DRAWING NO: UST2
 REVISION: -

COMPANY SUPERVISOR AND CONTRACTOR TO VERIFY ALL MEASUREMENTS ON WORK OR AT SITE. THIS DRAWING IS THE PROPERTY OF IRVING OIL LTD. AND SHALL BE RETURNED ON COMPLETION OF WORK.

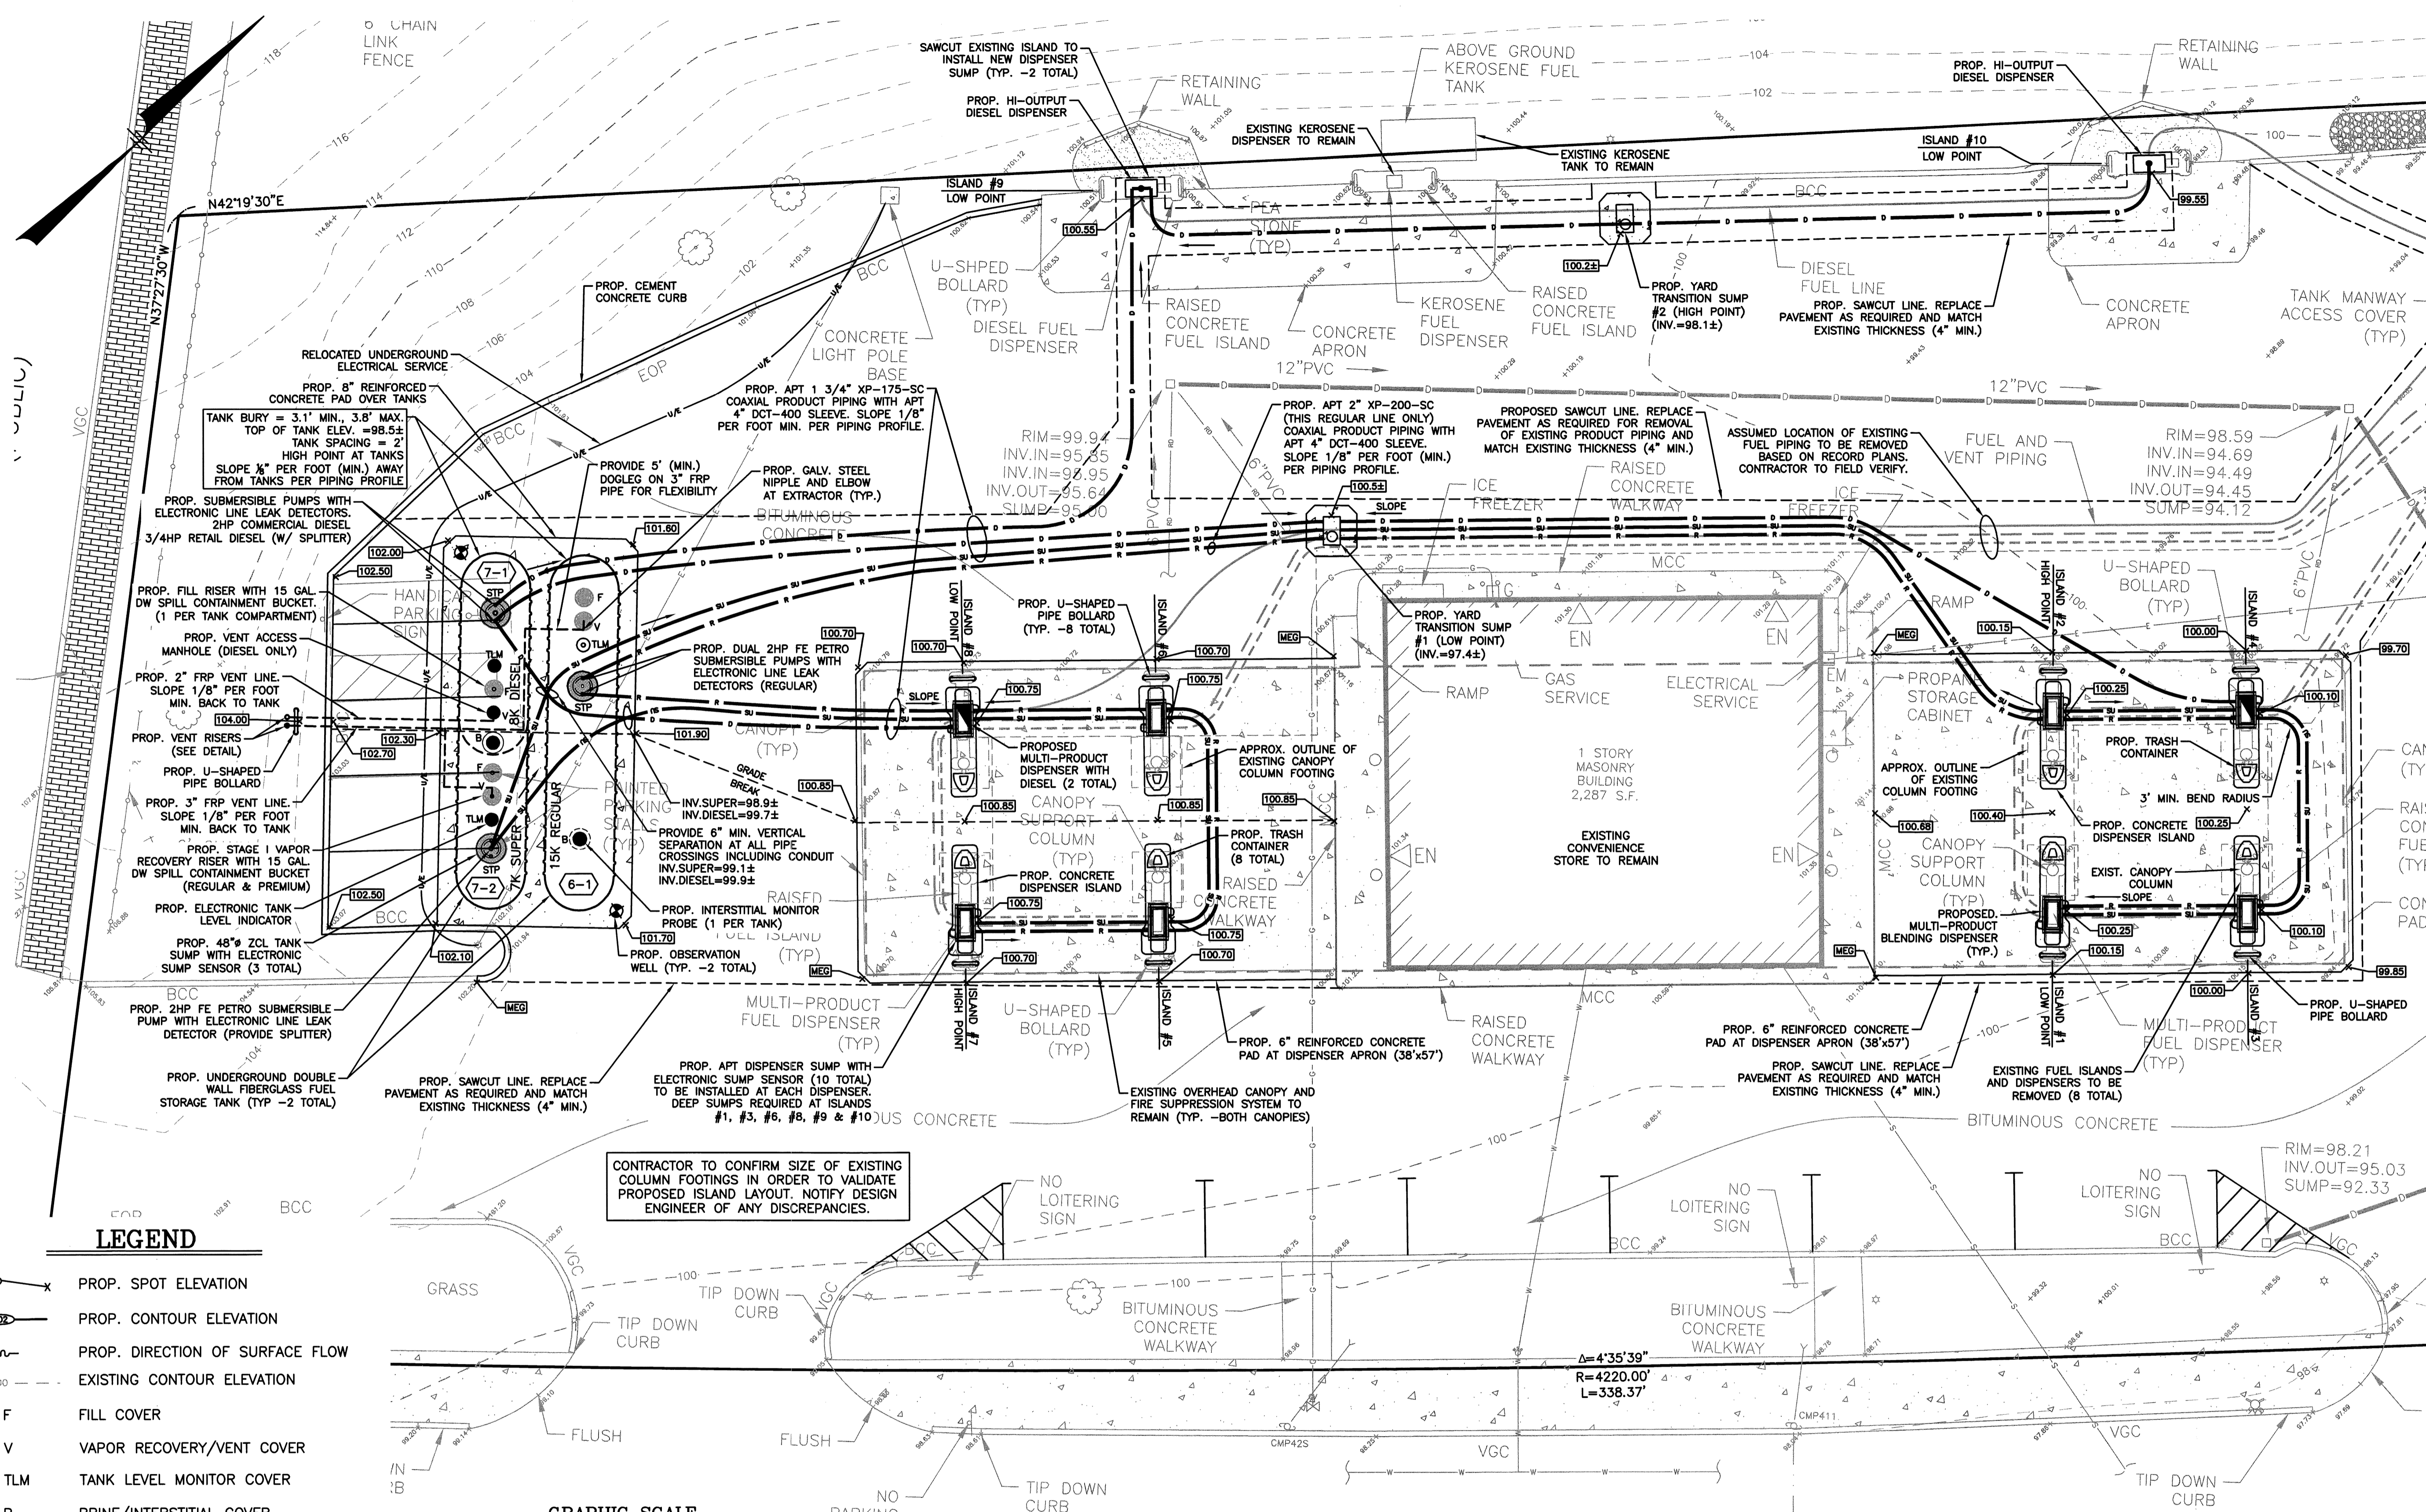

CONTRACTOR TO CONFIRM SIZE OF EXISTING COLUMN FOOTINGS IN ORDER TO VALIDATE PROPOSED ISLAND LAYOUT. NOTIFY DESIGN ENGINEER OF ANY DISCREPANCIES.

LEGEND

- 99.50 PROP. SPOT ELEVATION
- 102 PROP. CONTOUR ELEVATION
- PROP. DIRECTION OF SURFACE FLOW
- 100 EXISTING CONTOUR ELEVATION
- F FILL COVER
- V VAPOR RECOVERY/VENT COVER
- TLM TANK LEVEL MONITOR COVER
- B BRINE/INTERSTITIAL COVER
- STP SUBMERSIBLE TANK PUMP

TANK LEGEND:

4-1 12K REGULAR	EXISTING 12,000 GAL DOUBLE WALL JACKETED STEEL UNDERGROUND STORAGE TANK TO BE ABANDONED IN PLACE. INSTALLED 11/1/1997.
5-1 8K SUPER	EXISTING 8,000 GAL DOUBLE WALL JACKETED STEEL UNDERGROUND STORAGE TANK TO BE ABANDONED IN PLACE. INSTALLED 11/1/1997.
5-2 4K DIESEL	EXISTING 4,000 GAL DOUBLE WALL JACKETED STEEL UNDERGROUND STORAGE TANK TO BE ABANDONED IN PLACE. INSTALLED 11/1/1997.
6-1 15K REGULAR	PROPOSED 15,000 GAL ZCL DOUBLE WALL FRP UNDERGROUND STORAGE TANK
7-1 7-2 BK DIESEL TK SUPER	PROPOSED 15,000 GAL COMPARTMENTALIZED ZCL DOUBLE WALL FIBERGLASS UNDERGROUND STORAGE TANK BASE=BK DIESEL (7-1) AND END=TK SUPER (7-2)

