


**NOTE:**  
1. SEE SHEET M-001 FOR LEGEND AND ABBREVIATIONS.

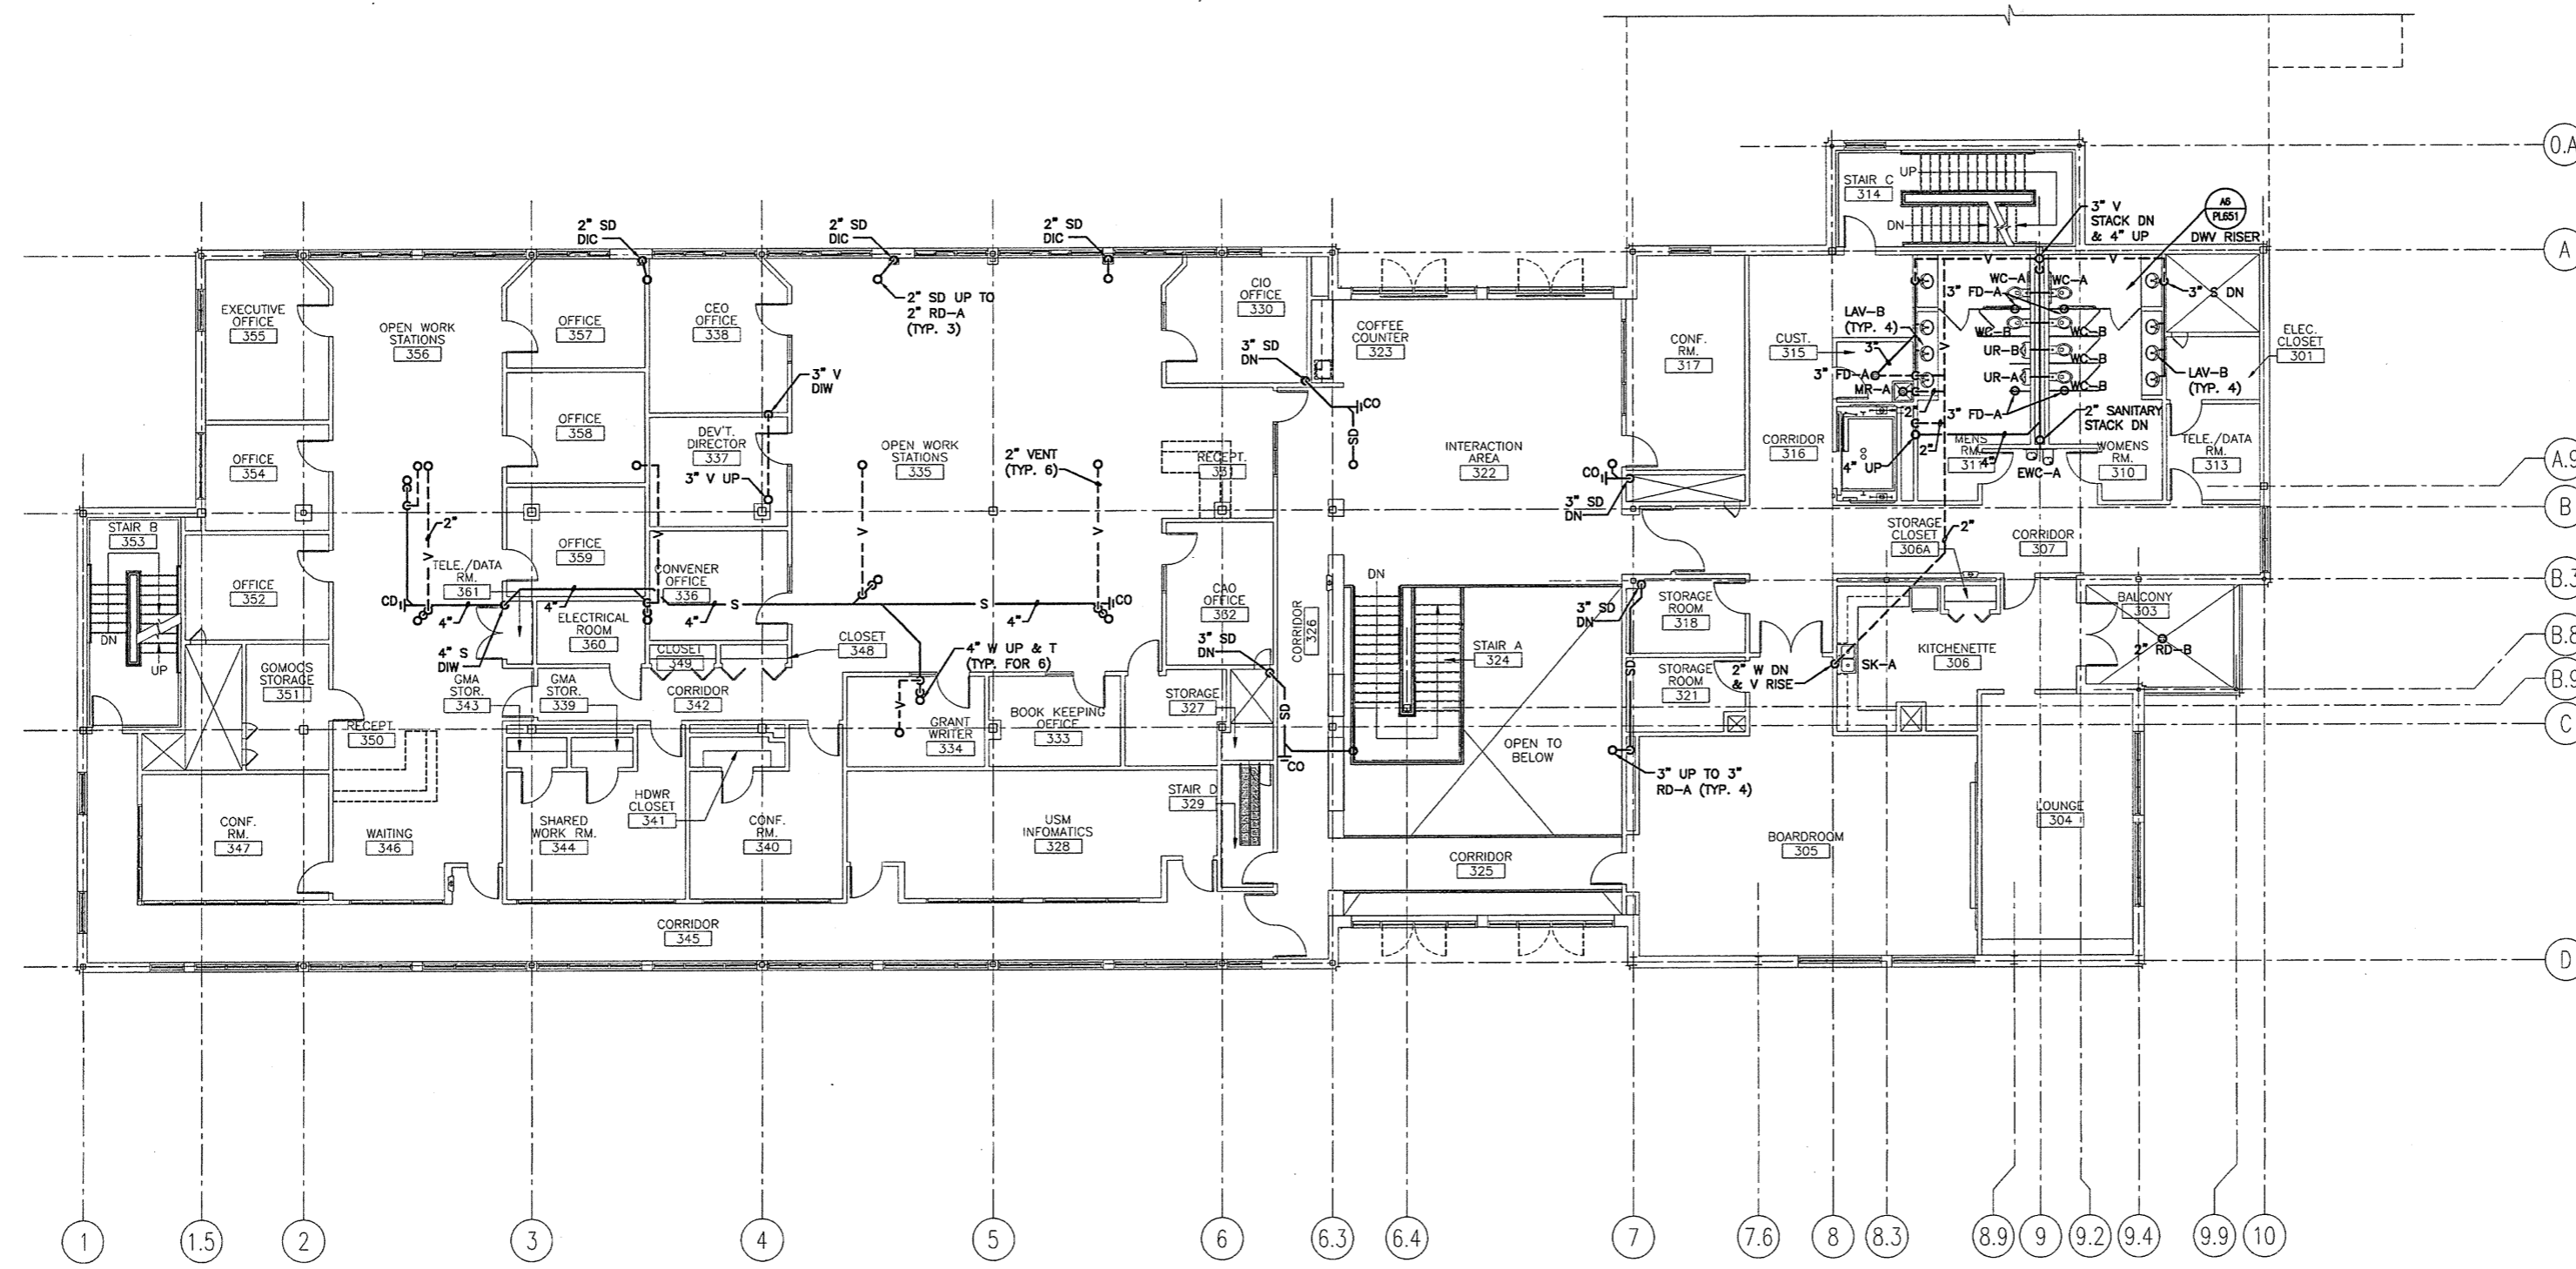

0	ISSUED FOR CONSTRUCTION	10-23-03
REV.	DESCRIPTION	DATE

**ISSUED FOR CONSTRUCTION**  
**10-23-03**

CURRENT ISSUE STATUS:

**SM RT** ARCHITECTURE ENGINEERING PLANNING  
144 Fore Street, P.O. Box 618  
Portland, Maine 04104  
tel. (207) 772-3846  
fax. (207) 772-1070

**THE GULF OF MAINE RESEARCH INSTITUTE**  
PORTLAND, MAINE

**THIRD FLOOR DW PIPING PLAN**

SHEET TITLE:	THIRD FLOOR DW PIPING PLAN
SCALE:	1/8" = 1'-0"
DATE:	10-23-03
PROJECT MANAGER:	DRL
GRAPHIC SCALE:	0" 1"
JOB CAP/DRAWN:	SDL/BOG
A/E OF RECORD:	DBR
SHEET No.:	PL103
SMRT CAD FILE:	PL103-03034
PROJECT No.:	03034

A1 FLOOR PLAN

1/8" = 1'-0"