



NOTE:
1. SEE SHEET M-001 FOR LEGEND AND ABBREVIATIONS.

KEYED NOTE:
① SEAL ALL PENETRATIONS THRU THIS FLOOR.

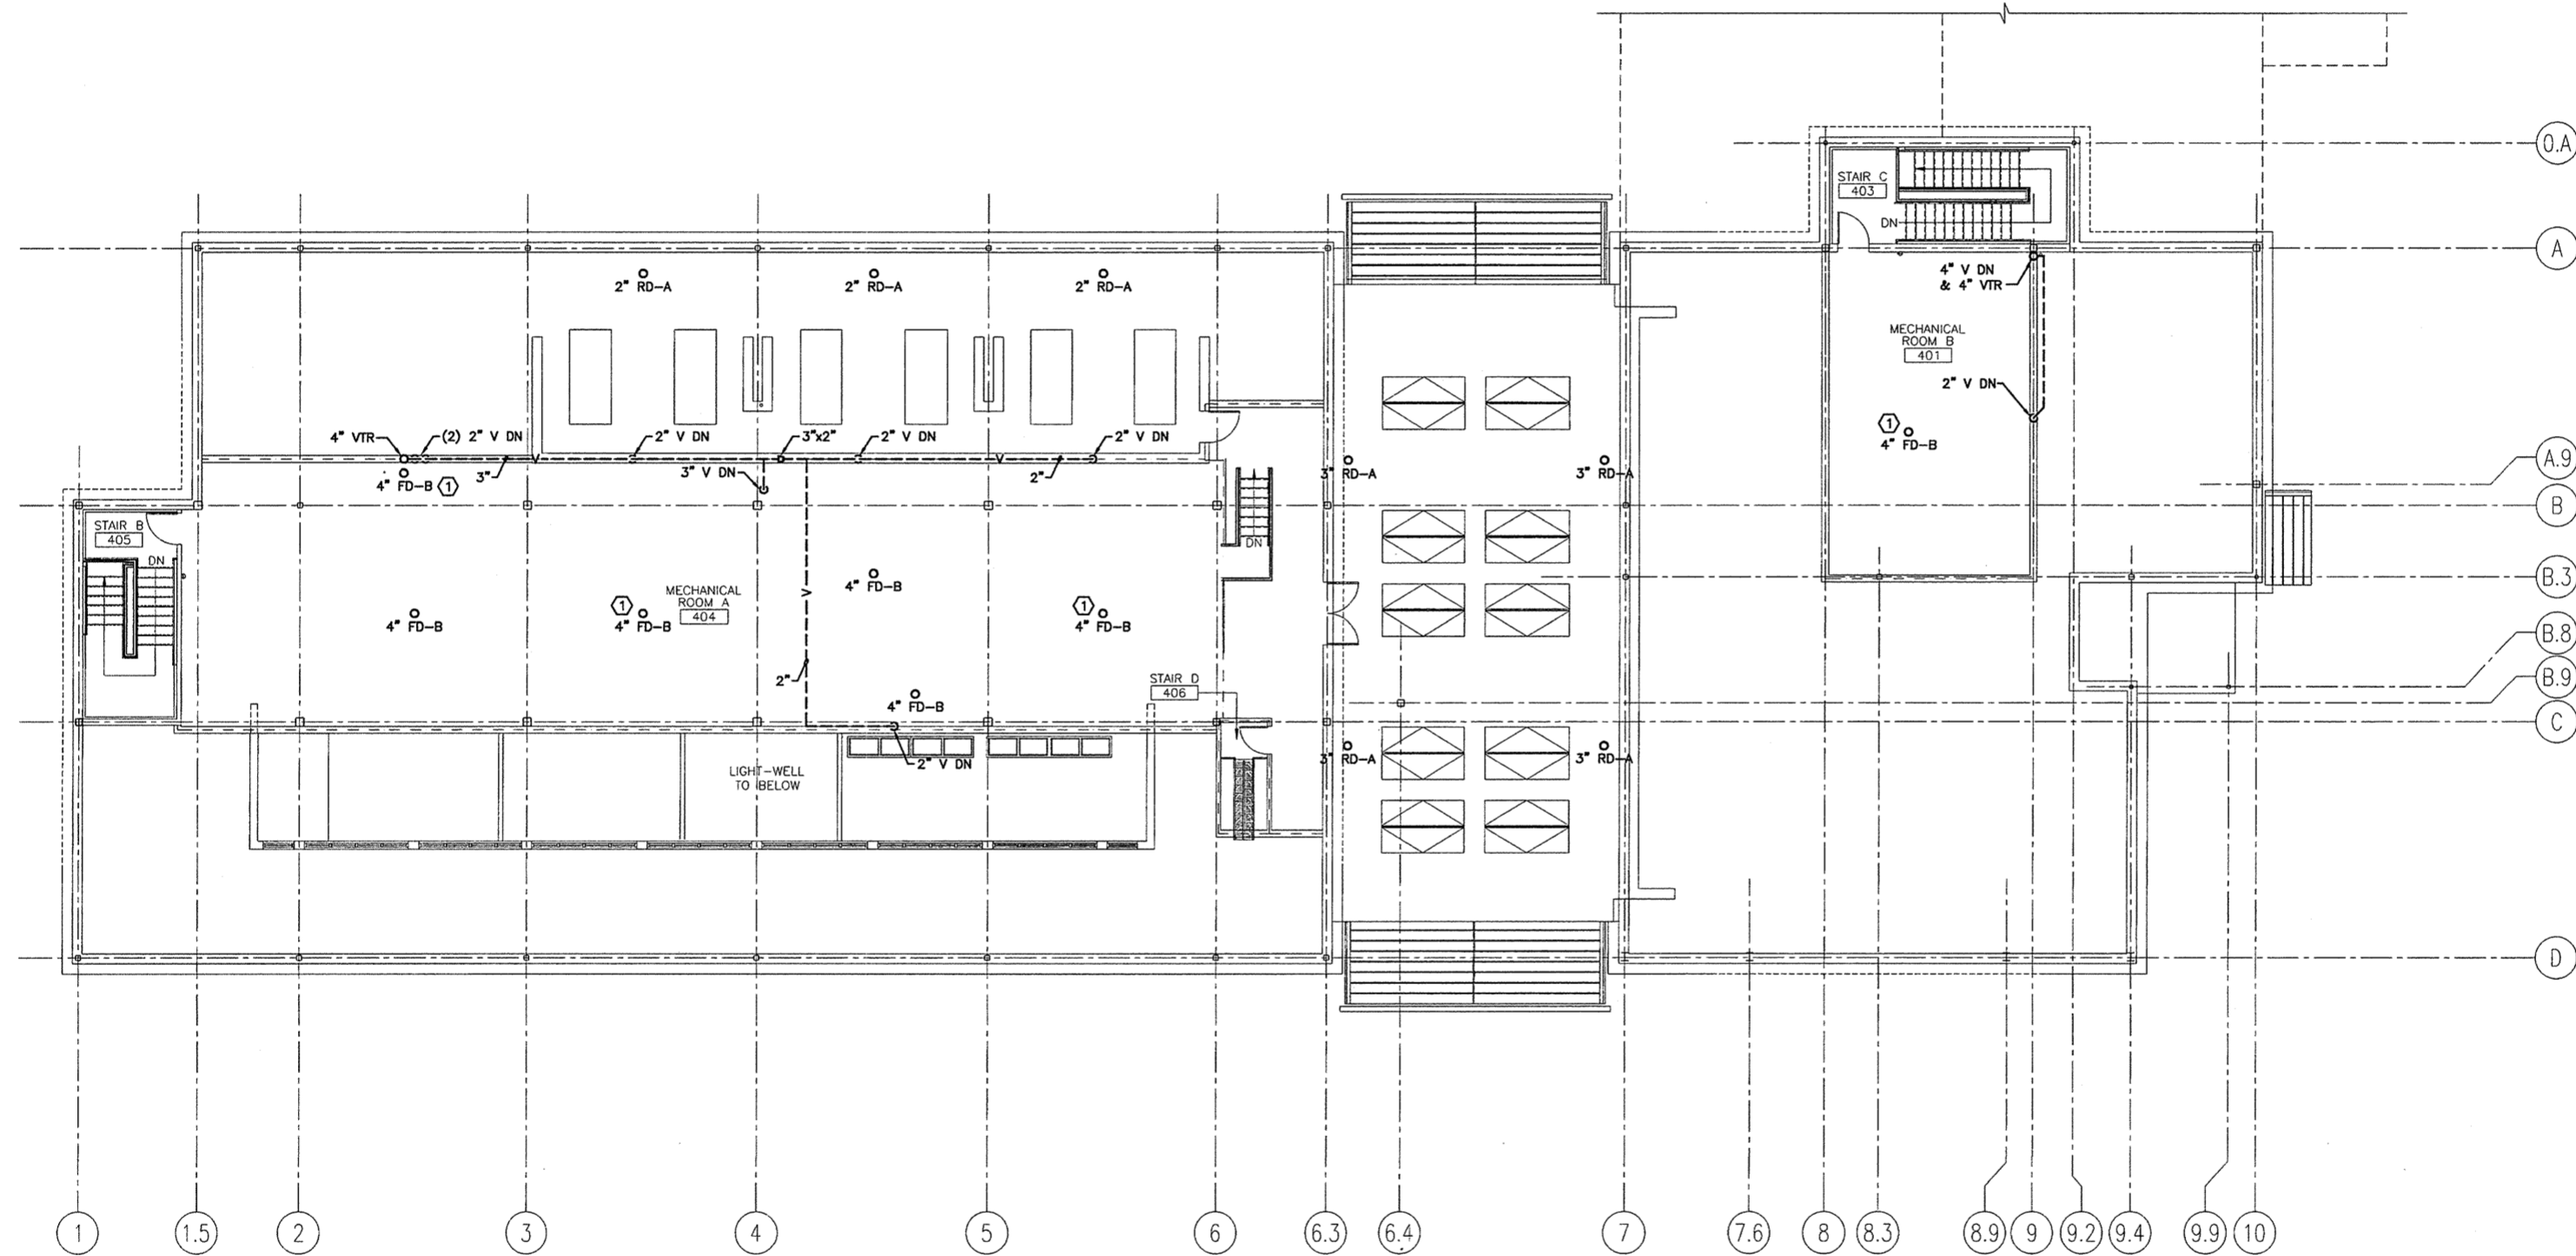

REV.	DESCRIPTION	DATE
0	ISSUED FOR CONSTRUCTION	10-23-03

ISSUED FOR CONSTRUCTION
10-23-03

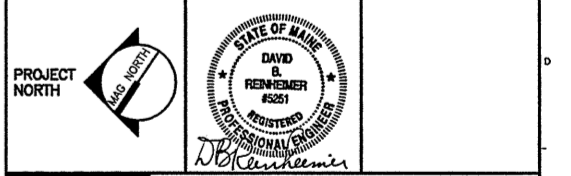

SMRT ARCHITECTURE ENGINEERING PLANNING
SMRT
144 Fore Street P.O. Box 618
Portland, Maine 04104
tel. (207) 772-3846
fax. (207) 772-1070

THE GULF OF MAINE RESEARCH INSTITUTE
PORTLAND, MAINE

MEZZANINE DWV PIPING PLAN

SCALE: 1/8" = 1'-0"	DATE: 10-23-03
PROJECT MANAGER: DRL	GRAPHIC SCALE: 0" 1"
JOB CAP/DRAWN: SDL/BGG	
A/E OF RECORD: DBR	SHEET No.
SMRT CAD FILE: PL104-03034	PL104
PROJECT No. 03034	

A1 FLOOR PLAN

1/8" = 1'-0"