


NOTE:
 1. SEE SHEET M-001 FOR LEGEND AND ABBREVIATIONS.

KEYED NOTE:
 ① 3/4" NG STUB, VALVE & CAP FOR FUTURE.
 ② 1/2" CA DROP IN WALL. SEE DETAIL 19/M-502.
 ③ 1/2" CA DROP TO TURRET ON LAB BENCH. SEE DETAIL 19/M-502.

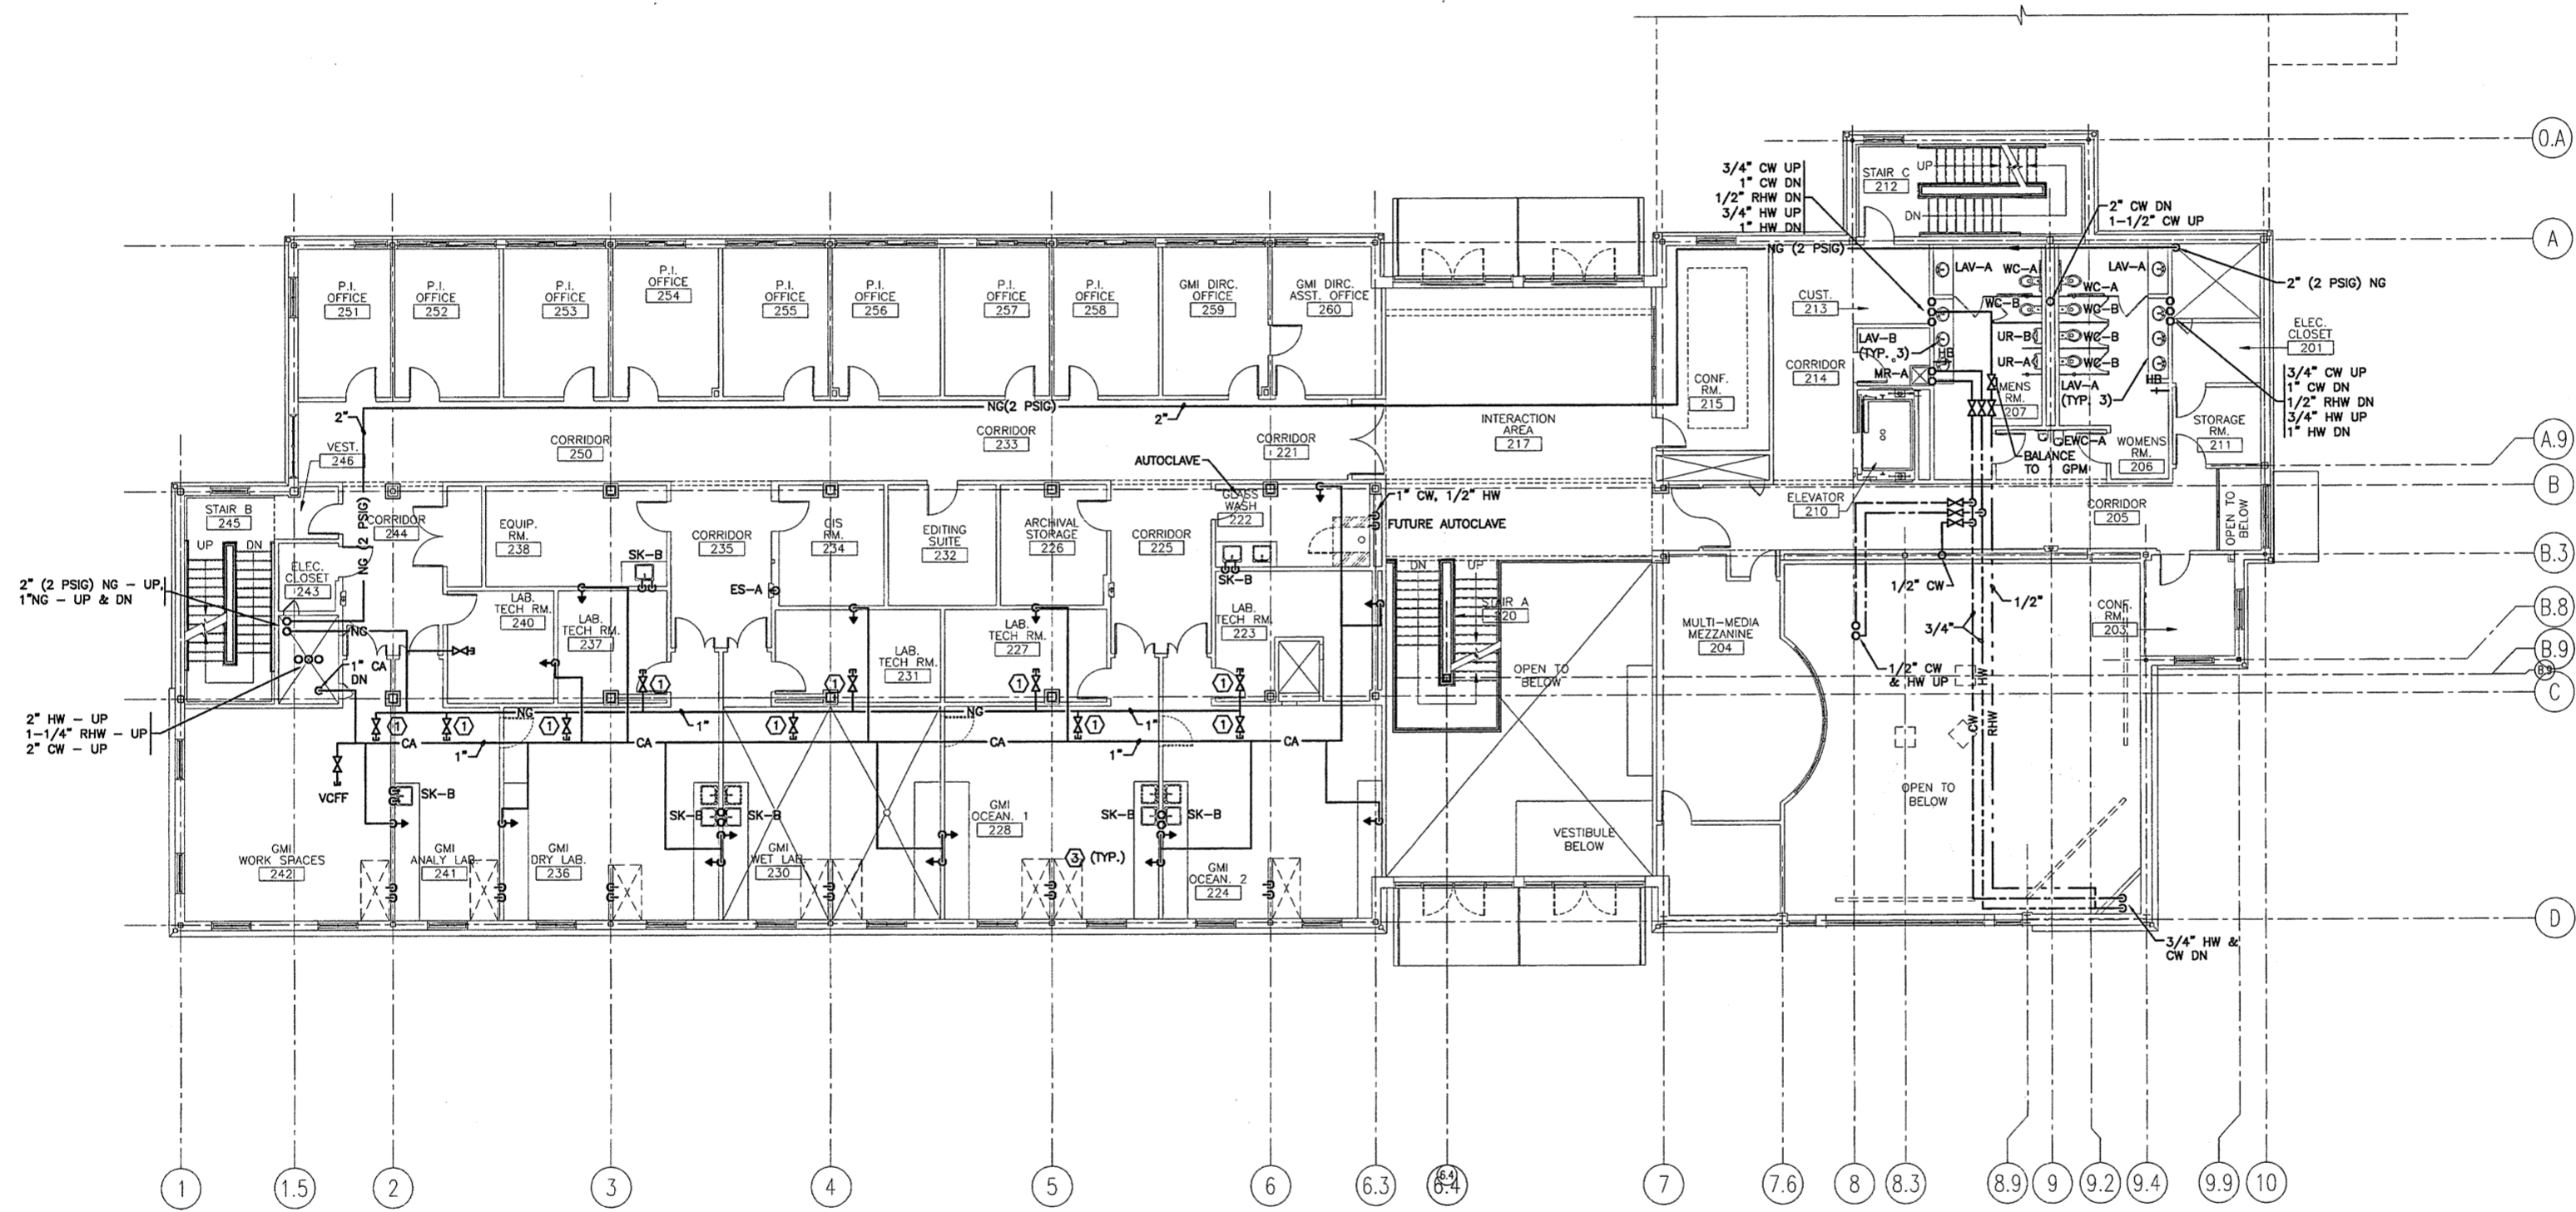

0	ISSUED FOR CONSTRUCTION	10-23-03
REV.	DESCRIPTION	DATE
ISSUED FOR CONSTRUCTION 10-23-03		
CURRENT ISSUE STATUS:		
PROJECT NORTH		
SM RT ARCHITECTURE ENGINEERING PLANNING 144 Fore Street P.O. Box 618 Portland, Maine 04104 tel. (207) 772-3846 fax. (207) 772-1070		
THE GULF OF MAINE RESEARCH INSTITUTE PORTLAND, MAINE		
PROJECT: SECOND FLOOR SUPPLY PIPING PLAN		
SHEET TITLE:		
SCALE:	1/8" = 1'-0"	DATE: 10-23-03
PROJECT MANAGER:	DRL	GRAPHIC SCALE: 0" 1"
JOB CAP/DRAWN:	SDL/BGG	
A/E OF RECORD:	DBR	SHEET No.
SMRT CAD FILE:	PL106-03034	PL106
PROJECT No.	03034	

A1 FLOOR PLAN

1/8" = 1'-0"