


NOTE:
1. SEE SHEET M-001 FOR LEGEND AND ABBREVIATIONS.

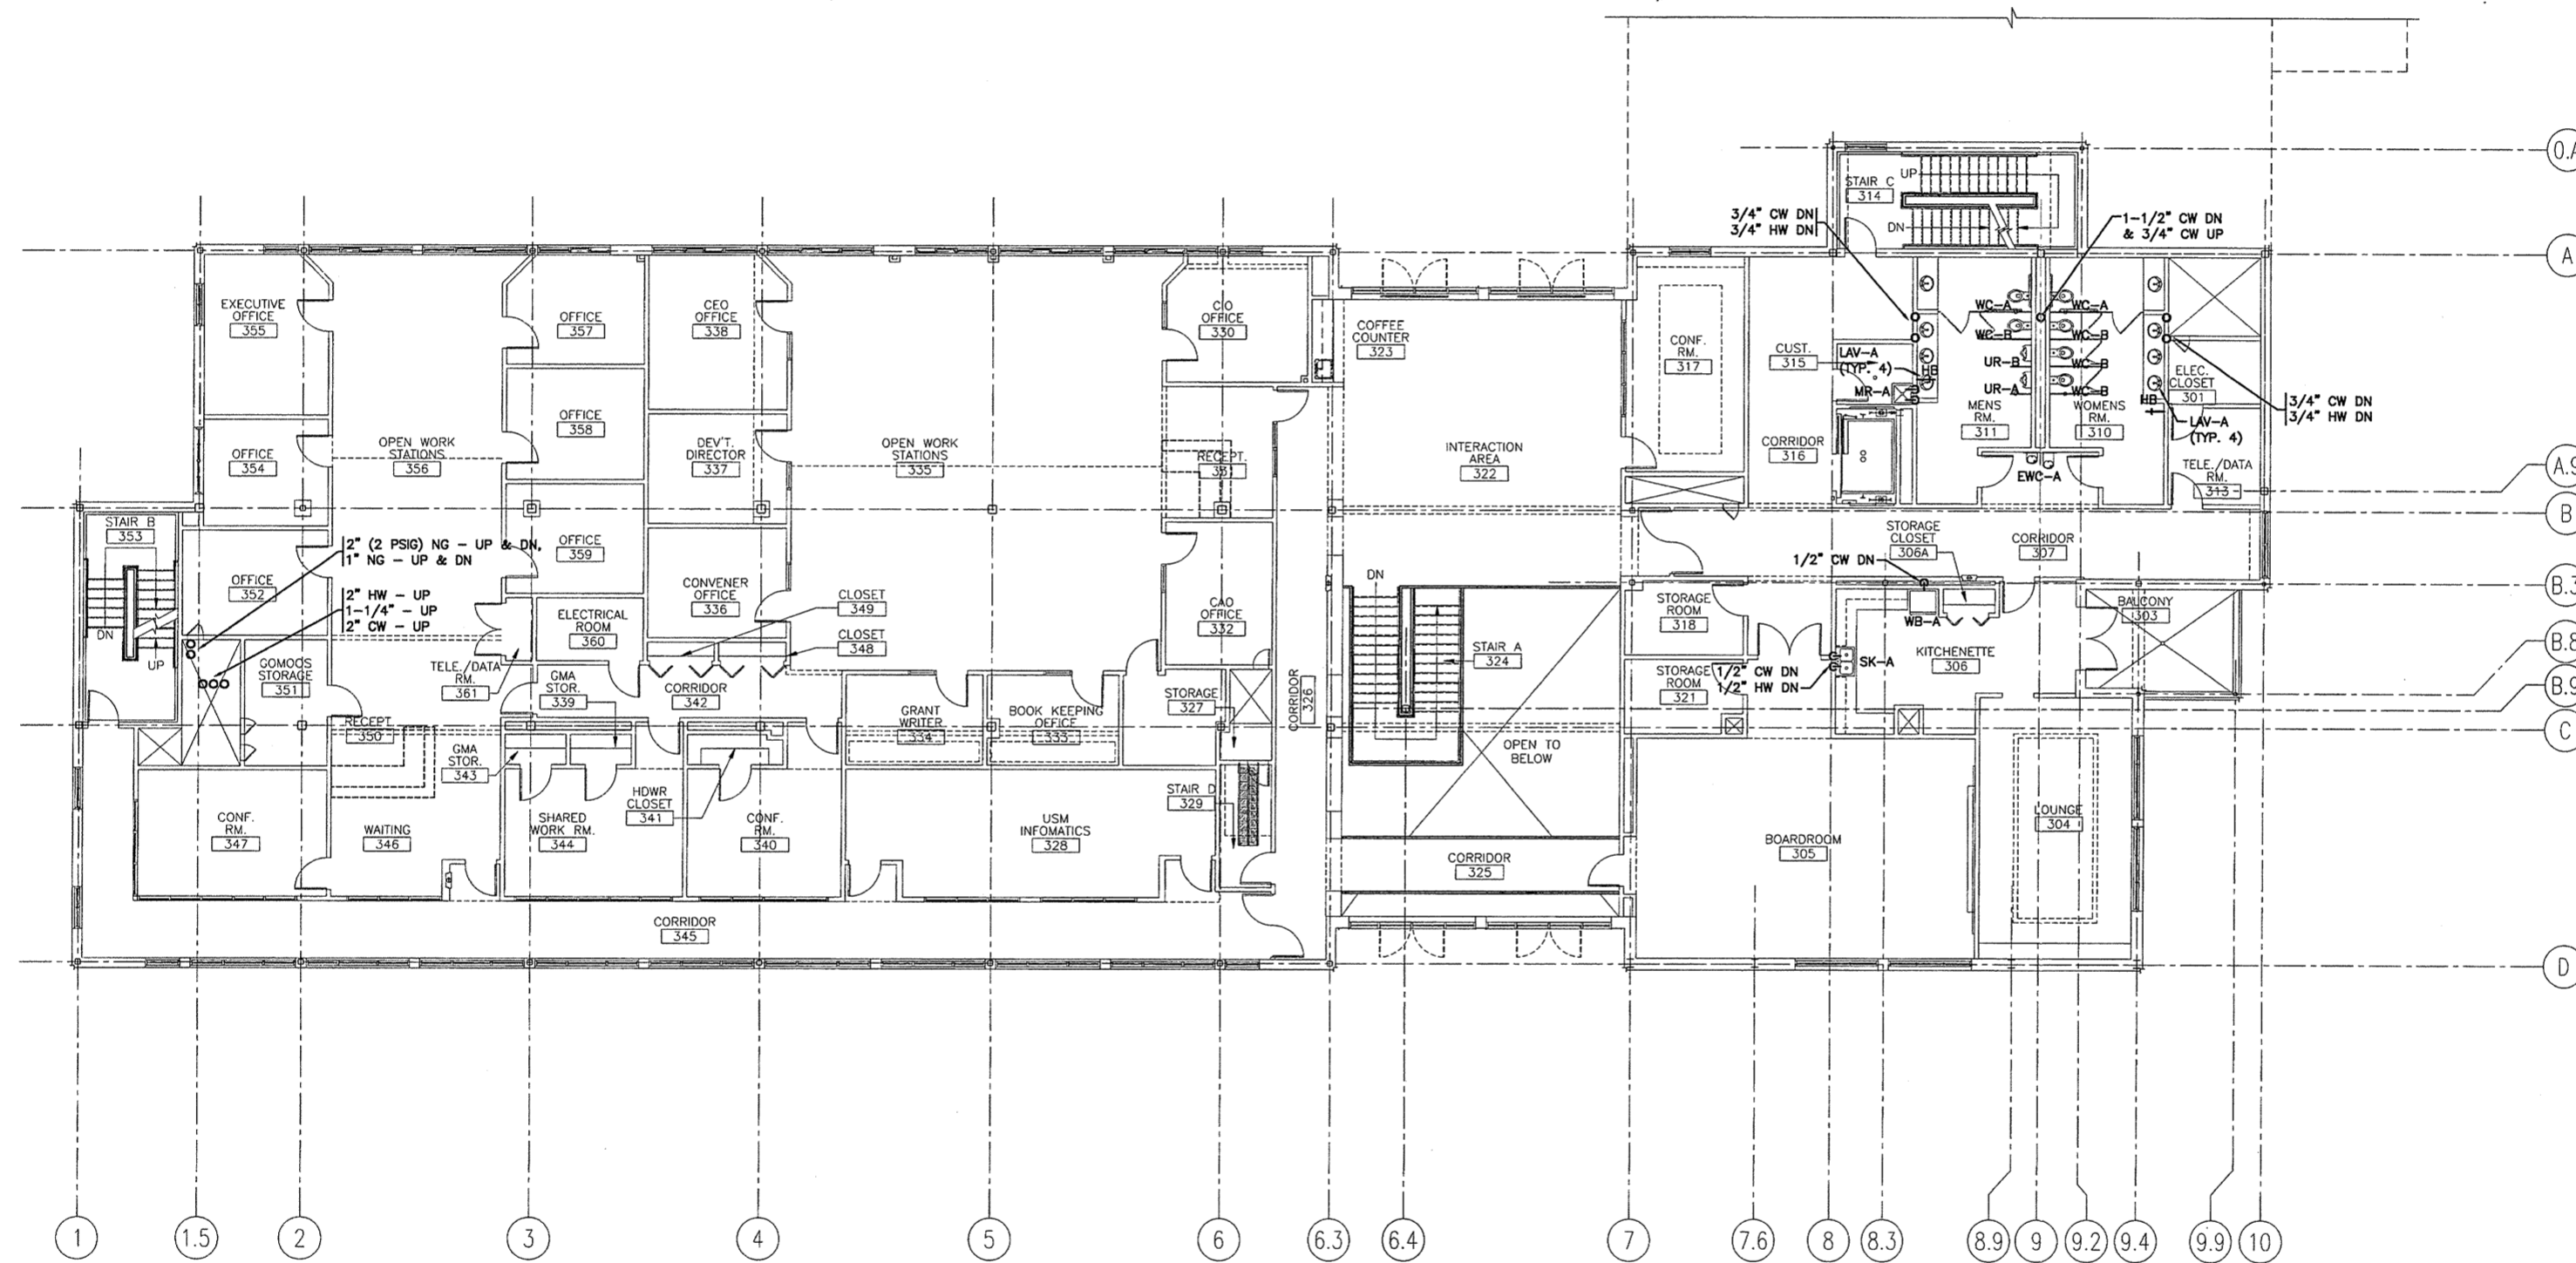

REV.	DESCRIPTION	DATE
0	ISSUED FOR CONSTRUCTION	10-23-03

ISSUED FOR CONSTRUCTION
10-23-03

CURRENT ISSUE STATUS:

SM RT ARCHITECTURE ENGINEERING PLANNING
SMRT
144 Fore Street/P.O. Box 618
Portland, Maine 04104
tel. (207) 772-3846
fax. (207) 772-1070

THE GULF OF MAINE RESEARCH INSTITUTE
PORTLAND, MAINE

THIRD FLOOR SUPPLY PIPING PLAN

SHEET TITLE:	10-23-03
SCALE: 1/8" = 1'-0"	DATE:
PROJECT MANAGER: DRL	GRAPHIC SCALE: 0" = 1'
JOB CAP/DRAWN: SDL/BGG	
A/E OF RECORD: DBR	SHEET No.
SMRT CAD FILE: PL107-03034	PL107
PROJECT No. 03034	

A1 FLOOR PLAN
1/8" = 1'-0"