


**NOTE:**  
 1. FOR EQUIPMENT AND PIPING TO BE CONSTRUCTED AS PART OF PHASE 1 SEE SEAWATER (SW) SHEETS.


PLC

FIELD

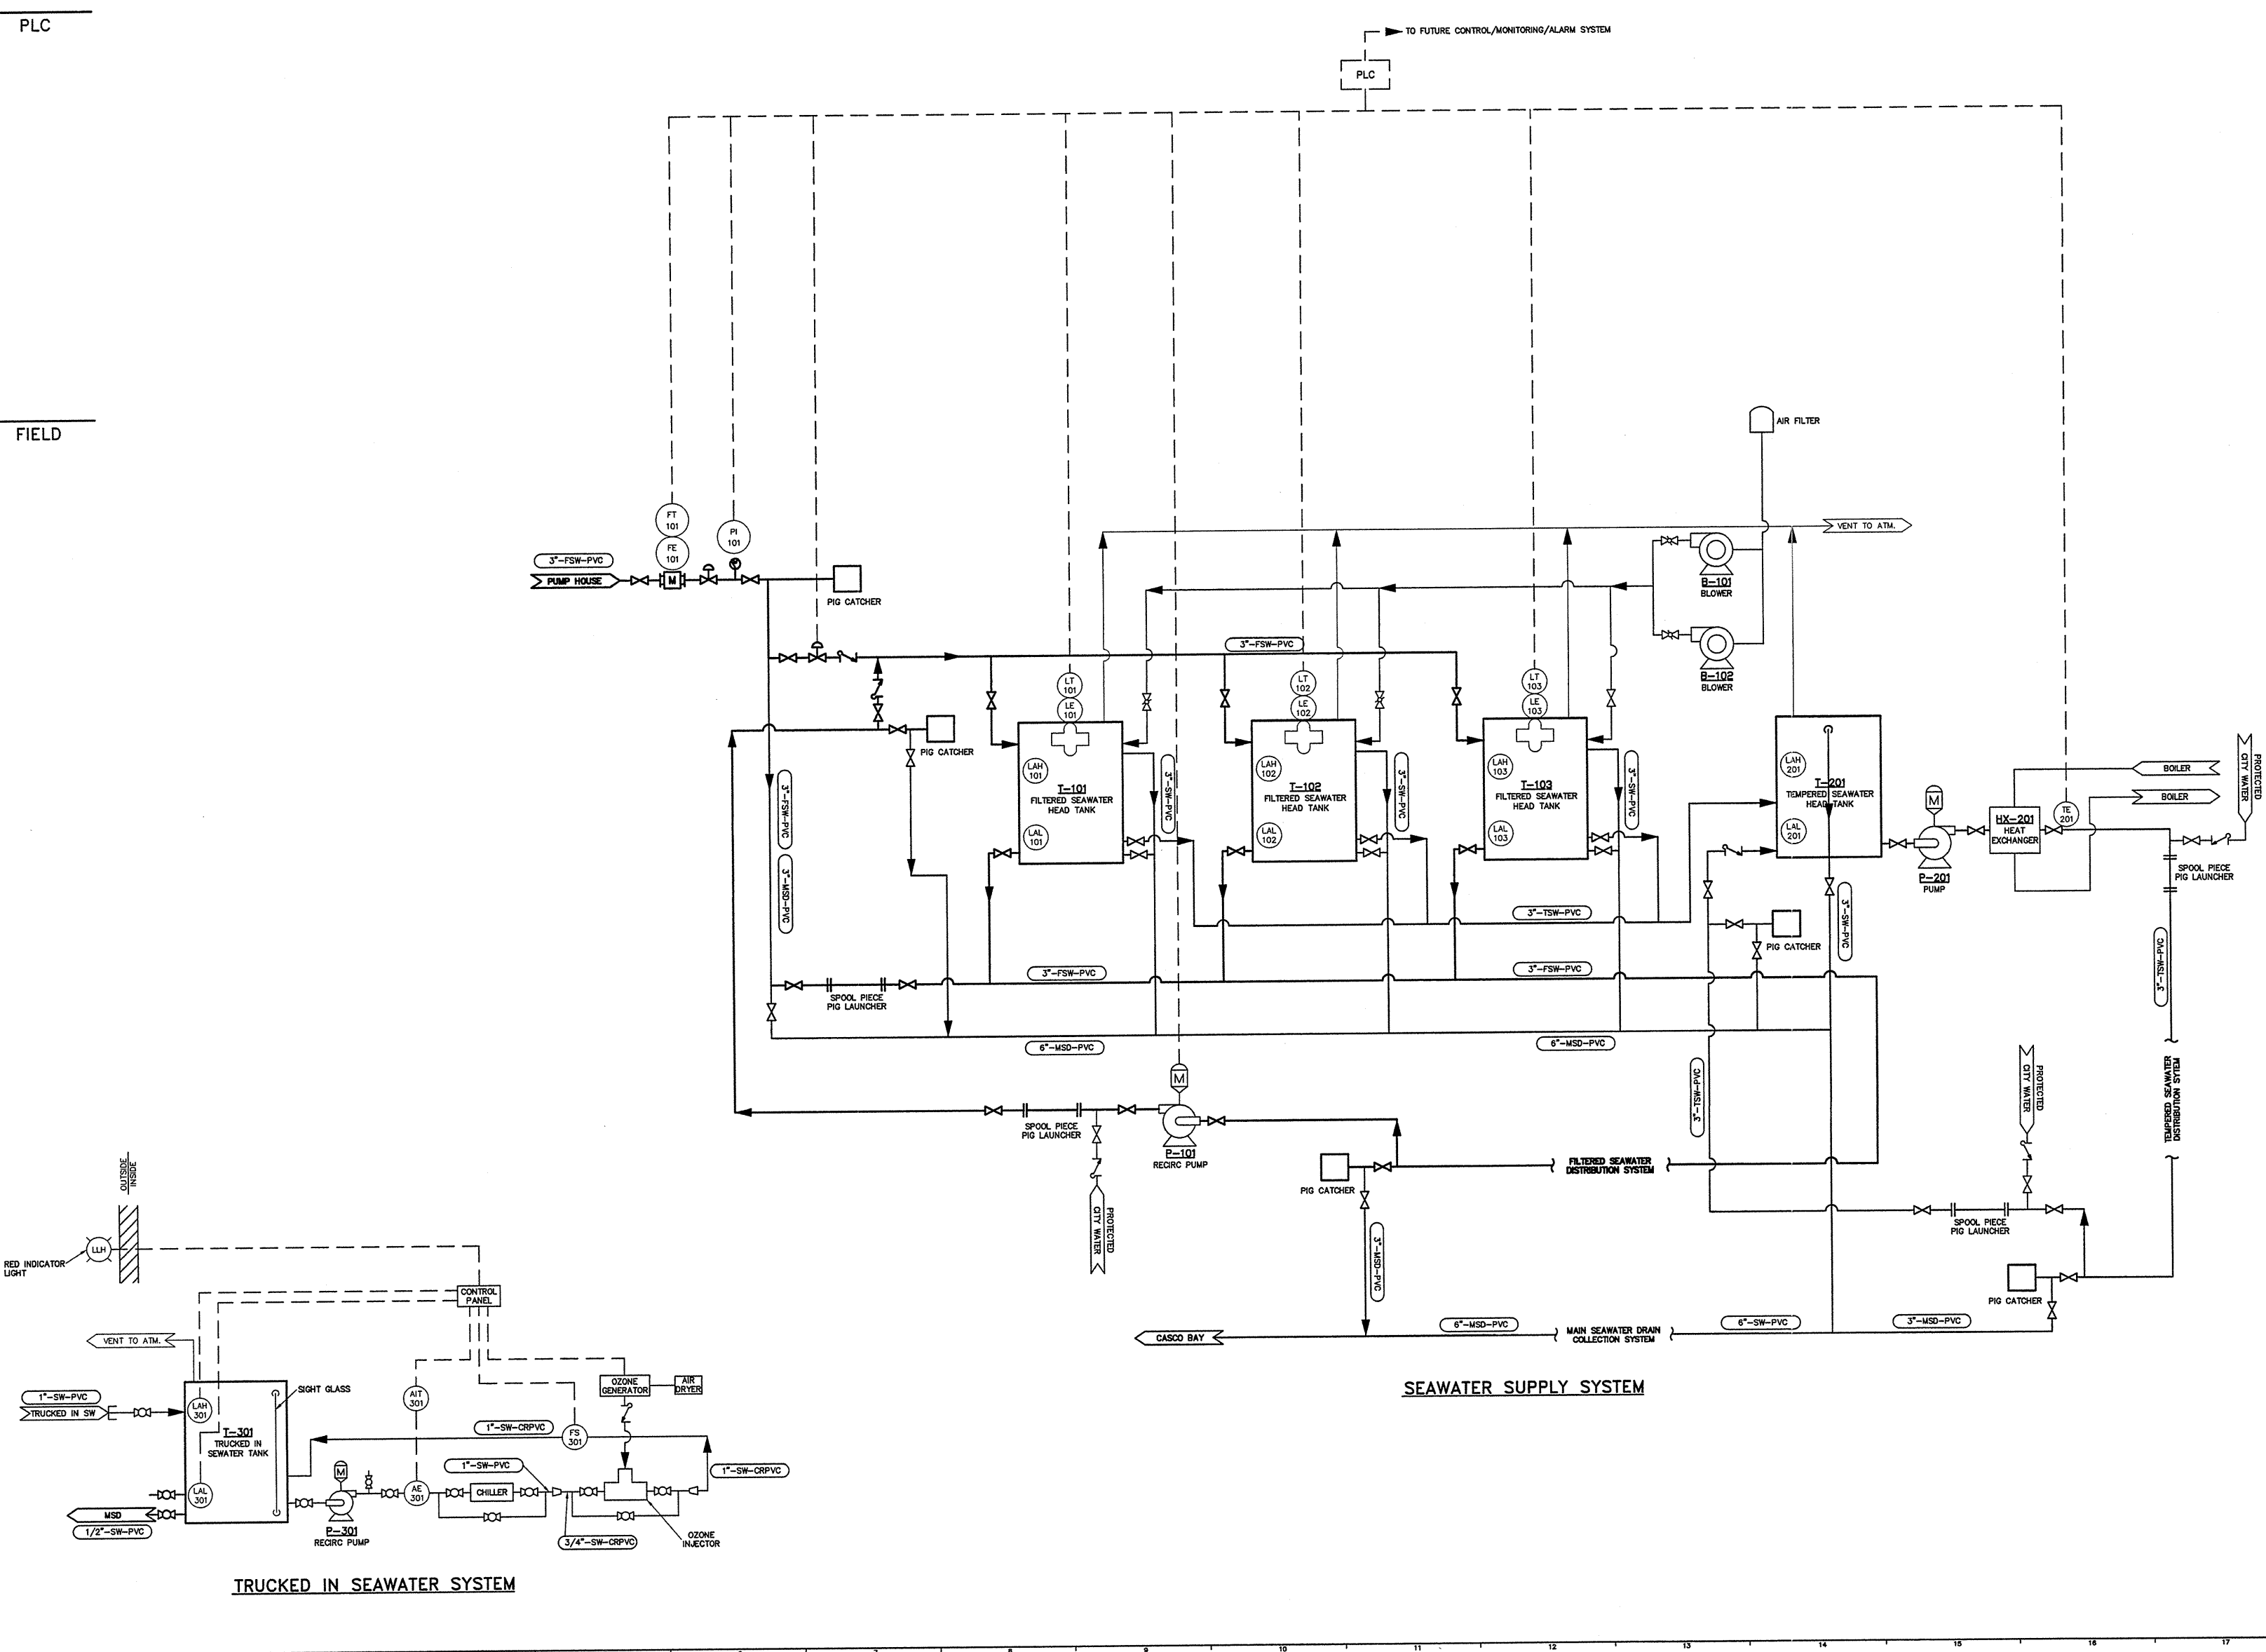

0	ISSUED FOR CONSTRUCTION	10/23/03
REV.	DESCRIPTION	DATE

**ISSUED FOR CONSTRUCTION**  
 10/23/03

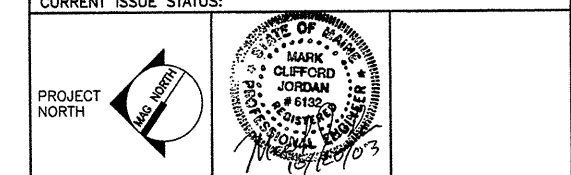

**SMRT**  
 ARCHITECTURE ENGINEERING PLANNING  
 SMRT  
 144 Fore Street P.O. Box 618  
 Portland, Maine 04104  
 tel. (207) 772-3846  
 fax. (207) 772-1070

**THE GULF OF MAINE RESEARCH INSTITUTE**  
 PORTLAND, MAINE

PROJECT:  
**PIPING AND INSTRUMENTATION DIAGRAM**

SHEET TITLE:	SW102	
SCALE:	NTS	DATE:
DESIGNED BY:	JSC	GRAPHIC SCALE:
DRAWN BY:	JSC	1" = 1'
CHECKED BY:	MCJ	SHEET No.
FILE:	20346801-P002	
PROJECT No.	03034	