


**NOTE:**

1. SEE SHEET E-001 FOR LEGEND AND GENERAL NOTES.

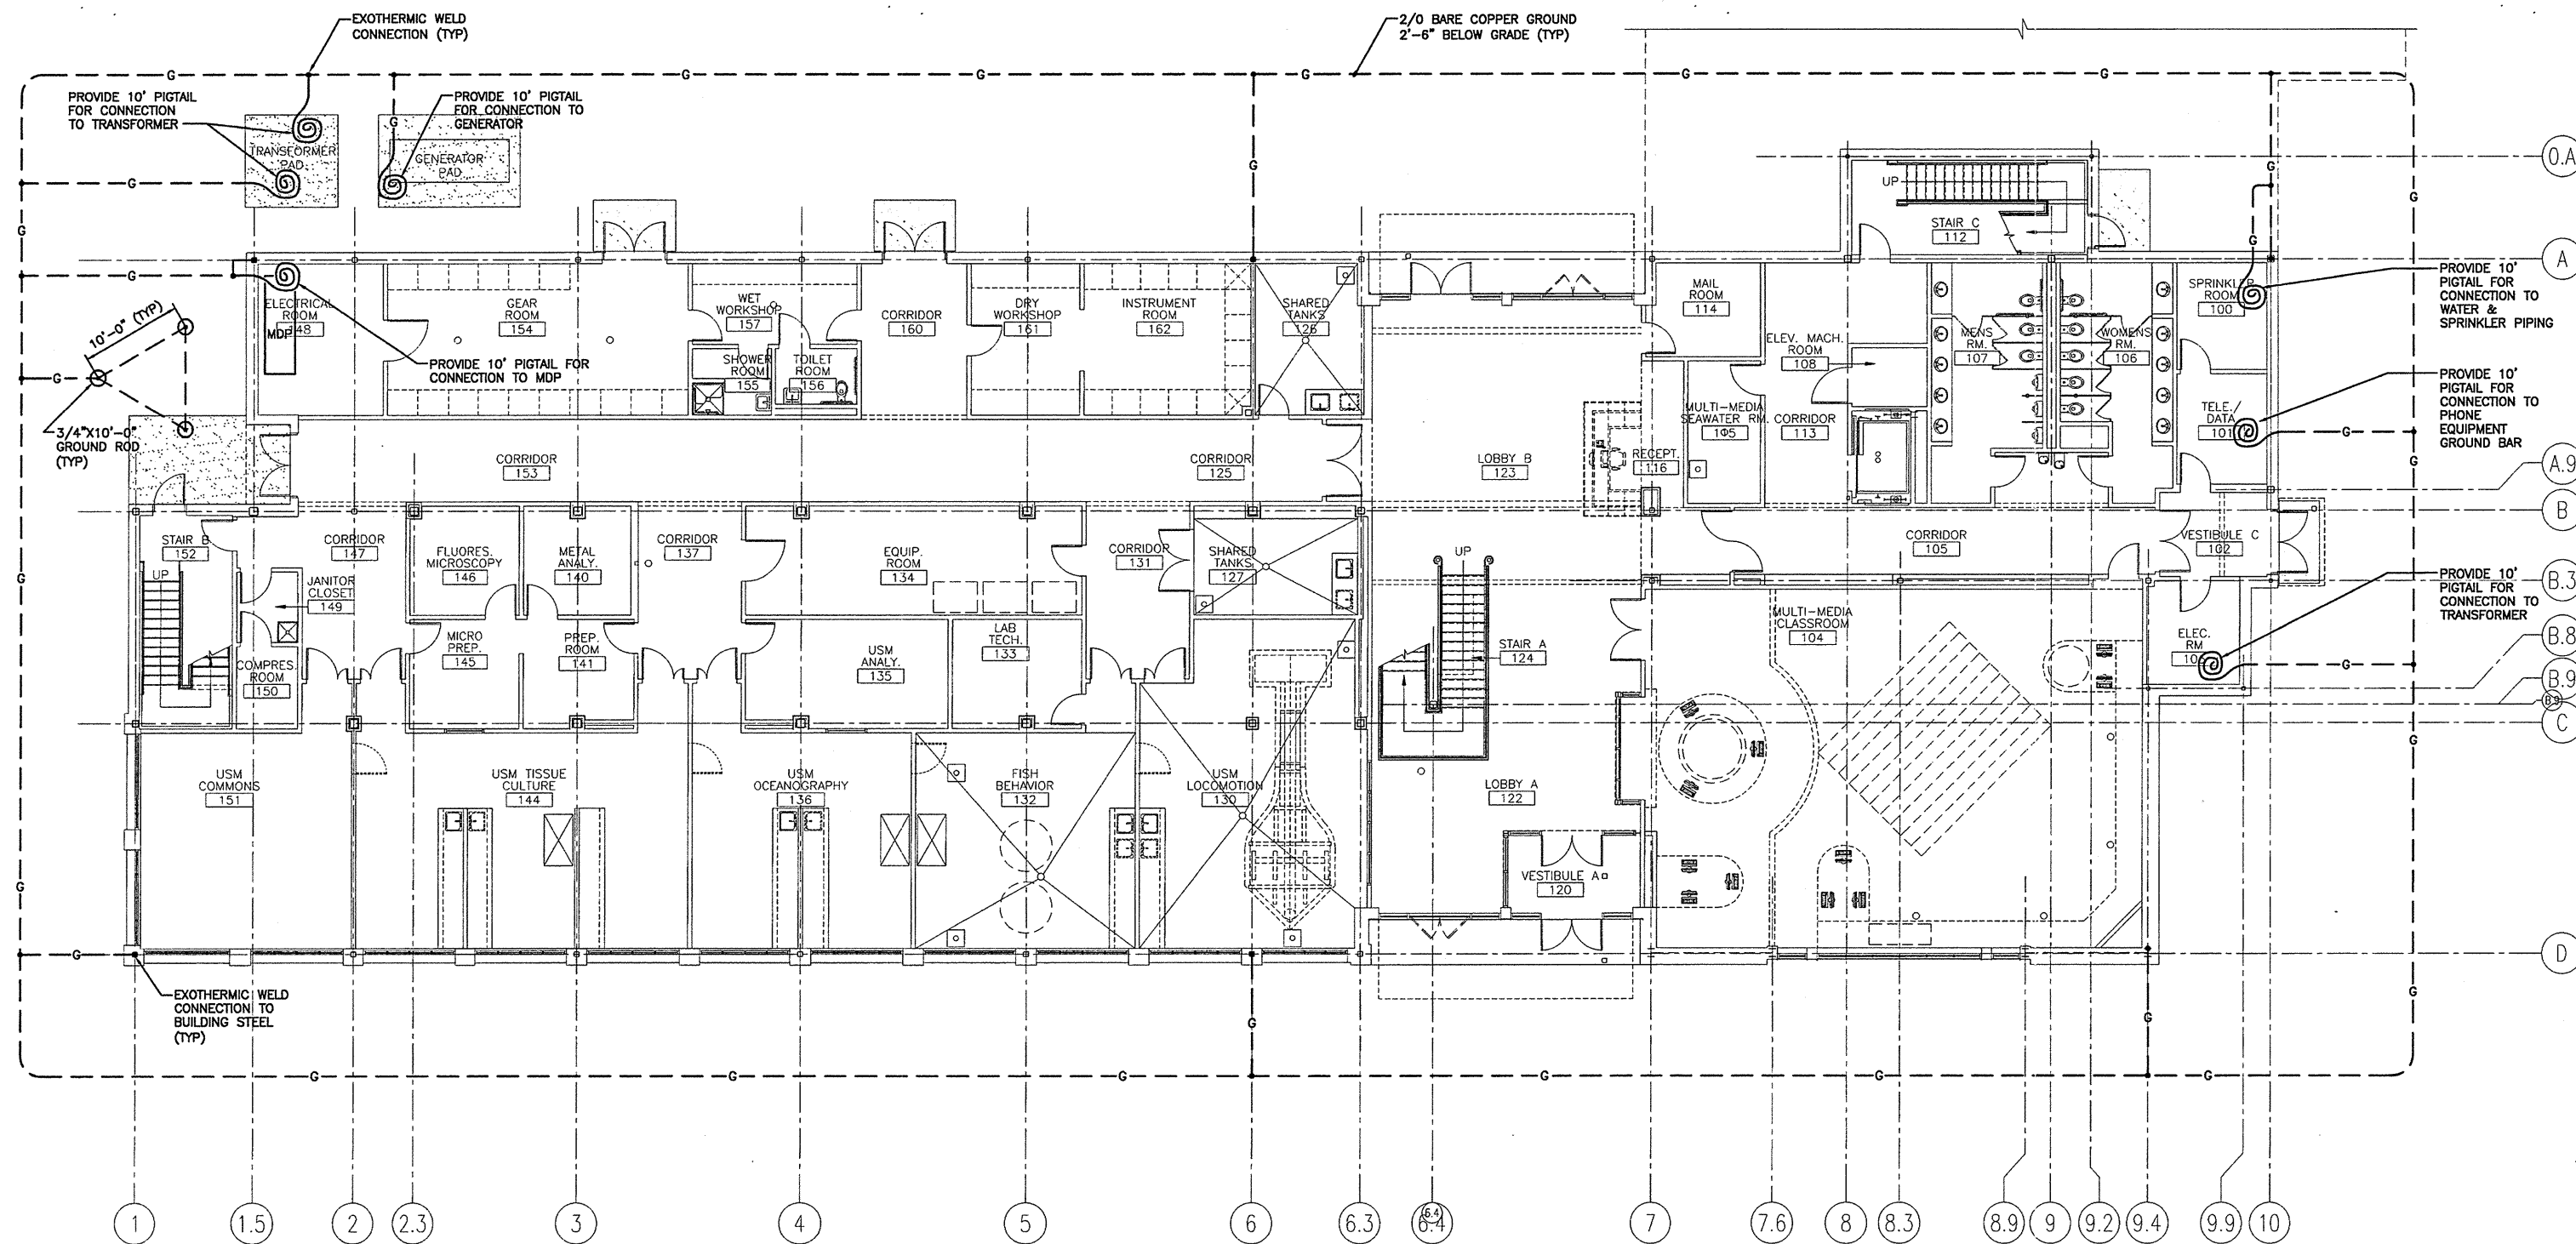

0	ISSUED FOR CONSTRUCTION	10-23-03
REV.	DESCRIPTION	DATE

**ISSUED FOR CONSTRUCTION**  
10-23-03

CURRENT ISSUE STATUS:

**SMRT**  
ARCHITECTURE ENGINEERING PLANNING  
144 Fore Street, P.O. Box 618  
Portland, Maine 04104  
tel. (207) 772-3846  
fax. (207) 772-1070

PROJECT: THE GULF OF MAINE RESEARCH INSTITUTE  
PORTLAND, MAINE

SHEET TITLE: ELECTRICAL GROUNDING PLAN

SCALE: 1/8" = 1'-0"	DATE: 10-23-03
PROJECT MANAGER: DRL	GRAPHIC SCALE: 0"
JOB CAP/DRAWN: SDL/LAM/JAC	
A/E OF RECORD: JPP	SHEET No.
SMRT CAD FILE: EG101-03034	EG101
PROJECT No. 03034	

A1 FIRST FLOOR PLAN  
1/8" = 1'-0"