



NOTE:
1. SEE SHEET E-001 FOR LEGEND AND GENERAL NOTES.


CABLE NUMBER	DESCRIPTION
1	5°C, 3#4/0 & 1#2 BARE GND, 15 KV
2	(3) - 4°C, 4#500 KCML & 1#3/0 GND
3	(2) - 3°C, 4#350 KCML & 1#1 GND
4	4°C, 4#500 KCML & 1#1/0 GND
5	3°C, 4#500 KCML & 1#3 GND
6	2-1/2°C, 4#4/0 & 1#2 GND
7	1-1/2°C, 3#1/0 & 1#6 GND
8	1-1/2°C, 4#1 & 1#6 GND
9	1-1/2°C, 4#2 & 1#6 GND
10	1°C, 3#6 & 1#8 GND
11	1°C, 4#6 & 1#10 GND
12	2°C, 4#1/0 & 1#6 GND
13	5°C, 4#4/0 & 1#2 BARE GND, 15KV

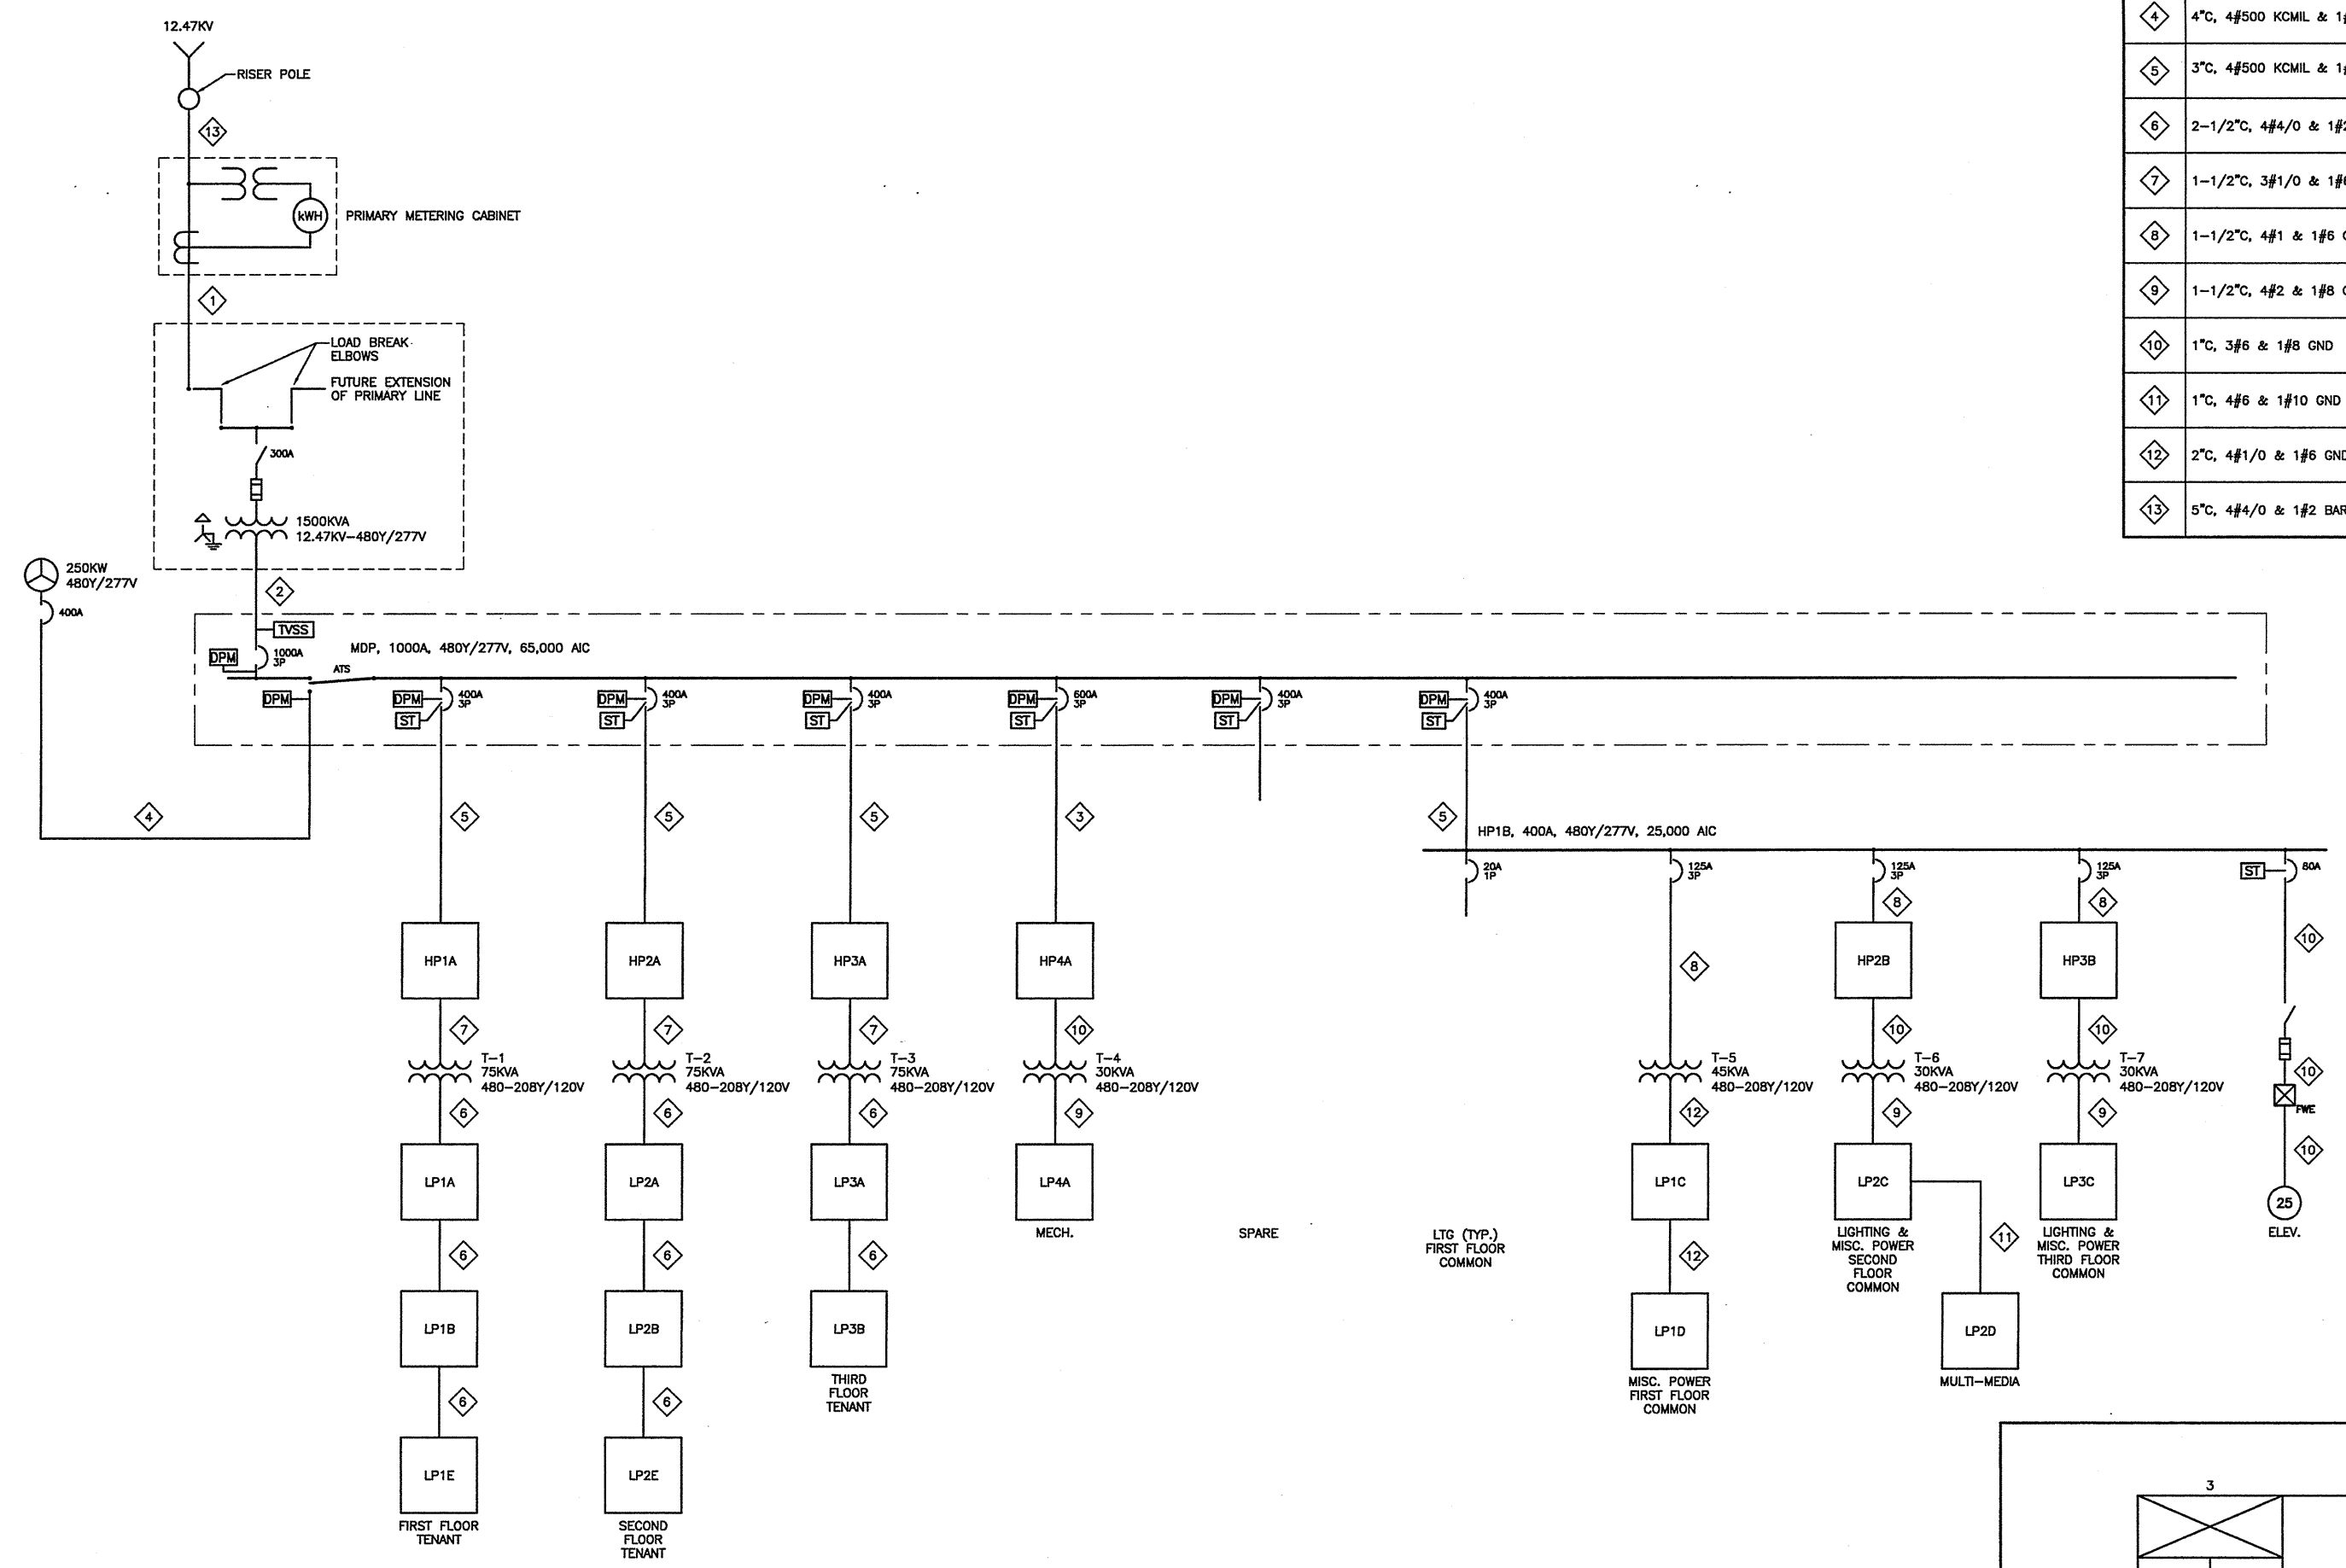

0	ISSUED FOR CONSTRUCTION	10-23-03
REV.	DESCRIPTION	DATE
ISSUED FOR CONSTRUCTION		
10-23-03		

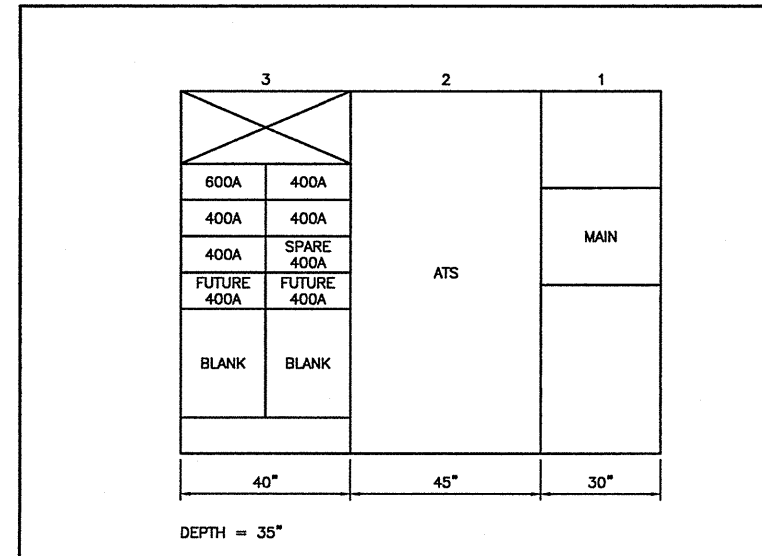

A15 ELEVATION - MDP FRONT VIEW
NOT TO SCALE

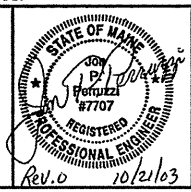
SMRT ARCHITECTURE ENGINEERING PLANNING
 144 Fore Street/P.O. Box 618
 Portland, Maine 04104
 Tel: (207) 772-3846
 Fax: (207) 772-1070

THE GULF OF MAINE RESEARCH INSTITUTE
 PORTLAND, MAINE

ONE-LINE DIAGRAM

SCALE:	AS NOTED	DATE:	10-23-03
PROJECT MANAGER:	DRL	GRAPHIC SCALE:	0" = 1"
JOB CAP/DRAWING:	SDL/LAM		
A/E OF RECORD:	JPP	SHEET No.	
SMRT CAD FILE:	EP651-03034		
PROJECT No.	03034		

EP651