

**REFLECTED CEILING NOTES**

1. FIRE SPRINKLERS SHALL BE LOCATED IN ALIGNMENT WITH OTHER CEILING ITEMS, TYPICALLY.
2. FIRE SPRINKLERS SHALL BE CENTERED IN CEILING TILE SQUARES (2X2).
3. FIRE SPRINKLERS SHALL BE PLACED TO COORDINATE WITH LIGHT FIXTURE POSITIONS INDICATED.
4. FIRE SPRINKLERS ARE SHOWN FOR COORDINATION ONLY. ADDITIONAL SPRINKLERS MAY BE REQUIRED FOR CODE COMPLIANCE, AS DETERMINED BY THE FIRE PROTECTION DESIGNER. SPRINKLERS ARE NOT SHOWN IN ALL AREAS WHERE REQUIRED. FIRE PROTECTION CONTRACTOR SHALL BE RESPONSIBLE FOR PROVIDING A COMPLETE, CODE COMPLIANT SYSTEM, INCLUDING HEADS NOT INDICATED IN THIS DRAWING. RE: MECH.
5. ALIGN CEILING ITEMS AS SHOWN, WITH COMMON CENTERLINES, TYPICALLY. CENTER ITEMS IN CEILINGS, OR IN AREAS UNLESS INDICATED OTHERWISE.
6. REFER TO ROOM FINISH SCHEDULE FOR CEILING HEIGHTS AND CEILING FINISHES TO BE PROVIDED.
7. EXCEPT WHERE INDICATED, CENTER CEILING GRIDS IN ROOMS. USE HALF TILES OR GREATER PERIMETERS AS POSSIBLE.
8. CEILING HEIGHT IS AS SCHEDULED ON AE601 TYPICAL.

**KEYED NOTES:**

- ① BREAK IN CEILING GRID. ALIGN INDEPENDENT GRID WITH CENTER OF WALL.

**SYMBOL LEGEND**

- 2x2 SUSPENDED CEILING PANEL AND GRID ASSEMBLY.
- 2x4 SUSPENDED CEILING PANEL AND GRID ASSEMBLY.
- GWB CEILING.
- LINEAR METAL SUSPENDED CEILING.
- OPEN CELL CEILING.
- 2x2 LAY-IN LIGHT FIXTURE.
- 2x4 LAY-IN LIGHT FIXTURE.
- 1x4 LIGHT FIXTURE.
- FLUORESCENT STRIP FIXTURE.
- DOWN LIGHT.
- CEILING MOUNTED EXIT LIGHT.
- RETURN AIR GRILLE.
- SUPPLY AIR GRILLE.
- EXHAUST AIR GRILLE.
- SPRINKLER HEAD.
- CEILING MOUNTED SPEAKER.
- CEILING MOUNTED SMOKE DETECTOR.
- TRACK LIGHT FIXTURE.

0	ISSUED FOR CONSTRUCTION	10-23-03
REV.	DESCRIPTION	DATE

**ISSUED FOR CONSTRUCTION**  
10-23-03

CURRENT ISSUE STATUS:


**SMRT** ARCHITECTURE ENGINEERING PLANNING  
SMRT  
144 Fore Street P.O. Box 618  
Portland, Maine 04104  
tel. (207) 772-3846  
fax. (207) 772-1070

**THE GULF OF MAINE RESEARCH INSTITUTE**  
PORTLAND, MAINE

PROJECT: **FIRST FLOOR REFLECTED CEILING PLAN**

SHEET TITLE: **FIRST FLOOR REFLECTED CEILING PLAN**

SCALE: 1/8" = 1'-0" DATE: 10-23-03  
PROJECT MANAGER: DRL GRAPHIC SCALE: 0' 1'  
JOB CAP/DRAWN: SDL/SDL  
A/E OF RECORD: PSS SHEET No.  
SMRT CAD FILE: AE111-03034 SHEET No. **AE111**  
PROJECT No. 03034

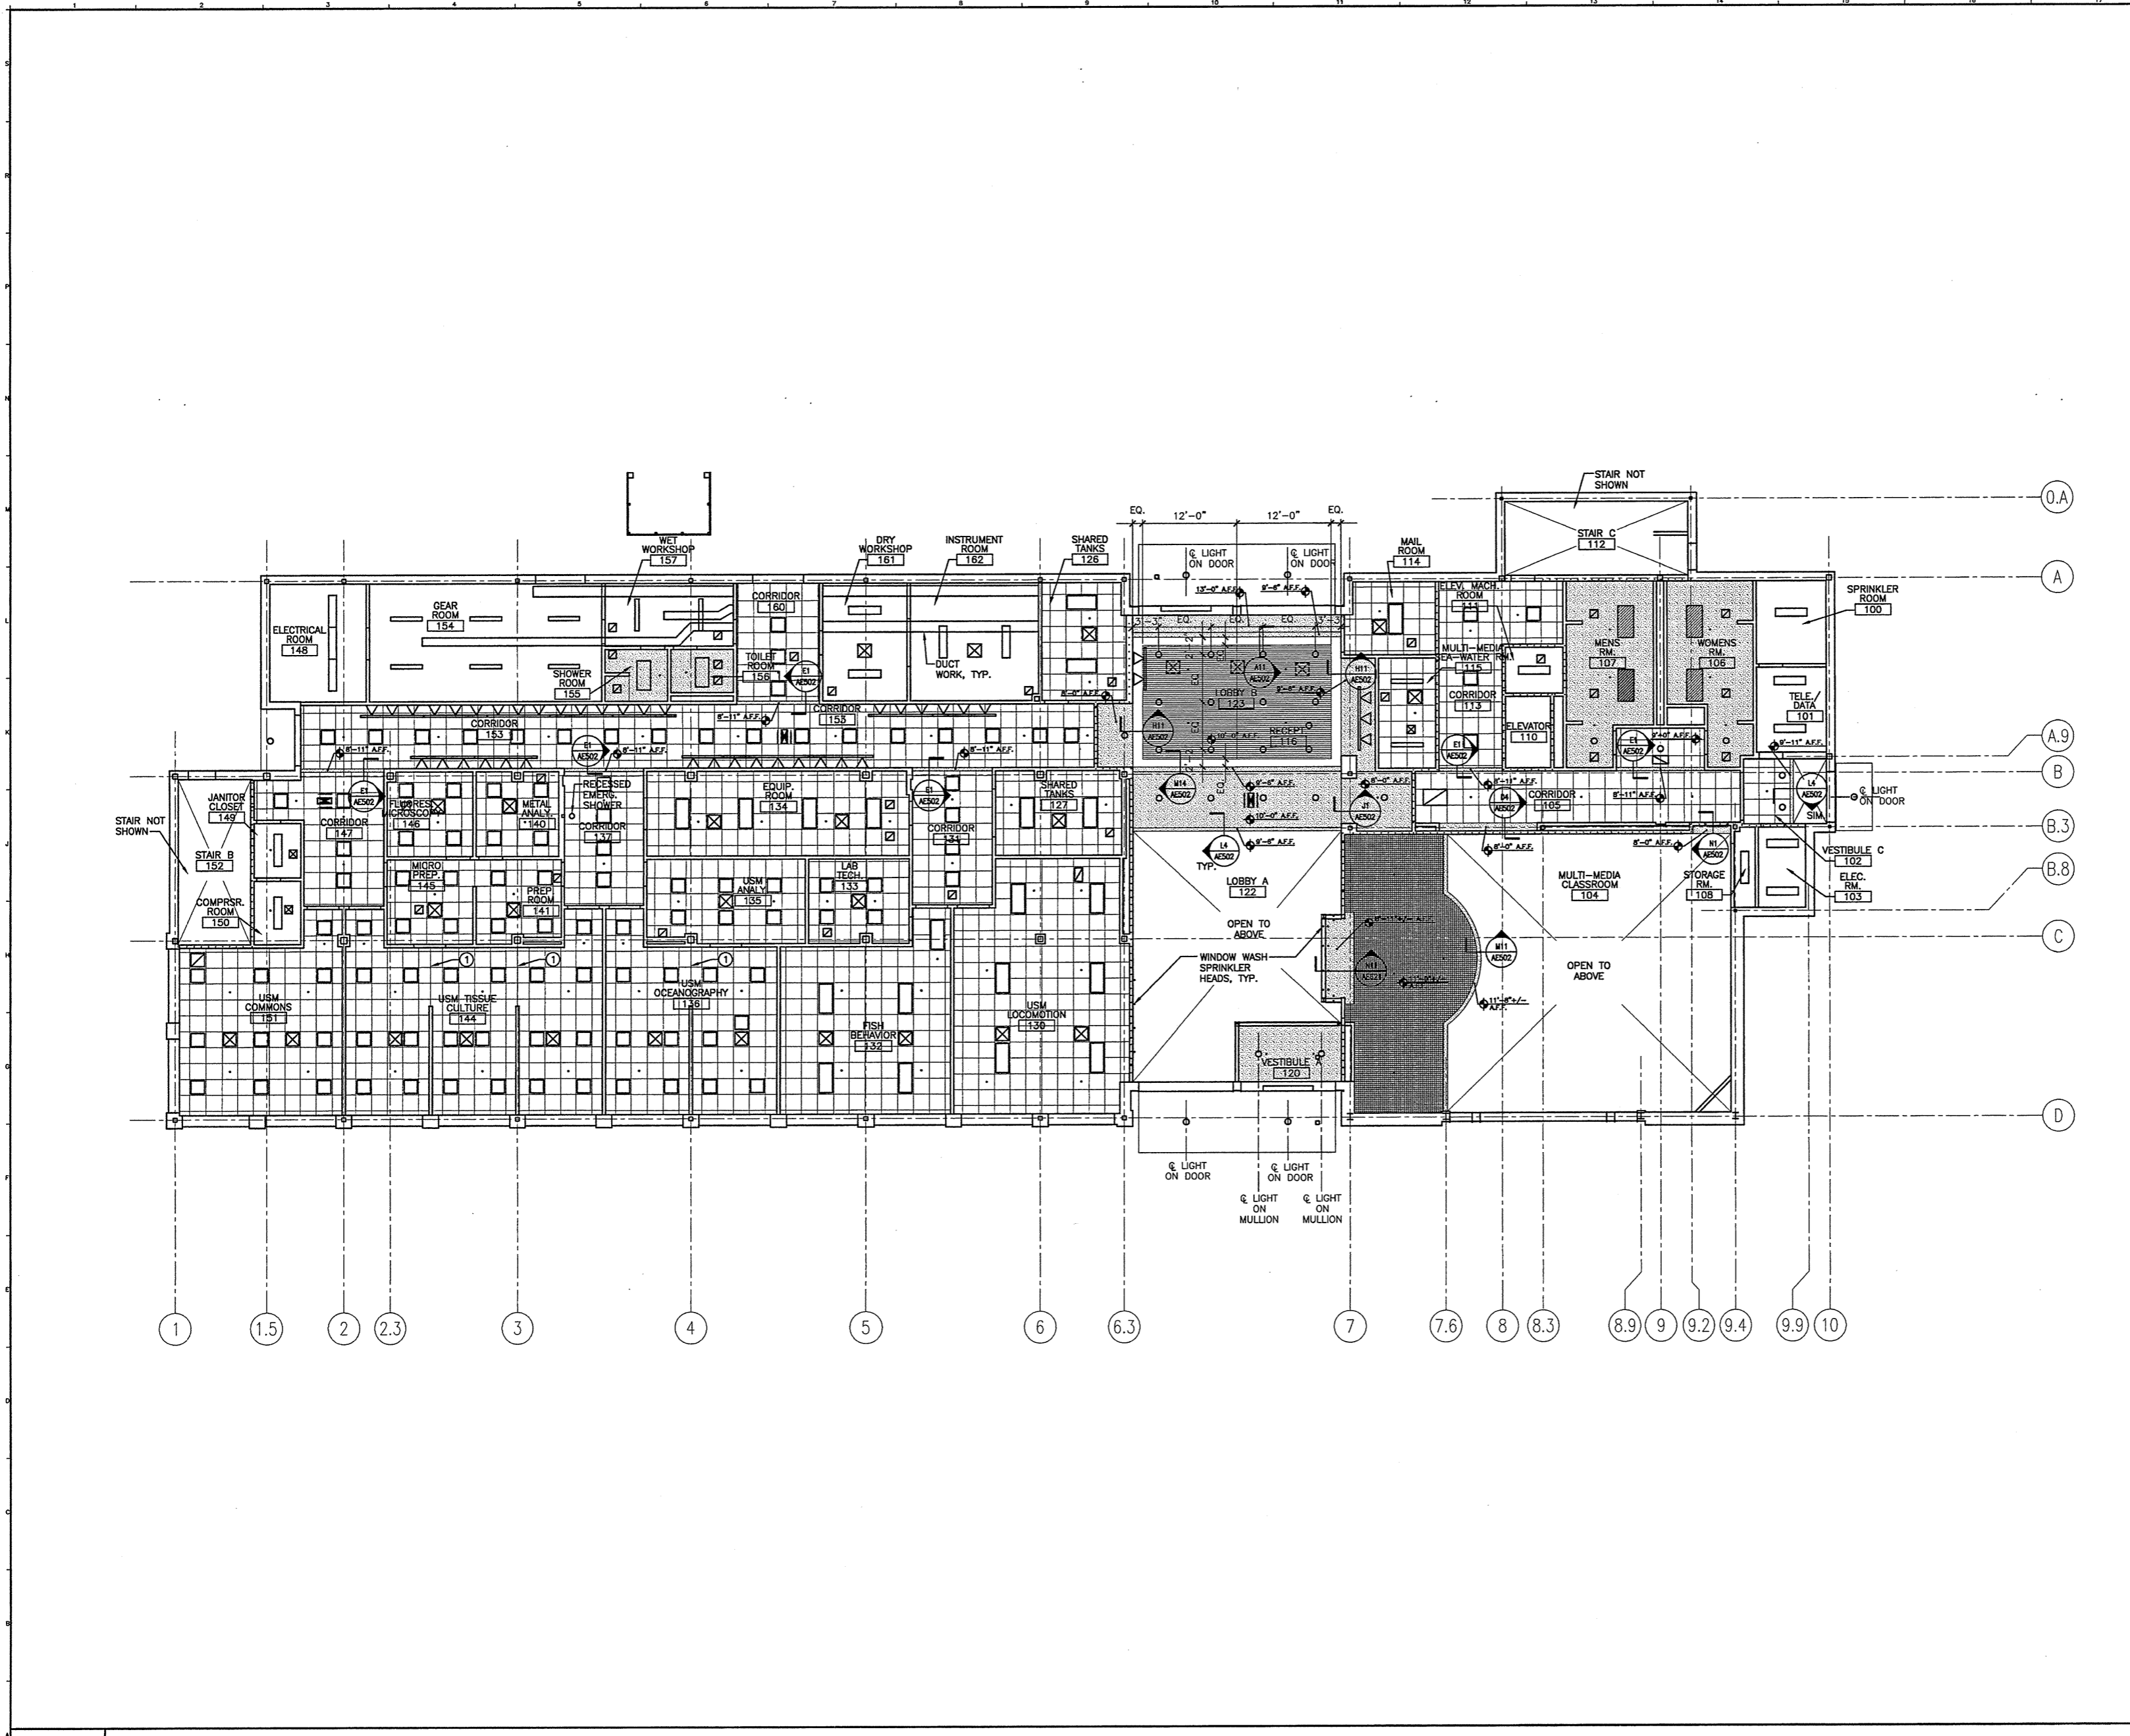

**A1 FIRST FLOOR REFLECTED CEILING PLAN**

1/8" = 1'-0"