
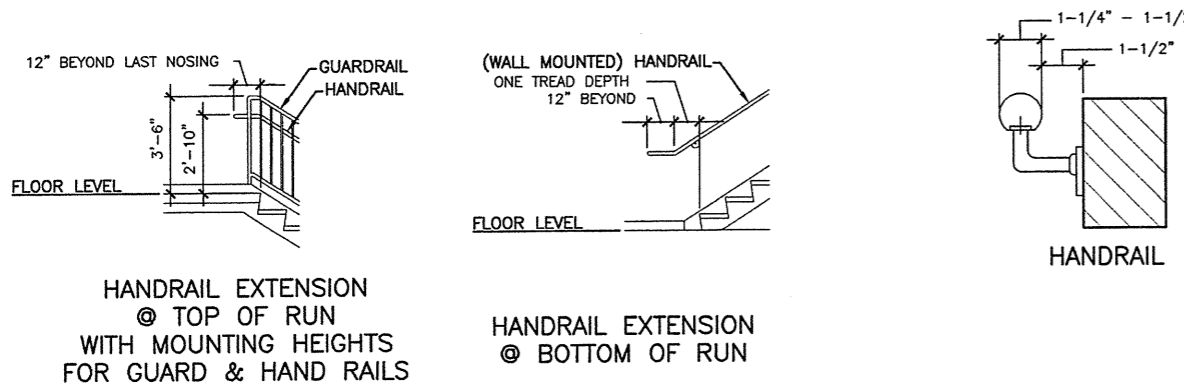


ELECTRICAL & FIRE PROTECTION DEVICES
TYPICAL UNLESS NOTED OTHERWISE

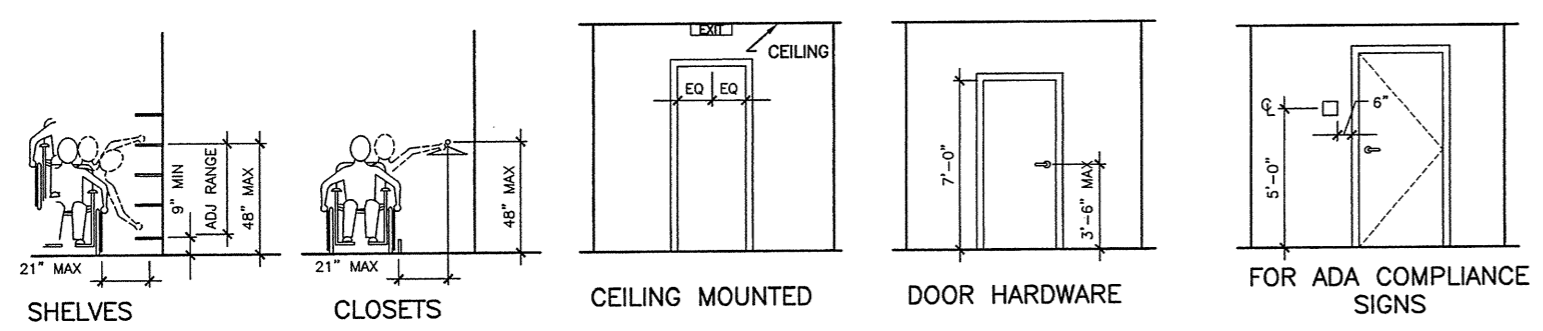

DRAWING LIST

- GENERAL VOLUME #1**
- G1001 COVER SHEET
 - G1002 GENERAL MOUNTING HEIGHTS AND DRAWING LIST
 - G1003 INTERIOR PARTITION AND EXTERIOR WALL LEGEND, ROOF TYPES
 - G1004 TOP OF WALL DETAILS
- CIVIL**
- CS101 EXISTING CONDITIONS AND DEMOLITION PLAN
 - CP101 SITE LAYOUT AND MATERIALS PLAN (PHASE 1)
 - CG101 GRADING, DRAINAGE AND EROSION CONTROL PLAN (PHASE 1)
 - CU101 UTILITIES PLAN
 - LP101 LANDSCAPING PLAN
- CP501 SITE DETAILS**
- CP502 SITE DETAILS
 - CP503 SITE DETAILS
- ARCHITECTURAL**
- A-001 FACILITY PLANS
 - A-002 CODE COMPLIANCE PLANS
- AE101 FIRST FLOOR PLAN
 - AE102 SECOND FLOOR PLAN
 - AE103 THIRD FLOOR PLAN
 - AE104 MEZZANINE FLOOR PLAN
 - AE105 FIRST FLOOR LAYOUT PLAN
 - AE106 SECOND FLOOR LAYOUT PLAN
 - AE107 THIRD FLOOR LAYOUT PLAN
 - AE108 MEZZANINE LEVEL LAYOUT PLAN
 - AE111 FIRST FLOOR REFLECTED CEILING PLAN
 - AE112 SECOND FLOOR REFLECTED CEILING PLAN
 - AE113 THIRD FLOOR REFLECTED CEILING PLAN
 - AE114 MEZZANINE REFLECTED CEILING PLAN
 - AE120 ROOF PLAN
 - AE201 EXTERIOR ELEVATIONS
 - AE202 EXTERIOR ELEVATIONS
 - AE211 INTERIOR ELEVATIONS
 - AE212 INTERIOR ELEVATIONS
 - AE213 INTERIOR ELEVATIONS
 - AE214 INTERIOR ELEVATIONS
 - AE221 INTERIOR ELEVATIONS
 - AE231 INTERIOR ELEVATIONS
 - AE232 INTERIOR ELEVATIONS
 - AE301 BUILDING SECTIONS
 - AE302 BUILDING SECTIONS
 - AE311 WALL SECTIONS
 - AE312 WALL SECTIONS
 - AE313 WALL SECTIONS
 - AE314 WALL SECTIONS
 - AE315 WALL SECTIONS
 - AE401 LARGE SCALE STAIR PLANS AND SECTIONS
 - AE402 LARGE SCALE STAIR AND ELEVATOR PLANS AND SECTIONS
 - AE403 STAIR DETAILS
 - AE411 LARGE SCALE PLANS
 - AE501 SECTION DETAILS
 - AE502 SECTION DETAILS
 - AE503 SECTION DETAILS
 - AE510 ROOF DETAILS
 - AE511 ROOF DETAILS
 - AE520 PLAN DETAILS
 - AE521 PLAN DETAILS
 - AE522 PLAN DETAILS
 - AE530 CASEWORK DETAILS
 - AE601 ROOM FINISH SCHEDULE
 - AE611 DOOR SCHEDULES
 - AE612 DOOR SCHEDULE, DOOR, FRAME AND WINDOW TYPES
 - AE613 INTERIOR WINDOW TYPES
 - AE621 INTERIOR DOOR AND WINDOW DETAILS
 - AE631 EXTERIOR DOOR AND WINDOW DETAILS
 - AE632 EXTERIOR DOOR AND WINDOW DETAILS
- STRUCTURAL**
- SG001 STRUCTURAL GENERAL NOTES
 - SB101 FOUNDATION AND SLAB PLAN
 - SB102 GROUND FLOOR SLAB REINFORCING PLAN
 - SB501 TYPICAL FOUNDATION SECTIONS AND DETAILS
 - SB502 FOUNDATION SECTIONS AND DETAILS
 - SB503 FOUNDATION SECTIONS AND DETAILS
 - SF101 SECOND FLOOR FRAMING PLAN
 - SF102 THIRD FLOOR FRAMING PLAN
 - SF103 MEZZANINE FRAMING PLAN
 - SF104 ROOF FRAMING PLAN
 - SF201 STRUCTURAL BRACING ELEVATIONS
 - SF202 STRUCTURAL BRACING ELEVATIONS
 - SF401 ENLARGED PARTIAL FRAMING PLANS
 - SF402 FIRE RATING PLANS
 - SF403 PARTIAL FRAMING PLANS, SECTIONS AND DETAILS
 - SF501 TYPICAL FRAMING SECTIONS AND DETAILS
 - SF502 FRAMING SECTIONS AND DETAILS
 - SF503 FRAMING SECTIONS AND DETAILS
 - SF504 FRAMING SECTIONS AND DETAILS
 - SF505 FRAMING SECTIONS AND DETAILS
 - SF601 COLUMN LAYOUT PLAN AND BASEPLATE DETAILS

GENERAL VOLUME #2

- G1001 COVER SHEET
 - G1002 GENERAL MOUNTING HEIGHTS AND DRAWING LIST
- MECHANICAL**
- M-001 LEGEND & ABBREVIATIONS
 - MH101 FIRST FLOOR HVAC PLAN
 - MH102 SECOND FLOOR HVAC PLAN
 - MH103 THIRD FLOOR HVAC PLAN
 - MH104 MEZZANINE HVAC PLAN
 - MP101 FIRST FLOOR HVAC PIPING PLAN
 - MP102 SECOND FLOOR HVAC PIPING PLAN
 - MP103 THIRD FLOOR HVAC PIPING PLAN
 - MP104 MEZZANINE HVAC PIPING PLAN
 - M-301 SECTIONS
 - M-501 DETAILS
 - M-502 DETAILS
 - M-601 SCHEDULES
 - M-602 SCHEDULES
 - M-651 SCHEMATICS
- PLUMBING**
- PL101 FIRST FLOOR DW PIPING PLAN
 - PL102 SECOND FLOOR DW PIPING PLAN
 - PL103 THIRD FLOOR DW PIPING PLAN
 - PL104 MEZZANINE DW PIPING PLAN
 - PL105 FIRST FLOOR SUPPLY PIPING PLAN
 - PL106 SECOND FLOOR SUPPLY PIPING PLAN
 - PL107 THIRD FLOOR SUPPLY PIPING PLAN
 - PL108 MEZZANINE SUPPLY PIPING PLAN
 - PL501 DETAILS
 - PL801 SCHEDULES
 - PL851 RISER DIAGRAMS
- SEA WATER**
- SW101 PROCESS AND INSTRUMENTATION DIAGRAM LEGEND
 - SW102 PIPING AND INSTRUMENTATION DIAGRAM
 - SW103 FOUNDATION AND SLAB MSD AND SSD PIPING PLAN
 - SW104 FIRST FLOOR SEAWATER SYSTEM PIPING PLAN
 - SW105 SECOND FLOOR SEAWATER SYSTEM PIPING PLAN
 - SW106 THIRD FLOOR SEAWATER SYSTEM PIPING PLAN
 - SW107 MEZZANINE SEAWATER SYSTEM PIPING PLAN
 - SW108 DETAILS
 - SW109 MECHANICAL DETAILS
- ELECTRICAL**
- E-001 LEGEND & GENERAL NOTES
 - ES101 SITE LIGHTING PLAN
 - ES102 SITE POWER PLAN
 - ES301 DUCTBANK DETAILS
 - EG101 ELECTRICAL GROUNDING PLAN
 - EP101 FIRST FLOOR POWER PLAN
 - EP102 SECOND FLOOR POWER PLAN
 - EP103 THIRD FLOOR POWER PLAN
 - EP104 MEZZANINE FLOOR POWER PLAN
 - EL101 FIRST FLOOR LIGHTING PLAN
 - EL102 SECOND FLOOR LIGHTING PLAN
 - EL103 THIRD FLOOR LIGHTING PLAN
 - EL104 MEZZANINE FLOOR LIGHTING PLAN
 - EY101 FIRST FLOOR SYSTEMS PLAN
 - EY102 SECOND FLOOR SYSTEMS PLAN
 - EY103 THIRD FLOOR SYSTEMS PLAN
 - EY104 MEZZANINE FLOOR SYSTEMS PLAN
 - EP401 FIRST FLOOR POWER PART PLAN
 - EP402 SECOND FLOOR POWER PART PLAN
 - EP601 PANEL SCHEDULES
 - EP602 PANEL SCHEDULES
 - EP603 PANEL SCHEDULES
 - EP651 ONE LINE DIAGRAM
 - EL601 LIGHT FIXTURE SCHEDULE

0	ISSUED FOR CONSTRUCTION	10-23-03
REV.	DESCRIPTION	DATE
ISSUED FOR CONSTRUCTION		
10-23-03		
CURRENT ISSUE STATUS:		
SMRT ARCHITECTURE ENGINEERING PLANNING SMRT 144 Fore Street/P.O. Box 618 Portland, Maine 04104 tel. (207) 773-8846 fax. (207) 773-1070		
THE GULF OF MAINE RESEARCH INSTITUTE PORTLAND, MAINE		
PROJECT: GENERAL MOUNTING HEIGHTS AND DRAWING LIST		
SHEET TITLE: GENERAL MOUNTING HEIGHTS AND DRAWING LIST		
SCALE: AS NOTED	DATE: 10-23-03	
PROJECT MANAGER: DNL	GRAPHIC SCALE: 1" = 1'-0"	
JOB CAP/DRAWN: SOL/SOL		
A/E OF RECORD: FSS	SHEET No.	
SMRT CAD FILE: G1002-03034		G1002
PROJECT No. 03034		

A1 GENRAL MOUNTING HEIGHTS

A9 DRAWING LIST

1/4" = 1'-0"