


**NOTE:**  
 1. SEE SHEET M-001 FOR LEGEND AND ABBREVIATIONS.

**KEYED NOTES:**  
 ① DROP & CONNECT TO BOILER GAS TRAIN INLET W/1" (2 PSIG) NG.  
 ② NG REGULATOR STATION, (KNOCK DOWN TO 0.5 PSIG), PIPE REGULATOR VENT THROUGH ROOF PER DETAIL J1/PL501.

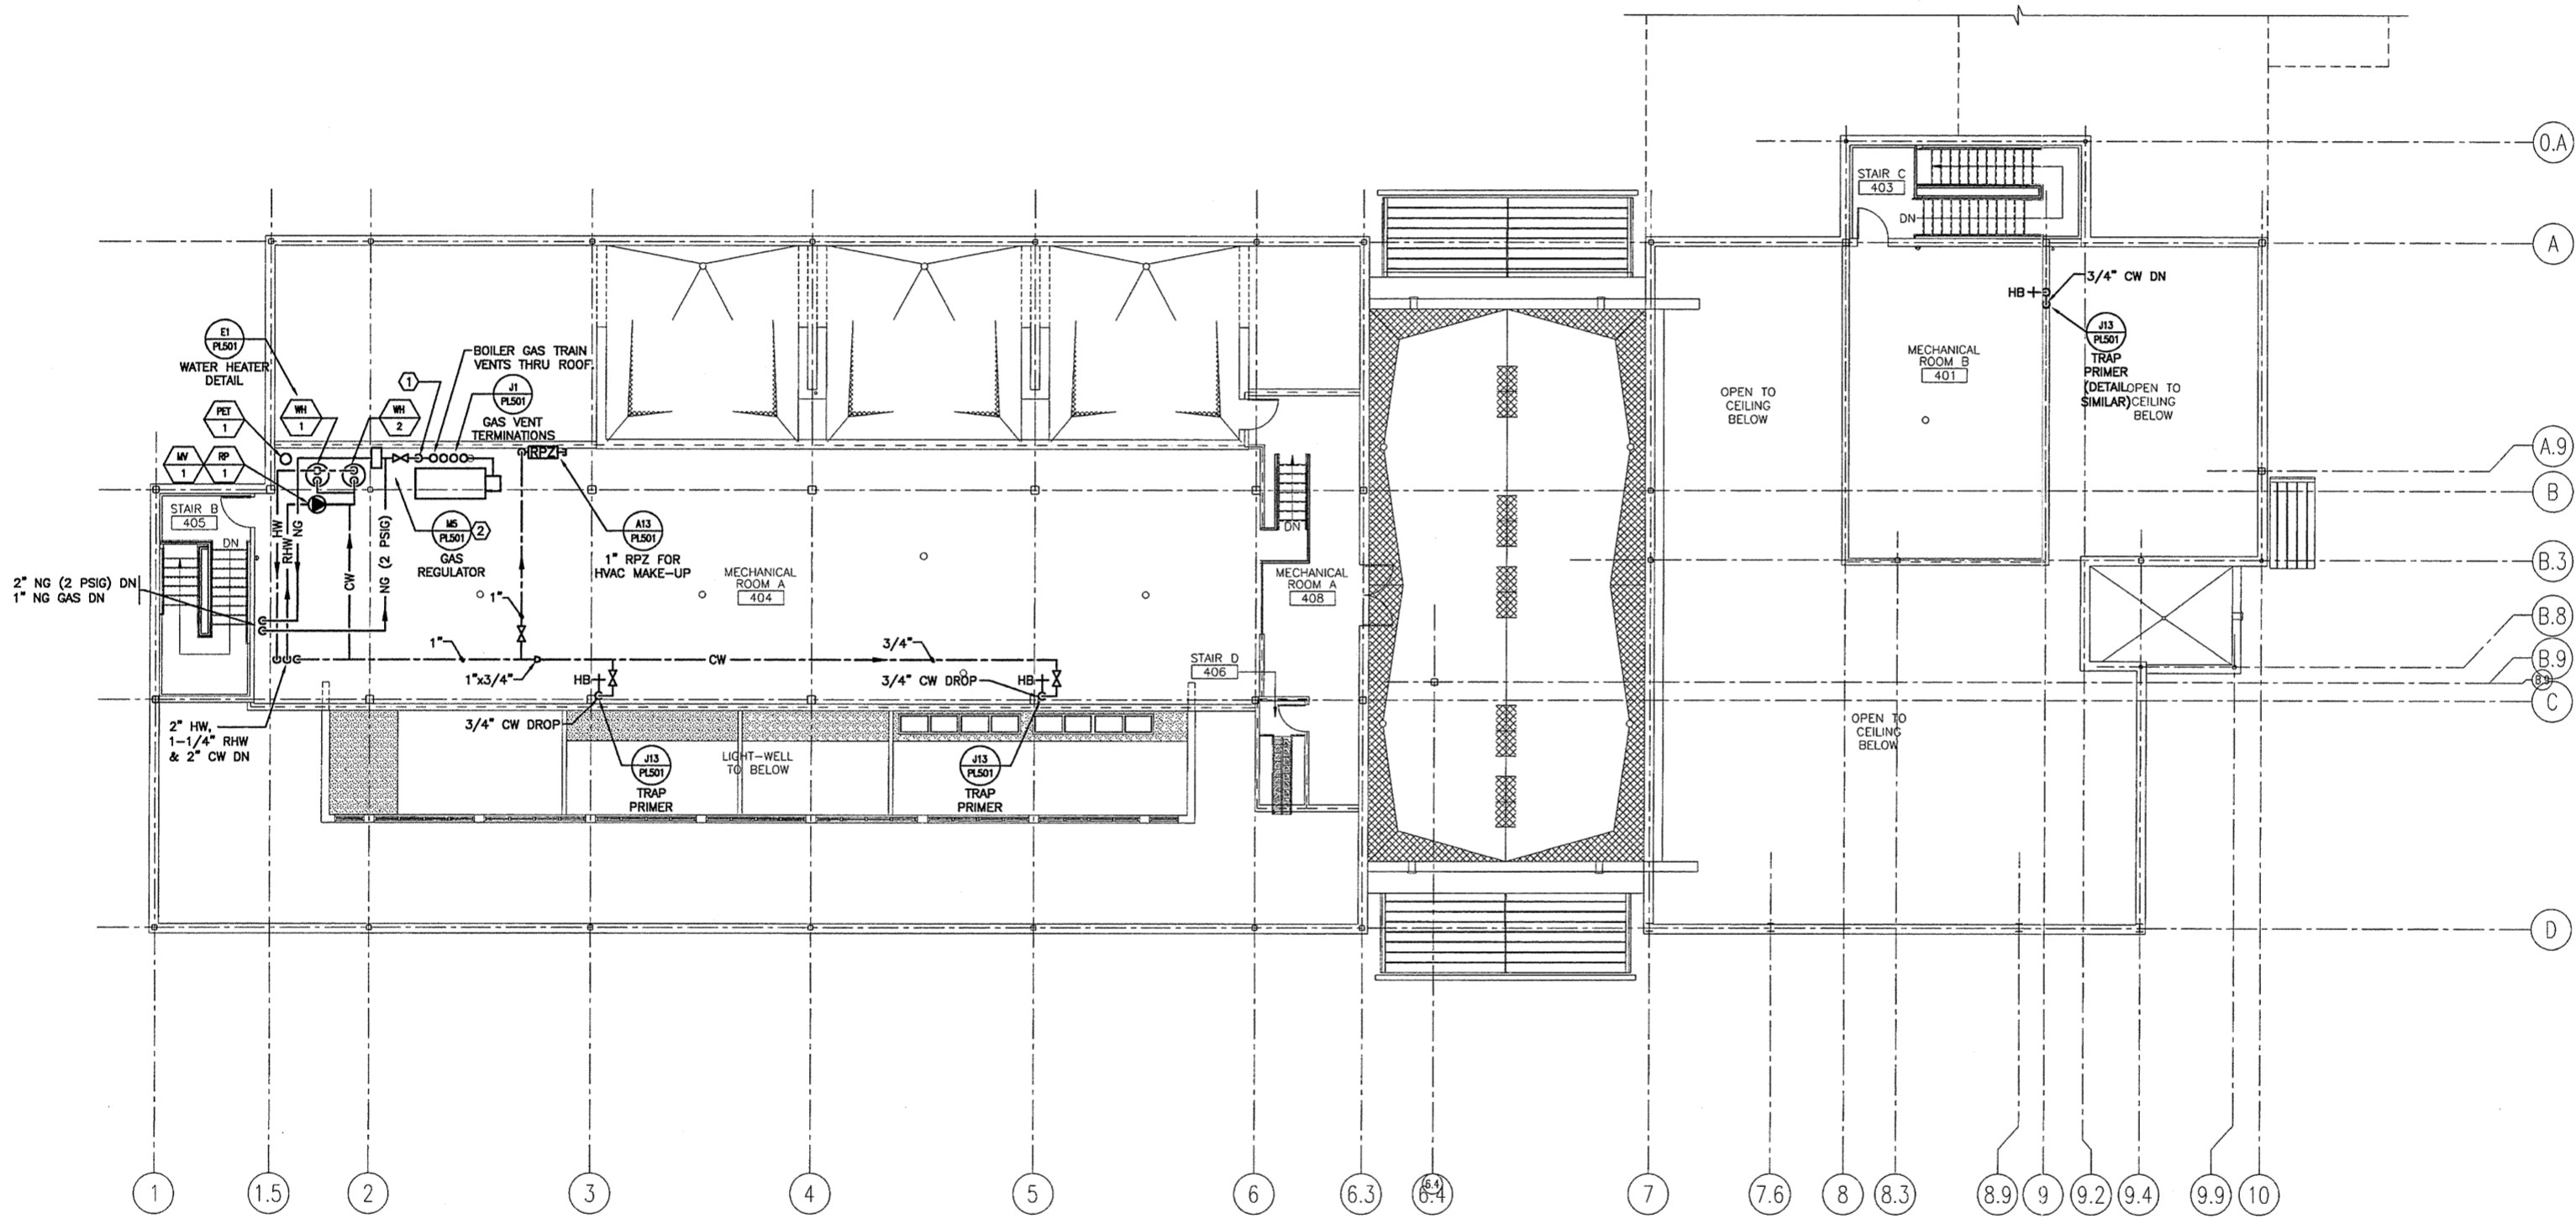

REV.	DESCRIPTION	DATE
0	ISSUED FOR CONSTRUCTION	10-23-03

**ISSUED FOR CONSTRUCTION**  
**10-23-03**

PROJECT NORTH

ARCHITECTURE ENGINEERING PLANNING

**SMRT**  
 144 Fore Street/P.O. Box 618  
 Portland, Maine 04104  
 Tel. (207) 772-3846  
 Fax. (207) 772-1070

**THE GULF OF MAINE RESEARCH INSTITUTE**  
 PORTLAND, MAINE

**MEZZANINE SUPPLY PIPING PLAN**

SHEET TITLE:	1/8" = 1'-0"	DATE:	10-23-03
PROJECT MANAGER:	DRL	GRAPHIC SCALE:	0' 1"
JOB CAP/DRAWN:	SDL/BGG		
A/E OF RECORD:	DBR	SHEET No.	PL108
SMRT CAD FILE:	PL108-03034		
PROJECT No.	03034		

**A1 FLOOR PLAN**  
 1/8" = 1'-0"