


- NOTE:**
1. FOR ALL SEAWATER PIPING AND DRAINS USE 45° LATERALS, 90° TEES ARE NOT ALLOWED UNLESS SPECIFIED ON THE DRAWINGS.
 2. USE LONG SWEEP ELBOWS ONLY.
 3. CONTRACTOR TO AVOID OTHER UTILITIES ABOVE DROP CEILING WHEN INSTALLING PIPE ABOVE DROP CEILING.
 4. ALL DRAIN PIPE SHALL BE SLOPED 1/4" PER FOOT.
 5. SEE SHEET SW108 FOR DETAILS

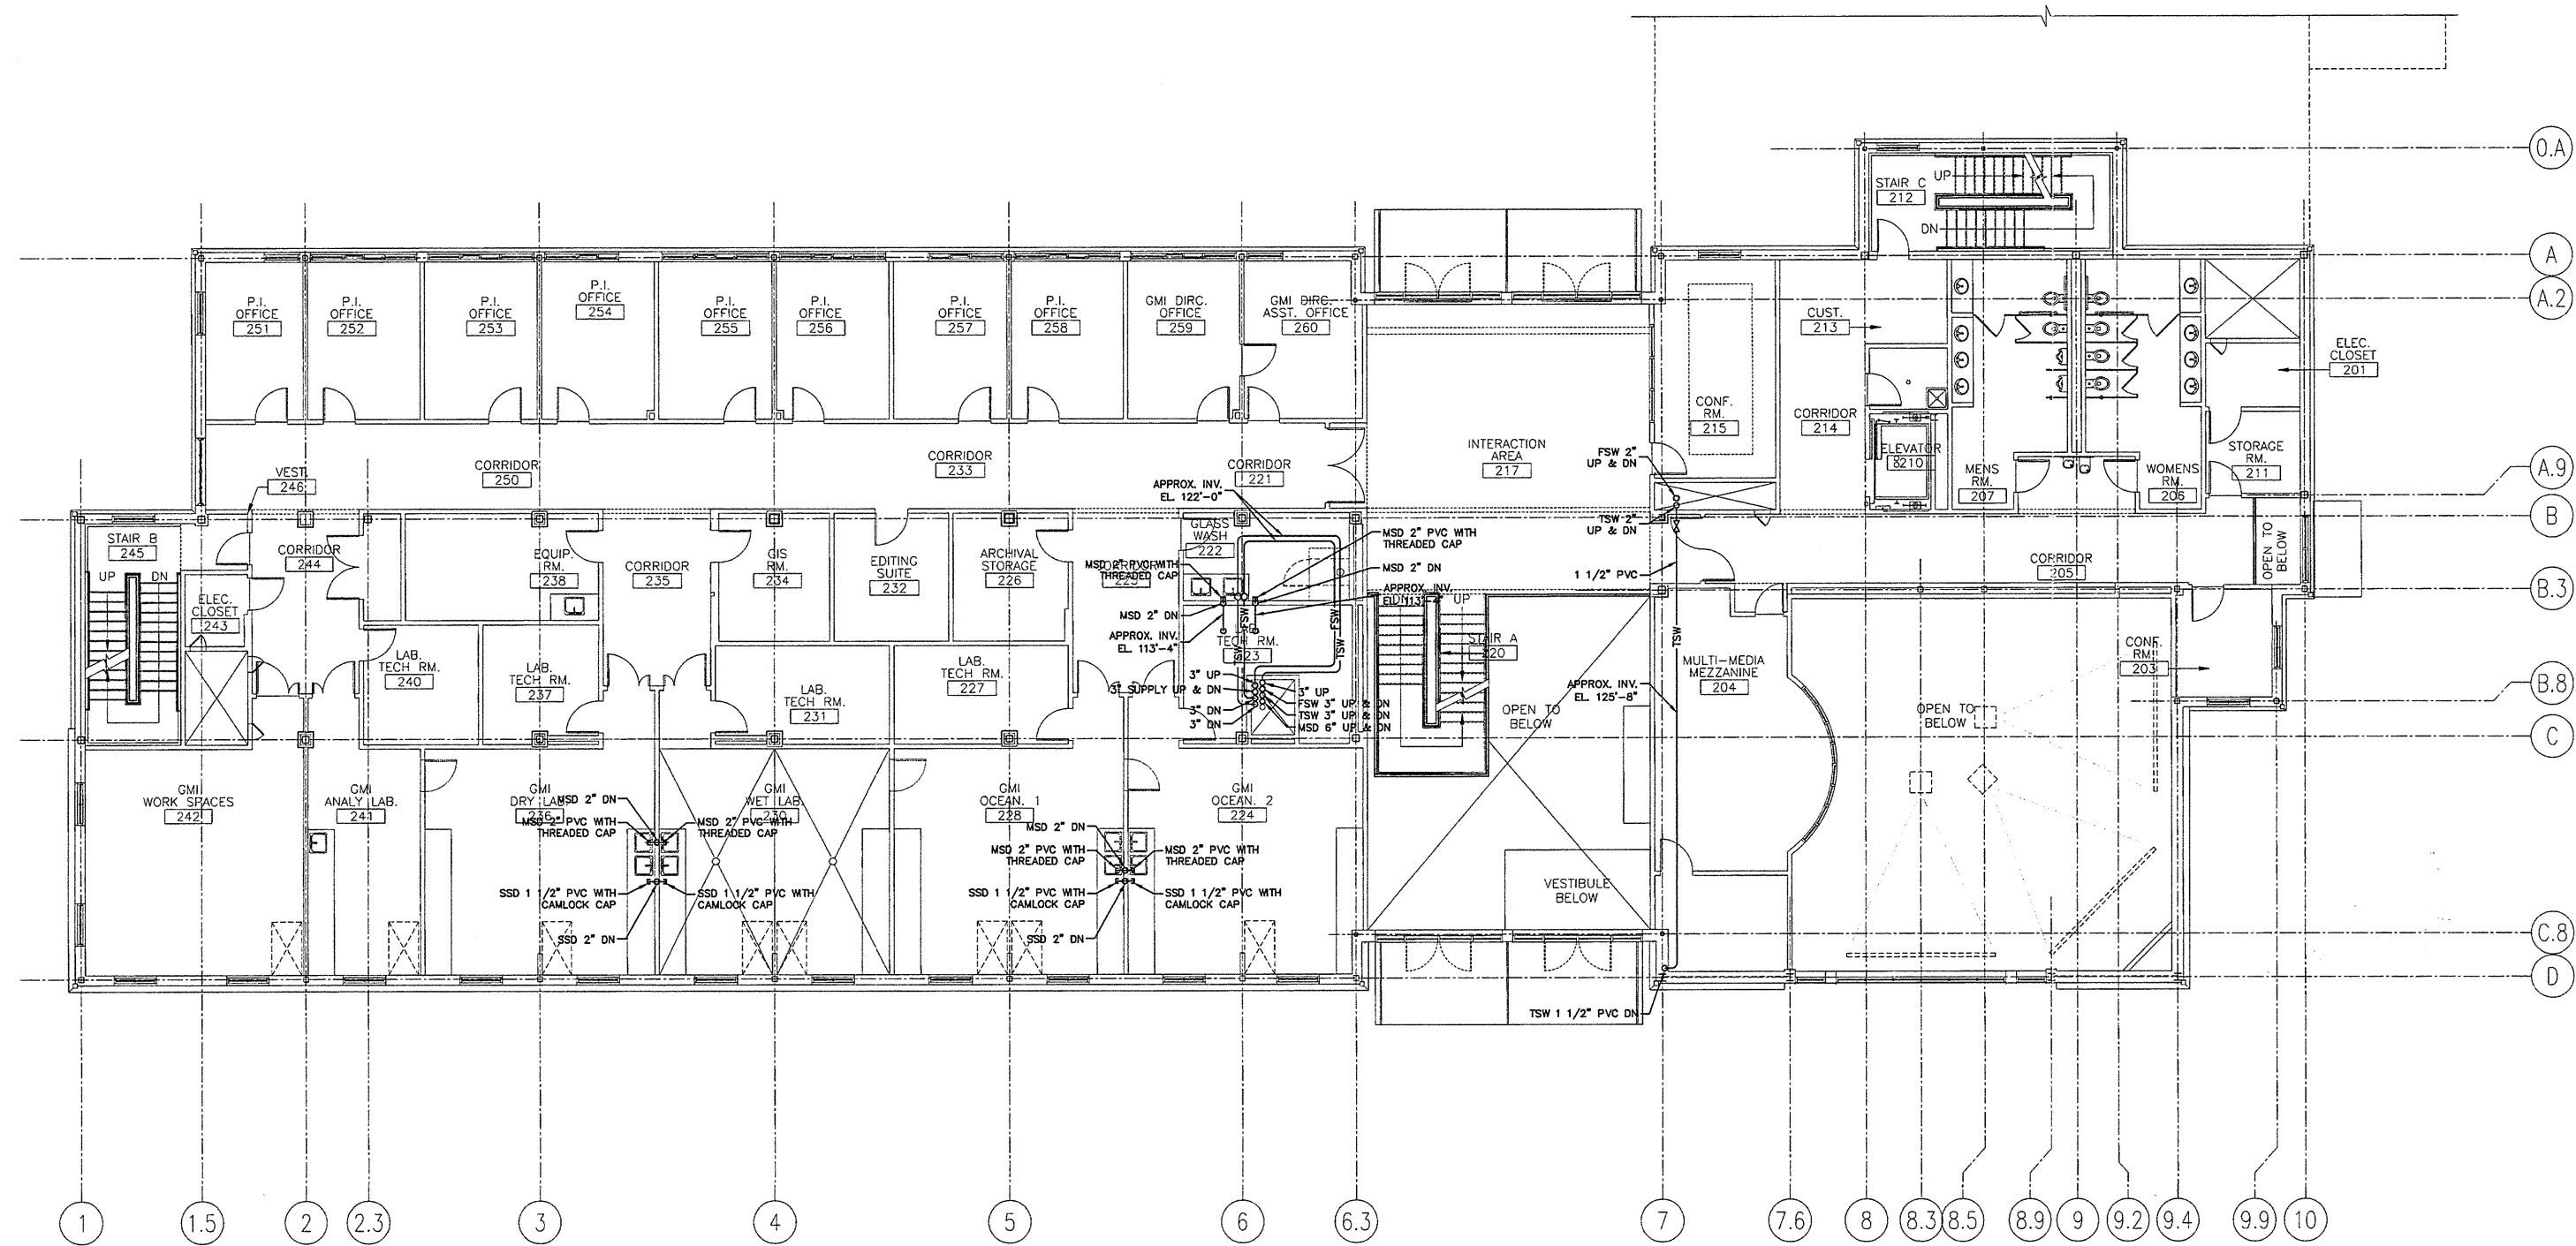

LEGEND

MAIN SEAWATER DRAIN	MSD
STERILIZED SEAWATER DRAIN	SSD
FILTERED SEAWATER	FSW
TEMPERED SEAWATER	TSW
FLOOR SINK	FS
FLOOR CLEANOUT	FCO
PIPE TAP	▽
SALT WATER SINK PIPE TAP	○

0	ISSUED FOR CONSTRUCTION	10/23/03
REV.	DESCRIPTION	DATE

ISSUED FOR CONSTRUCTION
 10/23/03

CURRENT ISSUE STATUS:

SM RT ARCHITECTURE ENGINEERING PLANNING
 144 Fore Street, P.O. Box 618
 Portland, Maine 04104
 tel. (207) 772-3846
 fax. (207) 772-1070

THE GULF OF MAINE RESEARCH INSTITUTE
 PORTLAND, MAINE

PROJECT: SECOND FLOOR SEAWATER SYSTEM PIPING PLAN

SHEET TITLE: SW105

SCALE: 1/8" = 1'-0" DATE: _____
 DESIGNED BY: JSC GRAPHIC SCALE: 0" 1"
 DRAWN BY: JBC/JSC
 CHECKED BY: MCJ SHEET No. _____
 FILE: PL111-03034
 PROJECT No. 03034

1/8" = 1'-0"