


- NOTE:**
1. FOR ALL SEAWATER PIPING AND DRAINS USE 45° LATERALS, 90° TEES ARE NOT ALLOWED UNLESS SPECIFIED ON THE DRAWINGS.
 2. USE LONG SWEEP ELBOWS ONLY.
 3. CONTRACTOR TO AVOID OTHER UTILITIES ABOVE DROP CEILING WHEN INSTALLING PIPE ABOVE DROP CEILING.
 4. ALL DRAIN PIPE SHALL BE SLOPED 1/4" PER FOOT.

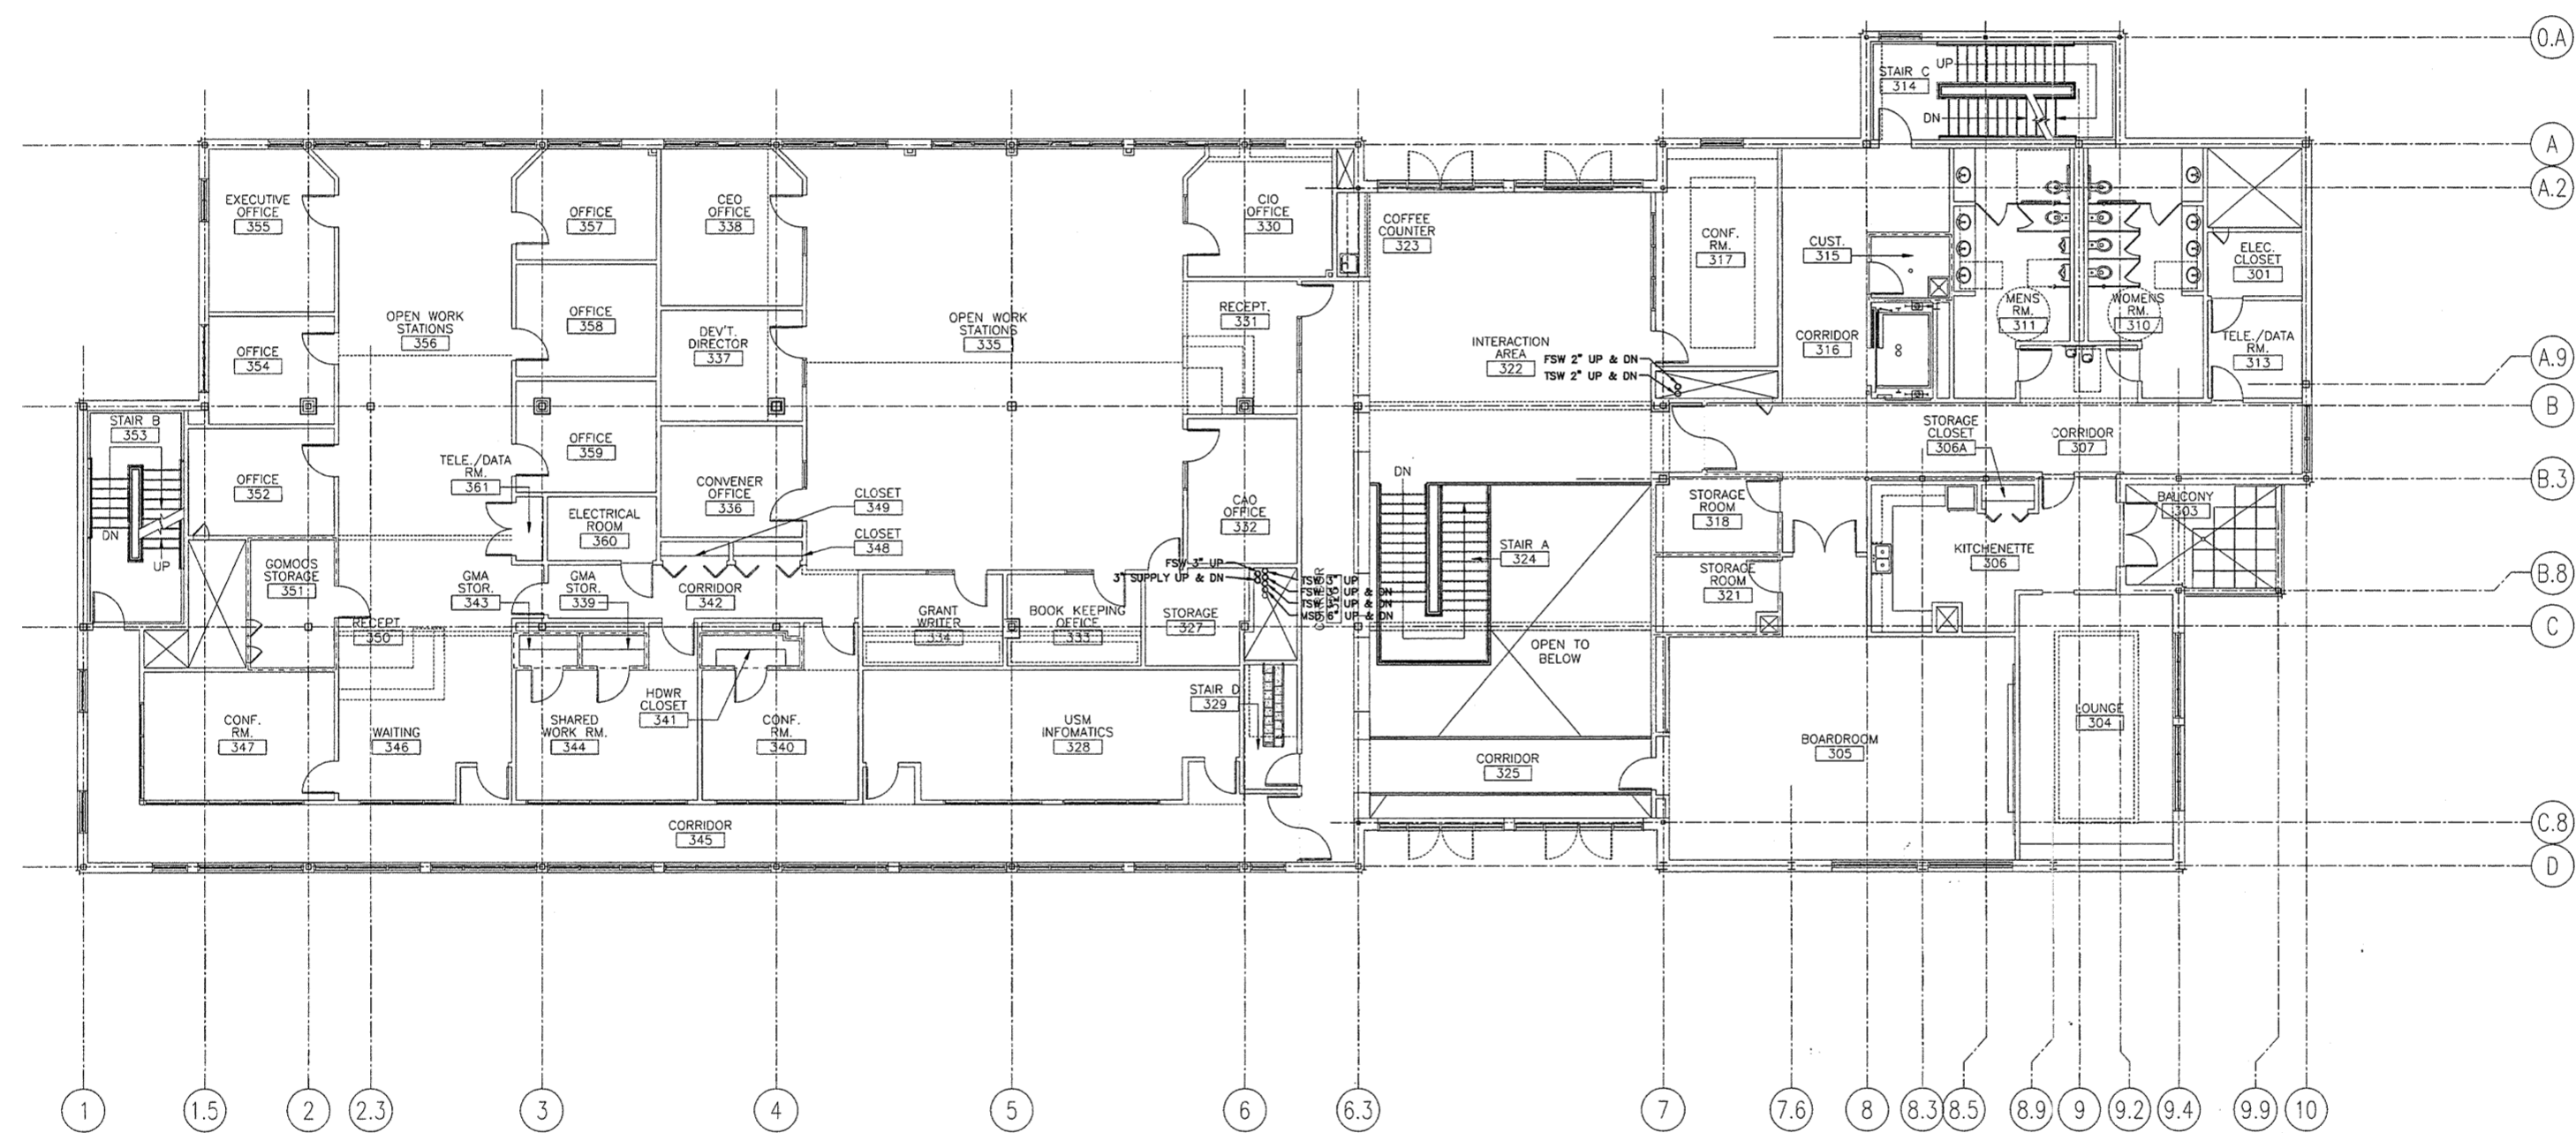

0	ISSUED FOR CONSTRUCTION	10/23/03
REV.	DESCRIPTION	DATE

ISSUED FOR CONSTRUCTION
 10/23/03

CURRENT ISSUE STATUS:

SM RT ARCHITECTURE ENGINEERING PLANNING
 144 Fore Street, P.O. Box 618
 Portland, Maine 04104
 tel. (207) 772-3846
 fax. (207) 772-1070

THE GULF OF MAINE RESEARCH INSTITUTE
 PORTLAND, MAINE

PROJECT: **THIRD FLOOR SEAWATER SYSTEM PIPING PLAN**

SHEET TITLE:	1/8" = 1'-0"	DATE:
DESIGNED BY:	JSC	GRAPHIC SCALE:
DRAWN BY:	JBC/JSC	
CHECKED BY:	MCJ	SHEET No.
FILE:	PL112-03034	SW106
PROJECT No.	03034	

1/8" = 1'-0"